


IRRIGATION NOTES:

1. EQUIPMENT DRAWN WITHIN FLOOR PLAN FOR GRAPHICAL PURPOSES.
2. IRRIGATION DESIGN IS BASED ON A MAXIMUM DEMAND OF GPM WITH A MINIMUM OPERATING PRESSURE OF PSI. LANDSCAPE CONTRACTOR SHALL TEST AND VERIFY PRESSURE AND FLOW PRIOR TO STARTING JOB AND NOTIFY LANDSCAPE ARCHITECT IMMEDIATELY IF WATER AND PRESSURE FLOWS DO NOT MEET THESE MINIMUM REQUIREMENTS.
3. IRRIGATION SYSTEM TO PROVIDE 100% COVERAGE TO OUR PLANTING AREAS
4. IRRIGATION PLAN IS DIAGRAMMATIC, INSTALL VALVES AND IRRIGATION LINES IN PLANTERS WHENEVER POSSIBLE

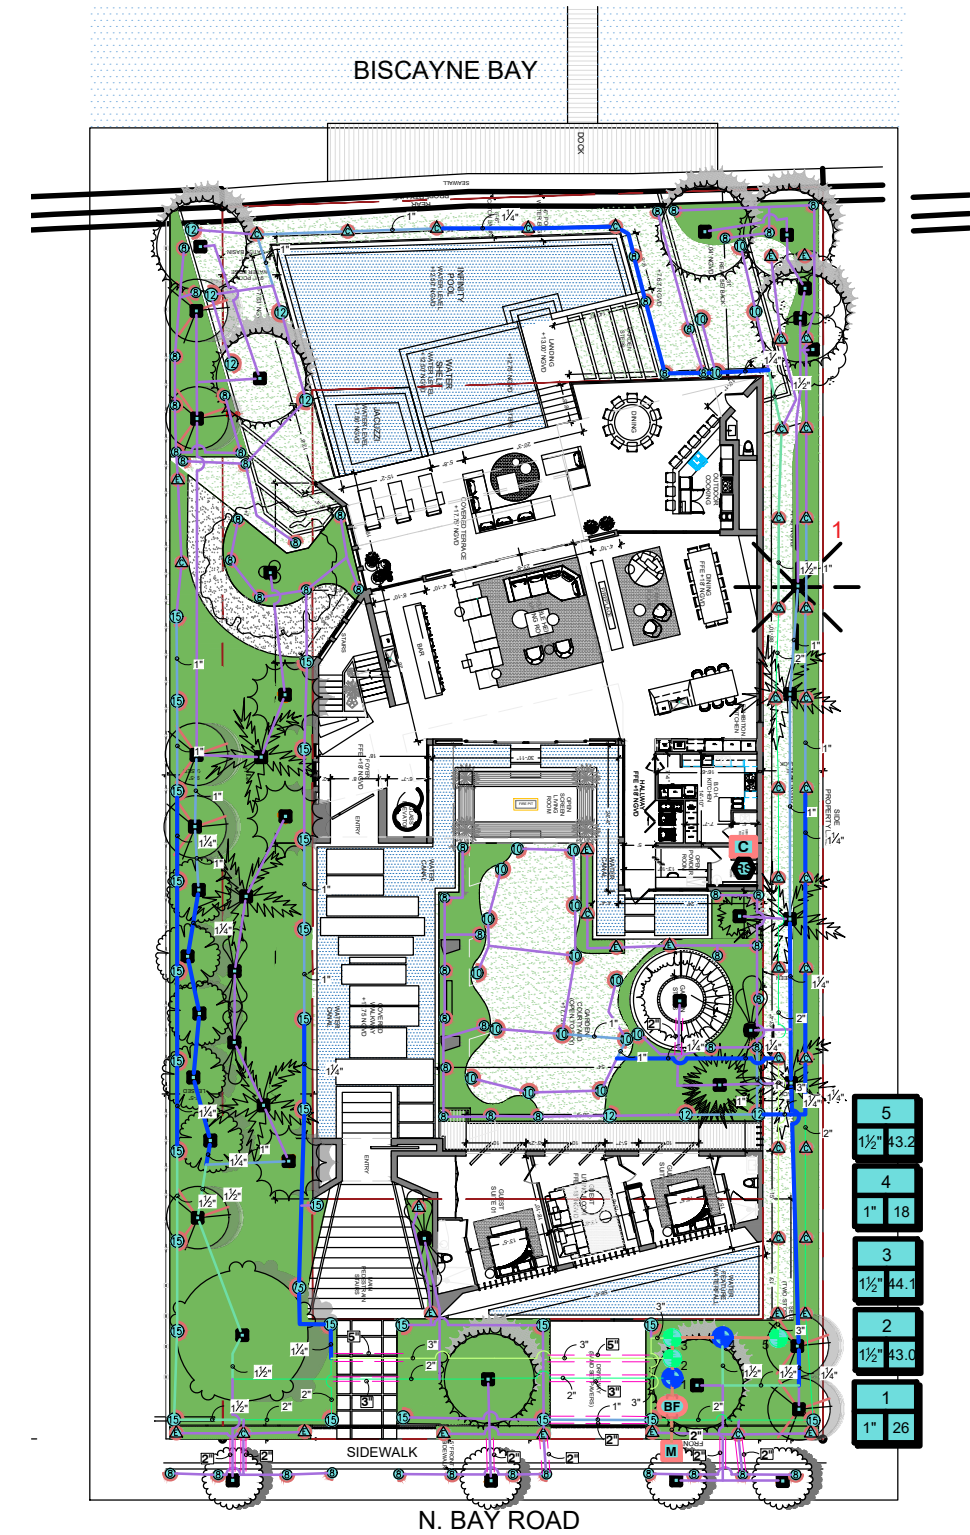

OVERALL IRRIGATION PLAN
Scale: 1/32"=1'-0"