
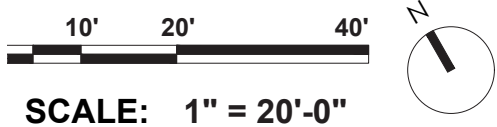


TREE MITIGATION PLAN

Legend

TREE TO REMAIN

TREE TO REMOVE

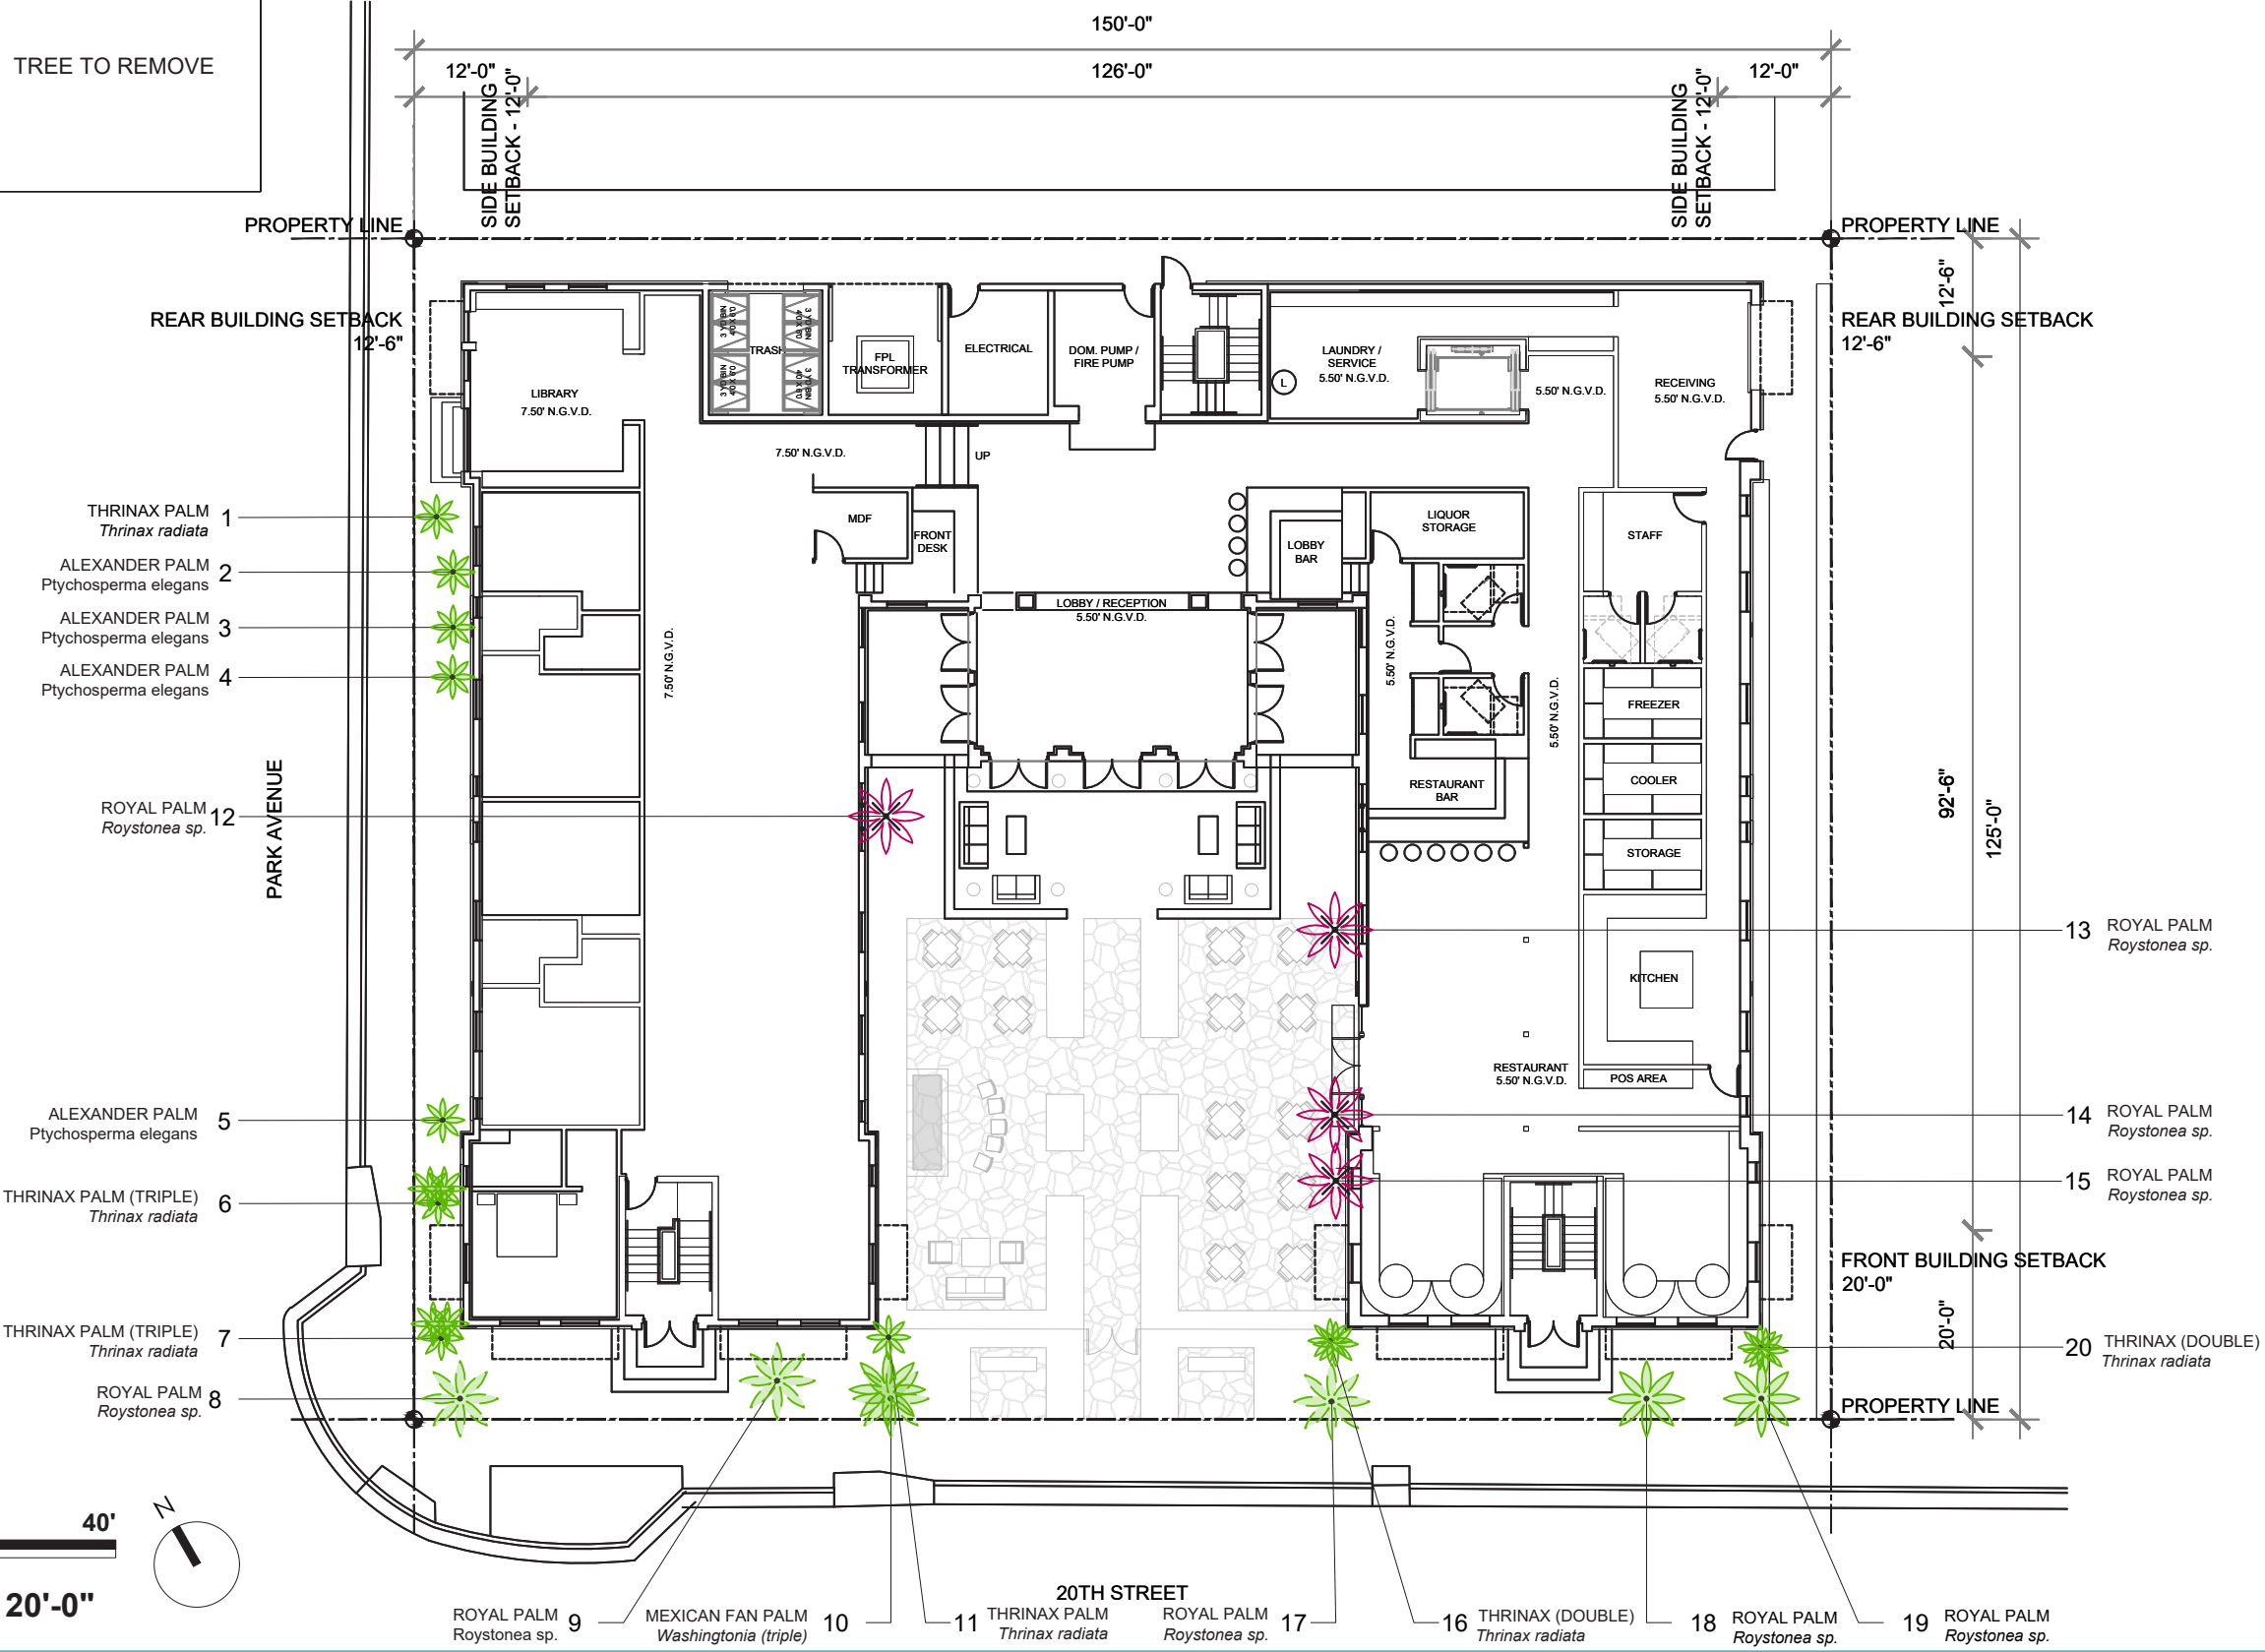

TREE REMOVALS



TREE PRESERVATIONS



Four (4) Palms to be removed.
Trees numbered 12, 13, 14, 15



PLANTING PLAN

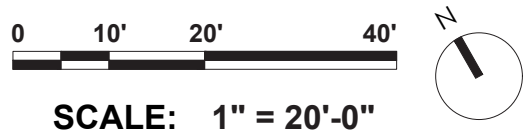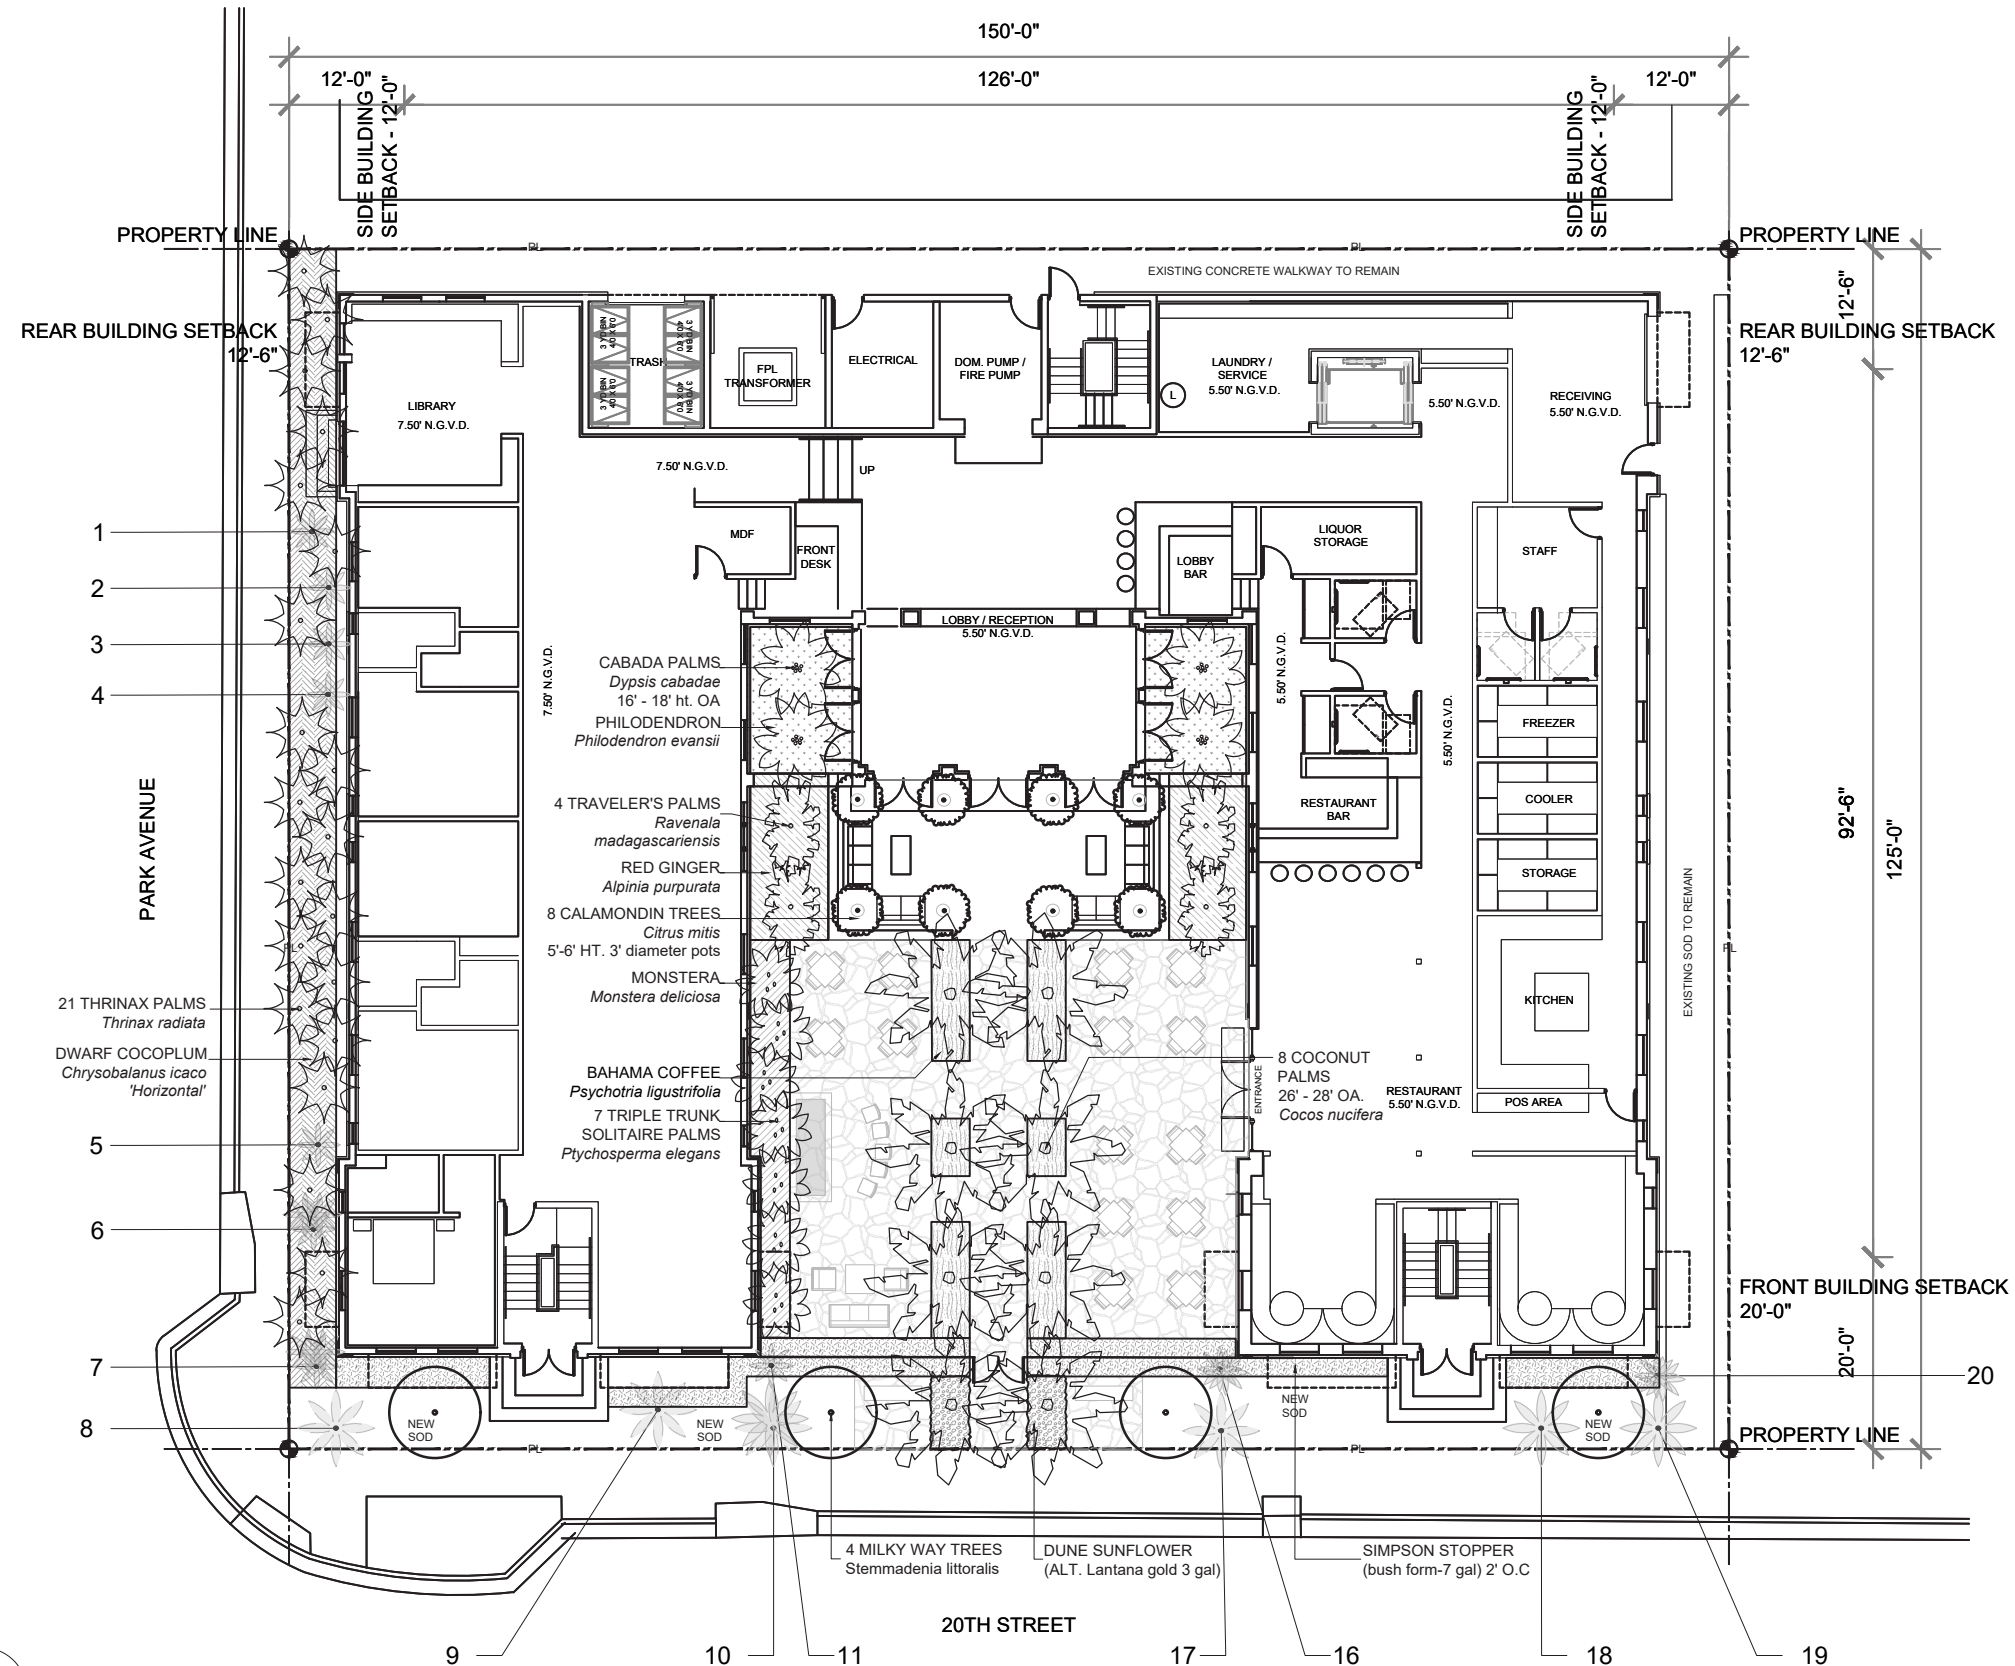

Palms



Dypsis cabadae
Cabada Palm



Cocos nucifera
Coconut palm



Ptychosperma elegans
Solitaire Palm



Ravenala madagascariensis
Travelers Palm



Thatch Palm
Thrinax radiata



Milky Way Tree
Stemmadenia littoralis

Shrubs and Groundcovers



Simpson Stopper
Myrcianthes fragrans




Bahama Coffee
Psychotria ligustrifolia



Dune Sunflower
Helianthus debilis




Wild Sage
Lantana depressa var. depressa

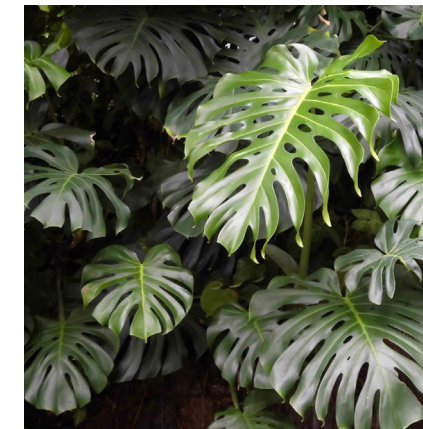

Swiss Cheese Monstera
Monstera deliciosa



HARDSCAPE PLAN

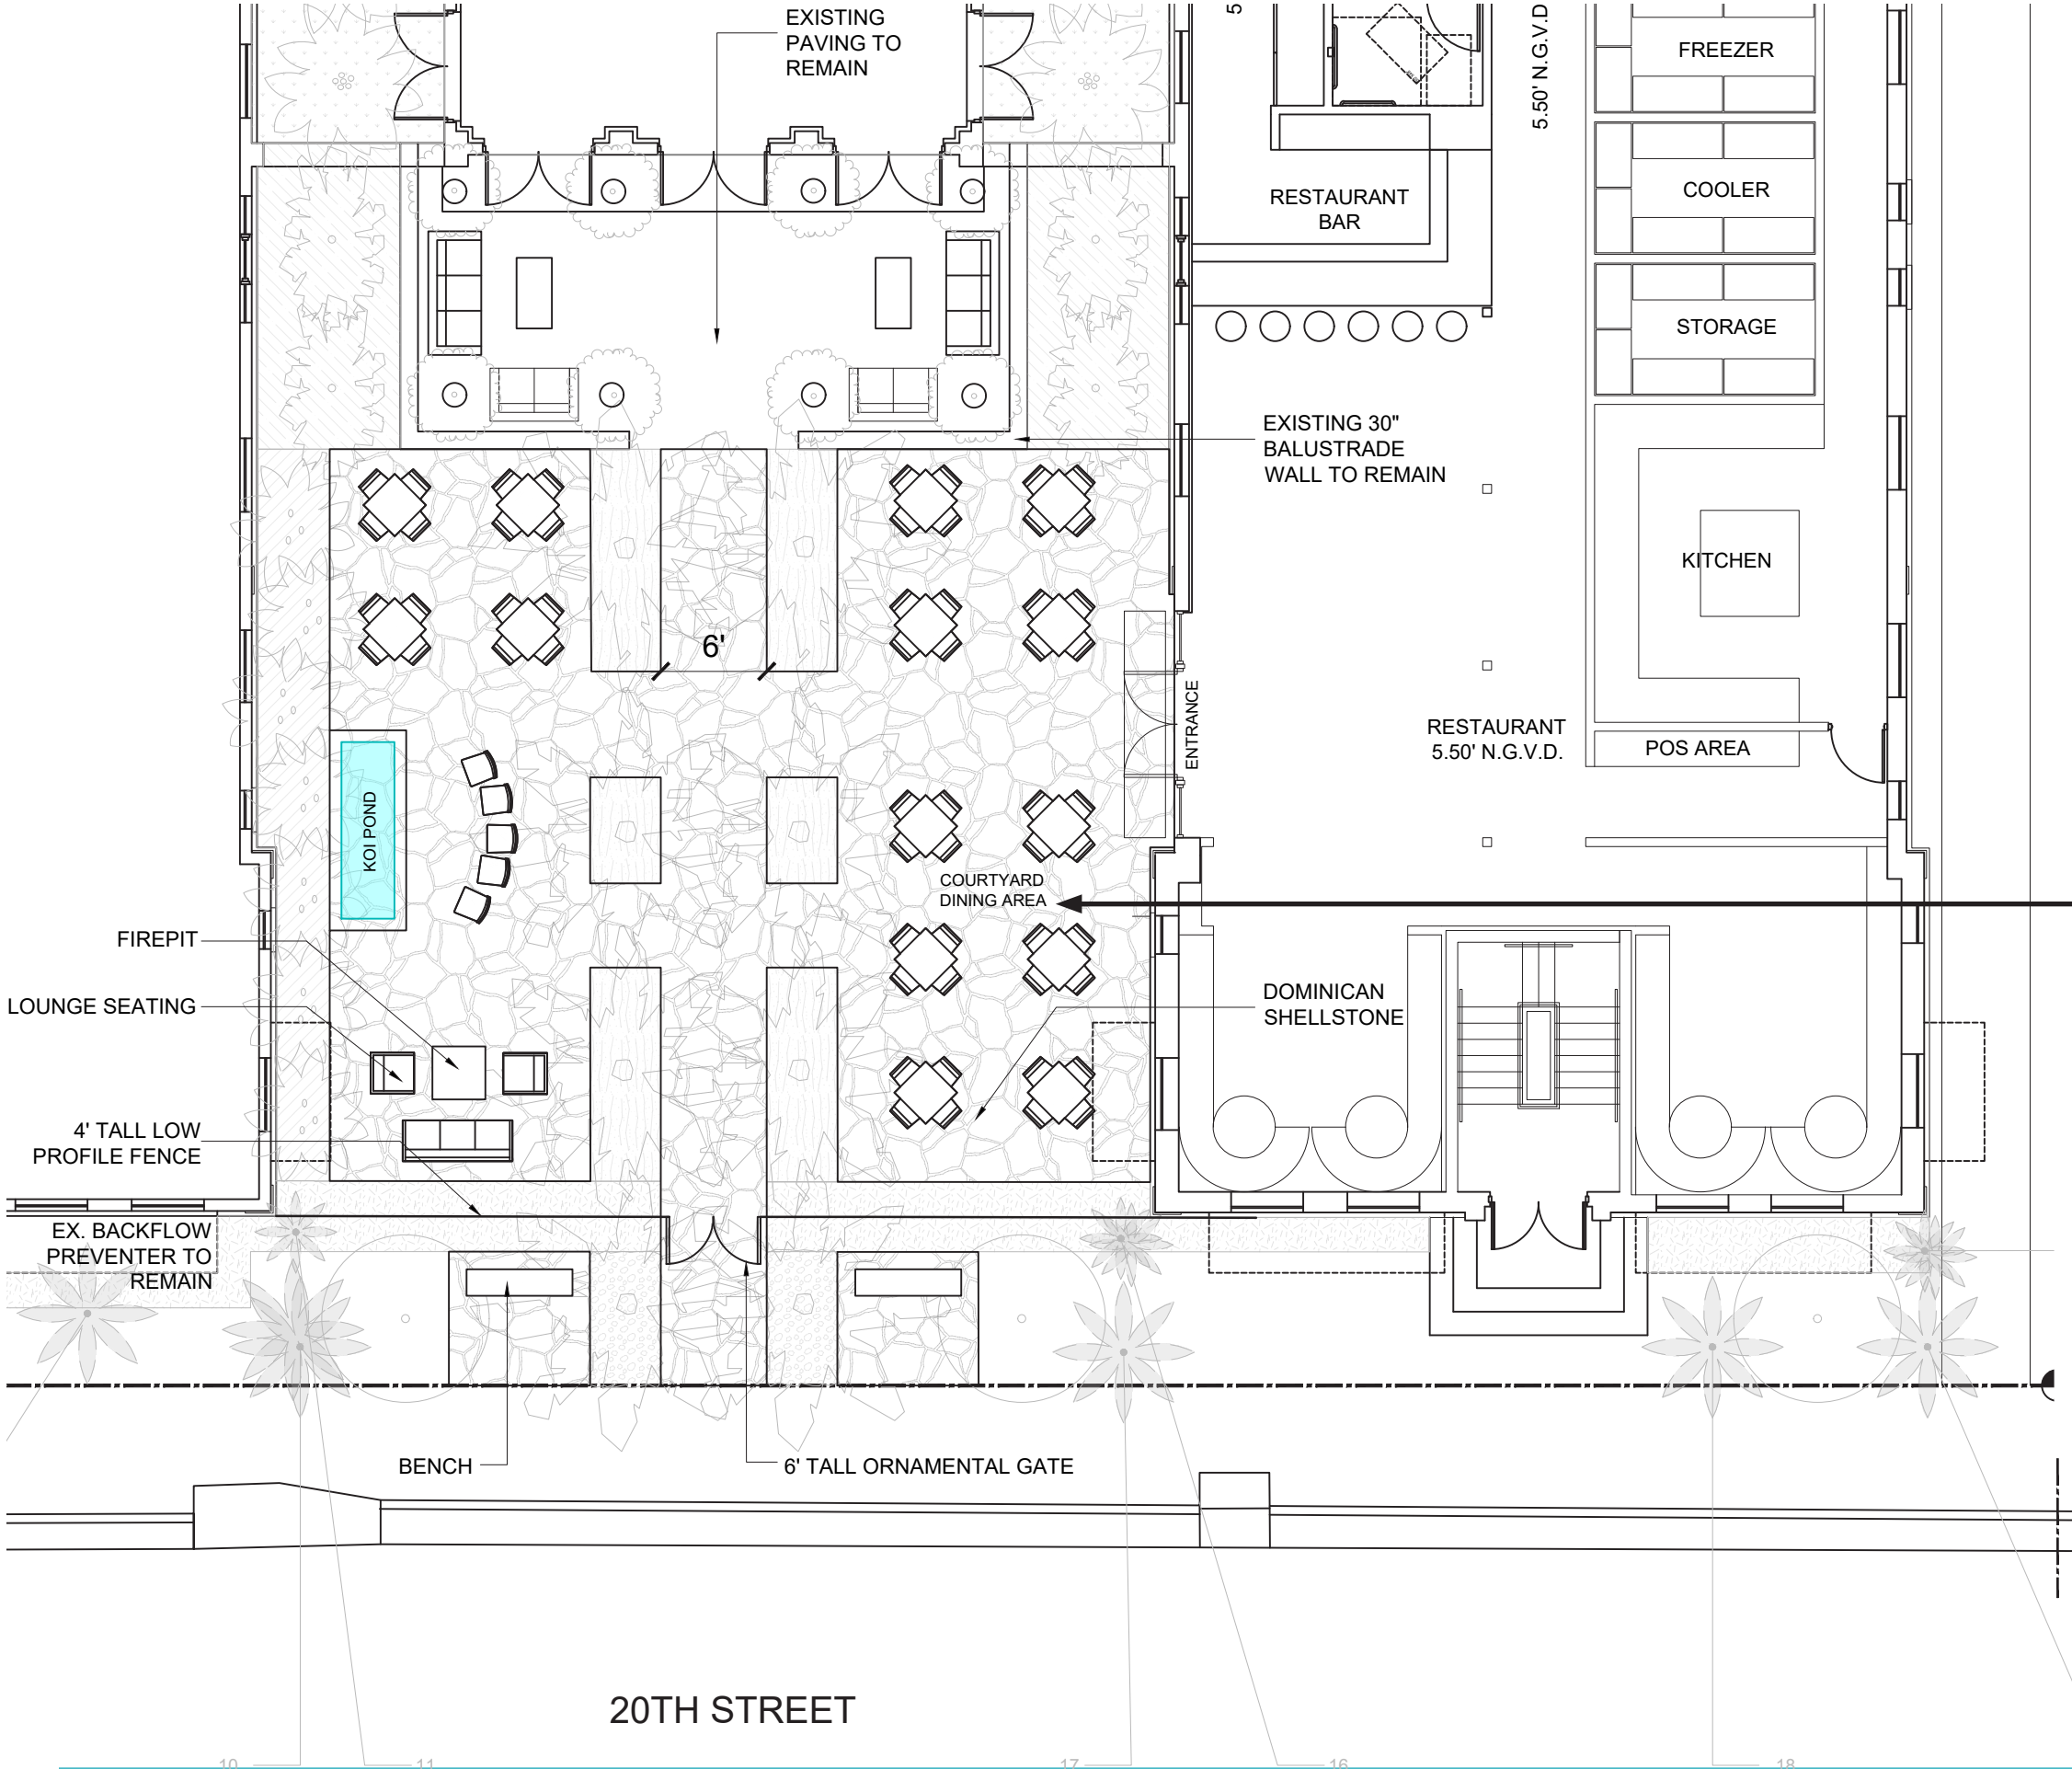

Dominican Shellstone Detail



Dominican Shellstone Flagstone



SCALE: 1" = 20'-0"




LIGHTING PLAN

LEGEND

- ▶ SMALL UPLIGHTS
- ▶ LARGE UPLIGHTS
- POND LIGHTS
- ▣ WALL WASHER LIGHTS
- PATH LIGHTS

- CABADA PALMS
Dyopsis cabadae
16' - 18' ht. OA
- PHILODENDRON
Philodendron evansii
- TRAVELER'S PALMS
Ravenala madagascariensis
- RED GINGER
Alpinia purpurata
- 8 CALAMONDIN TREES
Citrus mitis
5'-6' HT. 3' diameter pots
- MONSTERA
Monstera deliciosa
- BAHAMA COFFEE
Psychotria ligustrifolia
- 7 TRIPLE TRUNK
SOLITAIRE PALMS
Ptychosperma elegans

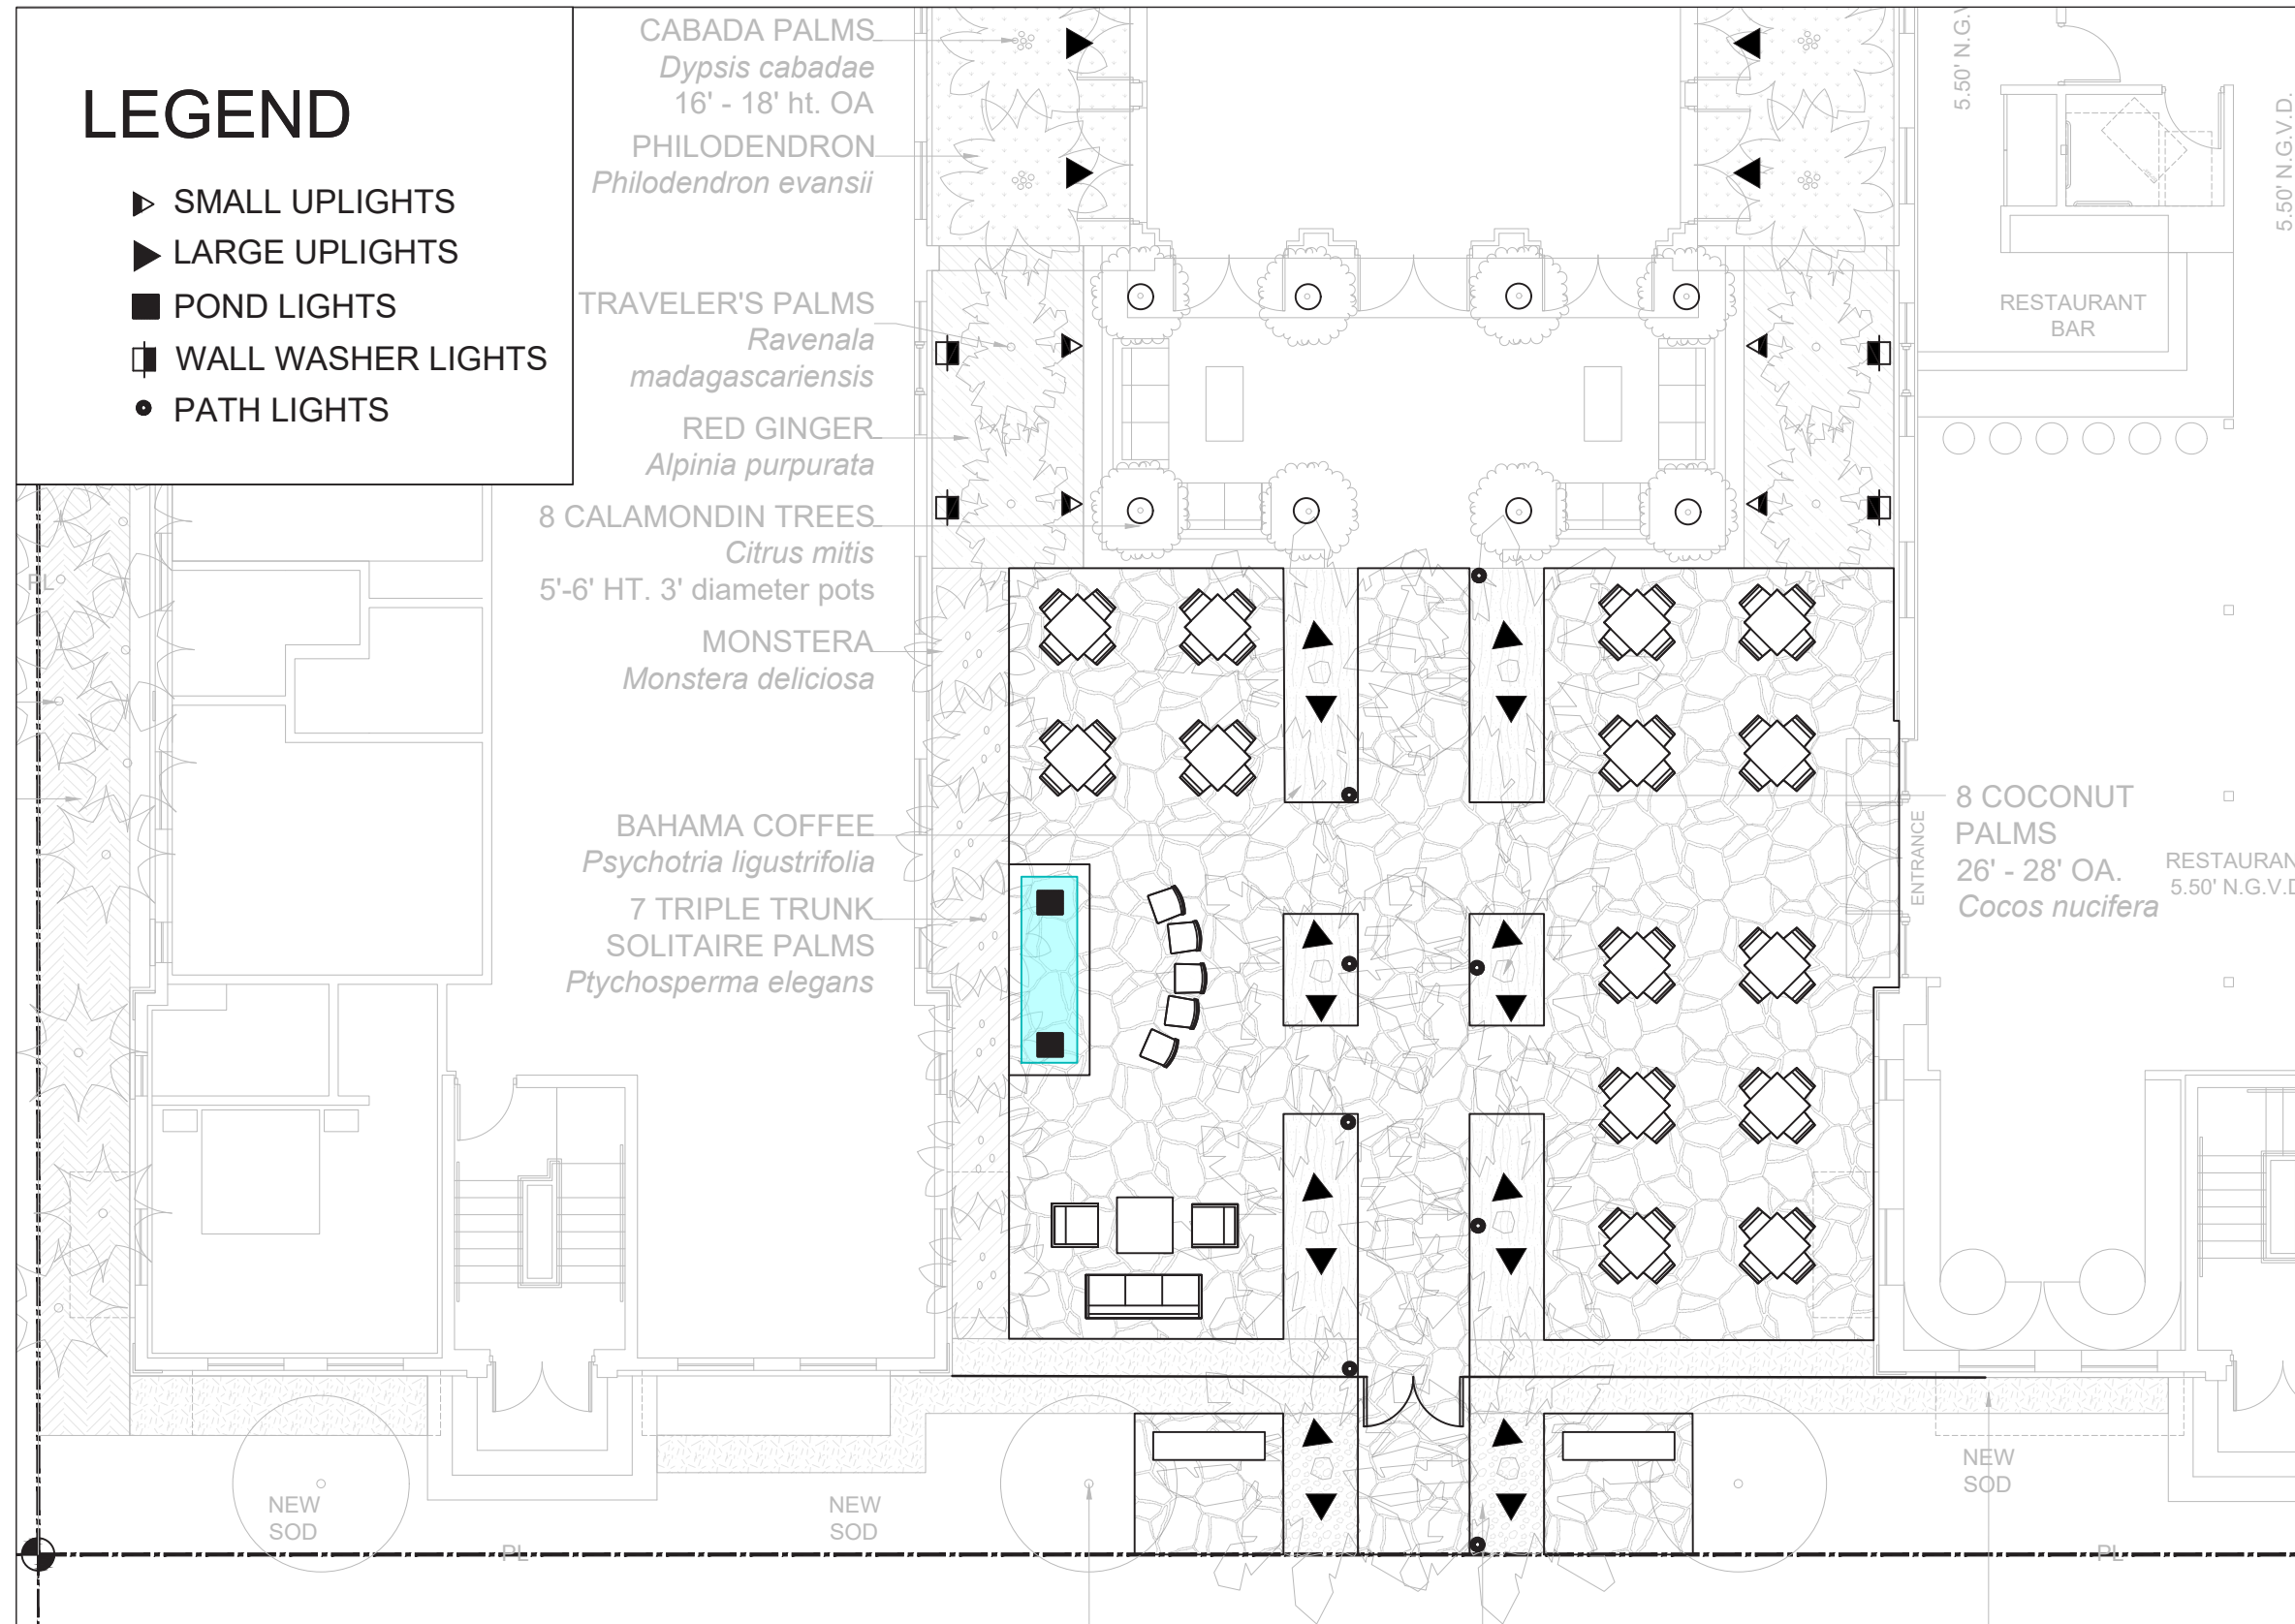

Palm Uplighting (large and small)
BK Lighting - Denali on Power Pipe
LED, 12-27 Watts - Tree Dependant



Flood light - Yosemite Integral
BK Lighting - Wall wash optic
LED, 23 or 34 Watts - modular design



Path and area - Square Litestick
BK Lighting - 3 Power Pipe options
LED, 3 Watts - modular design

