


NOT FOR CONSTRUCTION

These Design And Drawings Are The Copyrighted Property Of Revuelta Architecture International. P.A. and May Not Be Reproduced, Excerpted, or Transmitted in Any Form or by Any Means, Electronic or Mechanical, Without Prior Written Consent of the Architect. The Contractor Must Check And Verify All Dimensions Of The Job And Be Responsible For Same. Reporting Any Discrepancies To The Architects Before Commencing Work. Drawings Not To Be Scaled. The Blueprint Shall Be The Basis For Construction. No Part Of This Drawing Shall Be Used For Any Other Project Without The Written Consent Of The Architect. By Approval: Date: 3/26/21

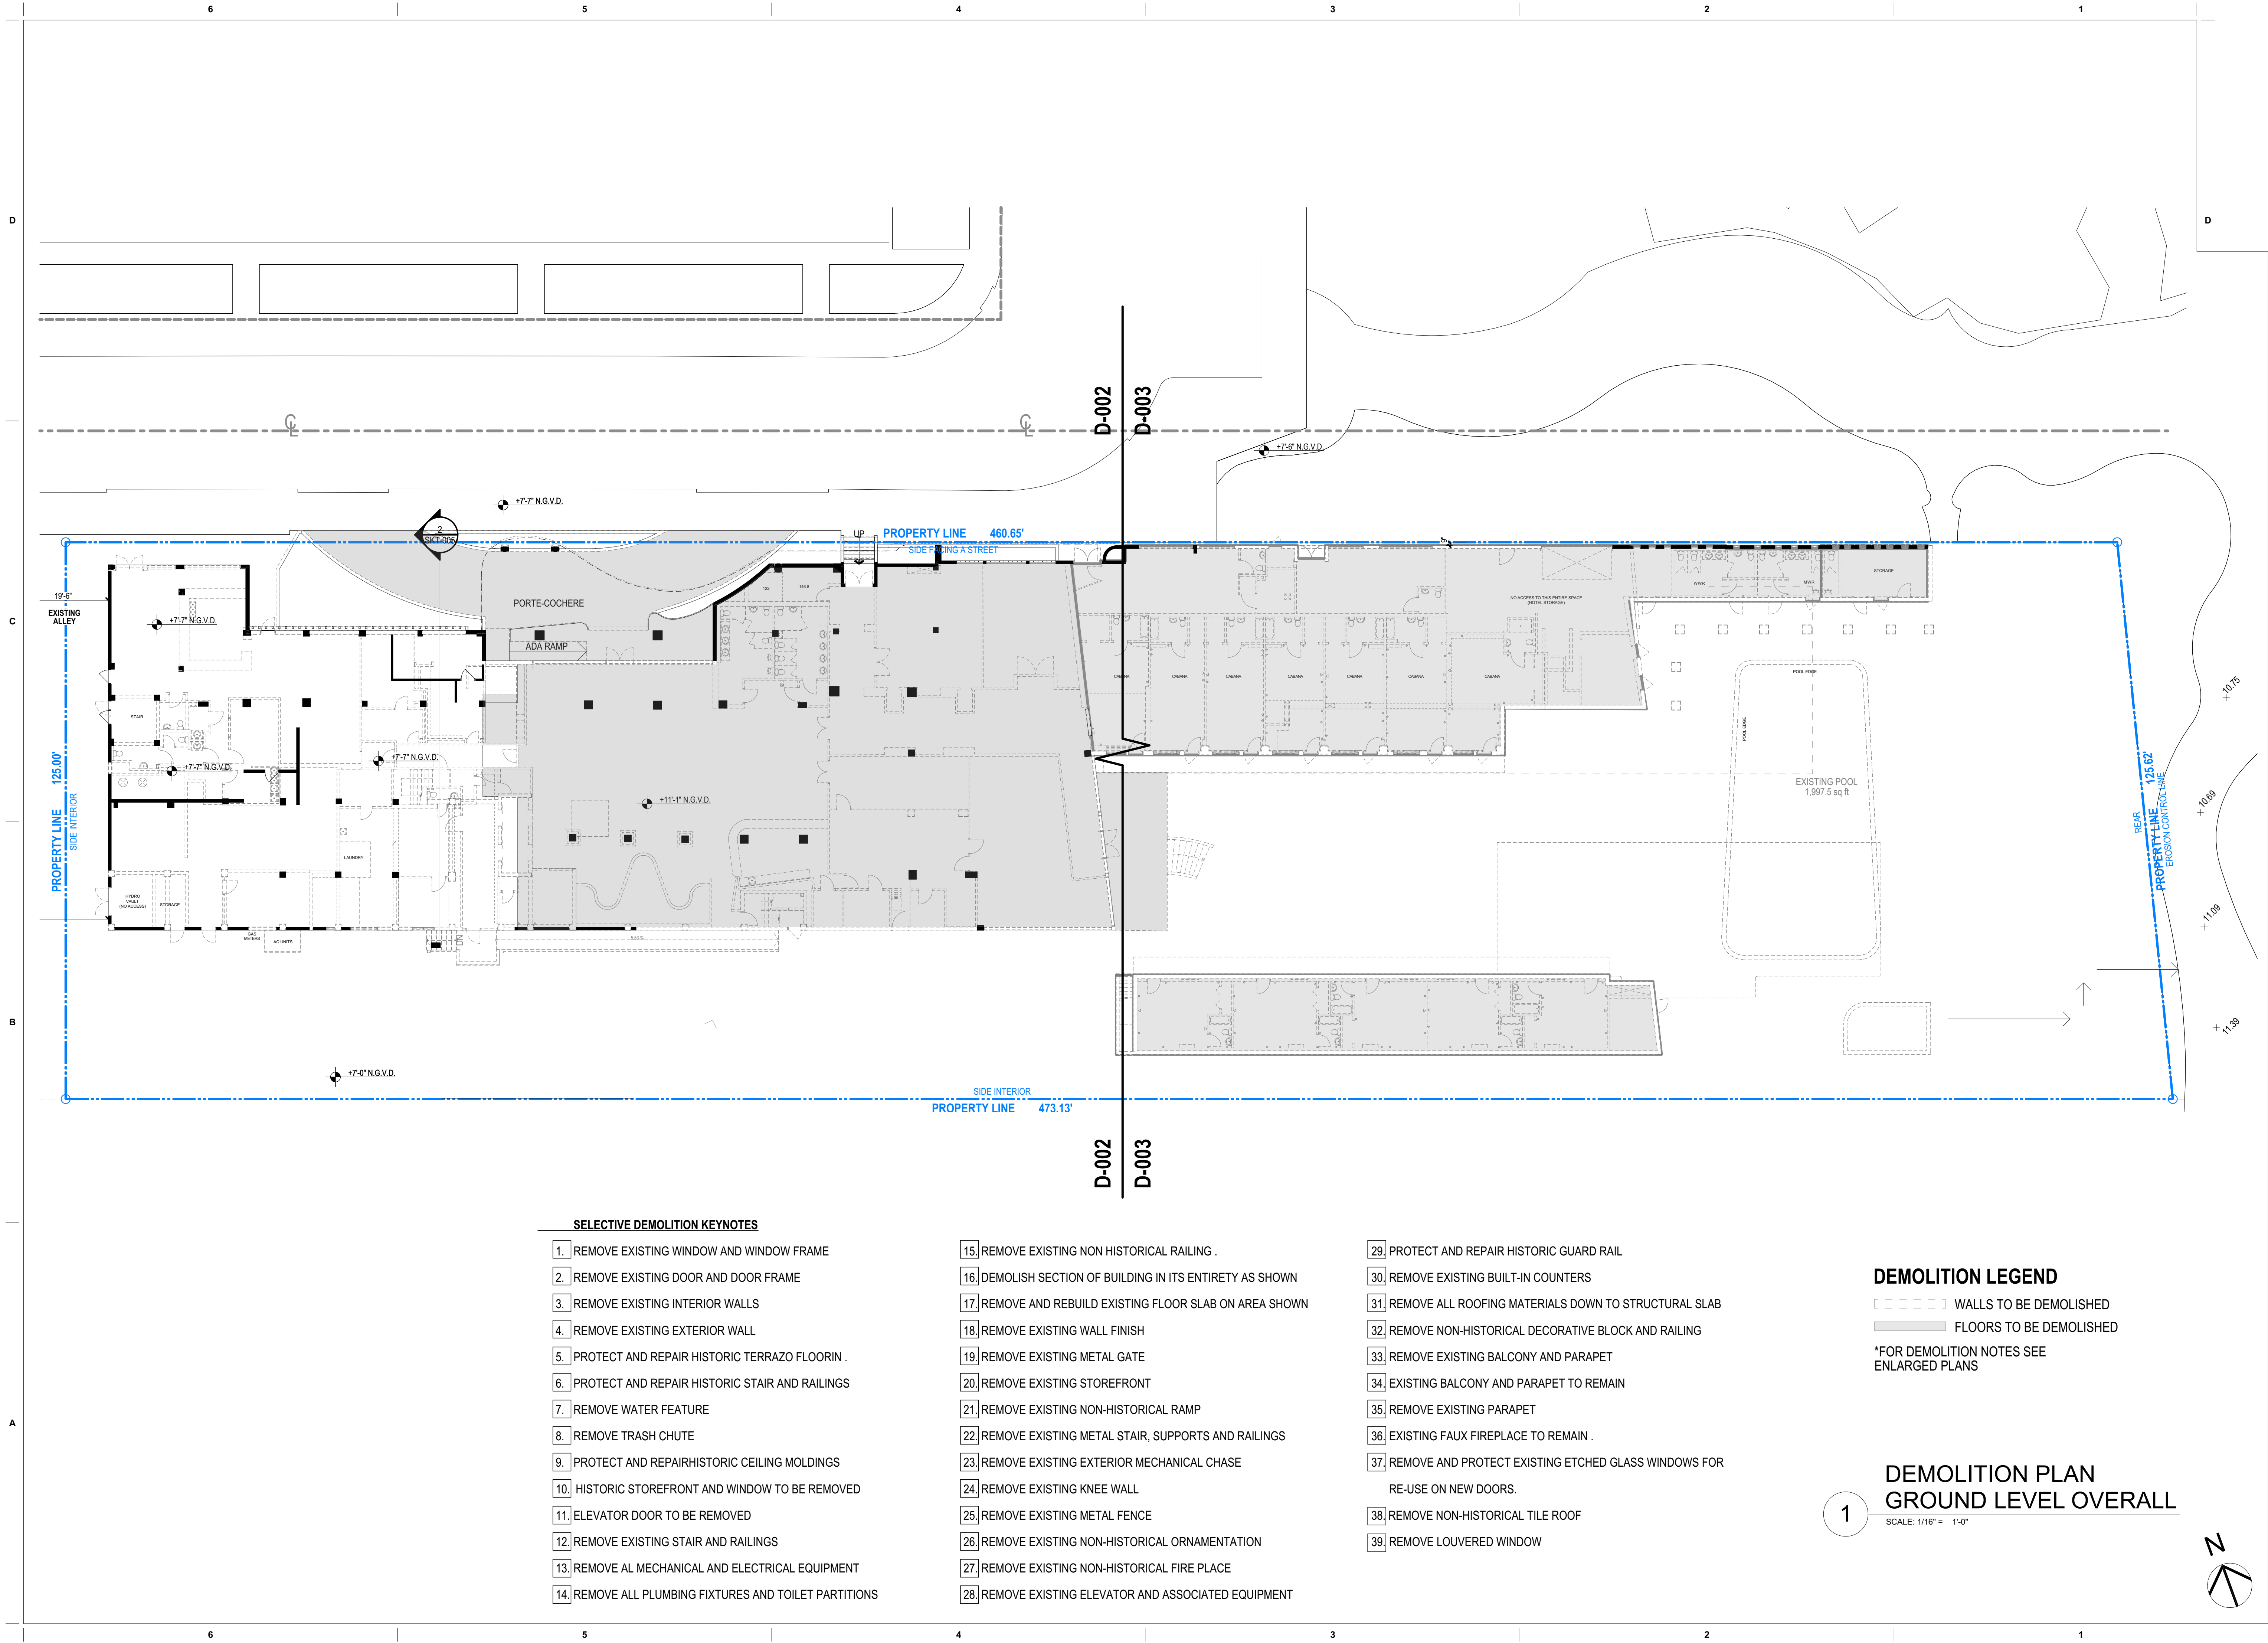

revuelta
architecture
international

Miami
Santiago, Chile

revuelta-architecture.com

2950 SW 27TH AVE
SUITE 110
MIAMI, FL 33135
T: 305.590.5000
F: 305.590.5040

DESIGN ARCHITECT

CITTERIO-VIEL
& PARTNERS

Project

**BVLGARI HOTEL
MIAMI BEACH**
100 21st STREET
MIAMI BEACH, FL 33139

Revisions

Owner Information

BHI Miami Limited Corp.
1521 Alton Rd.
Suite 403
Miami Beach, FL 33139
(786) 785-6504

Consultant

Luis O. Revuelta

AR-007972

HPB SET

Date

03/05/2021

Scale

AS SHOWN


Project No.

2005

Sheet Name
DEMOLITION PLAN - GROUND LEVEL
OVERALL

Sheet No.

D-001

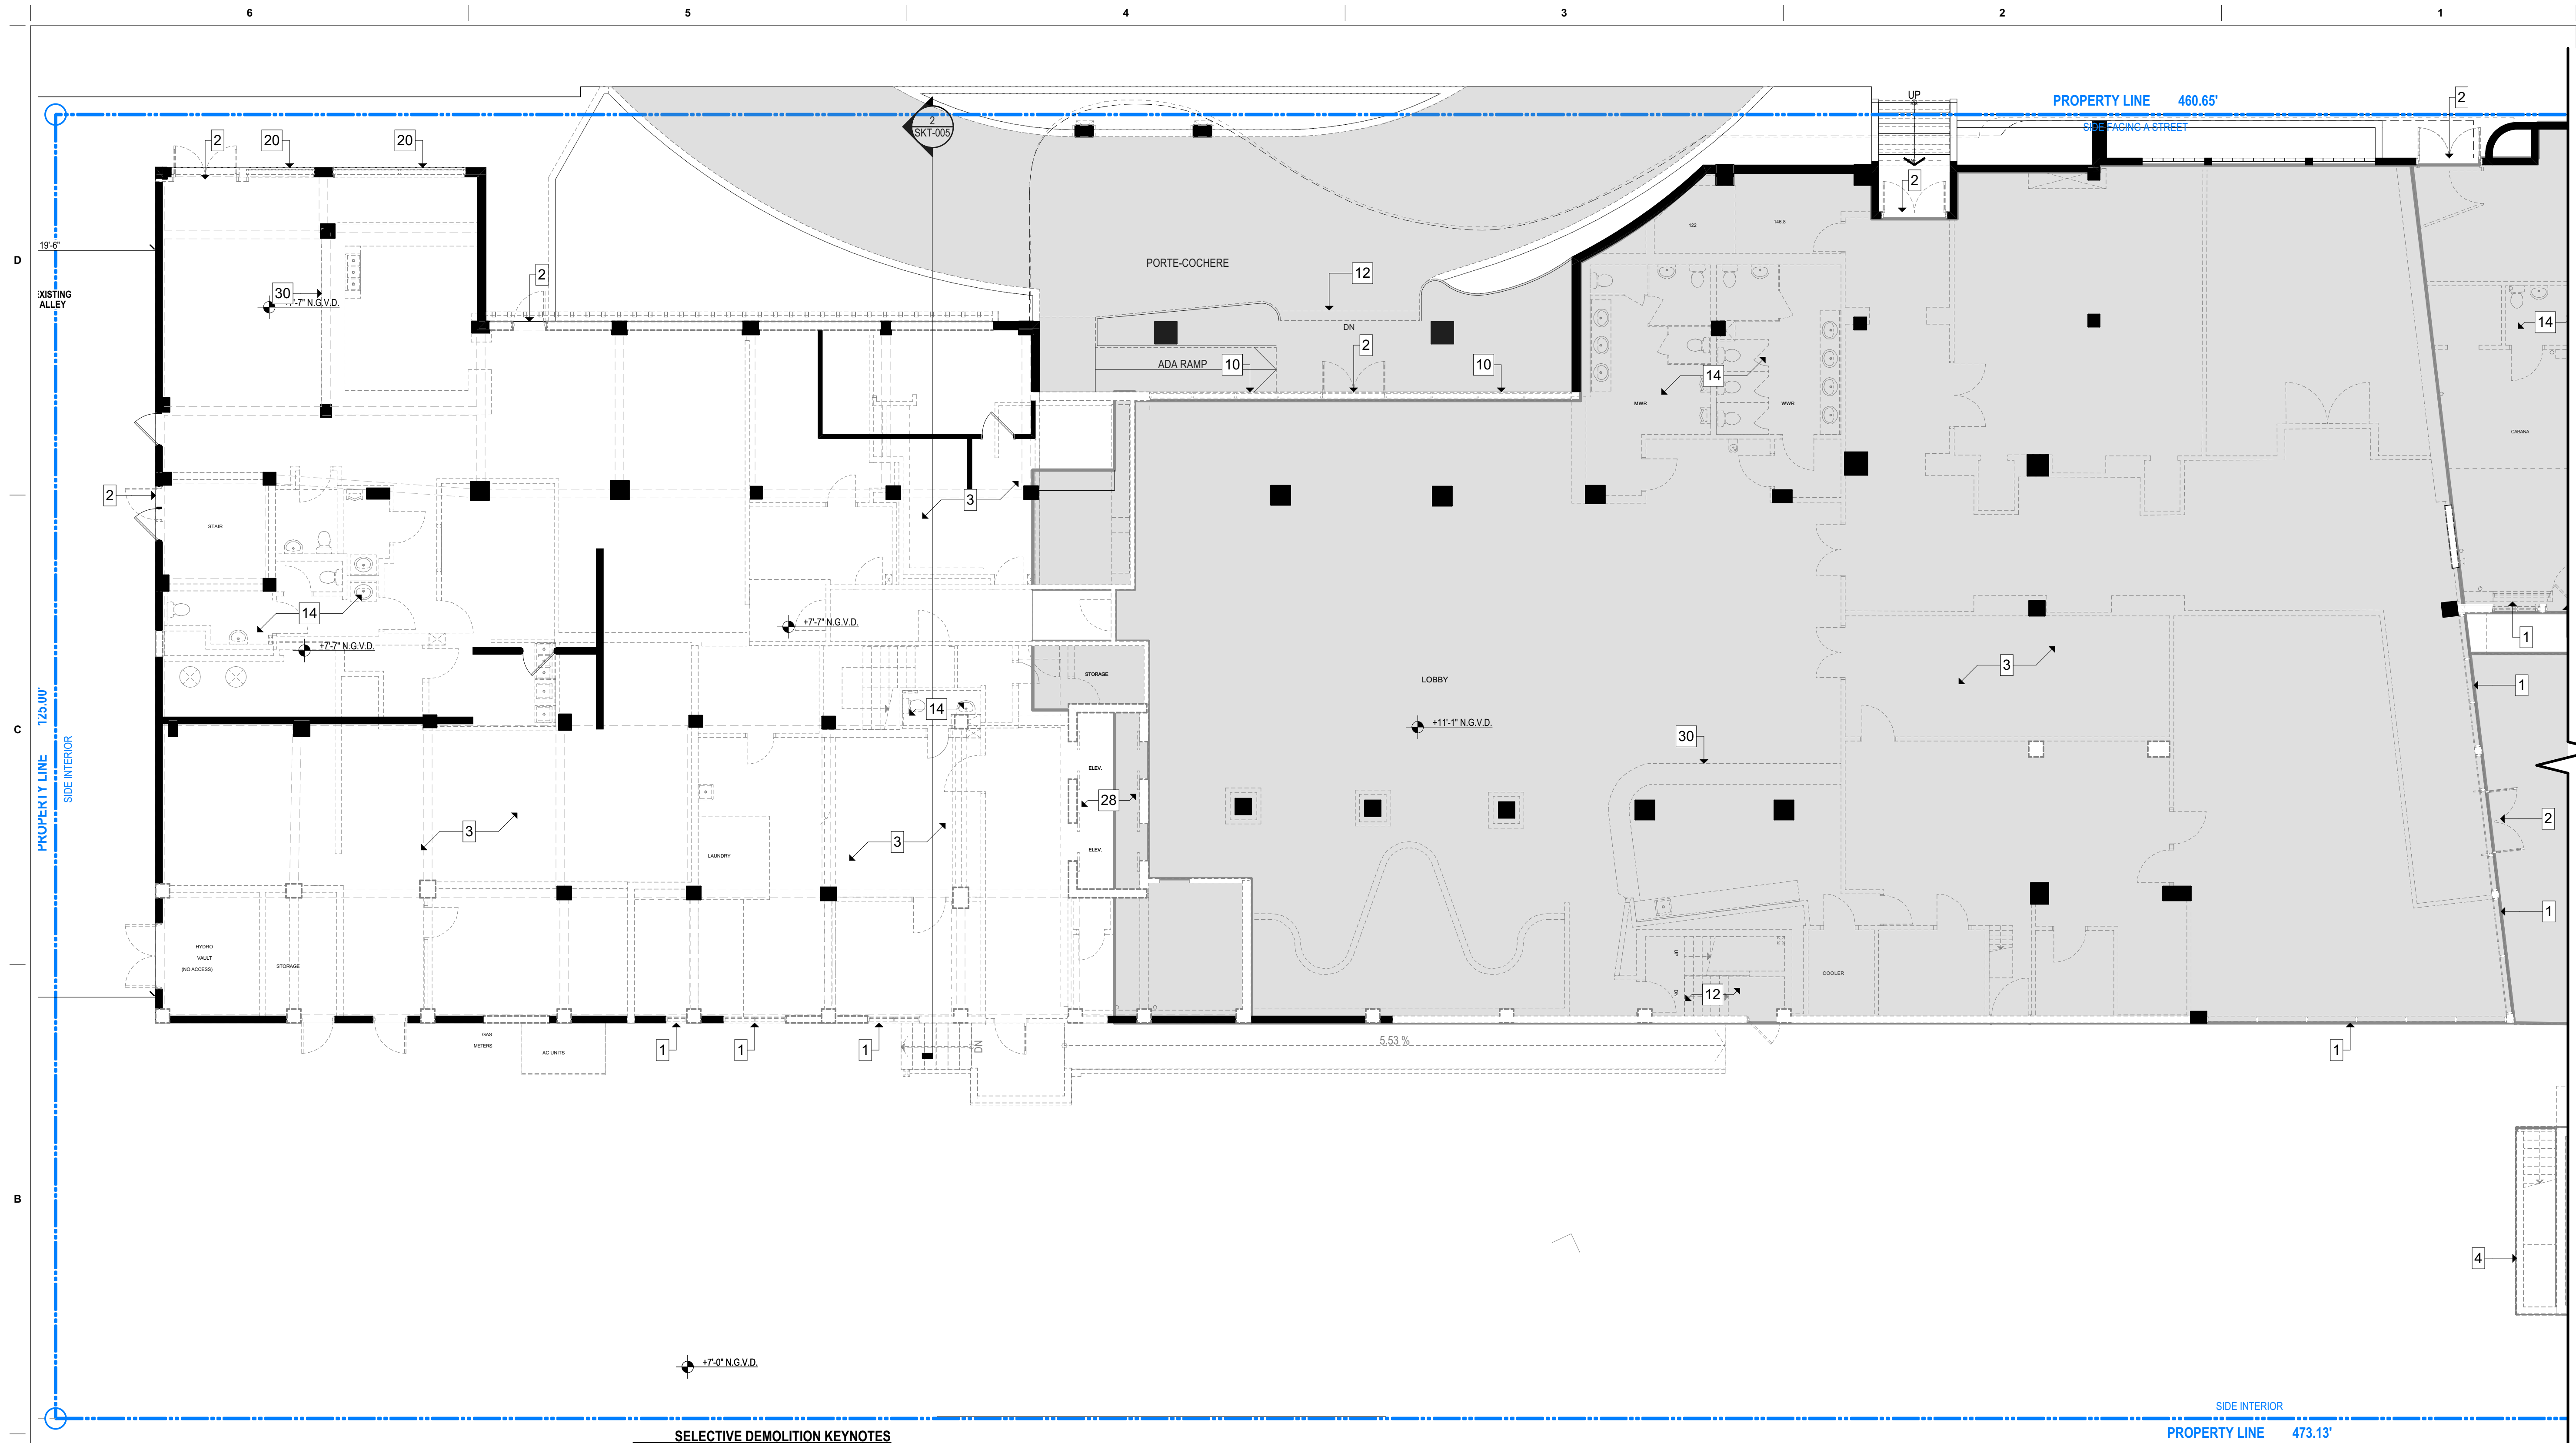

1. REMOVE EXISTING WINDOW AND WINDOW FRAME
2. REMOVE EXISTING DOOR AND DOOR FRAME
3. REMOVE EXISTING INTERIOR WALLS
4. REMOVE EXISTING EXTERIOR WALL
5. PROTECT AND REPAIR HISTORIC TERRAZZO FLOORING.
6. PROTECT AND REPAIR HISTORIC STAIR AND RAILINGS
7. REMOVE WATER FEATURE
8. REMOVE TRASH CHUTE
9. PROTECT AND REPAIR HISTORIC CEILING MOLDINGS
10. HISTORIC STOREFRONT AND WINDOW TO BE REMOVED
11. ELEVATOR DOOR TO BE REMOVED
12. REMOVE EXISTING STAIR AND RAILINGS
13. REMOVE ALL MECHANICAL AND ELECTRICAL EQUIPMENT
14. REMOVE ALL PLUMBING FIXTURES AND TOILET PARTITIONS


15. REMOVE EXISTING NON HISTORICAL RAILING .
16. DEMOLISH SECTION OF BUILDING IN ITS ENTIRETY AS SHOWN
17. REMOVE AND REBUILD EXISTING FLOOR SLAB ON AREA SHOWN
18. REMOVE EXISTING WALL FINISH
19. REMOVE EXISTING METAL GATE
20. REMOVE EXISTING STOREFRONT
21. REMOVE EXISTING NON-HISTORICAL RAMP
22. REMOVE EXISTING METAL STAIR, SUPPORTS AND RAILINGS
23. REMOVE EXISTING EXTERIOR MECHANICAL CHASE
24. REMOVE EXISTING KNEE WALL
25. REMOVE EXISTING METAL FENCE
26. REMOVE EXISTING NON-HISTORICAL ORNAMENTATION
27. REMOVE EXISTING NON-HISTORICAL FIRE PLACE
28. REMOVE EXISTING ELEVATOR AND ASSOCIATED EQUIPMENT

- 29] PROTECT AND REPAIR HISTORIC GUARD RAIL
- 30] REMOVE EXISTING BUILT-IN COUNTERS
- 31] REMOVE ALL ROOFING MATERIALS DOWN TO STRUCTURAL SLAB
- 32] REMOVE NON-HISTORICAL DECORATIVE BLOCK AND RAILING
- 33] REMOVE EXISTING BALCONY AND PARAPET
- 34] EXISTING BALCONY AND PARAPET TO REMAIN
- 35] REMOVE EXISTING PARAPET
- 36] EXISTING FAUX FIREPLACE TO REMAIN .
- 37] REMOVE AND PROTECT EXISTING ETCHED GLASS WINDOWS FOR RE-USE ON NEW DOORS.
- 38] REMOVE NON-HISTORICAL TILE ROOF
- 39] REMOVE LOUVERED WINDOW

 WALLS TO BE DEMOLISHED
 FLOORS TO BE DEMOLISHED


SCALE: 1/8" = 1'-0"

Sheet No.

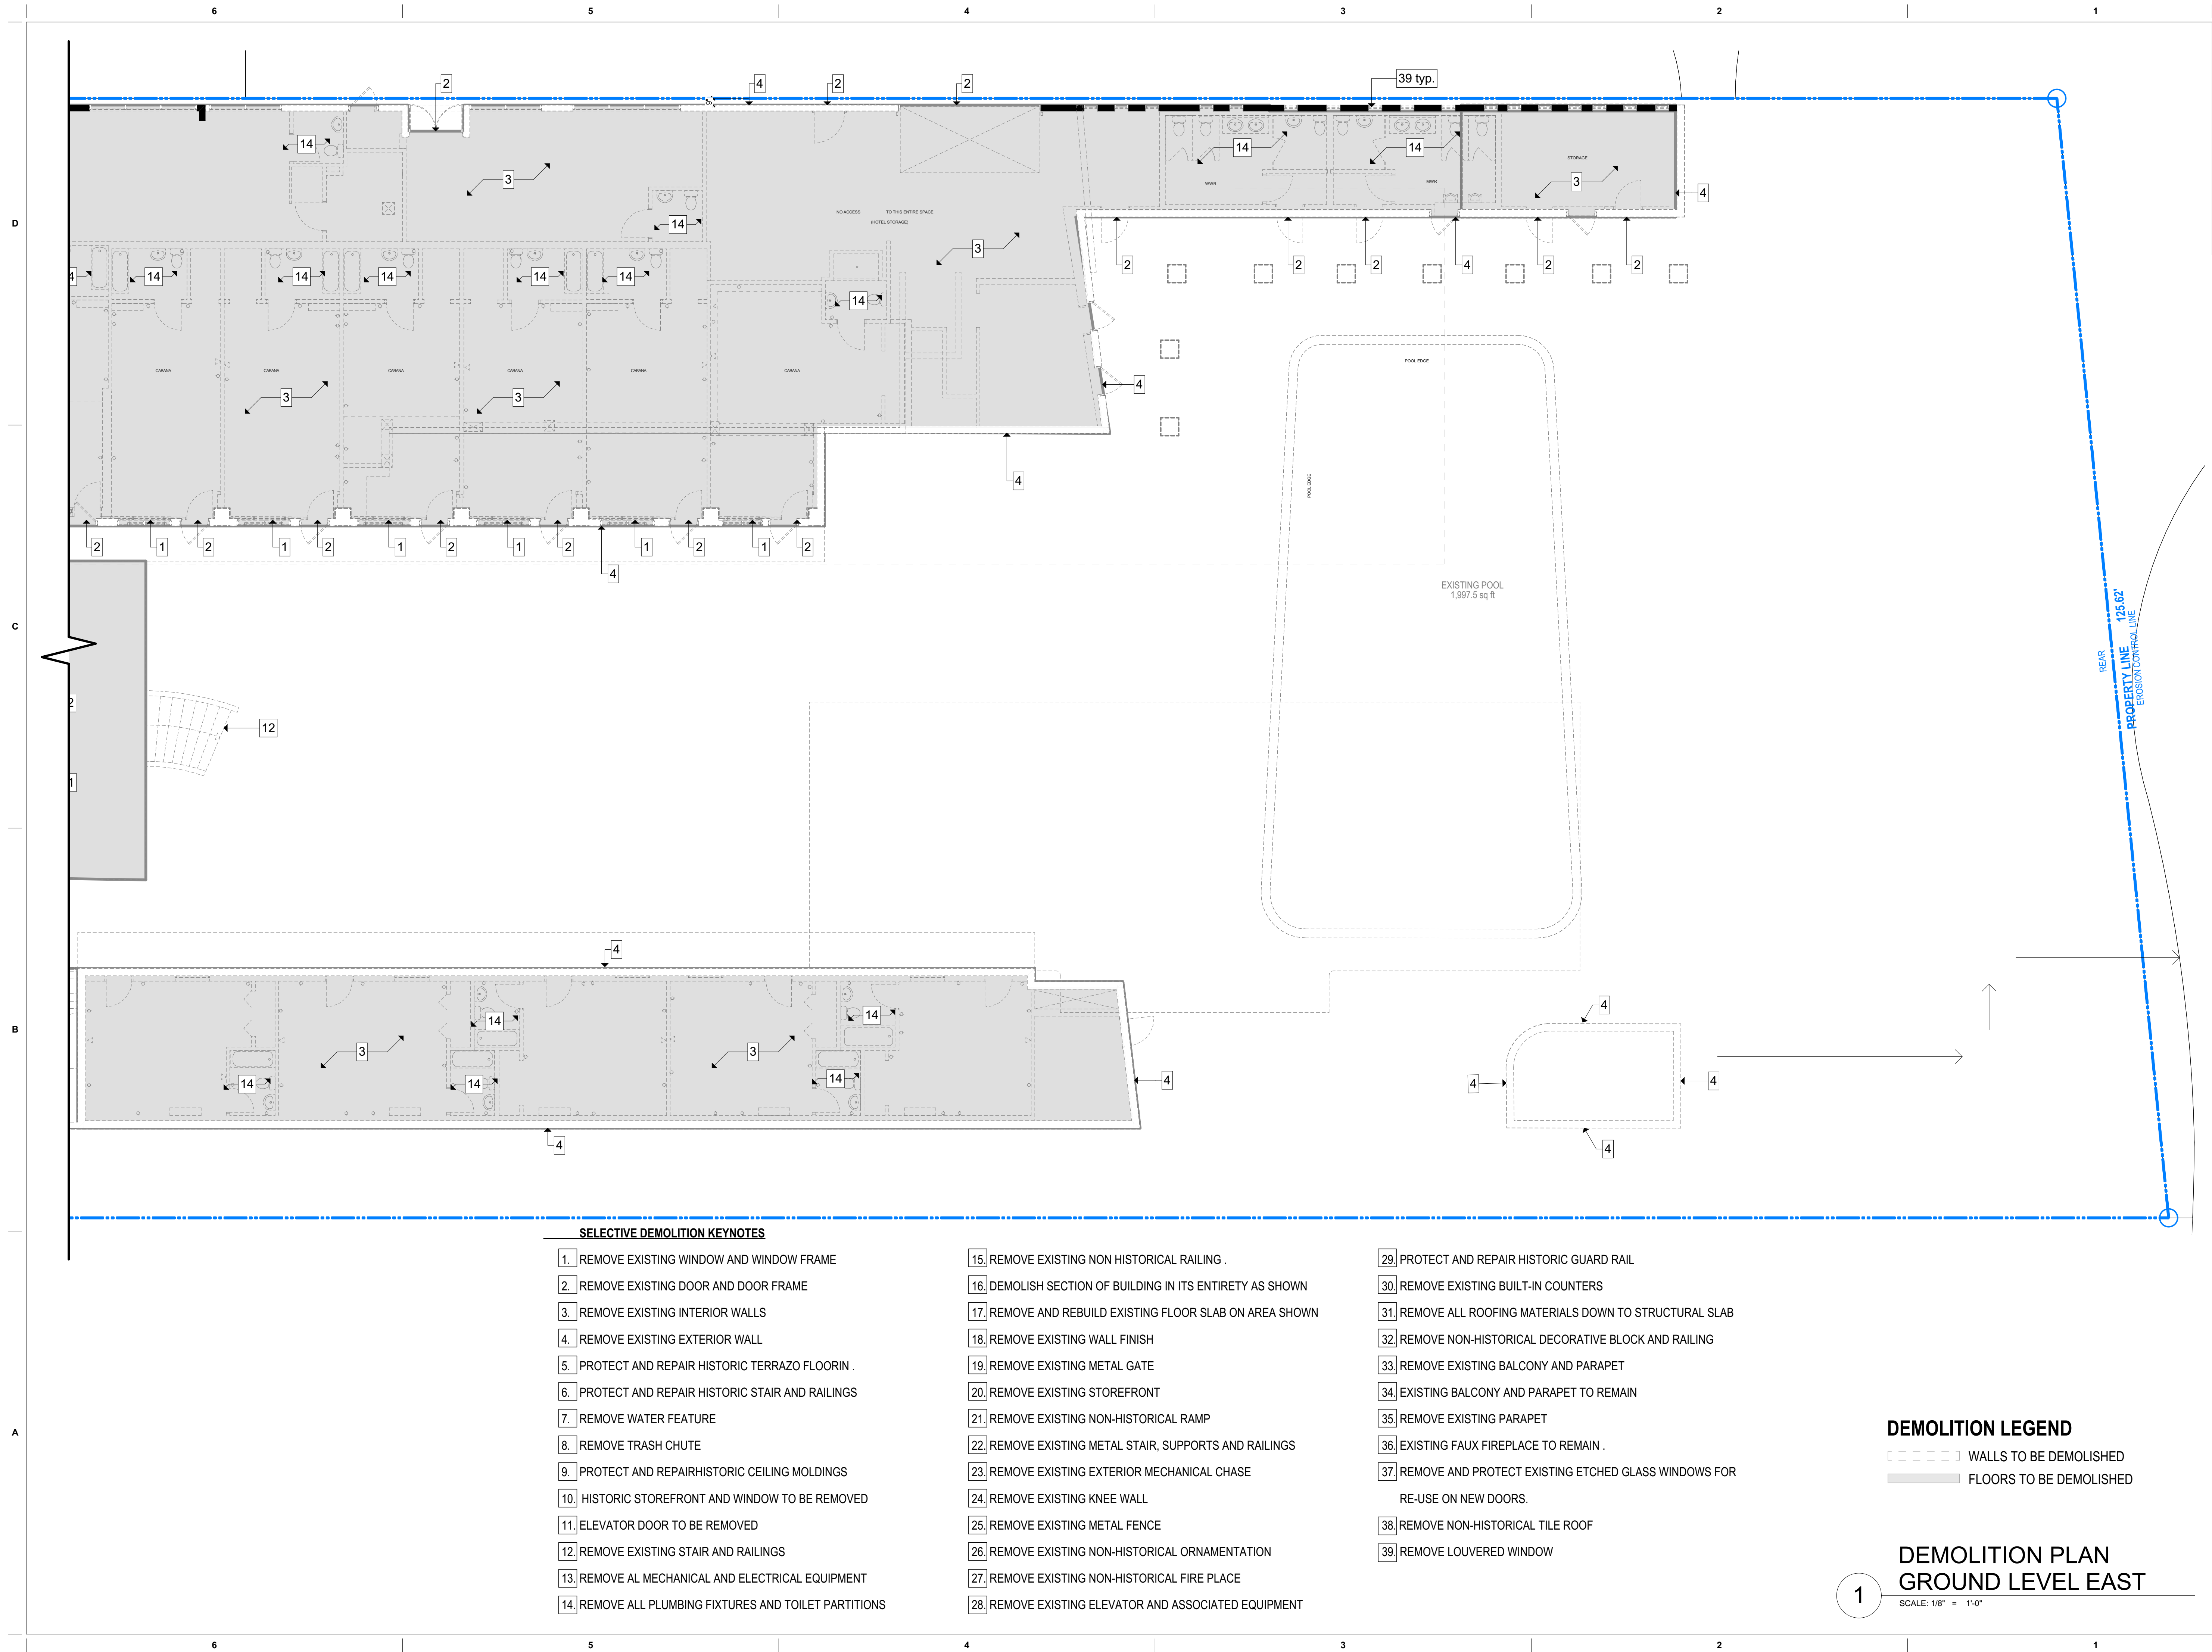

NOT FOR CONSTRUCTION

These Design And Drawings Are The Copyrighted Property Of Revuelta Architecture International, P.A. and May Not Be Reproduced Except with Specific Written Consent of the Architect. The Contractor Must Check And Verify All Dimensions Of The Job And Be Responsible For Same. Reporting Any Discrepancies To The Architects Before Commencing Work. Drawings Not to be Scaled. This Blueprint Shall Close 23. 1. Blueprint Basic for ARCHICAD 23/2020. Seal: PLU/2020-FL/01. By: 03/05/2021

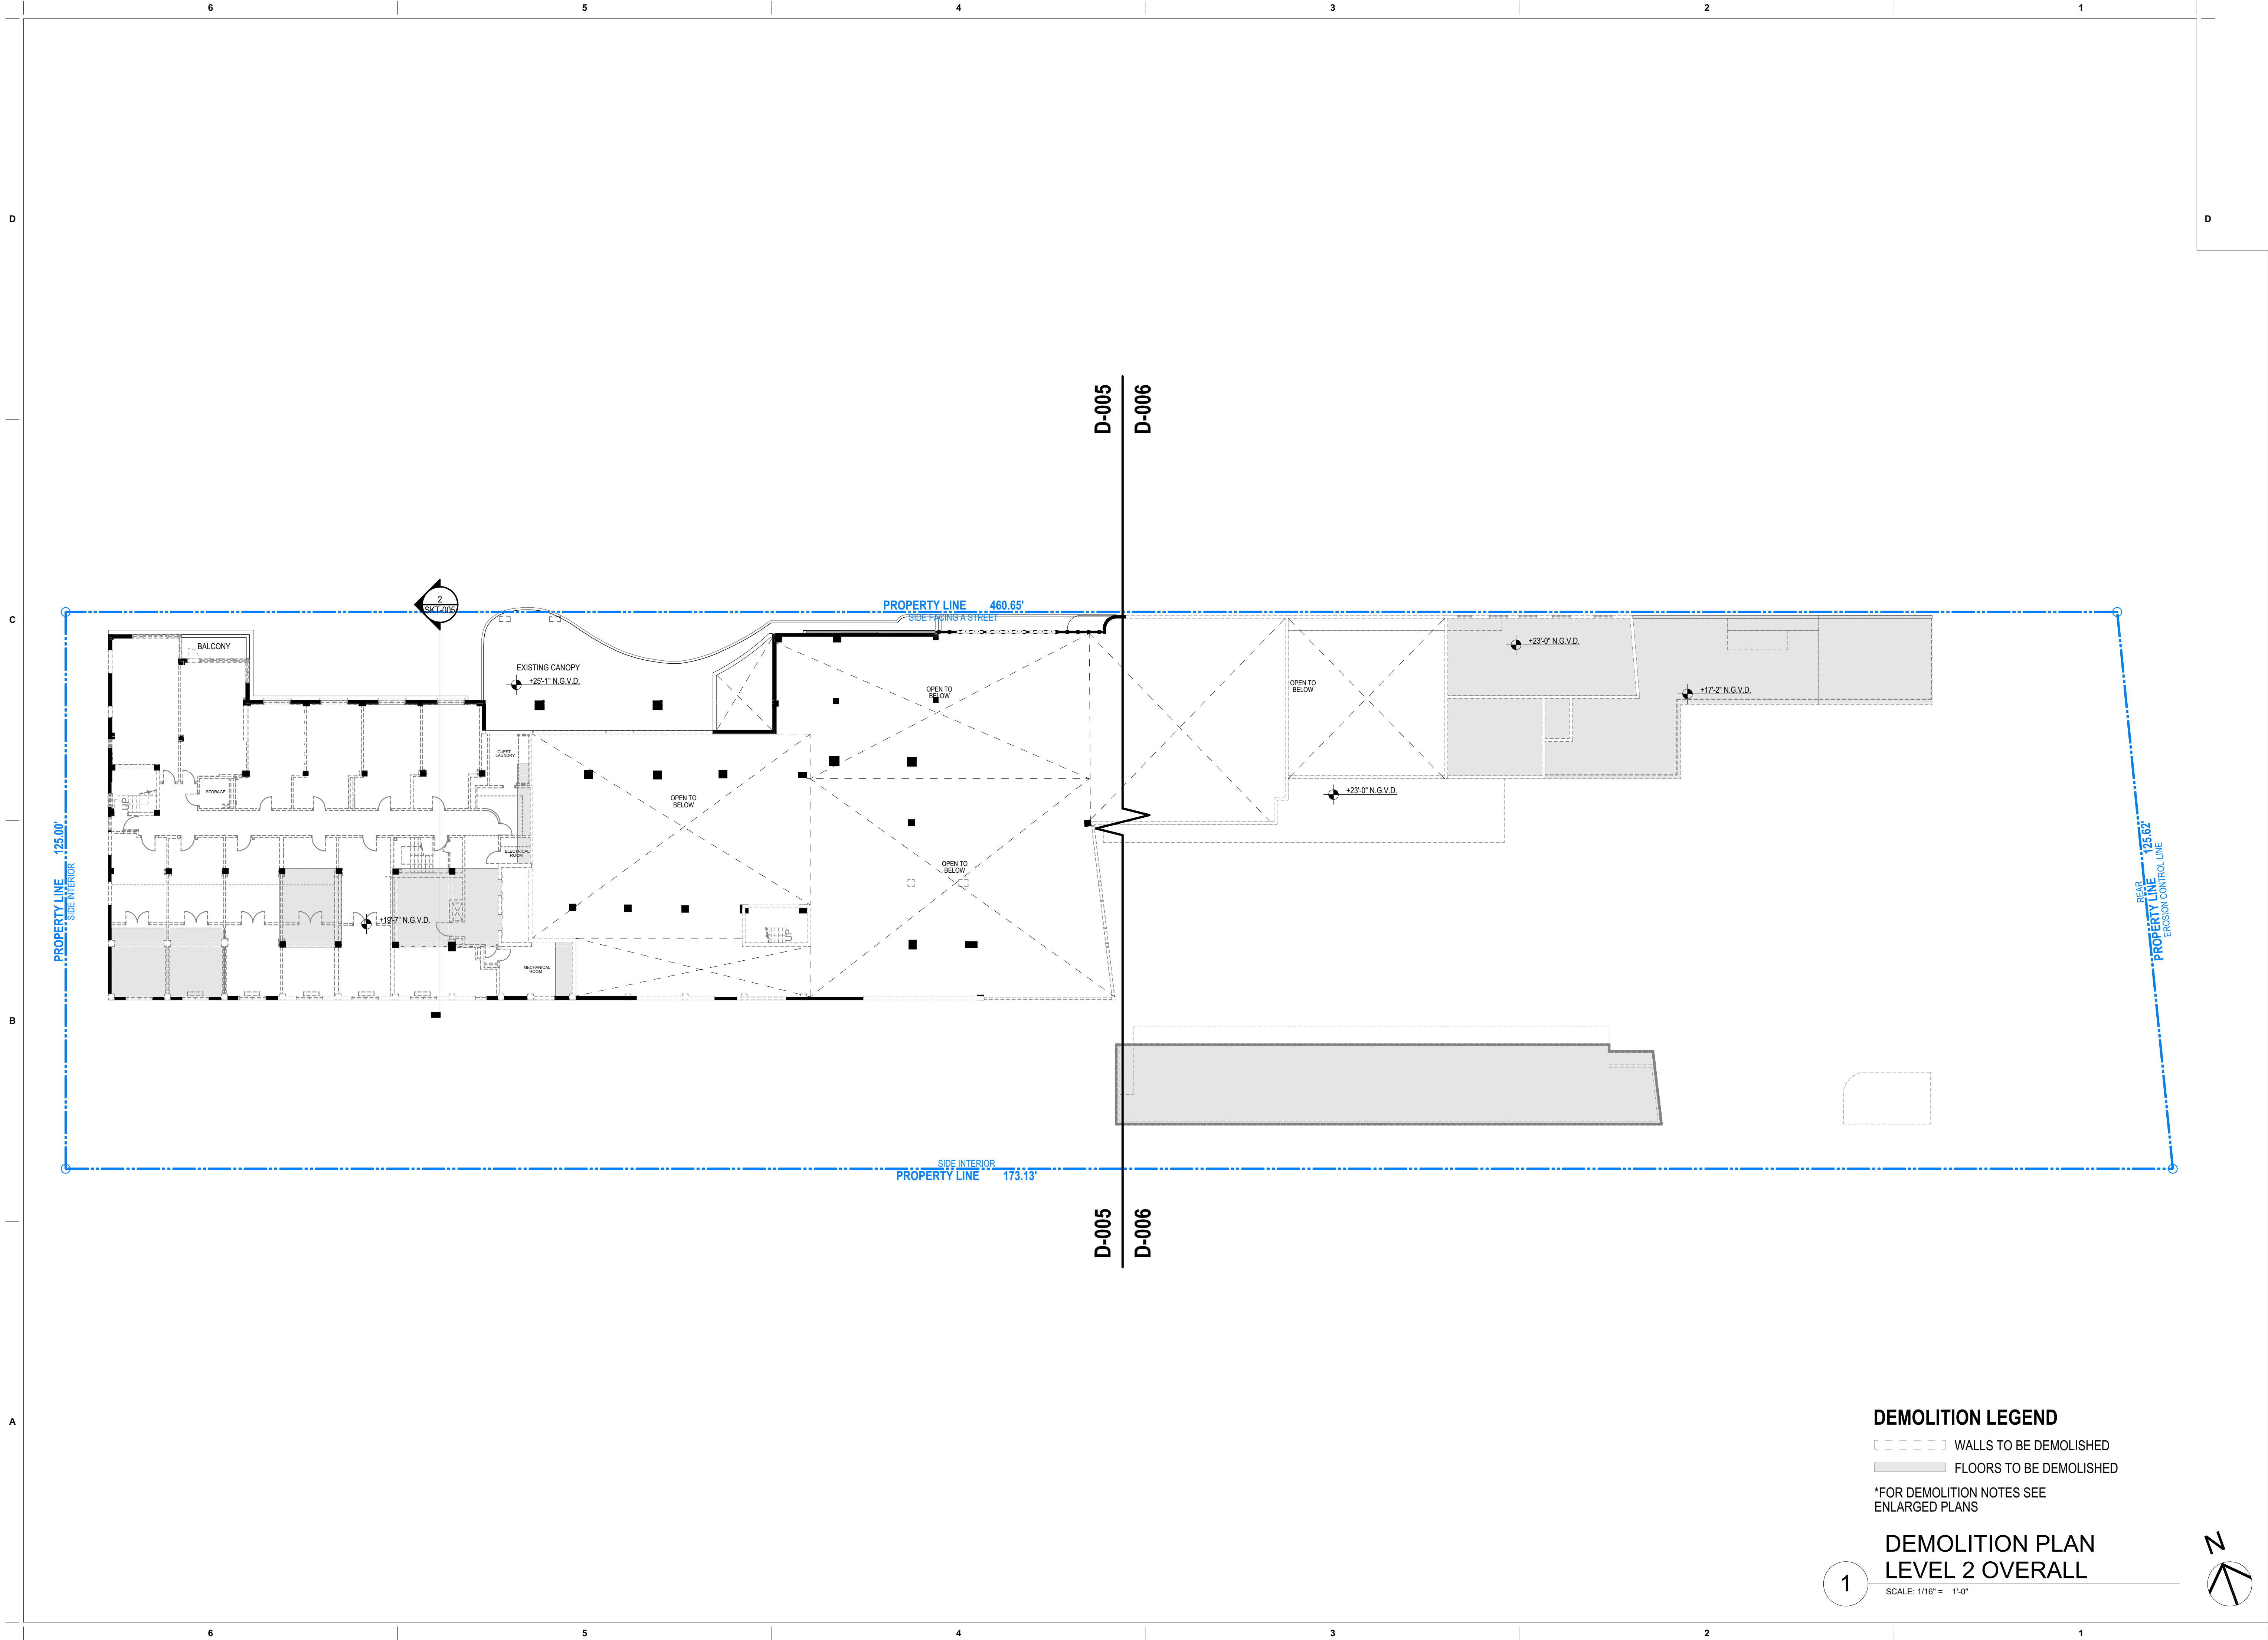

DEMOLITION LEGEND

- WALLS TO BE DEMOLISHED
- FLOORS TO BE DEMOLISHED

*FOR DEMOLITION NOTES SEE
ENLARGED PLANS

DEMOLITION PLAN LEVEL 2 OVERALL

SCALE: 1/16" = 1'-0"

revuelta
architecture
international

Miami
Santiago, Chile

revuelta-architecture.com

2950 SW 27TH AVE
SUITE 110
MIAMI, FL 33135
T: 305.590.5000
F: 305.590.5040

DESIGN ARCHITECT

CITTERIO-VIEL
& PARTNERS

Project

**BVLGARI HOTEL
MIAMI BEACH**
100 21st STREET
MIAMI BEACH, FL 33139

Revisions

Owner Information

BHI Miami Limited Corp.
1521 Alton Rd.
Suite 403
Miami Beach, FL 33139
(786) 785-6504

Consultant

Luis O. Revuelta

AR-007972

HPB SET

Date

03/05/2021

Scale

AS SHOWN

Project No.

2005

Sheet Name


DEMOLITION PLAN - LEVEL 2
OVERALL

Sheet No.

D-004

NOT FOR CONSTRUCTION

These Design And Drawings Are The Copyrighted Property Of Revuelta Architecture International, P.A. and May Not Be Reproduced Except with Specific Written Consent of the Architect. The Contractor Must Check And Verify All Dimensions Of The Job And Be Responsible For Same. Reporting Any Discrepancies To The Architects Before Commencing Work. Drawings Not to be Scaled. The Building: 100 21st Street, 11th Floor, Miami, FL 33139. Date: 03/05/2021

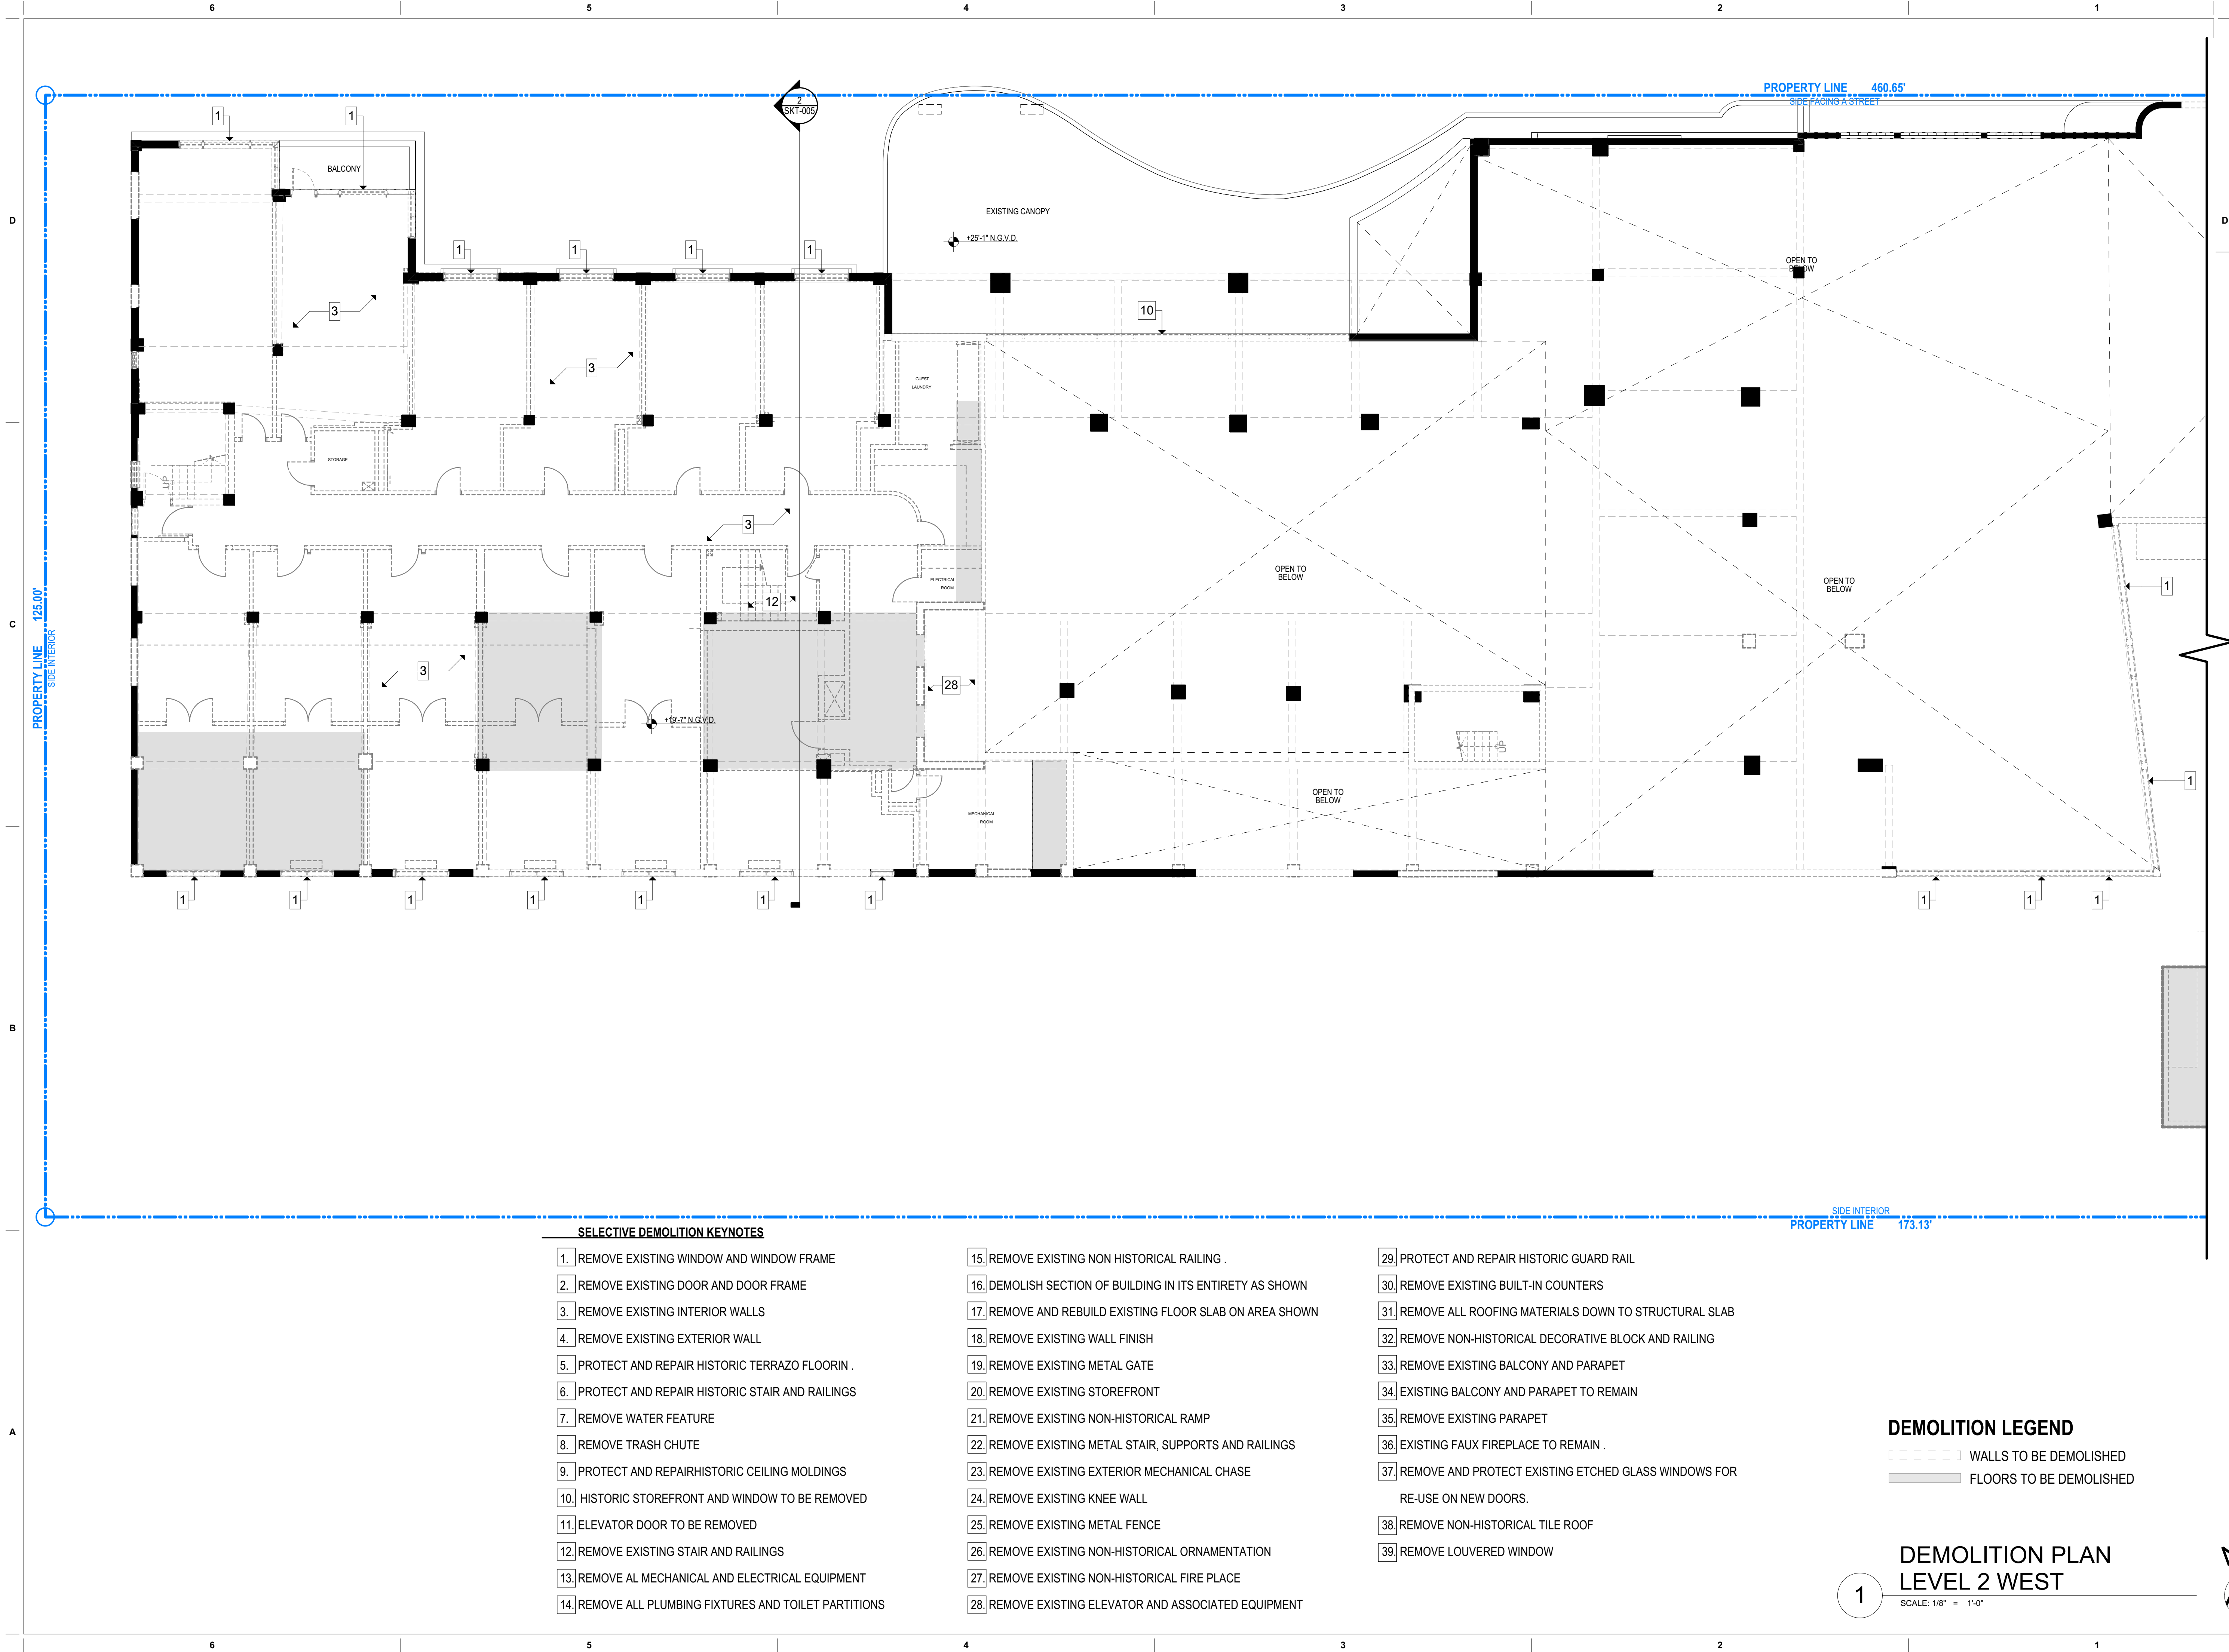

SELECTIVE DEMOLITION KEYNOTES

1. REMOVE EXISTING WINDOW AND WINDOW FRAME
2. REMOVE EXISTING DOOR AND DOOR FRAME
3. REMOVE EXISTING INTERIOR WALLS
4. REMOVE EXISTING EXTERIOR WALL
5. PROTECT AND REPAIR HISTORIC TERRAZO FLOORIN .
6. PROTECT AND REPAIR HISTORIC STAIR AND RAILINGS
7. REMOVE WATER FEATURE
8. REMOVE TRASH CHUTE
9. PROTECT AND REPAIR HISTORIC CEILING MOLDINGS
10. HISTORIC STOREFRONT AND WINDOW TO BE REMOVED
11. ELEVATOR DOOR TO BE REMOVED
12. REMOVE EXISTING STAIR AND RAILINGS
13. REMOVE AL MECHANICAL AND ELECTRICAL EQUIPMENT
14. REMOVE ALL PLUMBING FIXTURES AND TOILET PARTITIONS

15. REMOVE EXISTING NON HISTORICAL RAILING .
16. DEMOLISH SECTION OF BUILDING IN ITS ENTIRETY AS SHOWN
17. REMOVE AND REBUILD EXISTING FLOOR SLAB ON AREA SHOWN
18. REMOVE EXISTING WALL FINISH
19. REMOVE EXISTING METAL GATE
20. REMOVE EXISTING STOREFRONT
21. REMOVE EXISTING NON-HISTORICAL RAMP
22. REMOVE EXISTING METAL STAIR, SUPPORTS AND RAILINGS
23. REMOVE EXISTING EXTERIOR MECHANICAL CHASE
24. REMOVE EXISTING KNEE WALL
25. REMOVE EXISTING METAL FENCE
26. REMOVE EXISTING NON-HISTORICAL ORNAMENTATION
27. REMOVE EXISTING NON-HISTORICAL FIRE PLACE
28. REMOVE EXISTING ELEVATOR AND ASSOCIATED EQUIPMENT

29. PROTECT AND REPAIR HISTORIC GUARD RAIL
30. REMOVE EXISTING BUILT-IN COUNTERS
31. REMOVE ALL ROOFING MATERIALS DOWN TO STRUCTURAL SLAB
32. REMOVE NON-HISTORICAL DECORATIVE BLOCK AND RAILING
33. REMOVE EXISTING BALCONY AND PARAPET
34. EXISTING BALCONY AND PARAPET TO REMAIN
35. REMOVE EXISTING PARAPET
36. EXISTING FAUX FIREPLACE TO REMAIN .
37. REMOVE AND PROTECT EXISTING ETCHED GLASS WINDOWS FOR RE-USE ON NEW DOORS.
38. REMOVE NON-HISTORICAL TILE ROOF
39. REMOVE LOUVERED WINDOW

DEMOLITION LEGEND

- WALLS TO BE DEMOLISHED
- FLOORS TO BE DEMOLISHED

DEMOLITION PLAN
LEVEL 2 WEST

SCALE: 1/8" = 1'-0"

revuelta
architecture
international

Miami
Santiago, Chile

revuelta-architecture.com

2950 SW 27TH AVE
SUITE 110
MIAMI, FL 33135
T: 305.590.5000
F: 305.590.5040

DESIGN ARCHITECT

CITTERIO-VIEL
& PARTNERS

Project

**BVLGARI HOTEL
MIAMI BEACH**
100 21st STREET
MIAMI BEACH, FL 33139

Revisions

Owner Information

BHI Miami Limited Corp.
1521 Alton Rd.
Suite 403
Miami Beach, FL 33139
(786) 785-6504

Consultant

Luis O. Revuelta
AR-007972

HPB SET

Date

03/05/2021

Scale

AS SHOWN

Project No.

2005

Sheet Name


DEMOLITION PLAN - LEVEL 2 WEST

Sheet No.

D-005

NOT FOR CONSTRUCTION

These Design And Drawings Are The Copyrighted Property Of Revuelta Architecture International, P.A. and May Not Be Reproduced Except with Specific Written Consent of the Architect. The Contractor Must Check And Verify All Dimensions Of The Job And Be Responsible For Same. Reporting Any Discrepancies To The Architects Before Commencing Work. Drawings Not to be Scaled. The Blueprint Shall Be the Basis for Construction. No Field Changes Shall Be Made Without the Written Approval of the Architect. By Approval: Date: 3/26/21

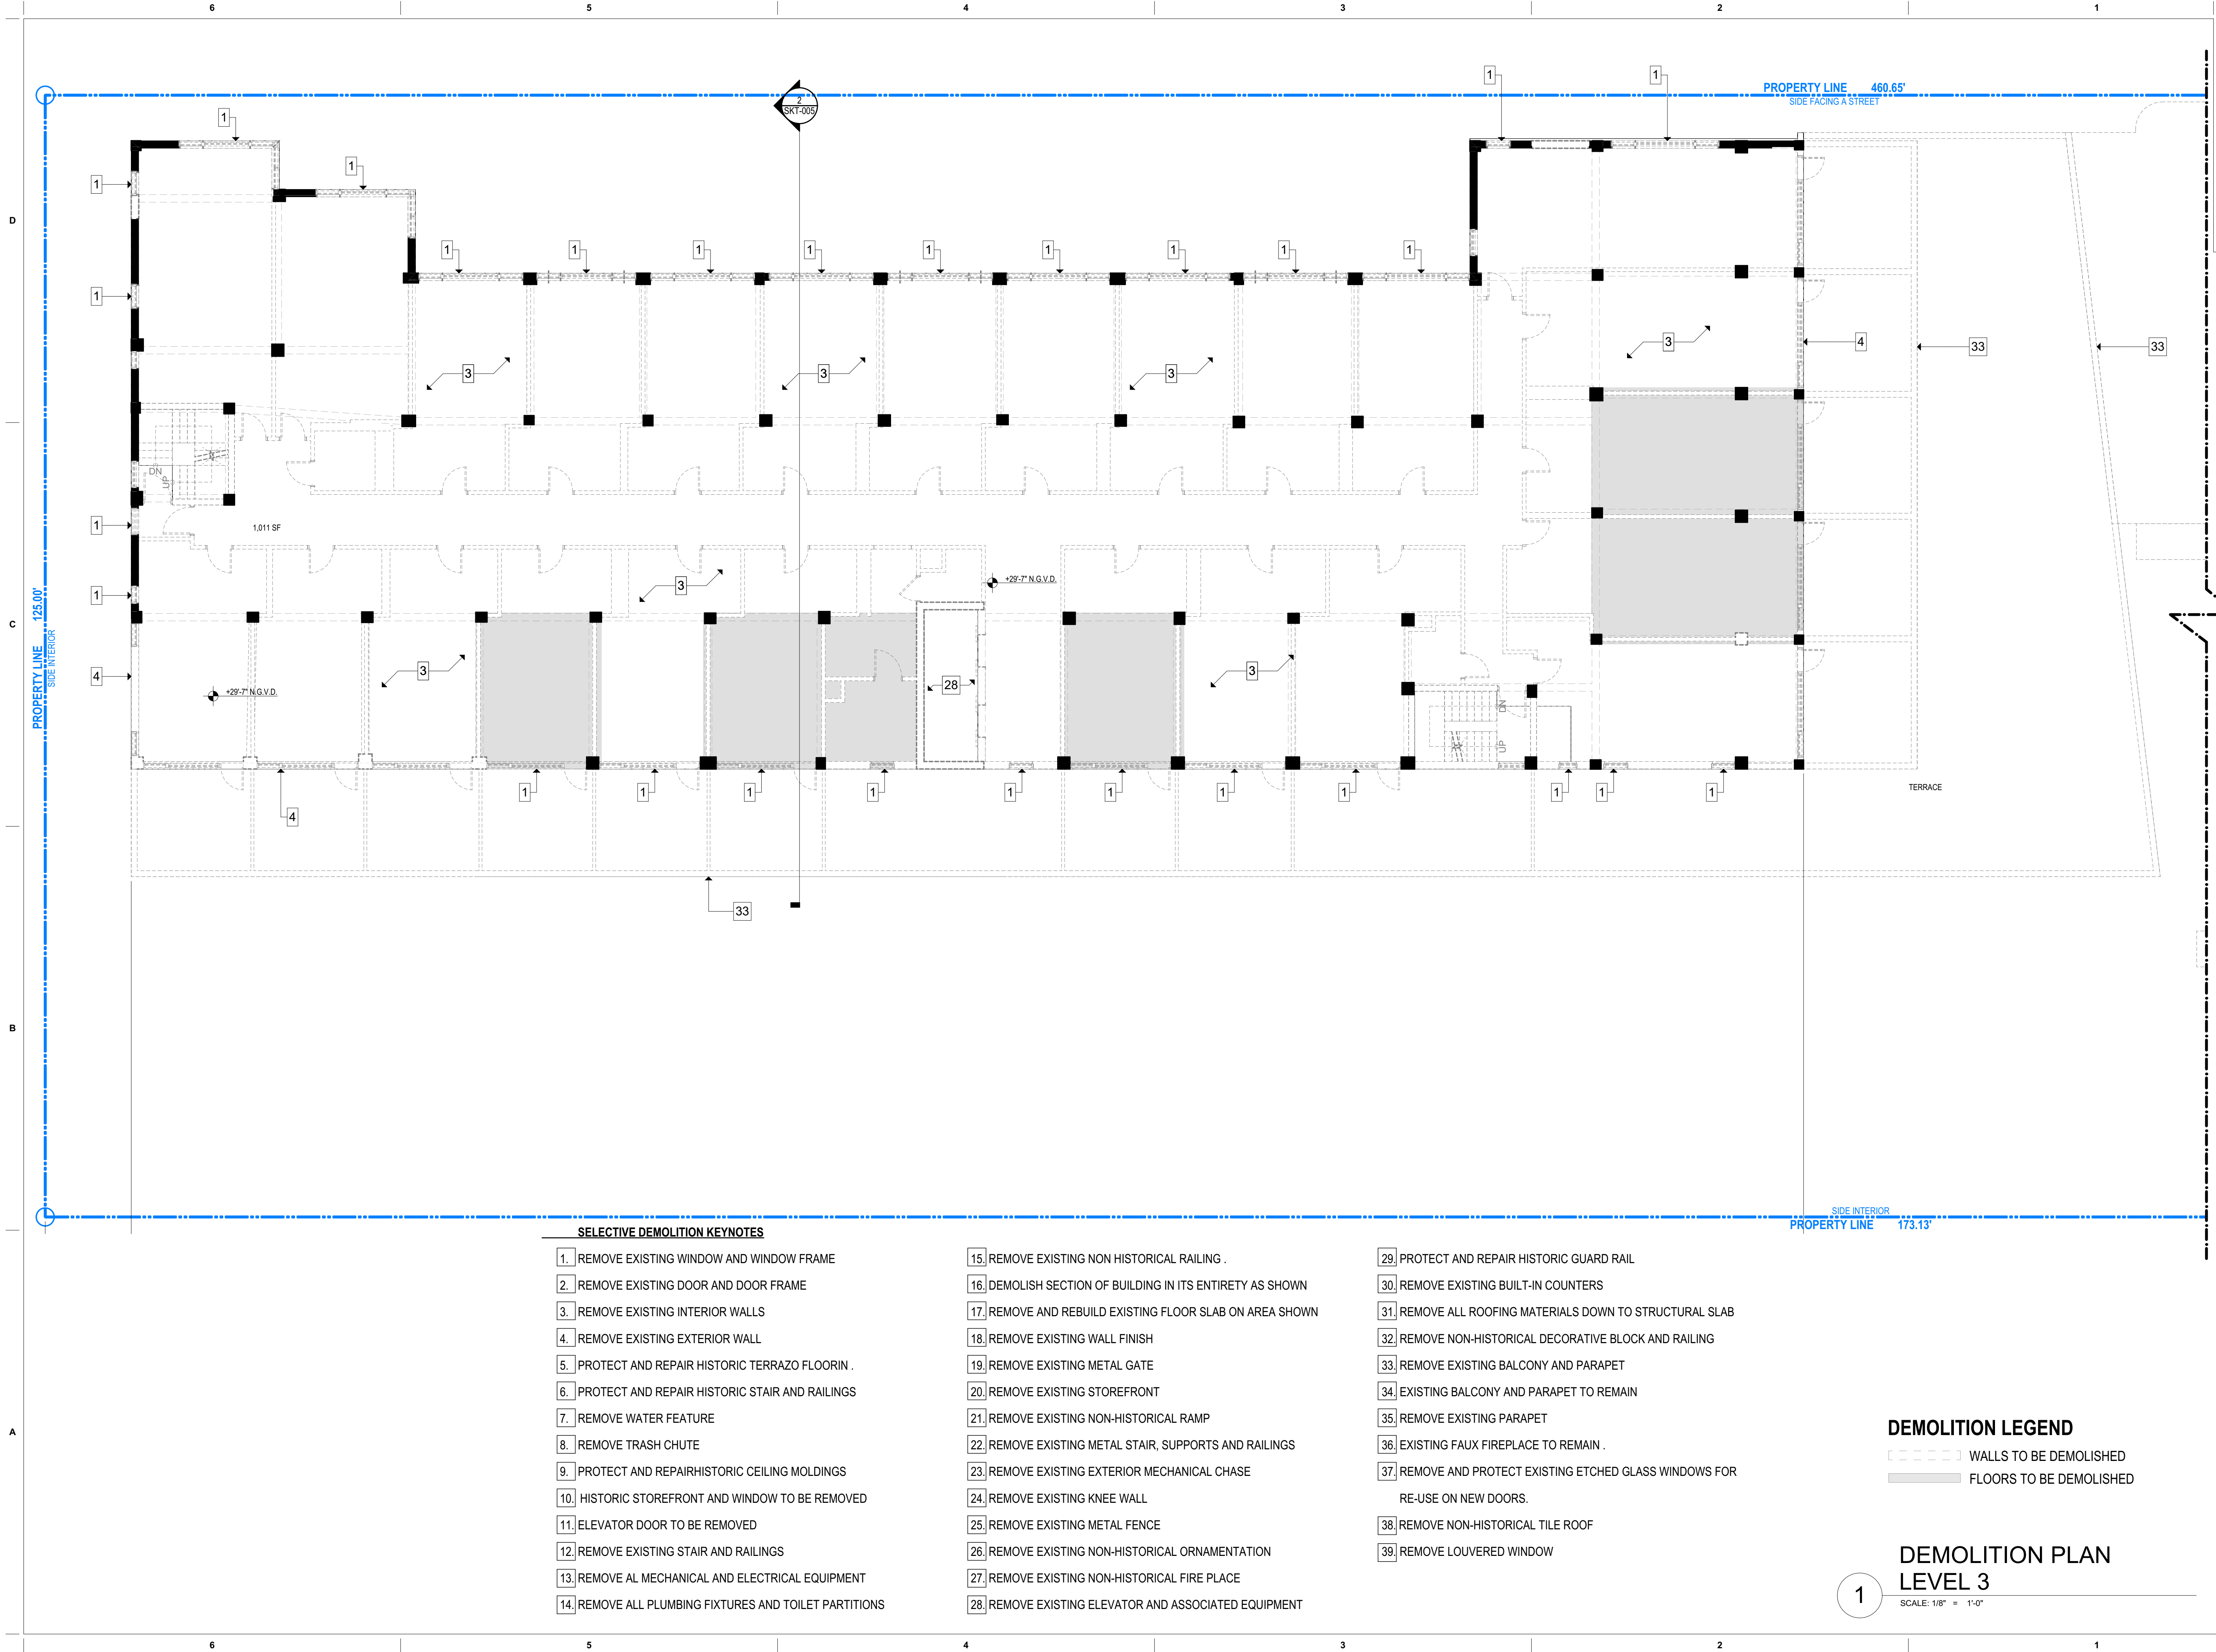

SELECTIVE DEMOLITION KEYNOTES

1. REMOVE EXISTING WINDOW AND WINDOW FRAME
2. REMOVE EXISTING DOOR AND DOOR FRAME
3. REMOVE EXISTING INTERIOR WALLS
4. REMOVE EXISTING EXTERIOR WALL
5. PROTECT AND REPAIR HISTORIC TERRAZO FLOORIN .
6. PROTECT AND REPAIR HISTORIC STAIR AND RAILINGS
7. REMOVE WATER FEATURE
8. REMOVE TRASH CHUTE
9. PROTECT AND REPAIR HISTORIC CEILING MOLDINGS
10. HISTORIC STOREFRONT AND WINDOW TO BE REMOVED
11. ELEVATOR DOOR TO BE REMOVED
12. REMOVE EXISTING STAIR AND RAILINGS
13. REMOVE AL MECHANICAL AND ELECTRICAL EQUIPMENT
14. REMOVE ALL PLUMBING FIXTURES AND TOILET PARTITIONS

15. REMOVE EXISTING NON HISTORICAL RAILING .
16. DEMOLISH SECTION OF BUILDING IN ITS ENTIRETY AS SHOWN
17. REMOVE AND REBUILD EXISTING FLOOR SLAB ON AREA SHOWN
18. REMOVE EXISTING WALL FINISH
19. REMOVE EXISTING METAL GATE
20. REMOVE EXISTING STOREFRONT
21. REMOVE EXISTING NON-HISTORICAL RAMP
22. REMOVE EXISTING METAL STAIR, SUPPORTS AND RAILINGS
23. REMOVE EXISTING EXTERIOR MECHANICAL CHASE
24. REMOVE EXISTING KNEE WALL
25. REMOVE EXISTING METAL FENCE
26. REMOVE EXISTING NON-HISTORICAL ORNAMENTATION
27. REMOVE EXISTING NON-HISTORICAL FIRE PLACE
28. REMOVE EXISTING ELEVATOR AND ASSOCIATED EQUIPMENT

29. PROTECT AND REPAIR HISTORIC GUARD RAIL
30. REMOVE EXISTING BUILT-IN COUNTERS
31. REMOVE ALL ROOFING MATERIALS DOWN TO STRUCTURAL SLAB
32. REMOVE NON-HISTORICAL DECORATIVE BLOCK AND RAILING
33. REMOVE EXISTING BALCONY AND PARAPET
34. EXISTING BALCONY AND PARAPET TO REMAIN
35. REMOVE EXISTING PARAPET
36. EXISTING FAUX FIREPLACE TO REMAIN .
37. REMOVE AND PROTECT EXISTING ETCHED GLASS WINDOWS FOR RE-USE ON NEW DOORS.
38. REMOVE NON-HISTORICAL TILE ROOF
39. REMOVE LOUVERED WINDOW

DEMOLITION LEGEND

- WALLS TO BE DEMOLISHED
- FLOORS TO BE DEMOLISHED

DEMOLITION PLAN
LEVEL 3

SCALE: 1/8" = 1'-0"

revuelta
architecture
international

Miami
Santiago, Chile

revuelta-architecture.com

2950 SW 27TH AVE
SUITE 110
MIAMI, FL 33135
T: 305.590.5000
F: 305.590.5040

DESIGN ARCHITECT

CITTERIO-VIEL
& PARTNERS

Project

BVLGARI HOTEL
MIAMI BEACH
100 21st STREET
MIAMI BEACH, FL 33139

Revisions

Owner Information

BHI Miami Limited Corp.
1521 Alton Rd.
Suite 403
Miami Beach, FL 33139
(786) 785-6504

Consultant

Luis O. Revuelta

AR-007972

HPB SET

Date

03/05/2021

Scale

AS SHOWN

Project No.

2005

Sheet Name

DEMOLITION PLAN - LEVEL 3

Sheet No.

D-007


1. REMOVE EXISTING WINDOW AND WINDOW FRAME
2. REMOVE EXISTING DOOR AND DOOR FRAME
3. REMOVE EXISTING INTERIOR WALLS
4. REMOVE EXISTING EXTERIOR WALL
5. PROTECT AND REPAIR HISTORIC TERRAZZO FLOORING.
6. PROTECT AND REPAIR HISTORIC STAIR AND RAILINGS
7. REMOVE WATER FEATURE
8. REMOVE TRASH CHUTE
9. PROTECT AND REPAIR HISTORIC CEILING MOLDINGS
10. HISTORIC STOREFRONT AND WINDOW TO BE REMOVED
11. ELEVATOR DOOR TO BE REMOVED
12. REMOVE EXISTING STAIR AND RAILINGS
13. REMOVE ALL MECHANICAL AND ELECTRICAL EQUIPMENT
14. REMOVE ALL PLUMBING FIXTURES AND TOILET PARTITIONS


15. REMOVE EXISTING NON HISTORICAL RAILING .
16. DEMOLISH SECTION OF BUILDING IN ITS ENTIRETY AS SHOWN
17. REMOVE AND REBUILD EXISTING FLOOR SLAB ON AREA SHOWN
18. REMOVE EXISTING WALL FINISH
19. REMOVE EXISTING METAL GATE
20. REMOVE EXISTING STOREFRONT
21. REMOVE EXISTING NON-HISTORICAL RAMP
22. REMOVE EXISTING METAL STAIR, SUPPORTS AND RAILINGS
23. REMOVE EXISTING EXTERIOR MECHANICAL CHASE
24. REMOVE EXISTING KNEE WALL
25. REMOVE EXISTING METAL FENCE
26. REMOVE EXISTING NON-HISTORICAL ORNAMENTATION
27. REMOVE EXISTING NON-HISTORICAL FIRE PLACE
28. REMOVE EXISTING ELEVATOR AND ASSOCIATED EQUIPMENT

38. REMOVE NON-HISTORICAL TILE ROOF
39. REMOVE LOUVERED WINDOW

DEMOLITION PLAN
LEVEL 4 THROUGH 7

SCALE: 1/8" = 1'-0"

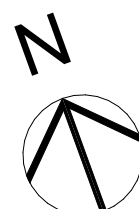


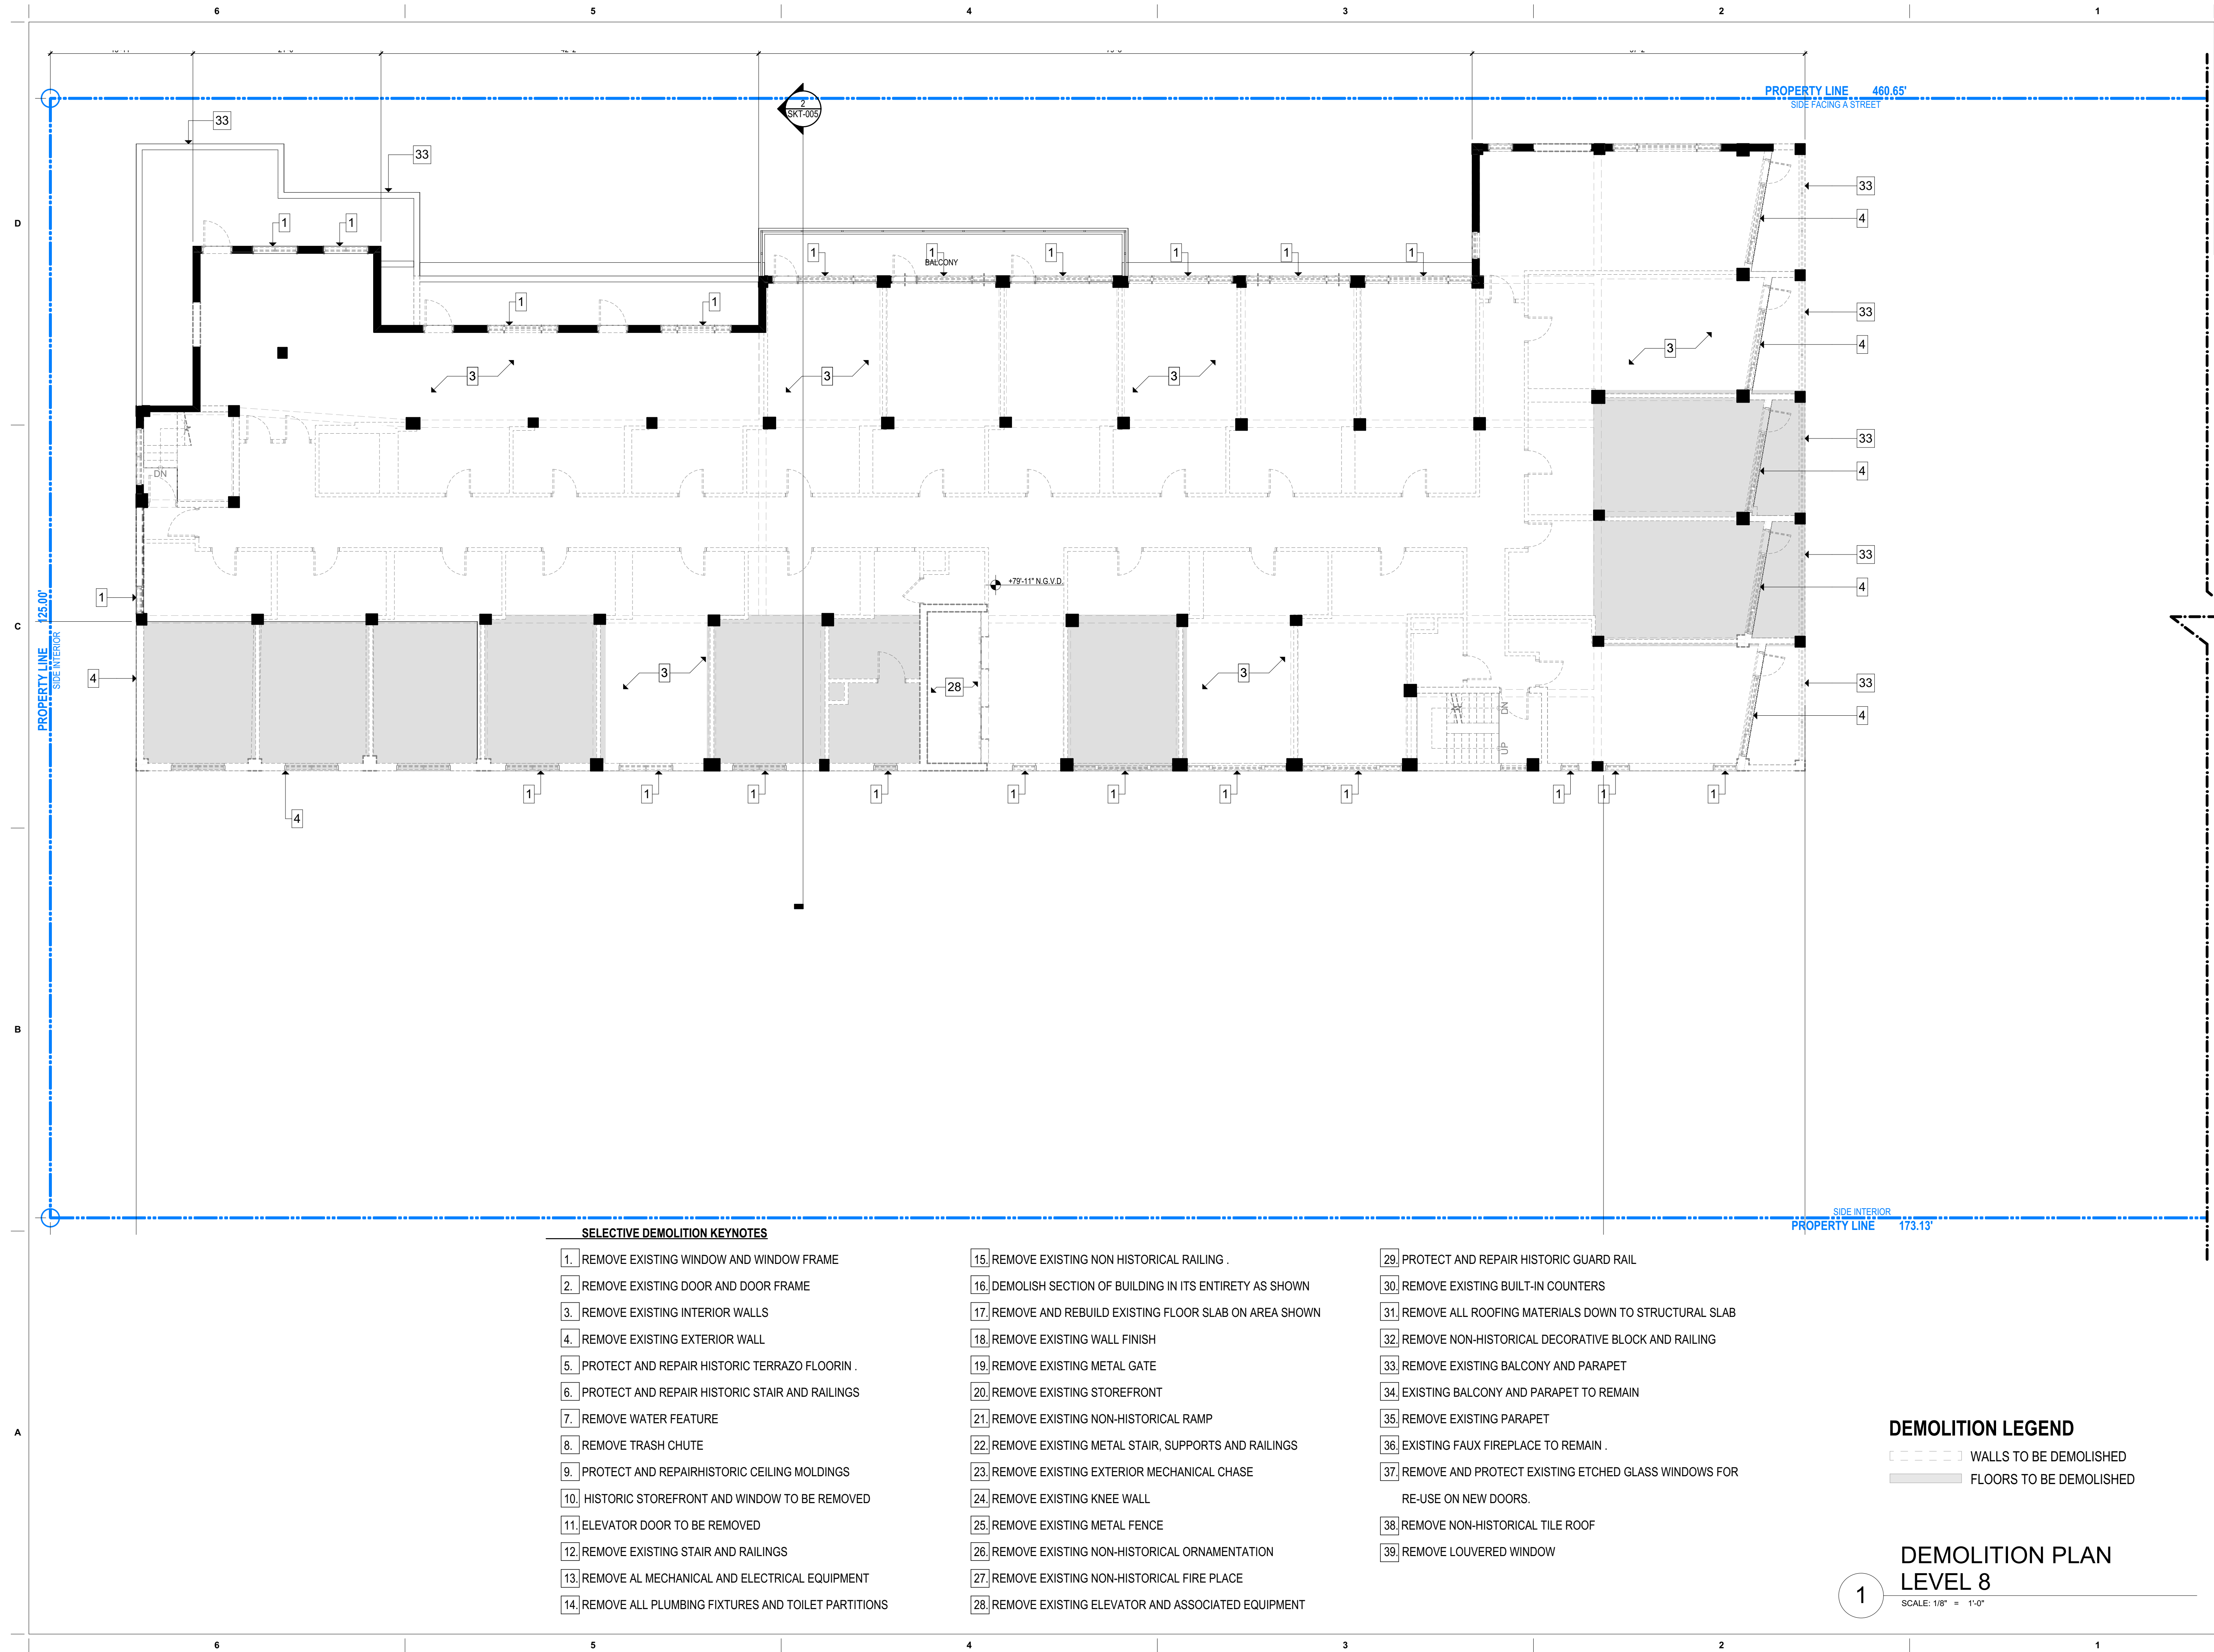

00

D-009

NOT FOR CONSTRUCTION

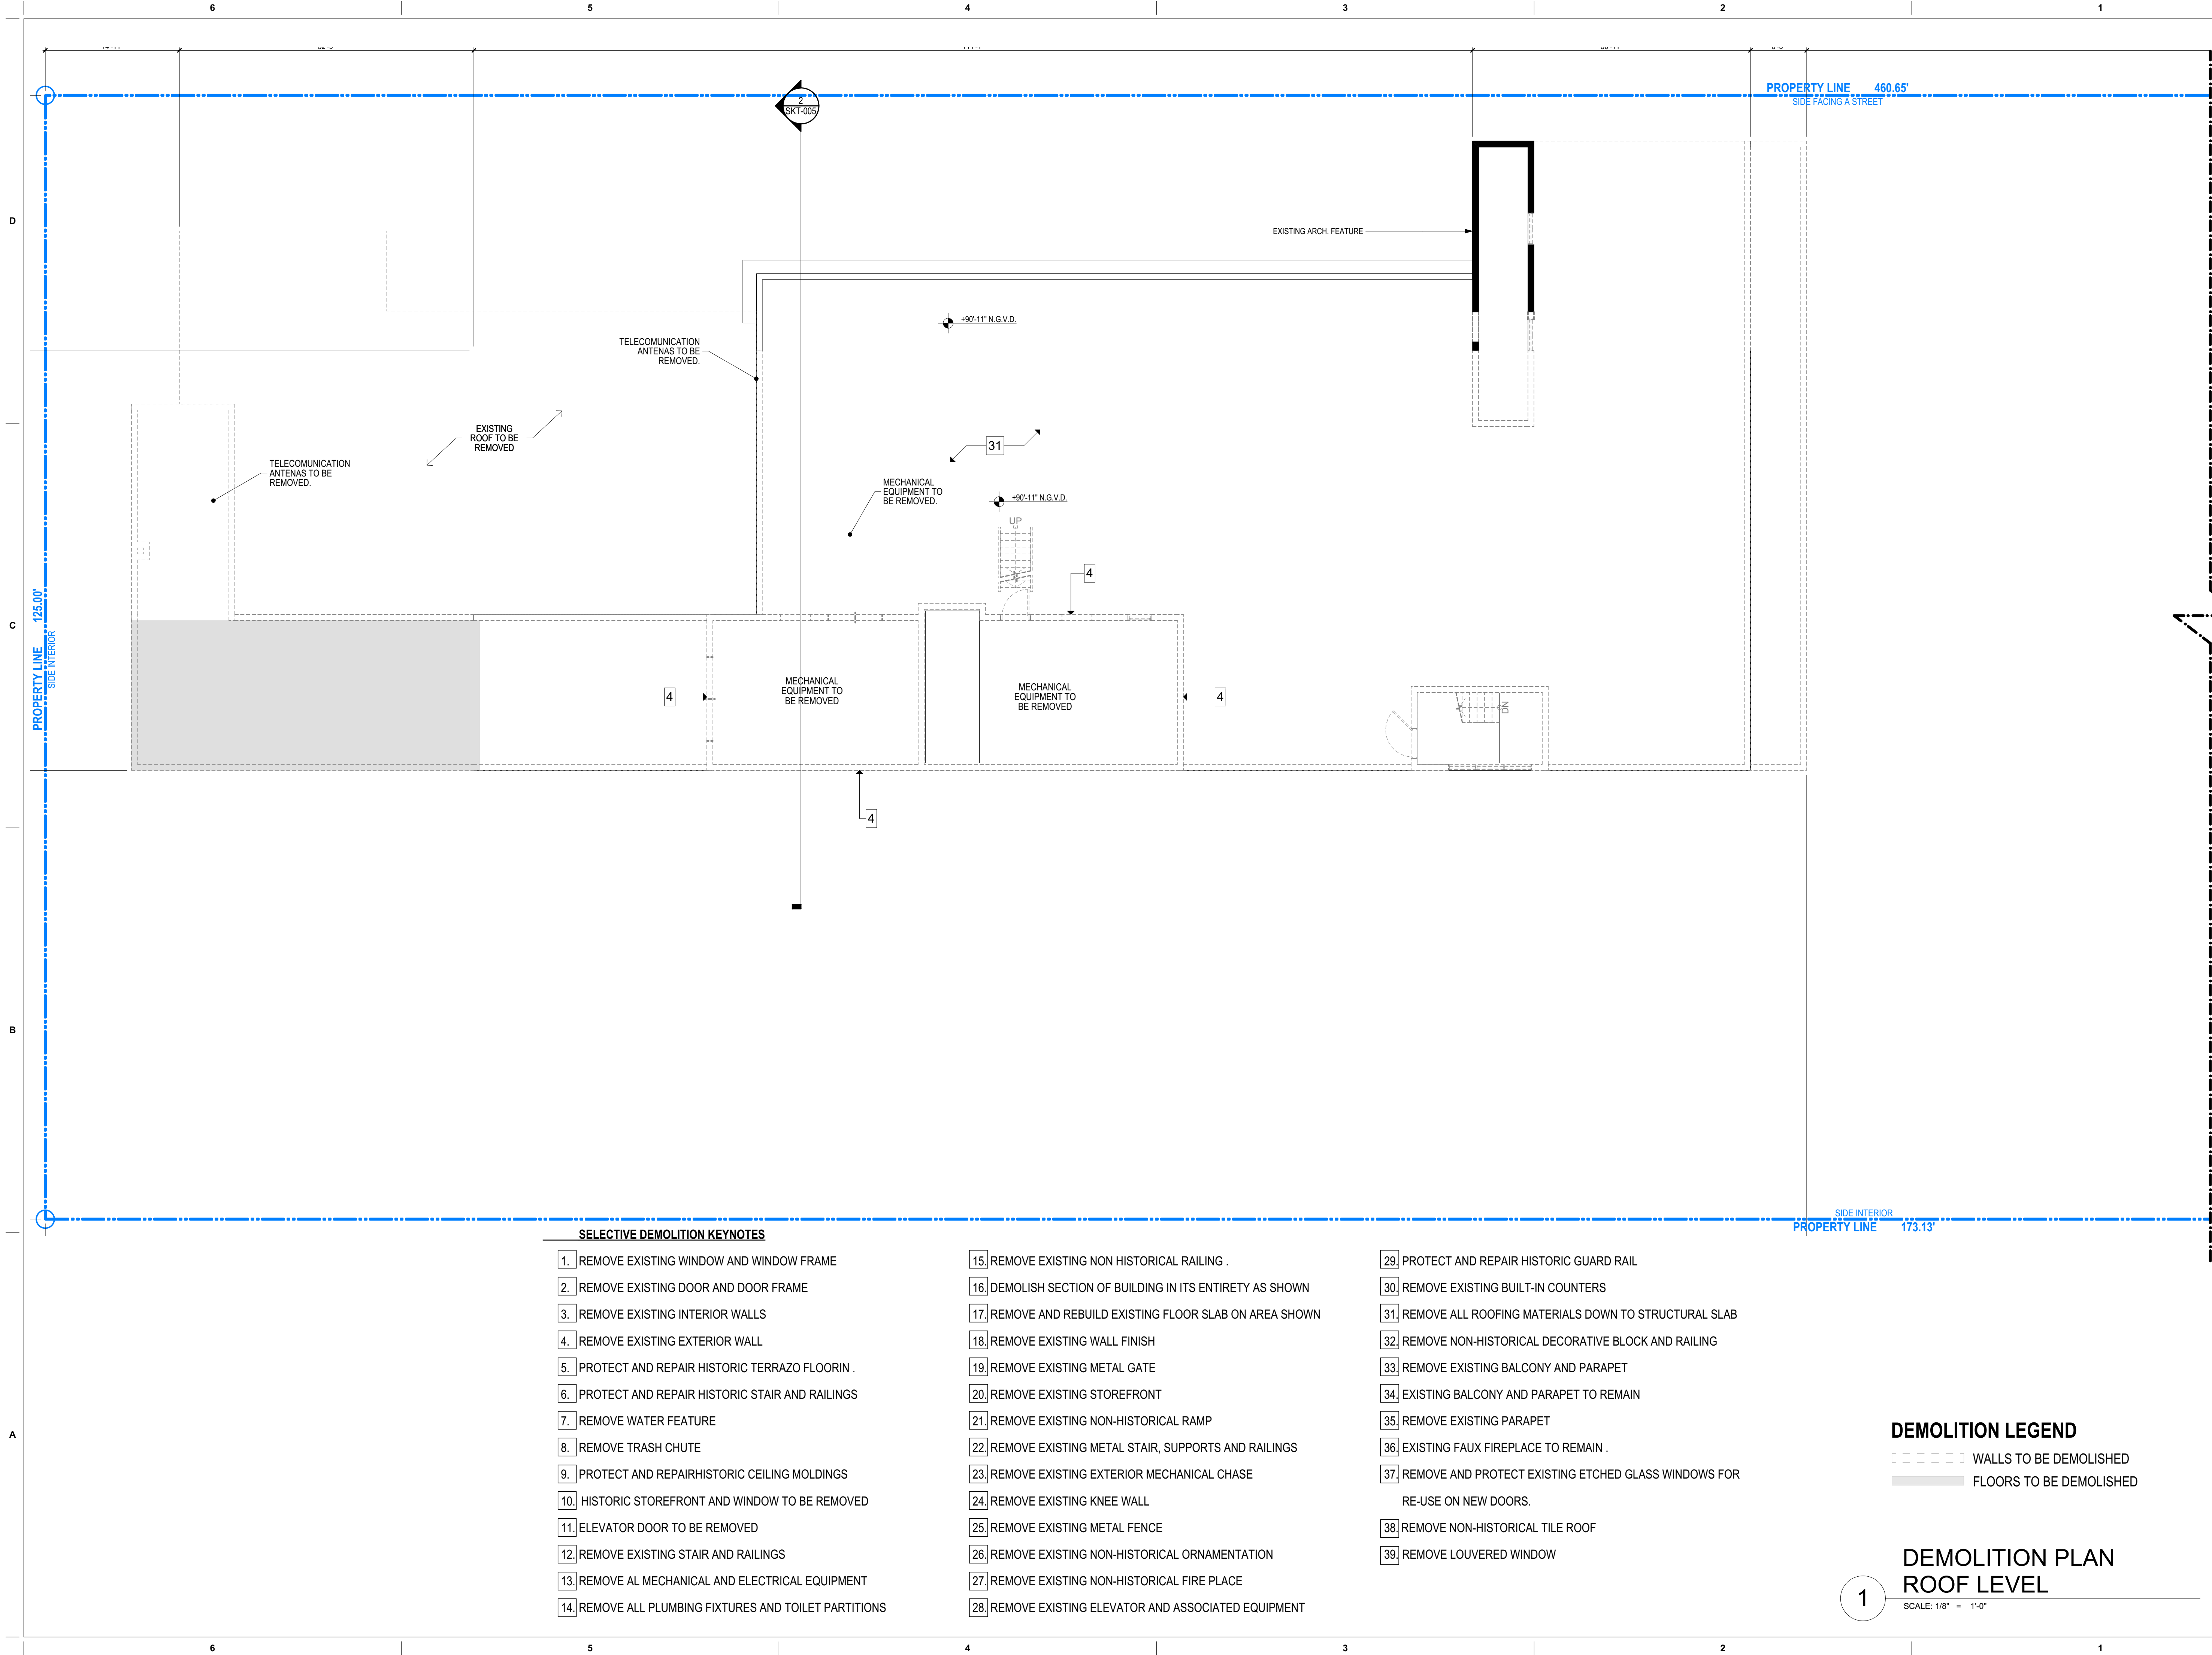

SELECTIVE DEMOLITION KEYNOTES

1. REMOVE EXISTING WINDOW AND WINDOW FRAME
2. REMOVE EXISTING DOOR AND DOOR FRAME
3. REMOVE EXISTING INTERIOR WALLS
4. REMOVE EXISTING EXTERIOR WALL
5. PROTECT AND REPAIR HISTORIC TERRAZO FLOORIN .
6. PROTECT AND REPAIR HISTORIC STAIR AND RAILINGS
7. REMOVE WATER FEATURE
8. REMOVE TRASH CHUTE
9. PROTECT AND REPAIRHISTORIC CEILING MOLDINGS
10. HISTORIC STOREFRONT AND WINDOW TO BE REMOVED
11. ELEVATOR DOOR TO BE REMOVED
12. REMOVE EXISTING STAIR AND RAILINGS
13. REMOVE AL MECHANICAL AND ELECTRICAL EQUIPMENT
14. REMOVE ALL PLUMBING FIXTURES AND TOILET PARTITIONS

15. REMOVE EXISTING NON HISTORICAL RAILING .
16. DEMOLISH SECTION OF BUILDING IN ITS ENTIRETY AS SHOWN
17. REMOVE AND REBUILD EXISTING FLOOR SLAB ON AREA SHOWN
18. REMOVE EXISTING WALL FINISH
19. REMOVE EXISTING METAL GATE
20. REMOVE EXISTING STOREFRONT
21. REMOVE EXISTING NON-HISTORICAL RAMP
22. REMOVE EXISTING METAL STAIR, SUPPORTS AND RAILINGS
23. REMOVE EXISTING EXTERIOR MECHANICAL CHASE
24. REMOVE EXISTING KNEE WALL
25. REMOVE EXISTING METAL FENCE
26. REMOVE EXISTING NON-HISTORICAL ORNAMENTATION
27. REMOVE EXISTING NON-HISTORICAL FIRE PLACE
28. REMOVE EXISTING ELEVATOR AND ASSOCIATED EQUIPMENT

29. PROTECT AND REPAIR HISTORIC GUARD RAIL
30. REMOVE EXISTING BUILT-IN COUNTERS
31. REMOVE ALL ROOFING MATERIALS DOWN TO STRUCTURAL SLAB
32. REMOVE NON-HISTORICAL DECORATIVE BLOCK AND RAILING
33. REMOVE EXISTING BALCONY AND PARAPET
34. EXISTING BALCONY AND PARAPET TO REMAIN
35. REMOVE EXISTING PARAPET
36. EXISTING FAUX FIREPLACE TO REMAIN .
37. REMOVE AND PROTECT EXISTING ETCHED GLASS WINDOWS FOR RE-USE ON NEW DOORS.
38. REMOVE NON-HISTORICAL TILE ROOF
39. REMOVE LOUVERED WINDOW

DEMOLITION LEGEND

- WALLS TO BE DEMOLISHED
- FLOORS TO BE DEMOLISHED

DEMOLITION PLAN
ROOF LEVEL

SCALE: 1/8" = 1'-0"

revuelta
architecture
international

Miami
Santiago, Chile

revuelta-architecture.com

2950 SW 27TH AVE
SUITE 110
MIAMI, FL 33135
T: 305.590.5000
F: 305.590.5040

DESIGN ARCHITECT

CITTERIO-VIEL
& PARTNERS

Project

BVLGARI HOTEL
MIAMI BEACH

100 21st STREET
MIAMI BEACH, FL 33139

Revisions

Owner Information

BHI Miami Limited Corp.

1521 Alton Rd.
Suite 403
Miami Beach, FL 33139
(786) 785-6504

Consultant

Luis O. Revuelta

AR-007972

HPB SET

Date

03/05/2021

Scale

AS SHOWN

Project No.


2005

Sheet Name

DEMOLITION PLAN - ROOF LEVEL

Sheet No.

D-010

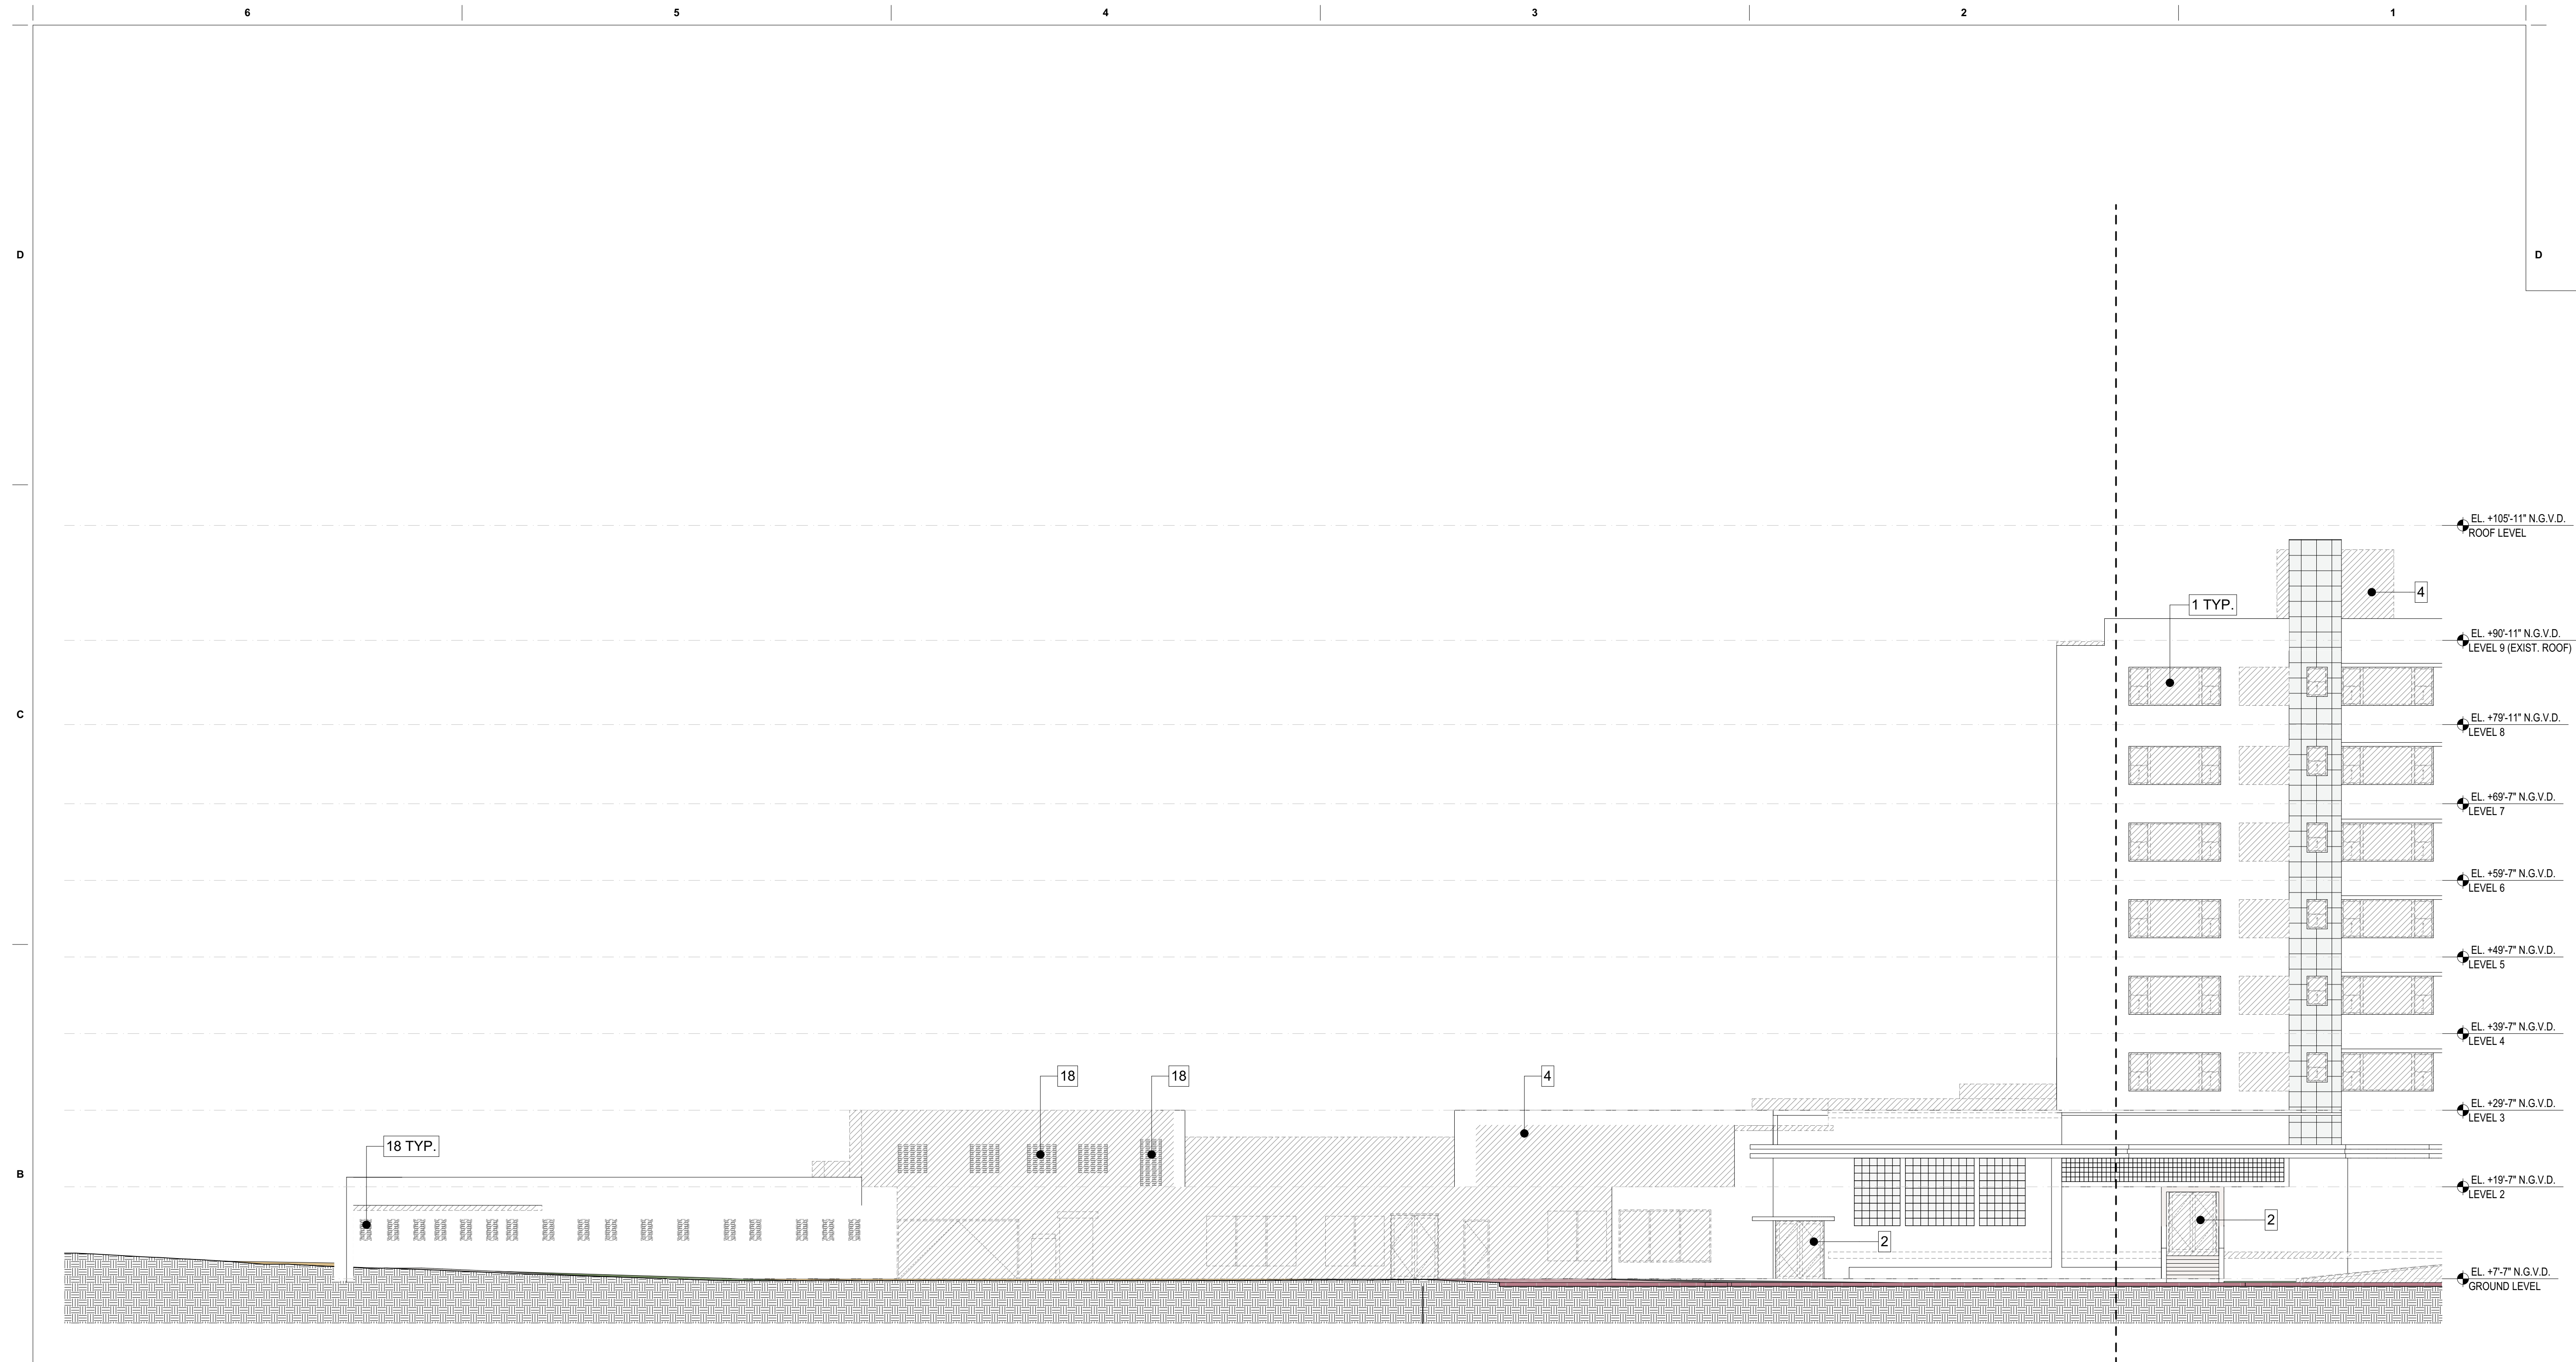

- ☒ 1. REMOVE EXISTING WINDOW AND WINDOW FRAME
- ☒ 2. REMOVE EXISTING DOOR AND DOOR FRAME
- ☒ 3. REMOVE EXISTING METAL GRILL WORK
- ☒ 4. REMOVE EXISTING EXTERIOR WALL
- ☒ 5. REMOVE EXISTING NON- HISTORICAL LIGHT FIXTURE.
- ☒ 6. REMOVE EXISTING BRICK FINISH
- ☒ 7. REMOVE ALL EXISTING EXPOSED PIPES, DOWN SPOUTS AND
☐ ELECTRICAL CONDUITS
- ☒ 8. REMOVE ALL EXPOSED DUCTS AND MECHANICAL EQUIPMENT
- ☒ 9. REMOVE EXISTING WALL FINISH
- ☒ 10. HISTORIC STOREFRONT AND WINDOW TO BE REMOVED
- ☒ 11. REMOVE EXISTING CANVAS AWNING AND ITS SUPPORT STRUCTURE.
- ☒ 12. REMOVE ALLEXPOSED EXTERIOR AIR CONDITIONING UNITS
- ☒ 13. REMOVE EXISTING NON-HISTORICAL RAILING

14. REMOVE EXISTING NON- HISTORICAL DECORATIVE BLOCK
15. REMOVE EXISTING NON HISTORICAL GLASS BLOCK
16. REMOVE NON-HISTORICAL TILE ROOF
17. REMOVE EXISTING SIGN
18. REMOVE EXISTING NON-HISTORICAL WINDOW
19. REMOVE EXISTING NON HISTORICAL RAMP
20. REMOVE EXISTING STOREFRONT
21. REMOVE EXISTING COLUMNS
22. REMOVE EXISTING SHUTTERS AND ASSOCIATED EQUIPMENT
23. REMOVE EXISTING BALCONY WALL
24. DEMOLISH BUILDING OR SECTION OF BUILDING IN ITS ENTIRETY
25. REMOVE EXISTING WOOD TERRACE AND STAIRS
26. REMOVE EXISTING NON-HISTORICAL ORNAMENTATION
27. REMOVE EXISTING NON-HISTORICAL DECORATIVE PILASTERS


- | | |
|----------|--|
| 29 | REMOVE EXISTING KNEE WALL |
| 30 | REMOVE EXISTING EXTERIOR MCHANICAL CHASE |
| 31 | REMOVE EXISTING STAIR ENCLOSURE |
| 32 | REMOVE EXISTING METAL STAIR, SUPPORTS AND RAILINGS |
| 33 | REMOVE EXISTING BALCONY AND GUARDRAIL |
| 34 | EXISTING BALCONY AND PARAPET TO REMAIN |
| 35 | REMOVE EXISTING PARAPET |
| 36 | REMOVE EXISTING EYEBROW OR SECTION OF EXISTING EYEBROW |
| AS SHOWN | |
| 37 | REMOVE EXISTING ROOF |

 TO BE DEMOLISHED

3 NORTH ELEVATION
SCALE: 3/32" = 1'-0"

NOT FOR CONSTRUCTION

These Design And Drawings Are The Copyrighted Property Of Revuelta Architecture International P.A. and May Not Be Reproduced Except with Specific Written Consent of the Architect. The Contractor Must Check And Verify All Dimensions Of The Job And Be Responsible For Same. Reporting Any Discrepancies To The Architects Before Commencing Work. Drawings Not to be Scaled. The Blueprint Shall Be the Basis for Construction. No Field Changes Allowed. By Approval: Date: 3/3/2021

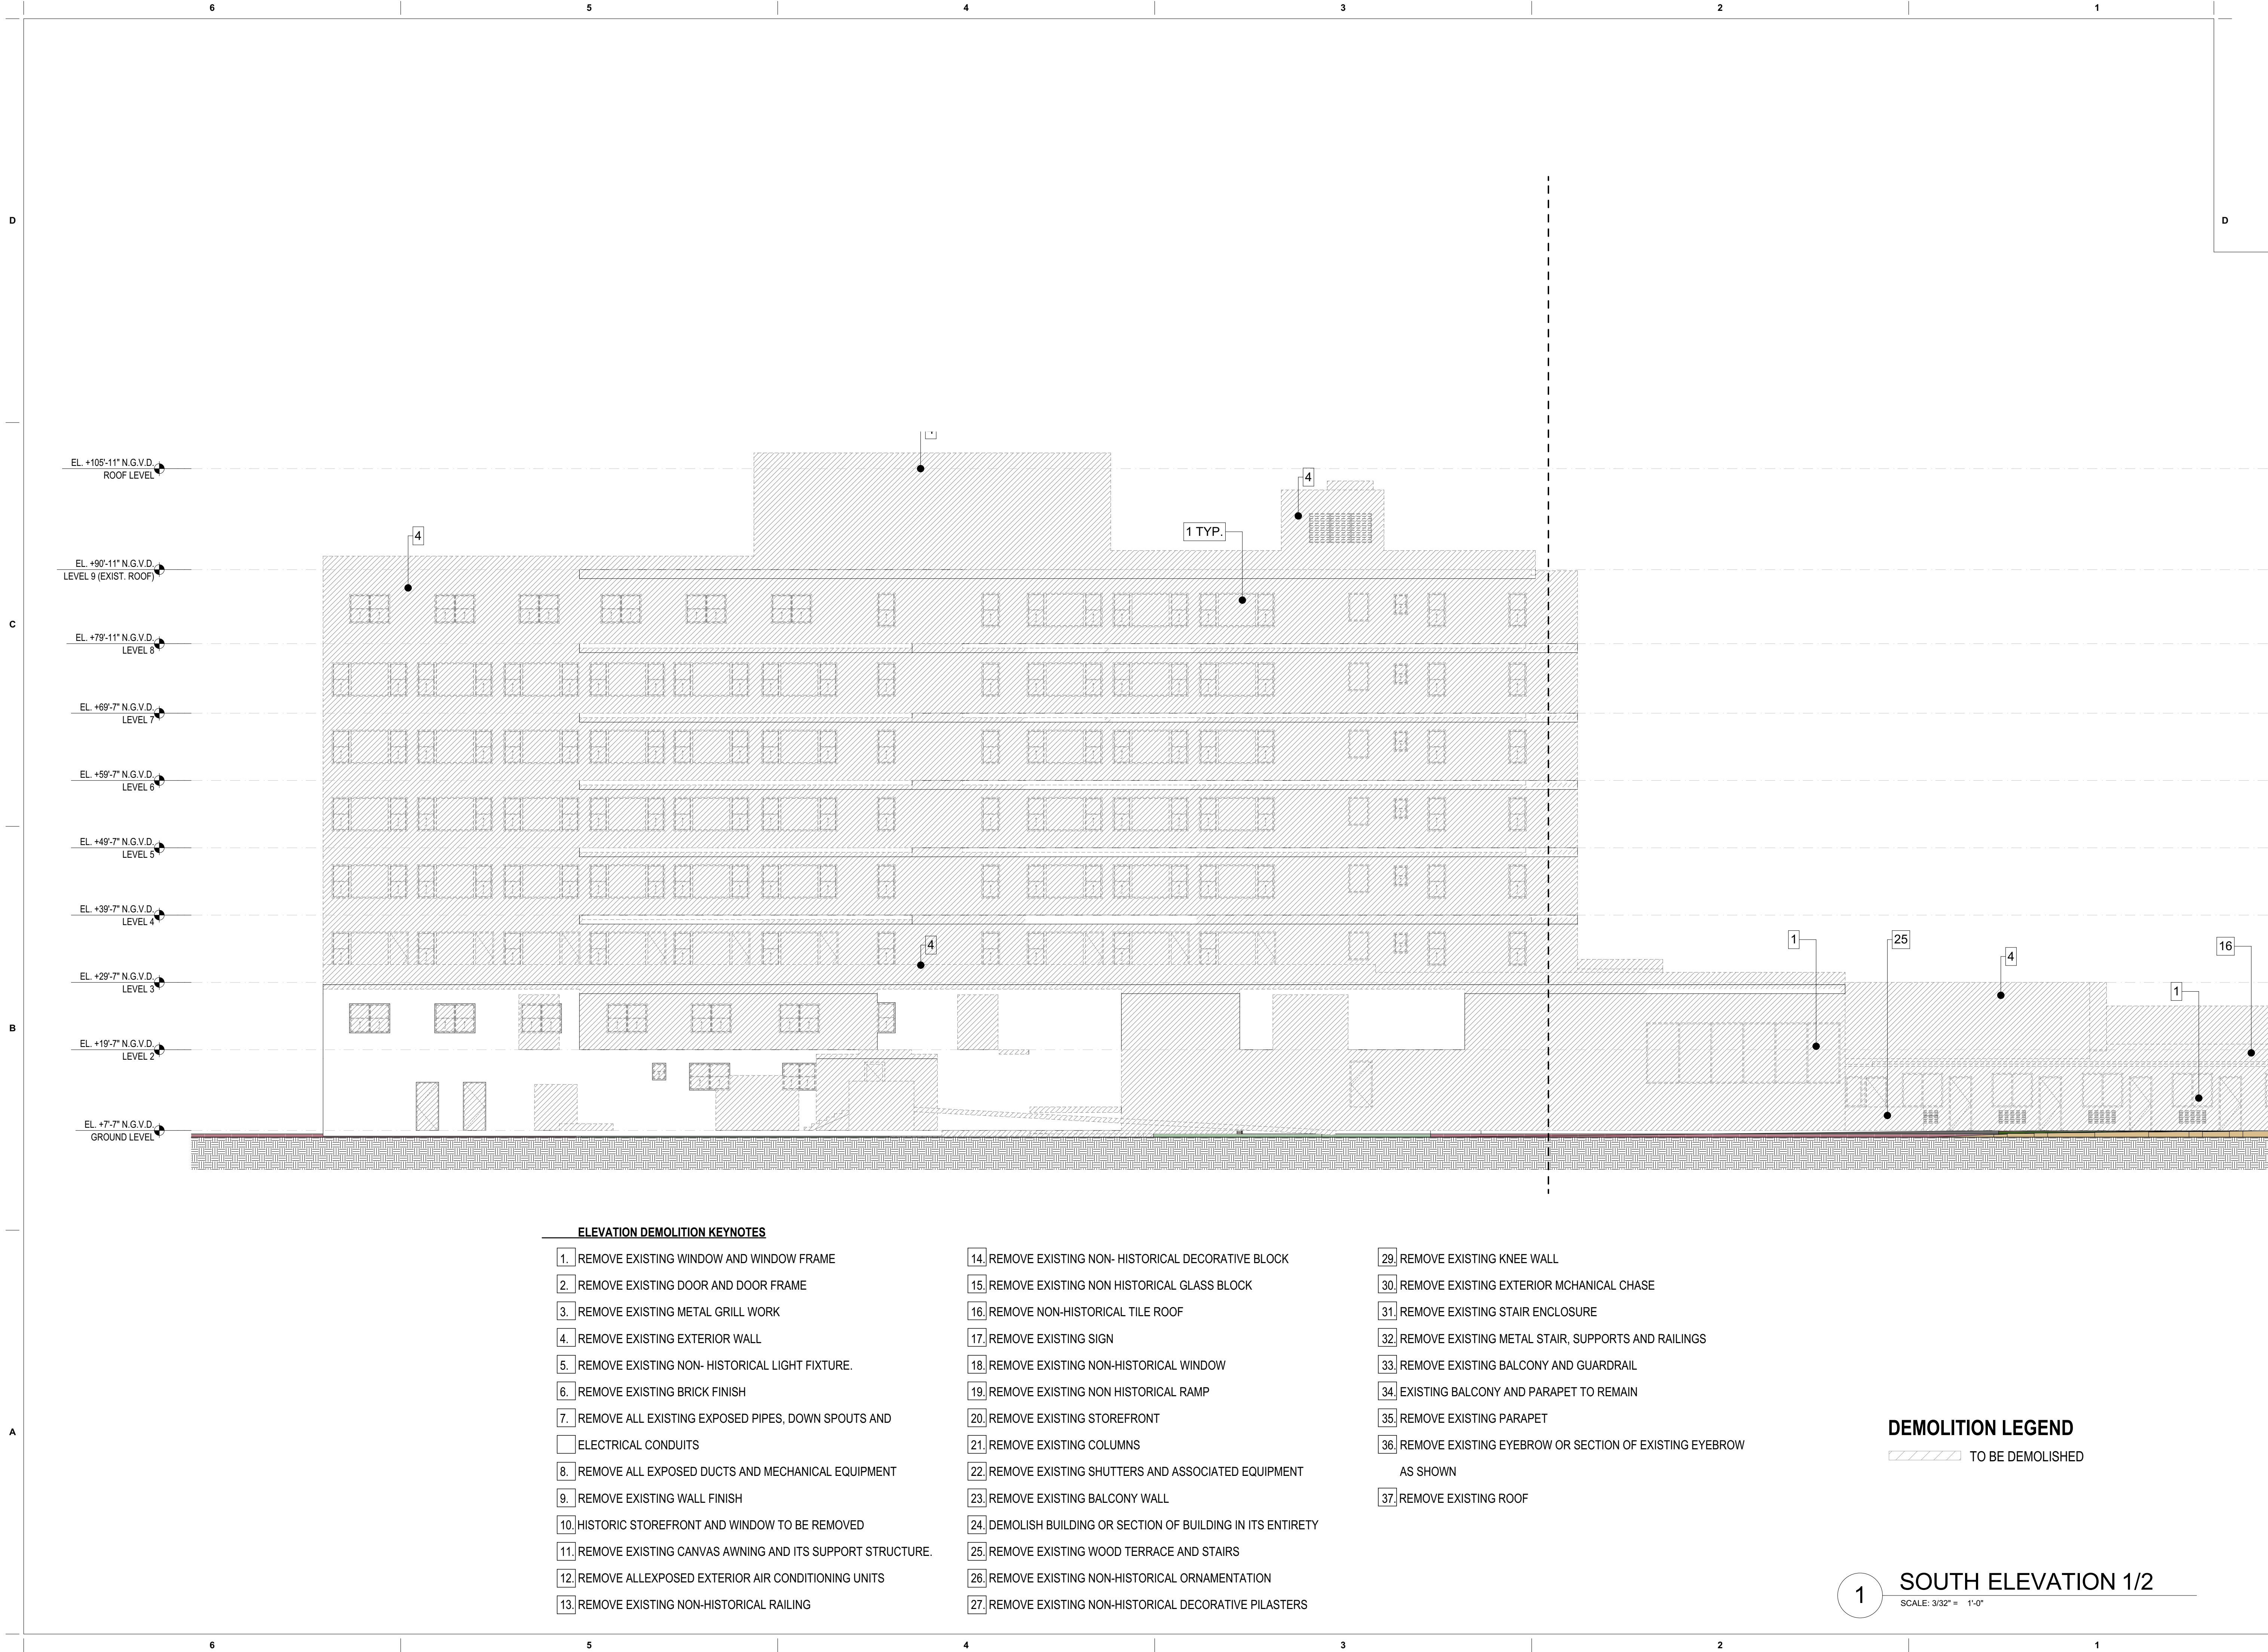

ELEVATION DEMOLITION KEYNOTES

1. REMOVE EXISTING WINDOW AND WINDOW FRAME
2. REMOVE EXISTING DOOR AND DOOR FRAME
3. REMOVE EXISTING METAL GRILL WORK
4. REMOVE EXISTING EXTERIOR WALL
5. REMOVE EXISTING NON- HISTORICAL LIGHT FIXTURE.
6. REMOVE EXISTING BRICK FINISH
7. REMOVE ALL EXISTING EXPOSED PIPES, DOWN SPOUTS AND ELECTRICAL CONDUITS
8. REMOVE ALL EXPOSED DUCTS AND MECHANICAL EQUIPMENT
9. REMOVE EXISTING WALL FINISH
10. HISTORIC STOREFRONT AND WINDOW TO BE REMOVED
11. REMOVE EXISTING CANVAS AWNING AND ITS SUPPORT STRUCTURE.
12. REMOVE ALLEXPOSED EXTERIOR AIR CONDITIONING UNITS
13. REMOVE EXISTING NON-HISTORICAL RAILING

14. REMOVE EXISTING NON- HISTORICAL DECORATIVE BLOCK
15. REMOVE EXISTING NON HISTORICAL GLASS BLOCK
16. REMOVE NON-HISTORICAL TILE ROOF
17. REMOVE EXISTING SIGN
18. REMOVE EXISTING NON-HISTORICAL WINDOW
19. REMOVE EXISTING NON HISTORICAL RAMP
20. REMOVE EXISTING STOREFRONT
21. REMOVE EXISTING COLUMNS
22. REMOVE EXISTING SHUTTERS AND ASSOCIATED EQUIPMENT
23. REMOVE EXISTING BALCONY WALL
24. DEMOLISH BUILDING OR SECTION OF BUILDING IN ITS ENTIRETY
25. REMOVE EXISTING WOOD TERRACE AND STAIRS
26. REMOVE EXISTING NON-HISTORICAL ORNAMENTATION
27. REMOVE EXISTING NON-HISTORICAL DECORATIVE PILASTERS

29. REMOVE EXISTING KNEE WALL
30. REMOVE EXISTING EXTERIOR MCHANICAL CHASE
31. REMOVE EXISTING STAIR ENCLOSURE
32. REMOVE EXISTING METAL STAIR, SUPPORTS AND RAILINGS
33. REMOVE EXISTING BALCONY AND GUARDRAIL
34. EXISTING BALCONY AND PARAPET TO REMAIN
35. REMOVE EXISTING PARAPET
36. REMOVE EXISTING EYEBROW OR SECTION OF EXISTING EYEBROW AS SHOWN
37. REMOVE EXISTING ROOF

DEMOLITION LEGEND

TO BE DEMOLISHED

1 SOUTH ELEVATION 1/2
SCALE: 3/32" = 1'-0"

revuelta
architecture
international

Miami
Santiago, Chile

revuelta-architecture.com

2950 SW 27TH AVE
SUITE 110
MIAMI, FL 33135
T: 305.590.5000
F: 305.590.5040

DESIGN ARCHITECT

CITTERIO-VIEL
& PARTNERS

Project

BVLGARI HOTEL
MIAMI BEACH

100 21st STREET
MIAMI BEACH, FL 33139

Revisions

Owner Information

BHI Miami Limited Corp.

1521 Alton Rd.
Suite 403
Miami Beach, FL 33139
(786) 785-6504

Consultant

Luis O. Revuelta

AR-0007972

HPB SET

Date

03/05/2021

Scale

AS SHOWN

Project No.

2005

Sheet Name

DEMOLITION PLAN - SOUTH

ELEVATION 1/2


Sheet No.

D-013

NOT FOR CONSTRUCTION

These Design And Drawings Are The Copyrighted Property Of Revuelta Architecture International P.A. and May Not Be Reproduced, Excerpted, or Modified Without The Written Consent of the Architect. The Contractor Must Check And Verify All Dimensions Of The Job And Be Responsible For Same. Reporting Any Discrepancies To The Architects Before Commencing Work. Drawings Not to be Scaled.

The Building: 100 21st Street, 11th Floor, Miami, FL 33139. Original: 11/16/2020. PLOM: By: 01/04/2021. Date: 3/5/2021

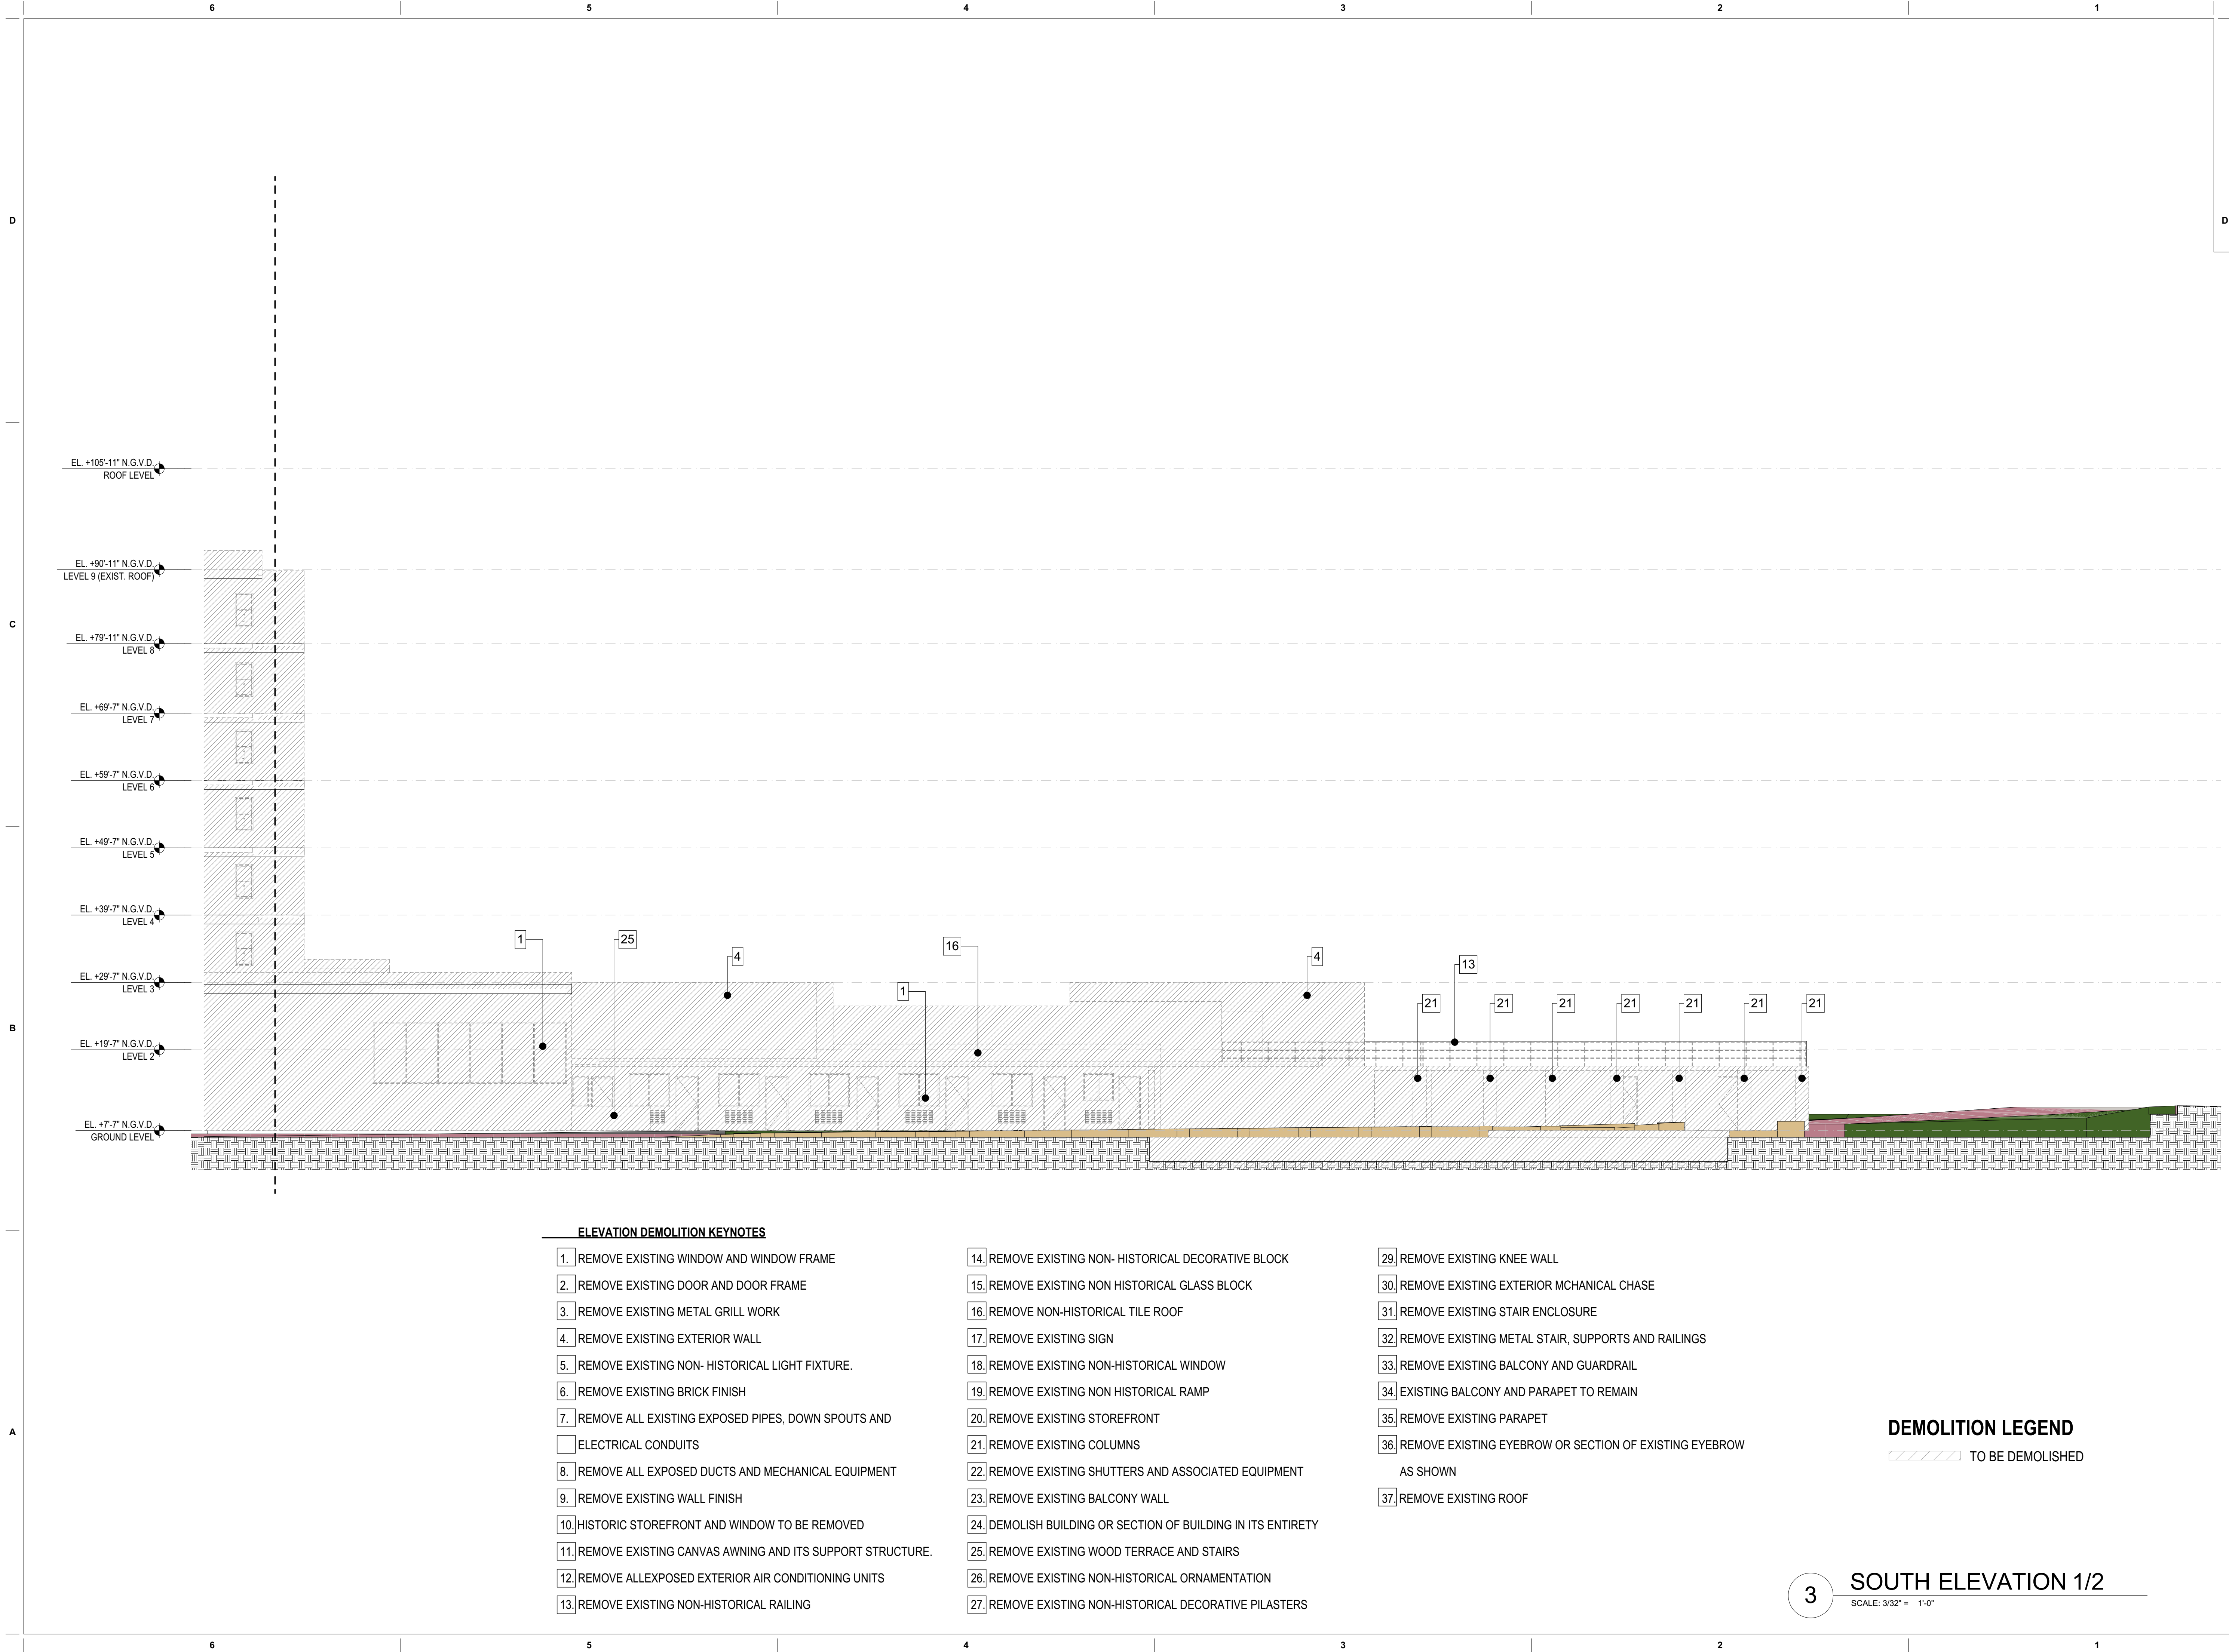

ELEVATION DEMOLITION KEYNOTES

- | | |
|---|--|
| 1. REMOVE EXISTING WINDOW AND WINDOW FRAME | 14. REMOVE EXISTING NON- HISTORICAL DECORATIVE BLOCK |
| 2. REMOVE EXISTING DOOR AND DOOR FRAME | 15. REMOVE EXISTING NON HISTORICAL GLASS BLOCK |
| 3. REMOVE EXISTING METAL GRILL WORK | 16. REMOVE NON-HISTORICAL TILE ROOF |
| 4. REMOVE EXISTING EXTERIOR WALL | 17. REMOVE EXISTING SIGN |
| 5. REMOVE EXISTING NON- HISTORICAL LIGHT FIXTURE. | 18. REMOVE EXISTING NON-HISTORICAL WINDOW |
| 6. REMOVE EXISTING BRICK FINISH | 19. REMOVE EXISTING NON HISTORICAL RAMP |
| 7. REMOVE ALL EXISTING EXPOSED PIPES, DOWN SPOUTS AND ELECTRICAL CONDUITS | 20. REMOVE EXISTING STOREFRONT |
| 8. REMOVE ALL EXPOSED DUCTS AND MECHANICAL EQUIPMENT | 21. REMOVE EXISTING COLUMNS |
| 9. REMOVE EXISTING WALL FINISH | 22. REMOVE EXISTING SHUTTERS AND ASSOCIATED EQUIPMENT |
| 10. HISTORIC STOREFRONT AND WINDOW TO BE REMOVED | 23. REMOVE EXISTING BALCONY WALL |
| 11. REMOVE EXISTING CANVAS AWNING AND ITS SUPPORT STRUCTURE. | 24. DEMOLISH BUILDING OR SECTION OF BUILDING IN ITS ENTIRETY |
| 12. REMOVE ALLEXPOSED EXTERIOR AIR CONDITIONING UNITS | 25. REMOVE EXISTING WOOD TERRACE AND STAIRS |
| 13. REMOVE EXISTING NON-HISTORICAL RAILING | 26. REMOVE EXISTING NON-HISTORICAL ORNAMENTATION |
| | 27. REMOVE EXISTING NON-HISTORICAL DECORATIVE PILASTERS |

- | |
|---|
| 29. REMOVE EXISTING KNEE WALL |
| 30. REMOVE EXISTING EXTERIOR MCHANICAL CHASE |
| 31. REMOVE EXISTING STAIR ENCLOSURE |
| 32. REMOVE EXISTING METAL STAIR, SUPPORTS AND RAILINGS |
| 33. REMOVE EXISTING BALCONY AND GUARDRAIL |
| 34. EXISTING BALCONY AND PARAPET TO REMAIN |
| 35. REMOVE EXISTING PARAPET |
| 36. REMOVE EXISTING EYEBROW OR SECTION OF EXISTING EYEBROW AS SHOWN |
| 37. REMOVE EXISTING ROOF |

DEMOLITION LEGEND

TO BE DEMOLISHED

3

SOUTH ELEVATION 1/2

SCALE: 3/32" = 1'-0"

revuelta
architecture
international

Miami
Santiago, Chile

revuelta-architecture.com

2950 SW 27TH AVE
SUITE 110
MIAMI, FL 33135
T: 305.590.5000
F: 305.590.5040

DESIGN ARCHITECT

CITTERIO-VIEL
& PARTNERS

Project

BVLGARI HOTEL
MIAMI BEACH

100 21st STREET
MIAMI BEACH, FL 33139

Revisions

Owner Information

BHI Miami Limited Corp.

1521 Alton Rd.
Suite 403
Miami Beach, FL 33139
(786) 785-6504

Consultant

Luis O. Revuelta

AR-0007972

SCHEMATIC DESIGN

Date

3/5/2021

Scale

AS SHOWN

Project No.



2005

Sheet Name
DEMOLITION PLAN - SOUTH
ELEVATION 2/2

Sheet No.

D-014

NOT FOR CONSTRUCTION

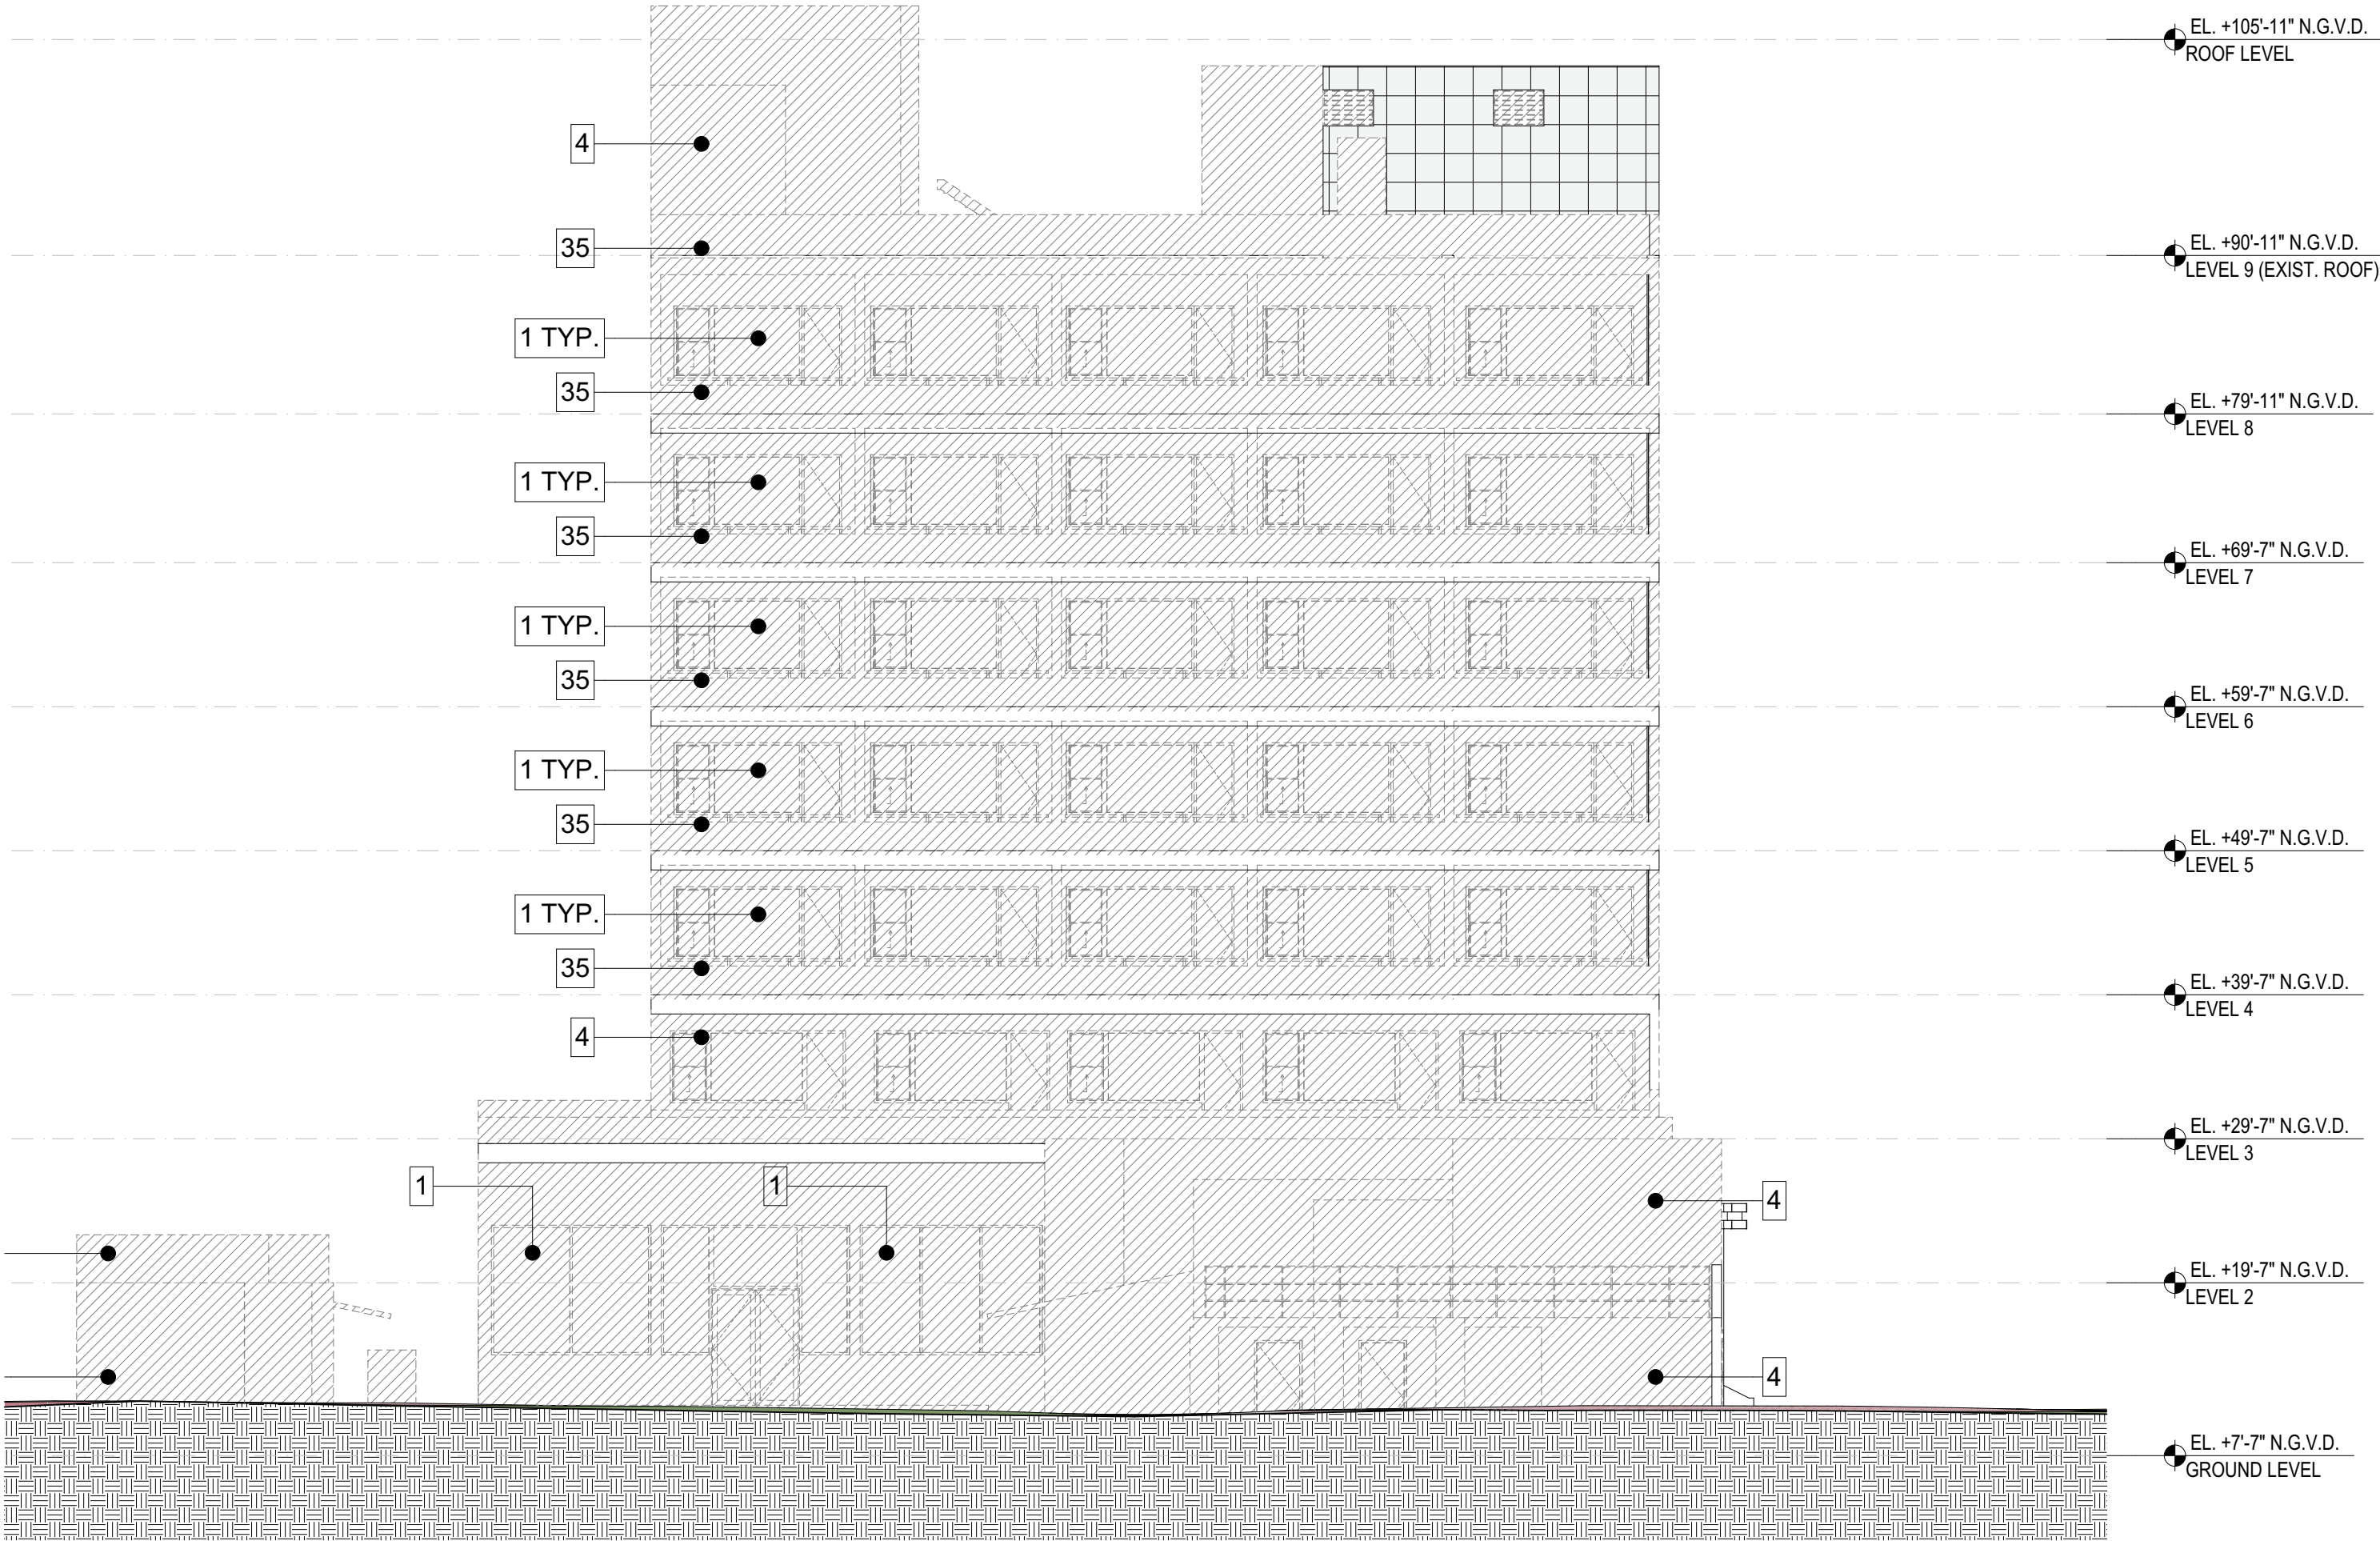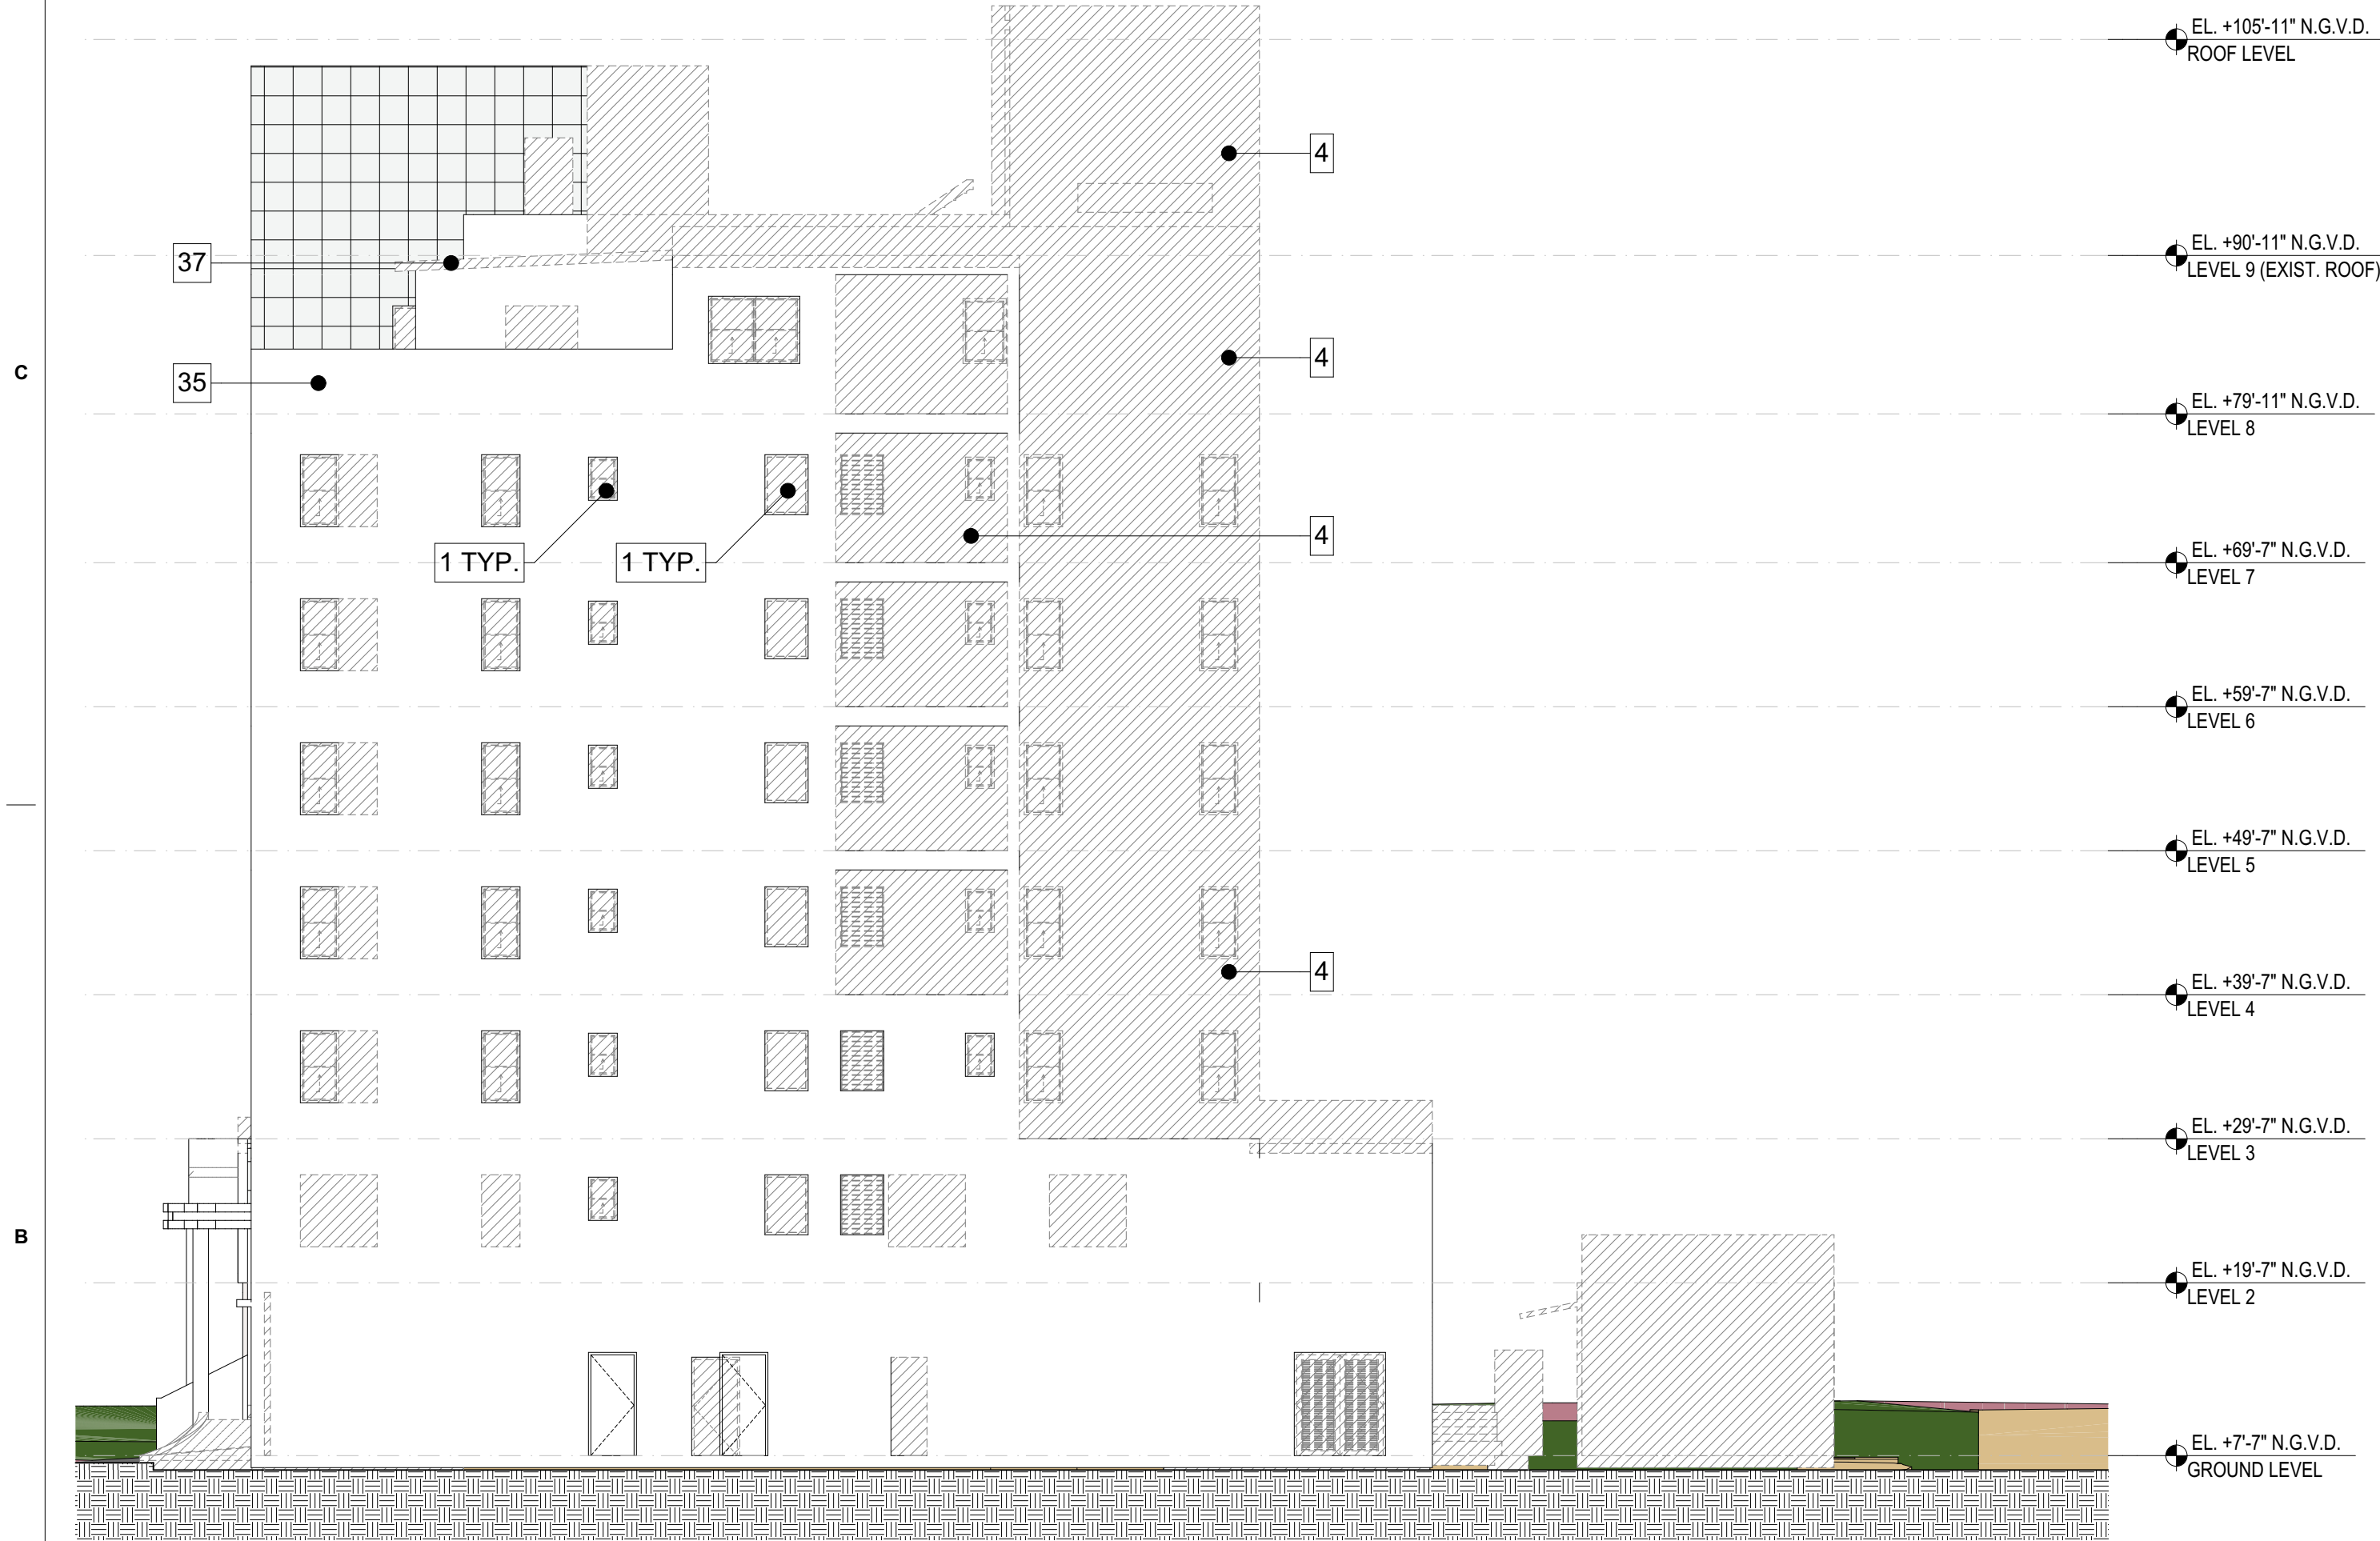

WEST ELEVATION

EAST ELEVATION

ELEVATION DEMOLITION KEYNOTES

- | | |
|---|--|
| 1. REMOVE EXISTING WINDOW AND WINDOW FRAME | 14. REMOVE EXISTING NON- HISTORICAL DECORATIVE BLOCK |
| 2. REMOVE EXISTING DOOR AND DOOR FRAME | 15. REMOVE EXISTING NON HISTORICAL GLASS BLOCK |
| 3. REMOVE EXISTING METAL GRILL WORK | 16. REMOVE NON-HISTORICAL TILE ROOF |
| 4. REMOVE EXISTING EXTERIOR WALL | 17. REMOVE EXISTING SIGN |
| 5. REMOVE EXISTING NON- HISTORICAL LIGHT FIXTURE. | 18. REMOVE EXISTING NON-HISTORICAL WINDOW |
| 6. REMOVE EXISTING BRICK FINISH | 19. REMOVE EXISTING NON HISTORICAL RAMP |
| 7. REMOVE ALL EXISTING EXPOSED PIPES, DOWN SPOUTS AND ELECTRICAL CONDUITS | 20. REMOVE EXISTING STOREFRONT |
| 8. REMOVE ALL EXPOSED DUCTS AND MECHANICAL EQUIPMENT | 21. REMOVE EXISTING COLUMNS |
| 9. REMOVE EXISTING WALL FINISH | 22. REMOVE EXISTING SHUTTERS AND ASSOCIATED EQUIPMENT |
| 10. HISTORIC STOREFRONT AND WINDOW TO BE REMOVED | 23. REMOVE EXISTING BALCONY WALL |
| 11. REMOVE EXISTING CANVAS AWNING AND ITS SUPPORT STRUCTURE. | 24. DEMOLISH BUILDING OR SECTION OF BUILDING IN ITS ENTIRETY |
| 12. REMOVE ALLEXPOSED EXTERIOR AIR CONDITIONING UNITS | 25. REMOVE EXISTING WOOD TERRACE AND STAIRS |
| 13. REMOVE EXISTING NON-HISTORICAL RAILING | 26. REMOVE EXISTING NON-HISTORICAL ORNAMENTATION |
| | 27. REMOVE EXISTING NON-HISTORICAL DECORATIVE PILASTERS |

- | |
|---|
| 29. REMOVE EXISTING KNEE WALL |
| 30. REMOVE EXISTING EXTERIOR MCHANICAL CHASE |
| 31. REMOVE EXISTING STAIR ENCLOSURE |
| 32. REMOVE EXISTING METAL STAIR, SUPPORTS AND RAILINGS |
| 33. REMOVE EXISTING BALCONY AND GUARDRAIL |
| 34. EXISTING BALCONY AND PARAPET TO REMAIN |
| 35. REMOVE EXISTING PARAPET |
| 36. REMOVE EXISTING EYEBROW OR SECTION OF EXISTING EYEBROW AS SHOWN |
| 37. REMOVE EXISTING ROOF |

DEMOLITION LEGEND

TO BE DEMOLISHED

revuelta
architecture
international

Miami
Santiago, Chile

revuelta-architecture.com

2950 SW 27TH AVE
SUITE 110
MIAMI, FL 33135
T: 305.590.5000
F: 305.590.5040

DESIGN ARCHITECT

CITTERIO-VIEL
& PARTNERS

Project

BVLGARI HOTEL
MIAMI BEACH

100 21st STREET
MIAMI BEACH, FL 33139

Revisions

Owner Information

BHI Miami Limited Corp.

1521 Alton Rd.
Suite 403
Miami Beach, FL 33139
(786) 785-6504

Consultant

Luis O. Revuelta

AR-0007972

HPB SET

Date

03/05/2021

Scale

AS SHOWN

Project No.


2005


Sheet Name

DEMOLITION PLAN - EAST & WEST
ELEVATIONS

Sheet No.

D-015

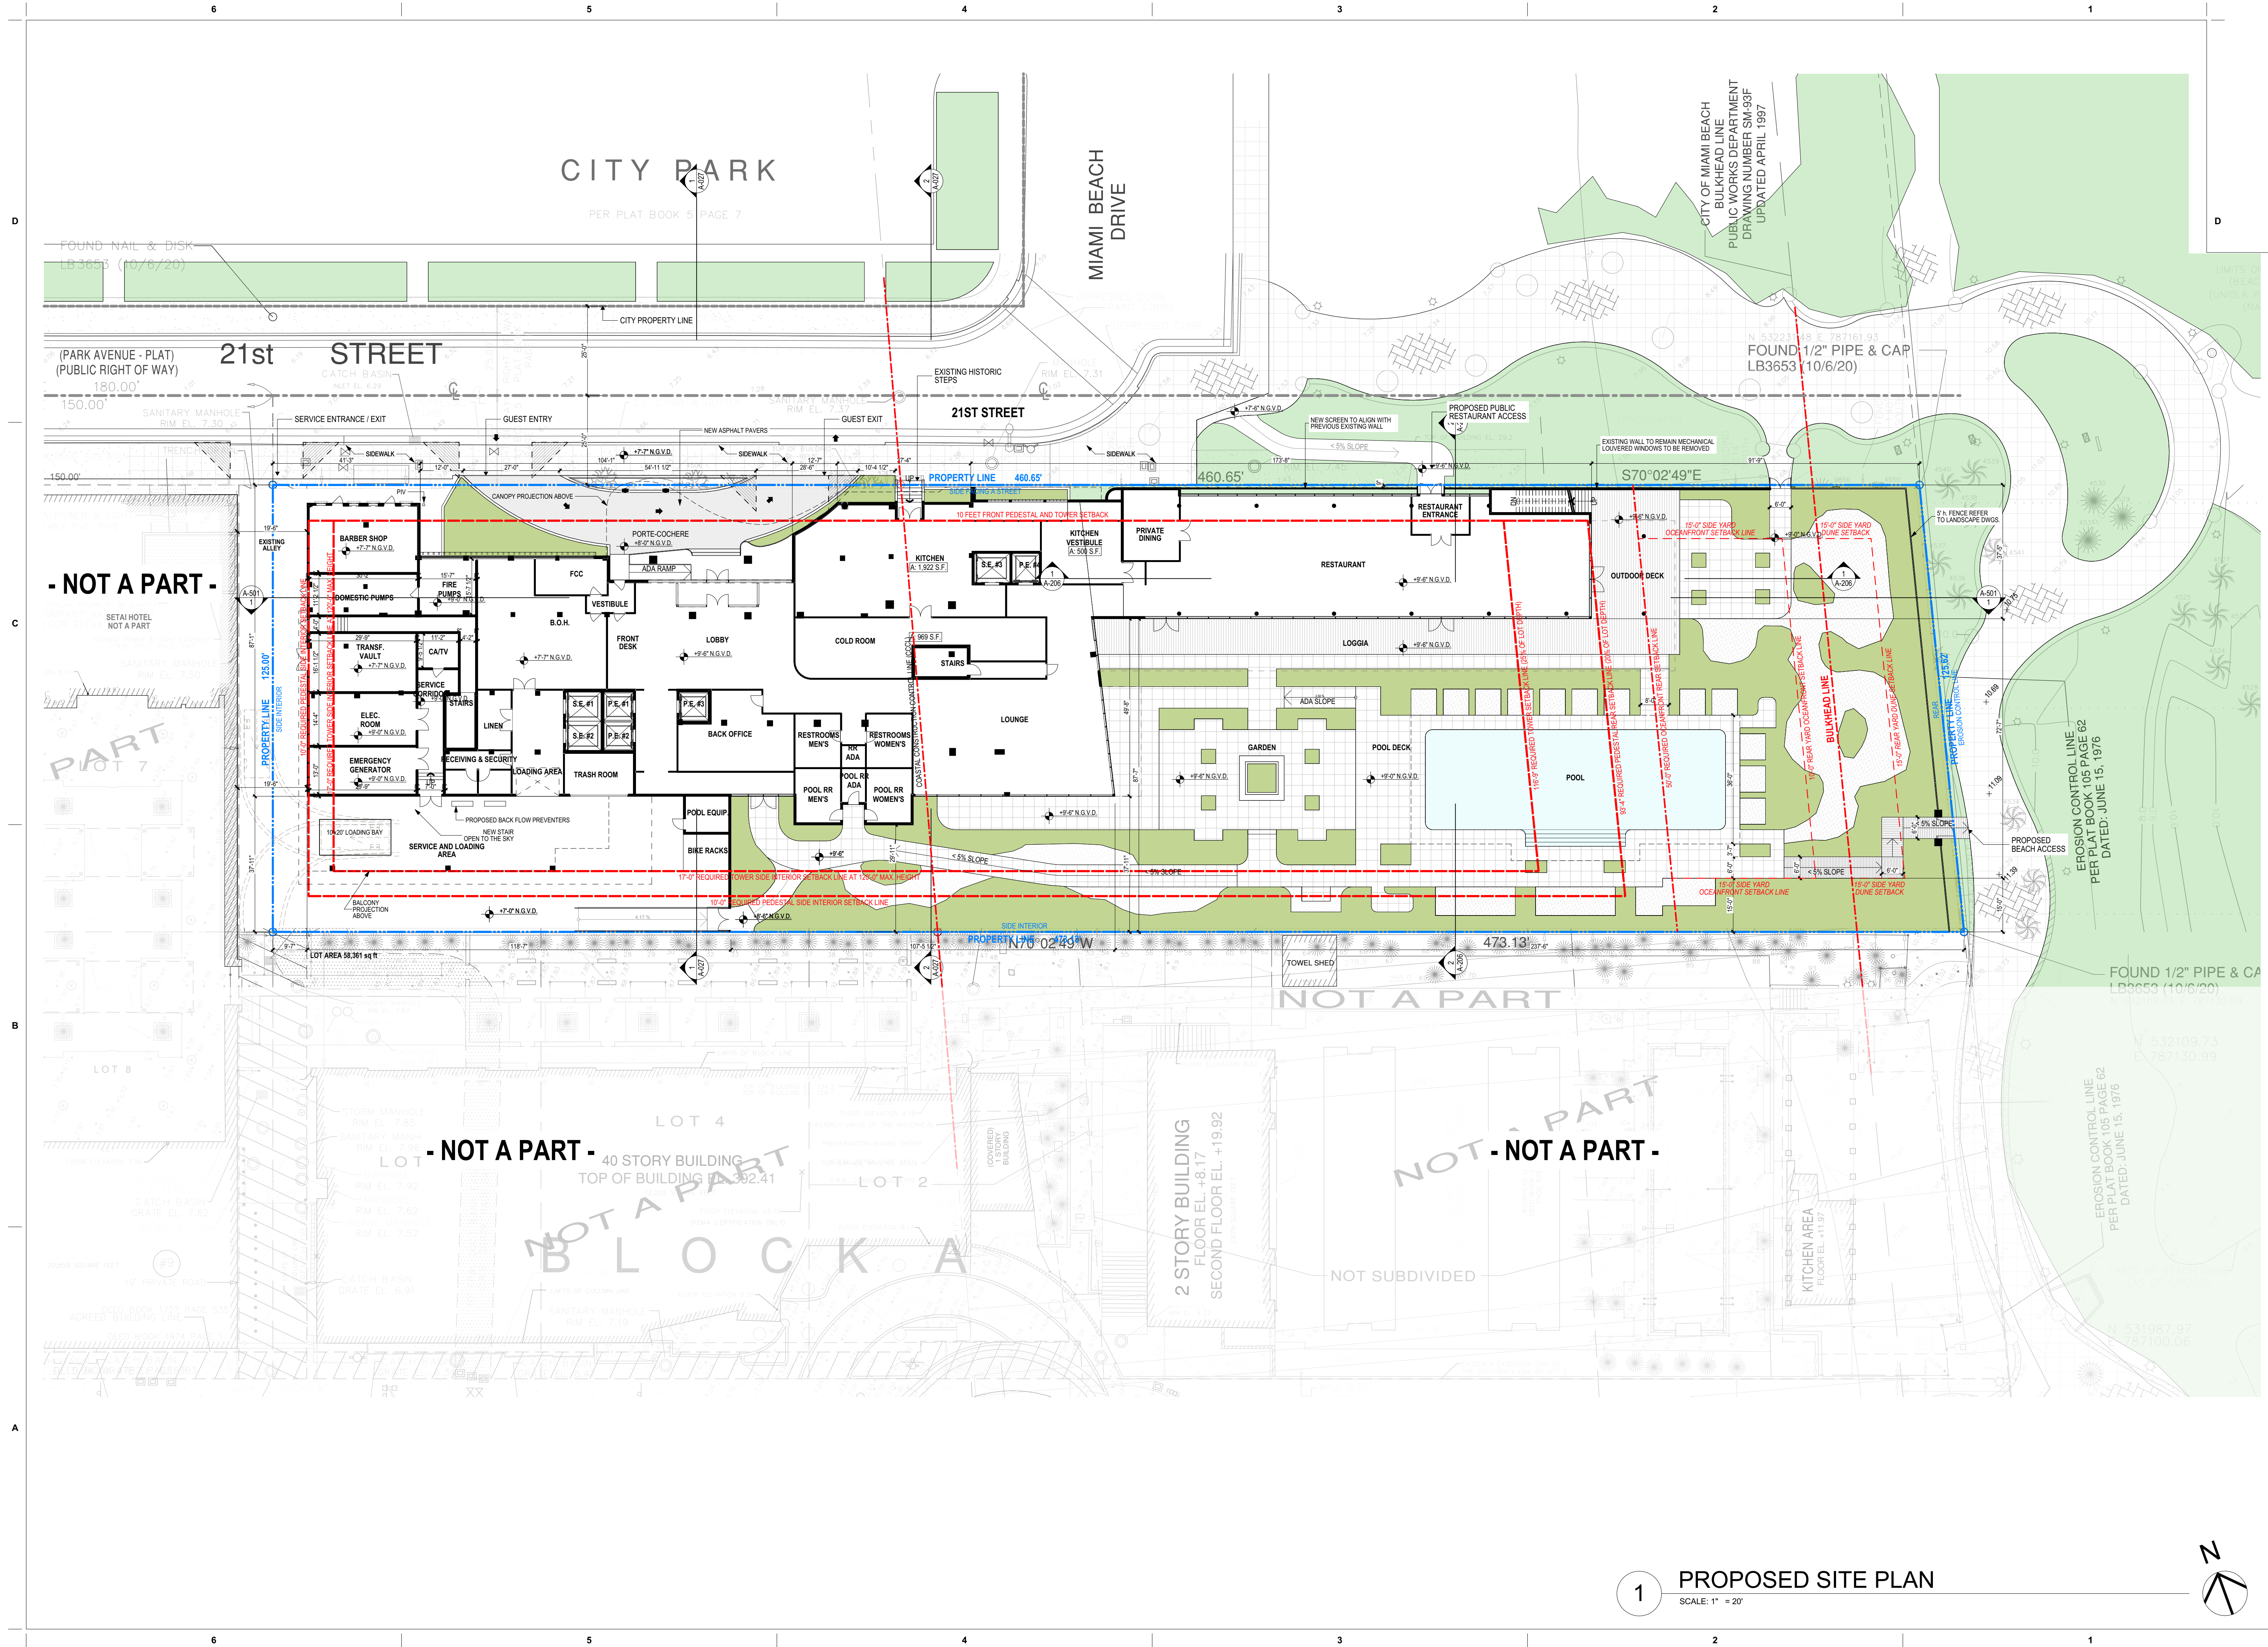

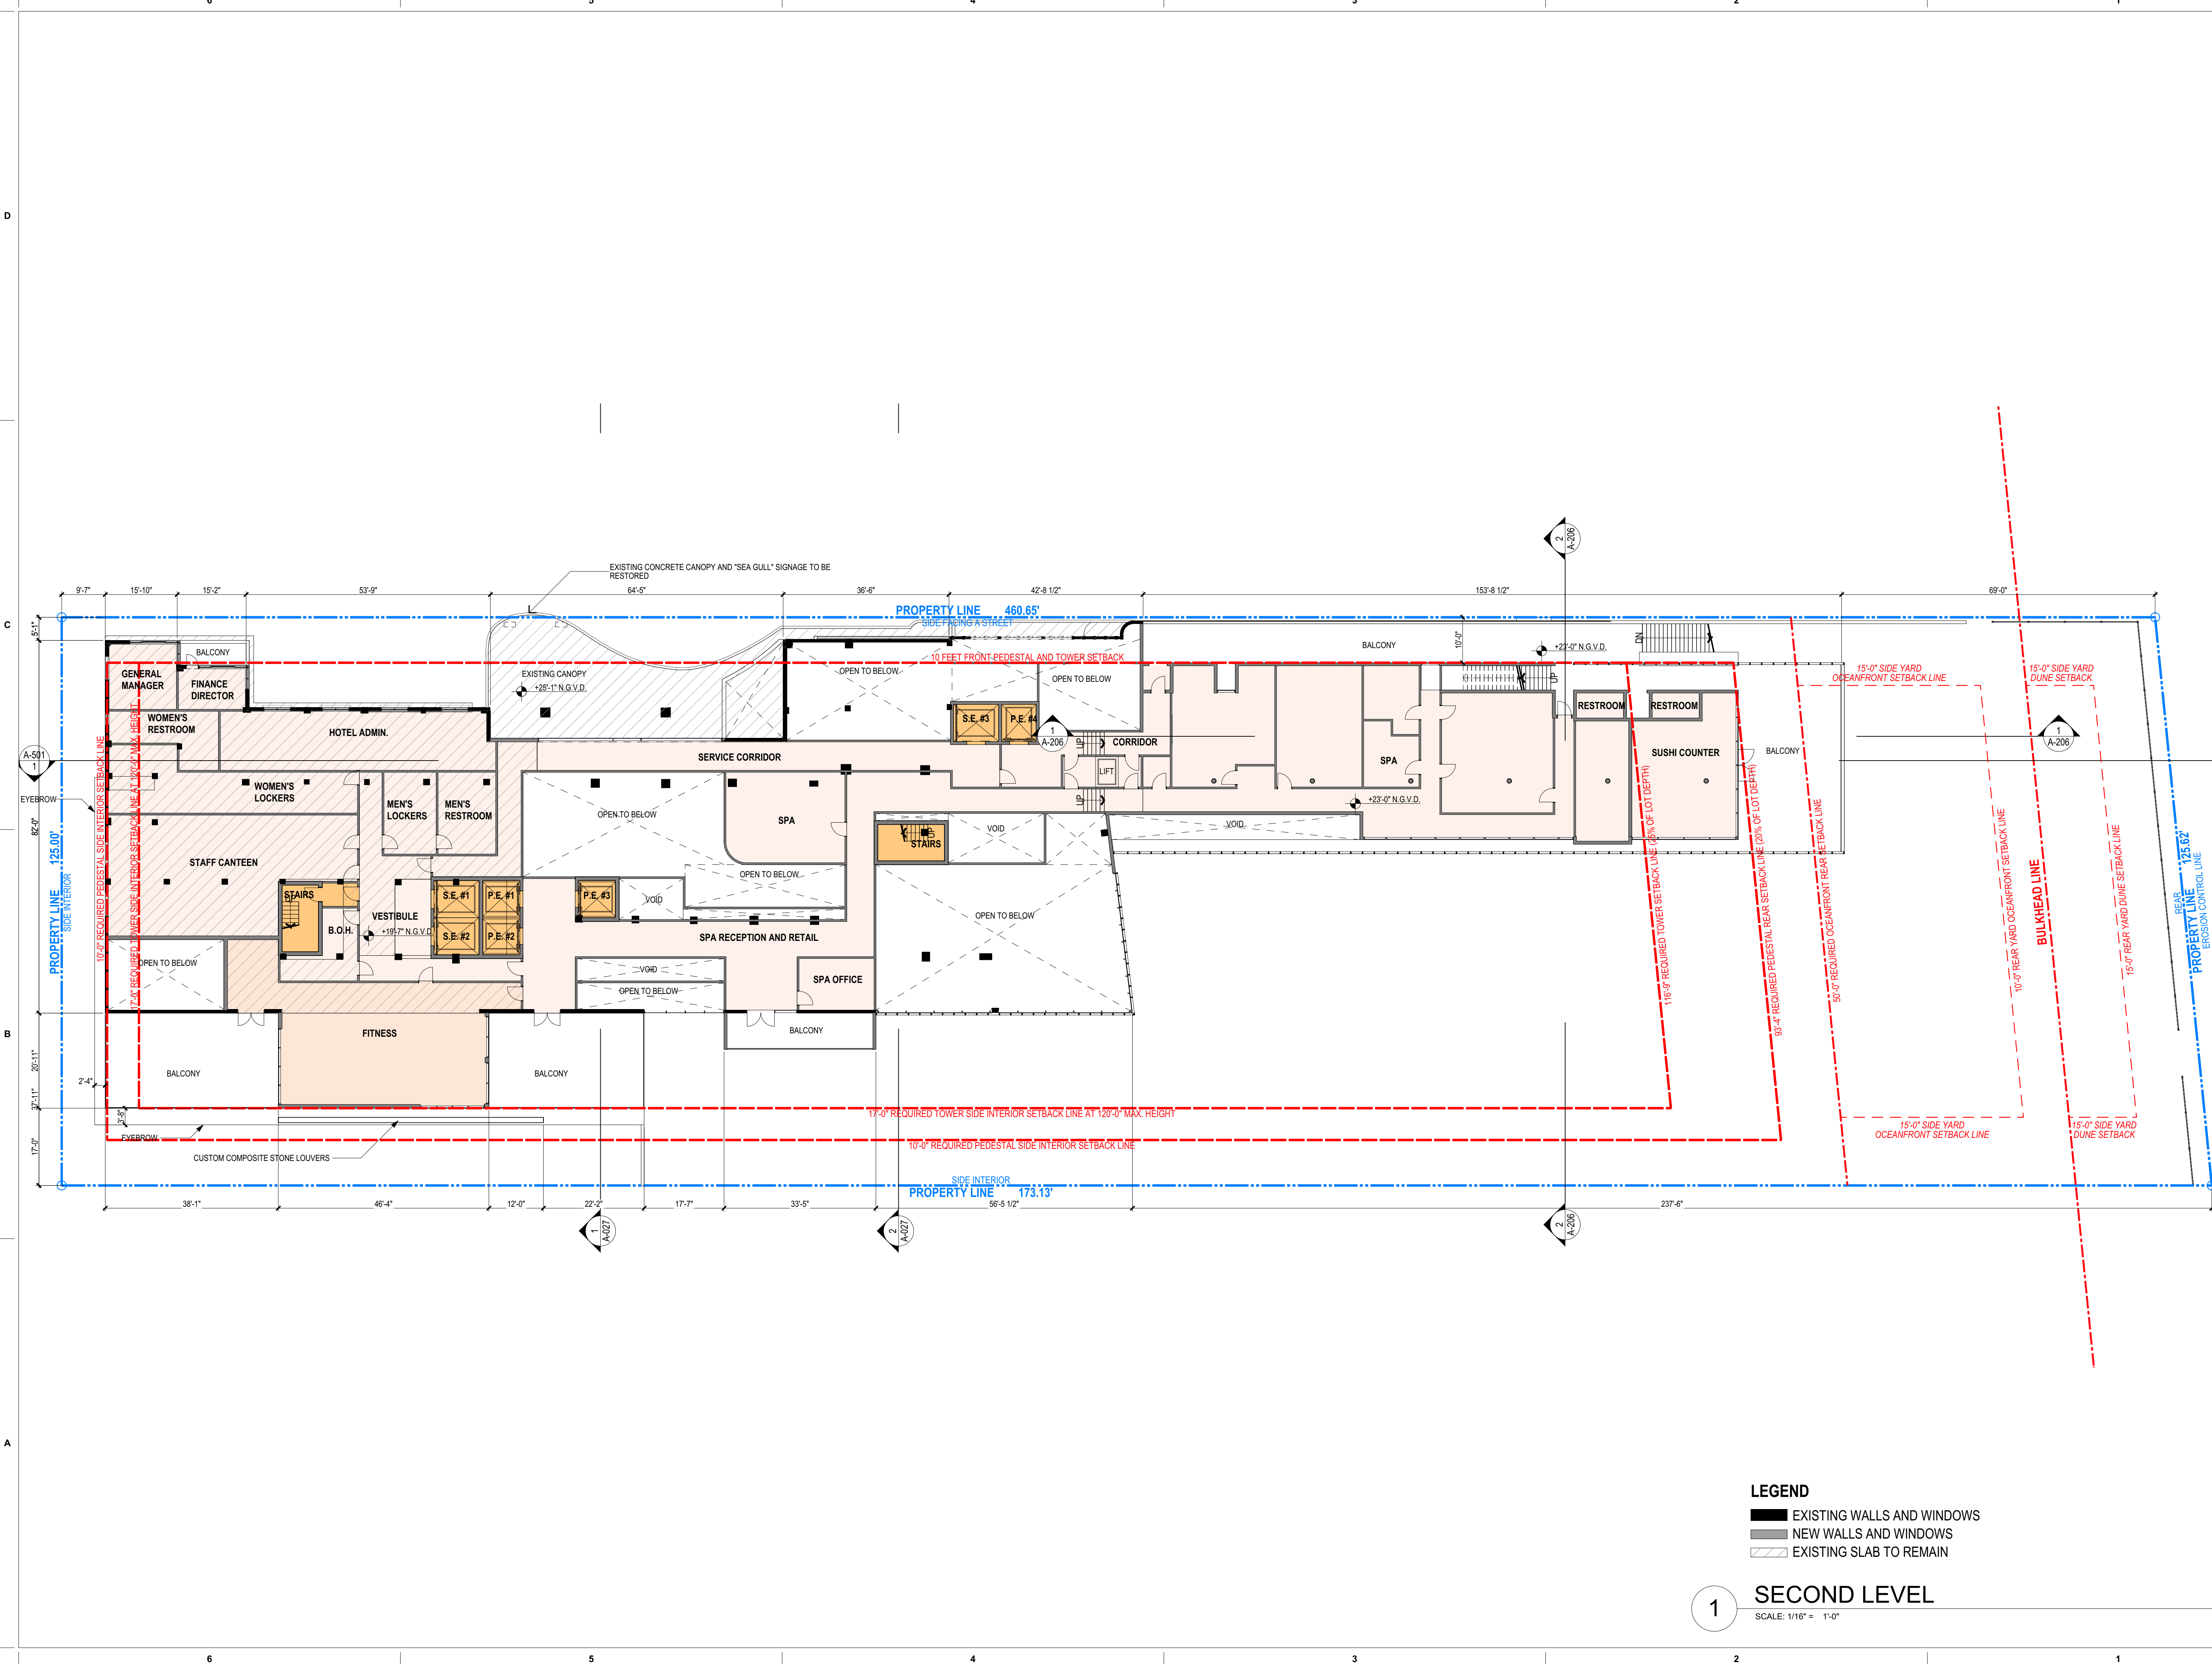

- LEGEND**
- EXISTING WALLS AND WINDOWS
 - NEW WALLS AND WINDOWS
 - EXISTING SLAB TO REMAIN

1 SECOND LEVEL

SCALE: 1/16" = 1'-0"

revuelta
architecture
international

Miami
Santiago, Chile

revuelta-architecture.com

2950 SW 27TH AVE
SUITE 110
MIAMI, FL 33135
T: 305.590.5000
F: 305.590.5040

DESIGN ARCHITECT

CITTERIO-VIEL
& PARTNERS

Project

**BVLGARI HOTEL
MIAMI BEACH**

100 21st STREET
MIAMI BEACH, FL 33139

Revisions

Owner Information

BHI Miami Limited Corp.

1521 Alton Rd.
Suite 403
Miami Beach, FL 33139
(786) 785-6504

Consultant

Luis O. Revuelta

AR-0007972

HPB SET

Date

03/05/2021

Scale

AS SHOWN

Project No.


2005

Sheet Name

PROPOSED LEVEL 2

Sheet No.

A-102

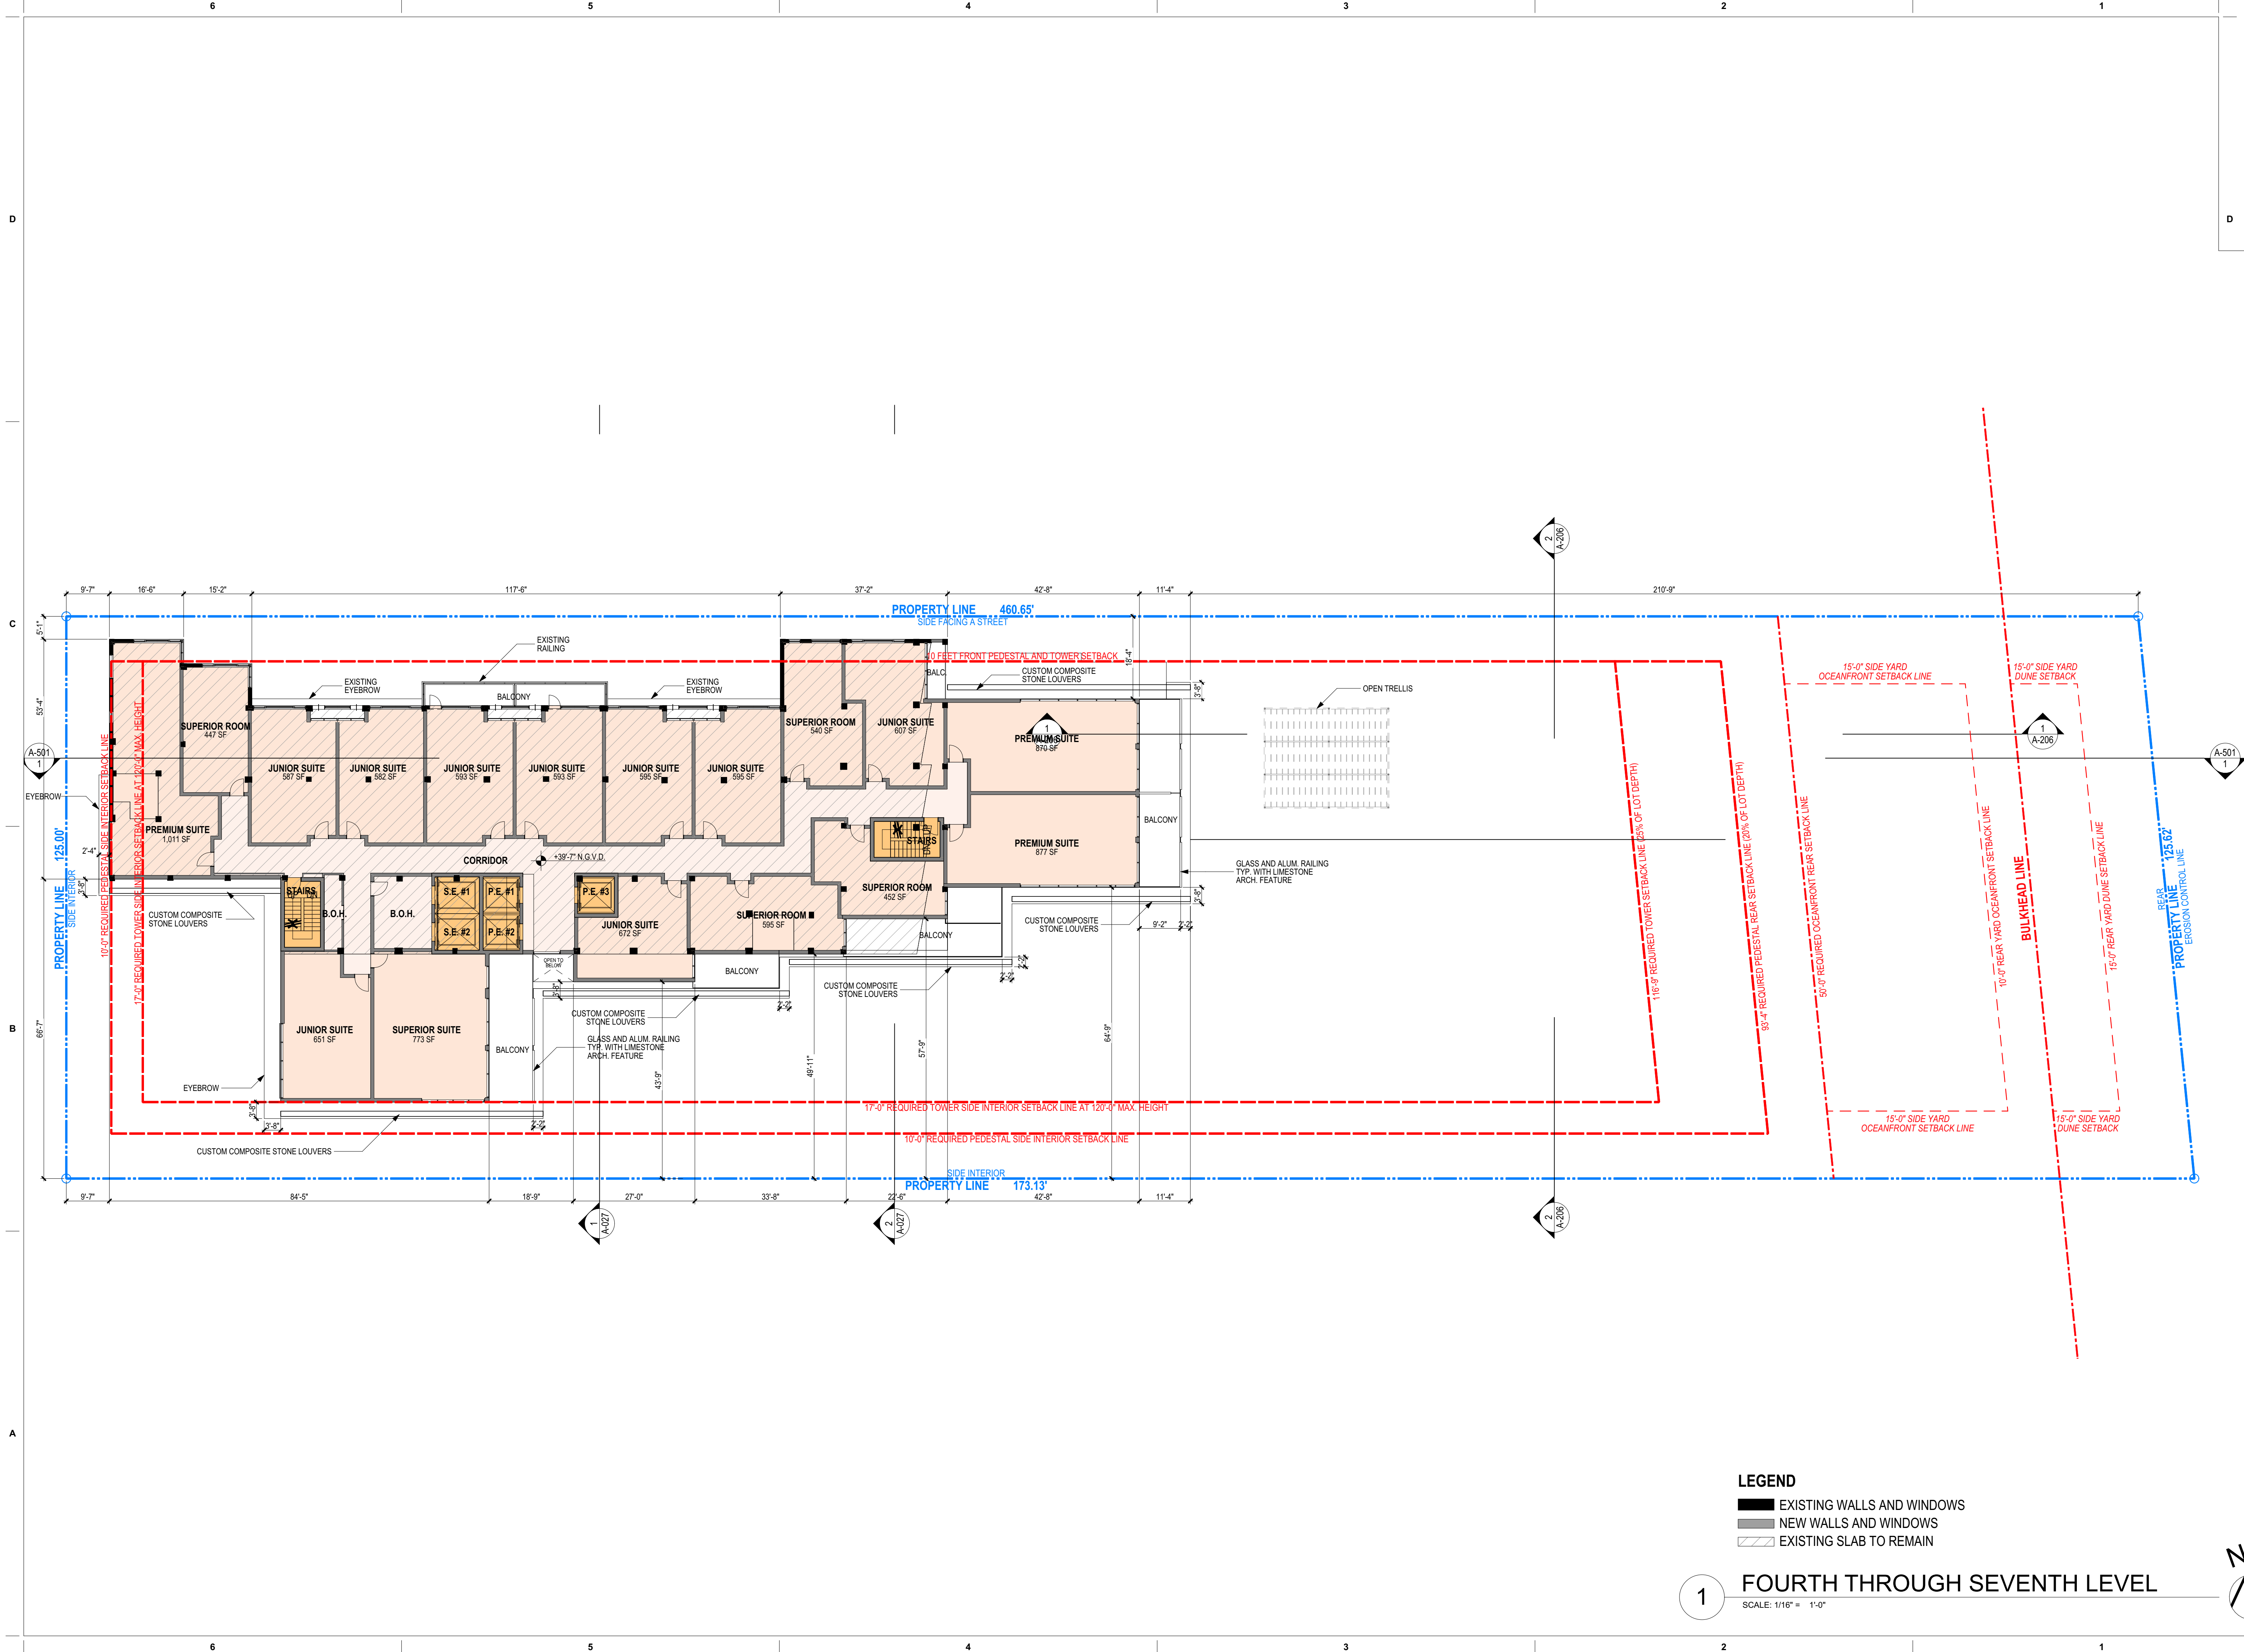

LEGEND

- EXISTING WALLS AND WINDOWS
- NEW WALLS AND WINDOWS
- EXISTING SLAB TO REMAIN

1 FOURTH THROUGH SEVENTH LEVEL
SCALE: 1/16" = 1'-0"

revuelta
architecture
international

Miami
Santiago, Chile

revuelta-architecture.com

2950 SW 27TH AVE
SUITE 1100
MIAMI, FL 33135
T: 305.590.5000
F: 305.590.5040

DESIGN ARCHITECT

CITTERIO-VIEL
& PARTNERS

Project

BVLGARI HOTEL
MIAMI BEACH

100 21st STREET
MIAMI BEACH, FL 33139

Revisions

Owner Information

BHI Miami Limited Corp.

1521 Alton Rd.
Suite 403
Miami Beach, FL 33139
(786) 785-6504

Consultant

Luis O. Revuelta

AR-007972

HPB SET

Date

03/05/2021

Scale

AS SHOWN

Project No.


2005

Sheet Name

PROPOSED LEVELS 4 THRU 7

Sheet No.

A-104

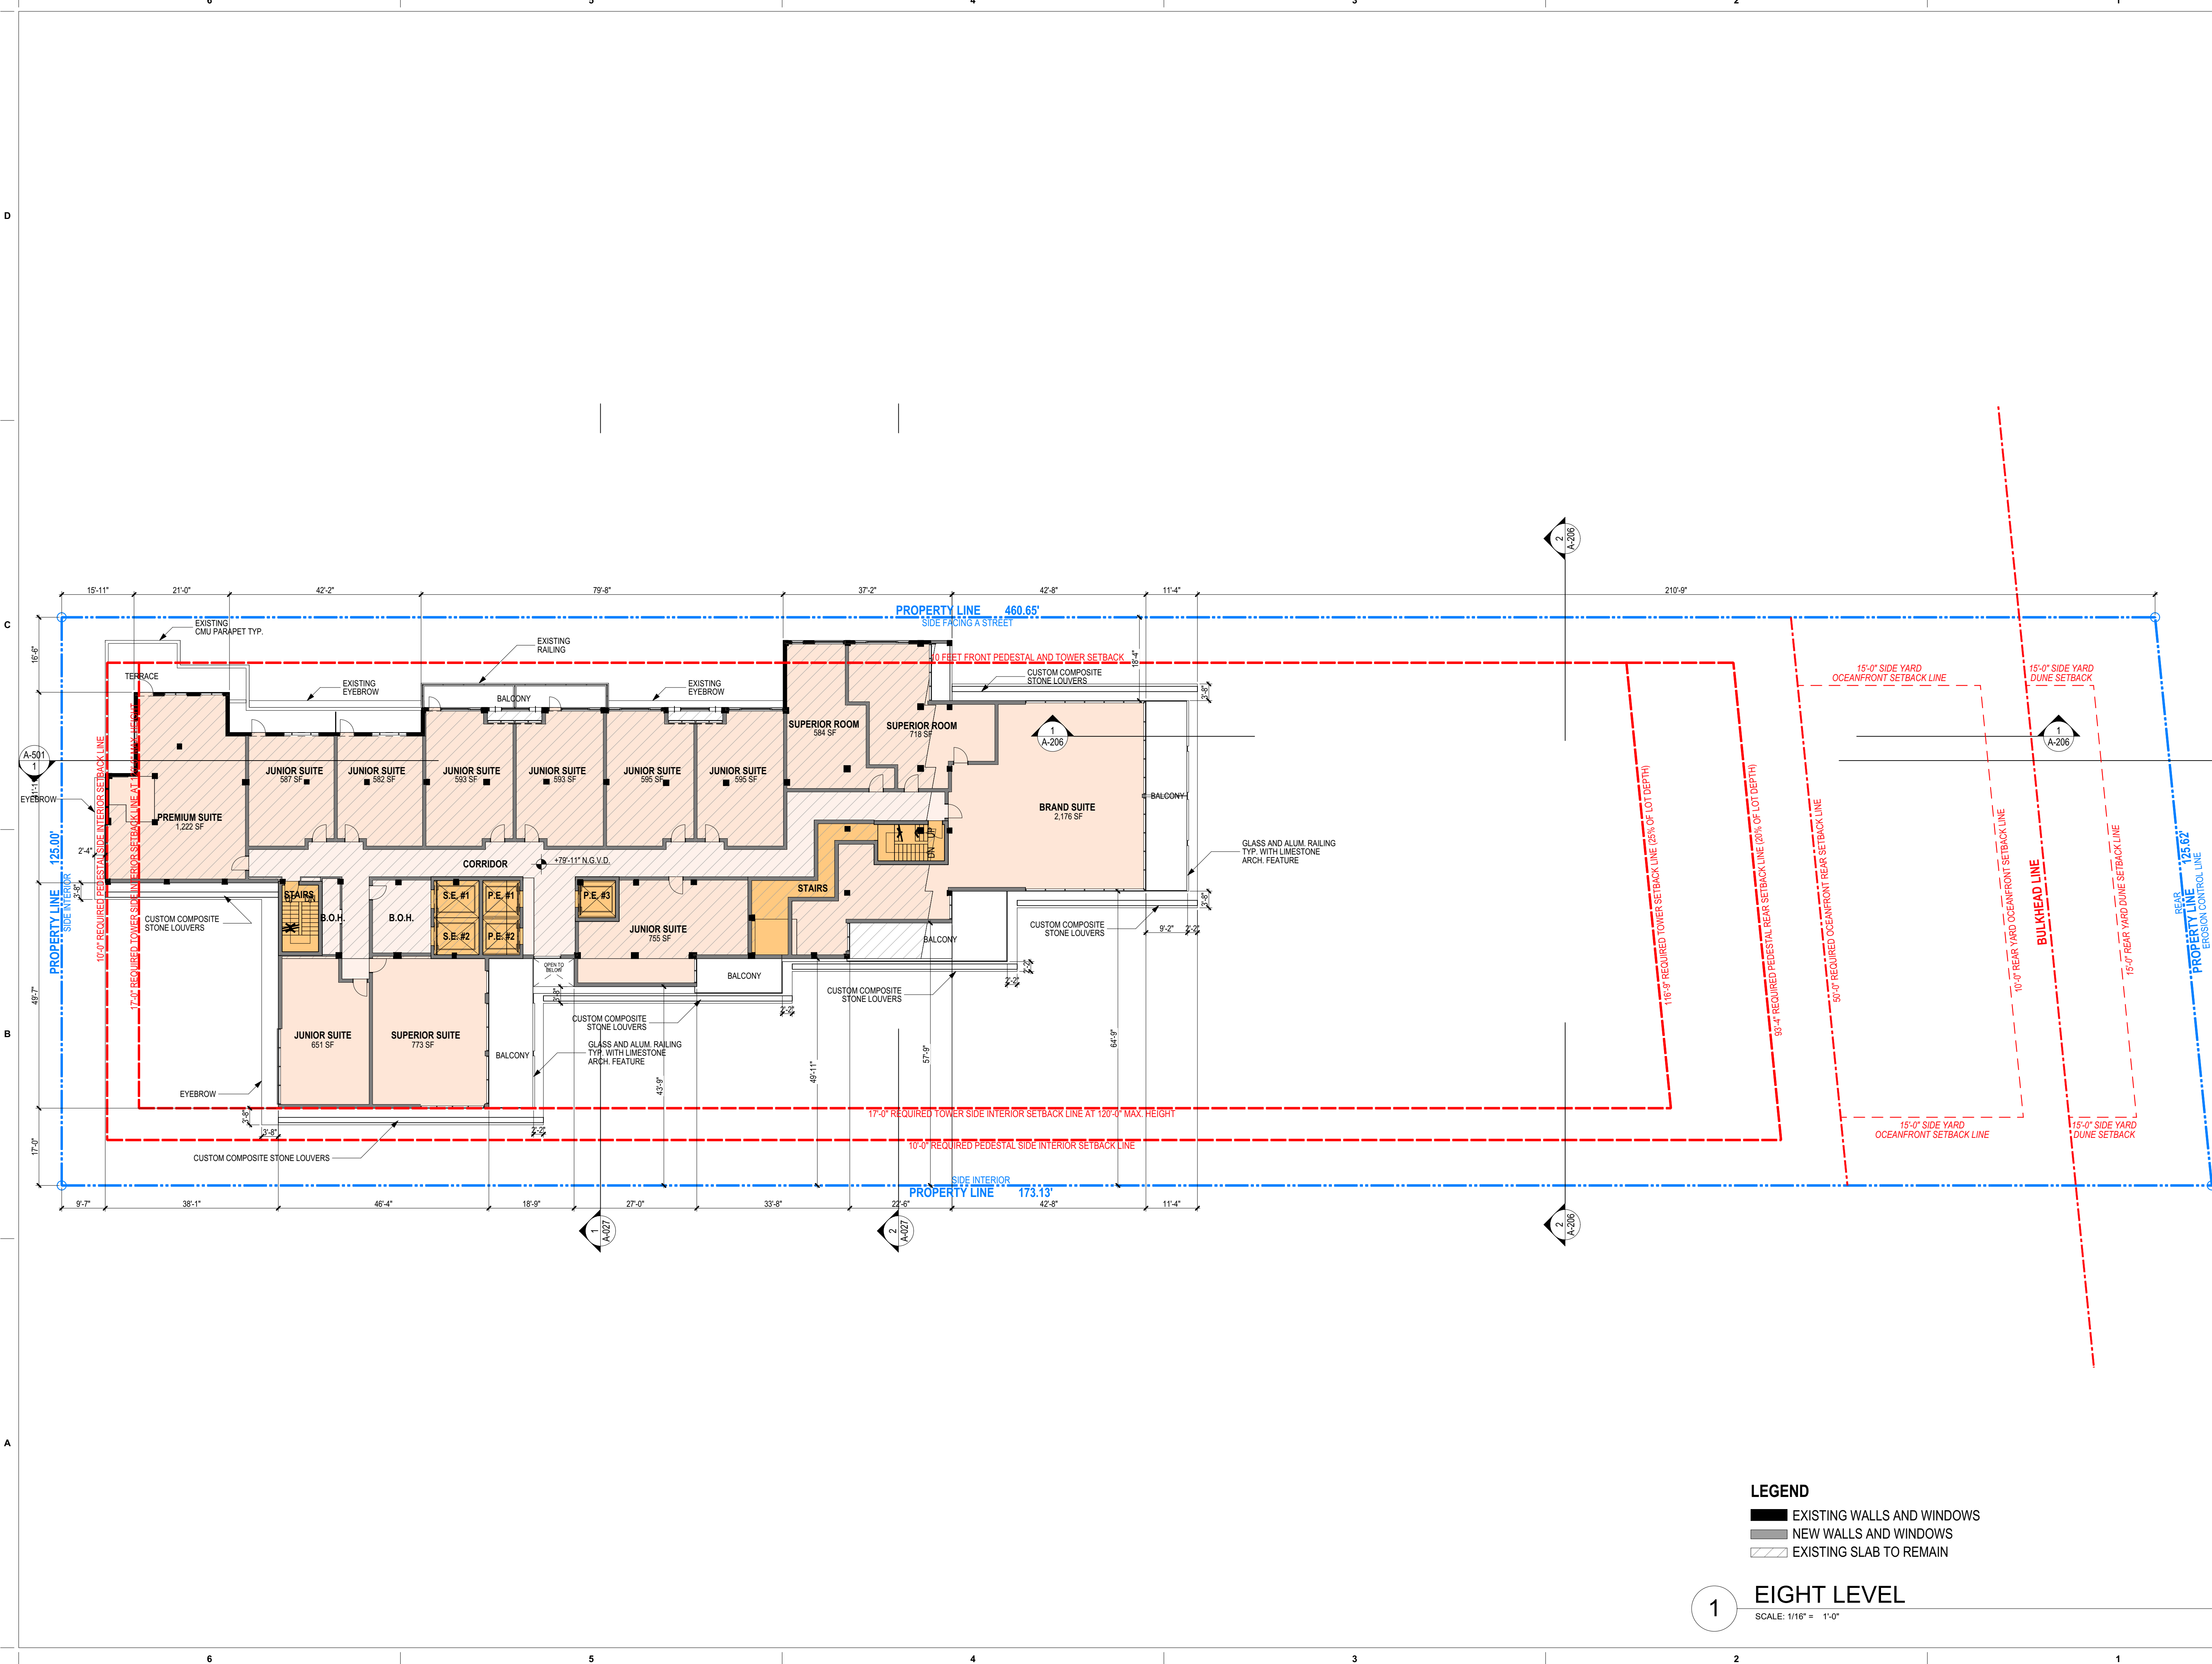

LEGEND

- EXISTING WALLS AND WINDOWS
- NEW WALLS AND WINDOWS
- EXISTING SLAB TO REMAIN

EIGHT LEVEL

SCALE: 1/16" = 1'-0"

revuelta
architecture
international

Miami
Santiago, Chile

revuelta-architecture.com

2950 SW 27TH AVE
SUITE 110
MIAMI, FL 33135
T: 305.590.5000
F: 305.590.5040

DESIGN ARCHITECT

CITTERIO-VIEL
& PARTNERS

Project

**BVLGARI HOTEL
MIAMI BEACH**

100 21st STREET
MIAMI BEACH, FL 33139

Revisions

Owner Information

BHI Miami Limited Corp.

1521 Alton Rd.
Suite 403
Miami Beach, FL 33139
(786) 785-6504

Consultant

Luis O. Revuelta

AR-007972

HPB SET

Date

03/05/2021

Scale

AS SHOWN

Project No.


2005


Sheet Name

PROPOSED LEVEL 8

Sheet No.

A-108

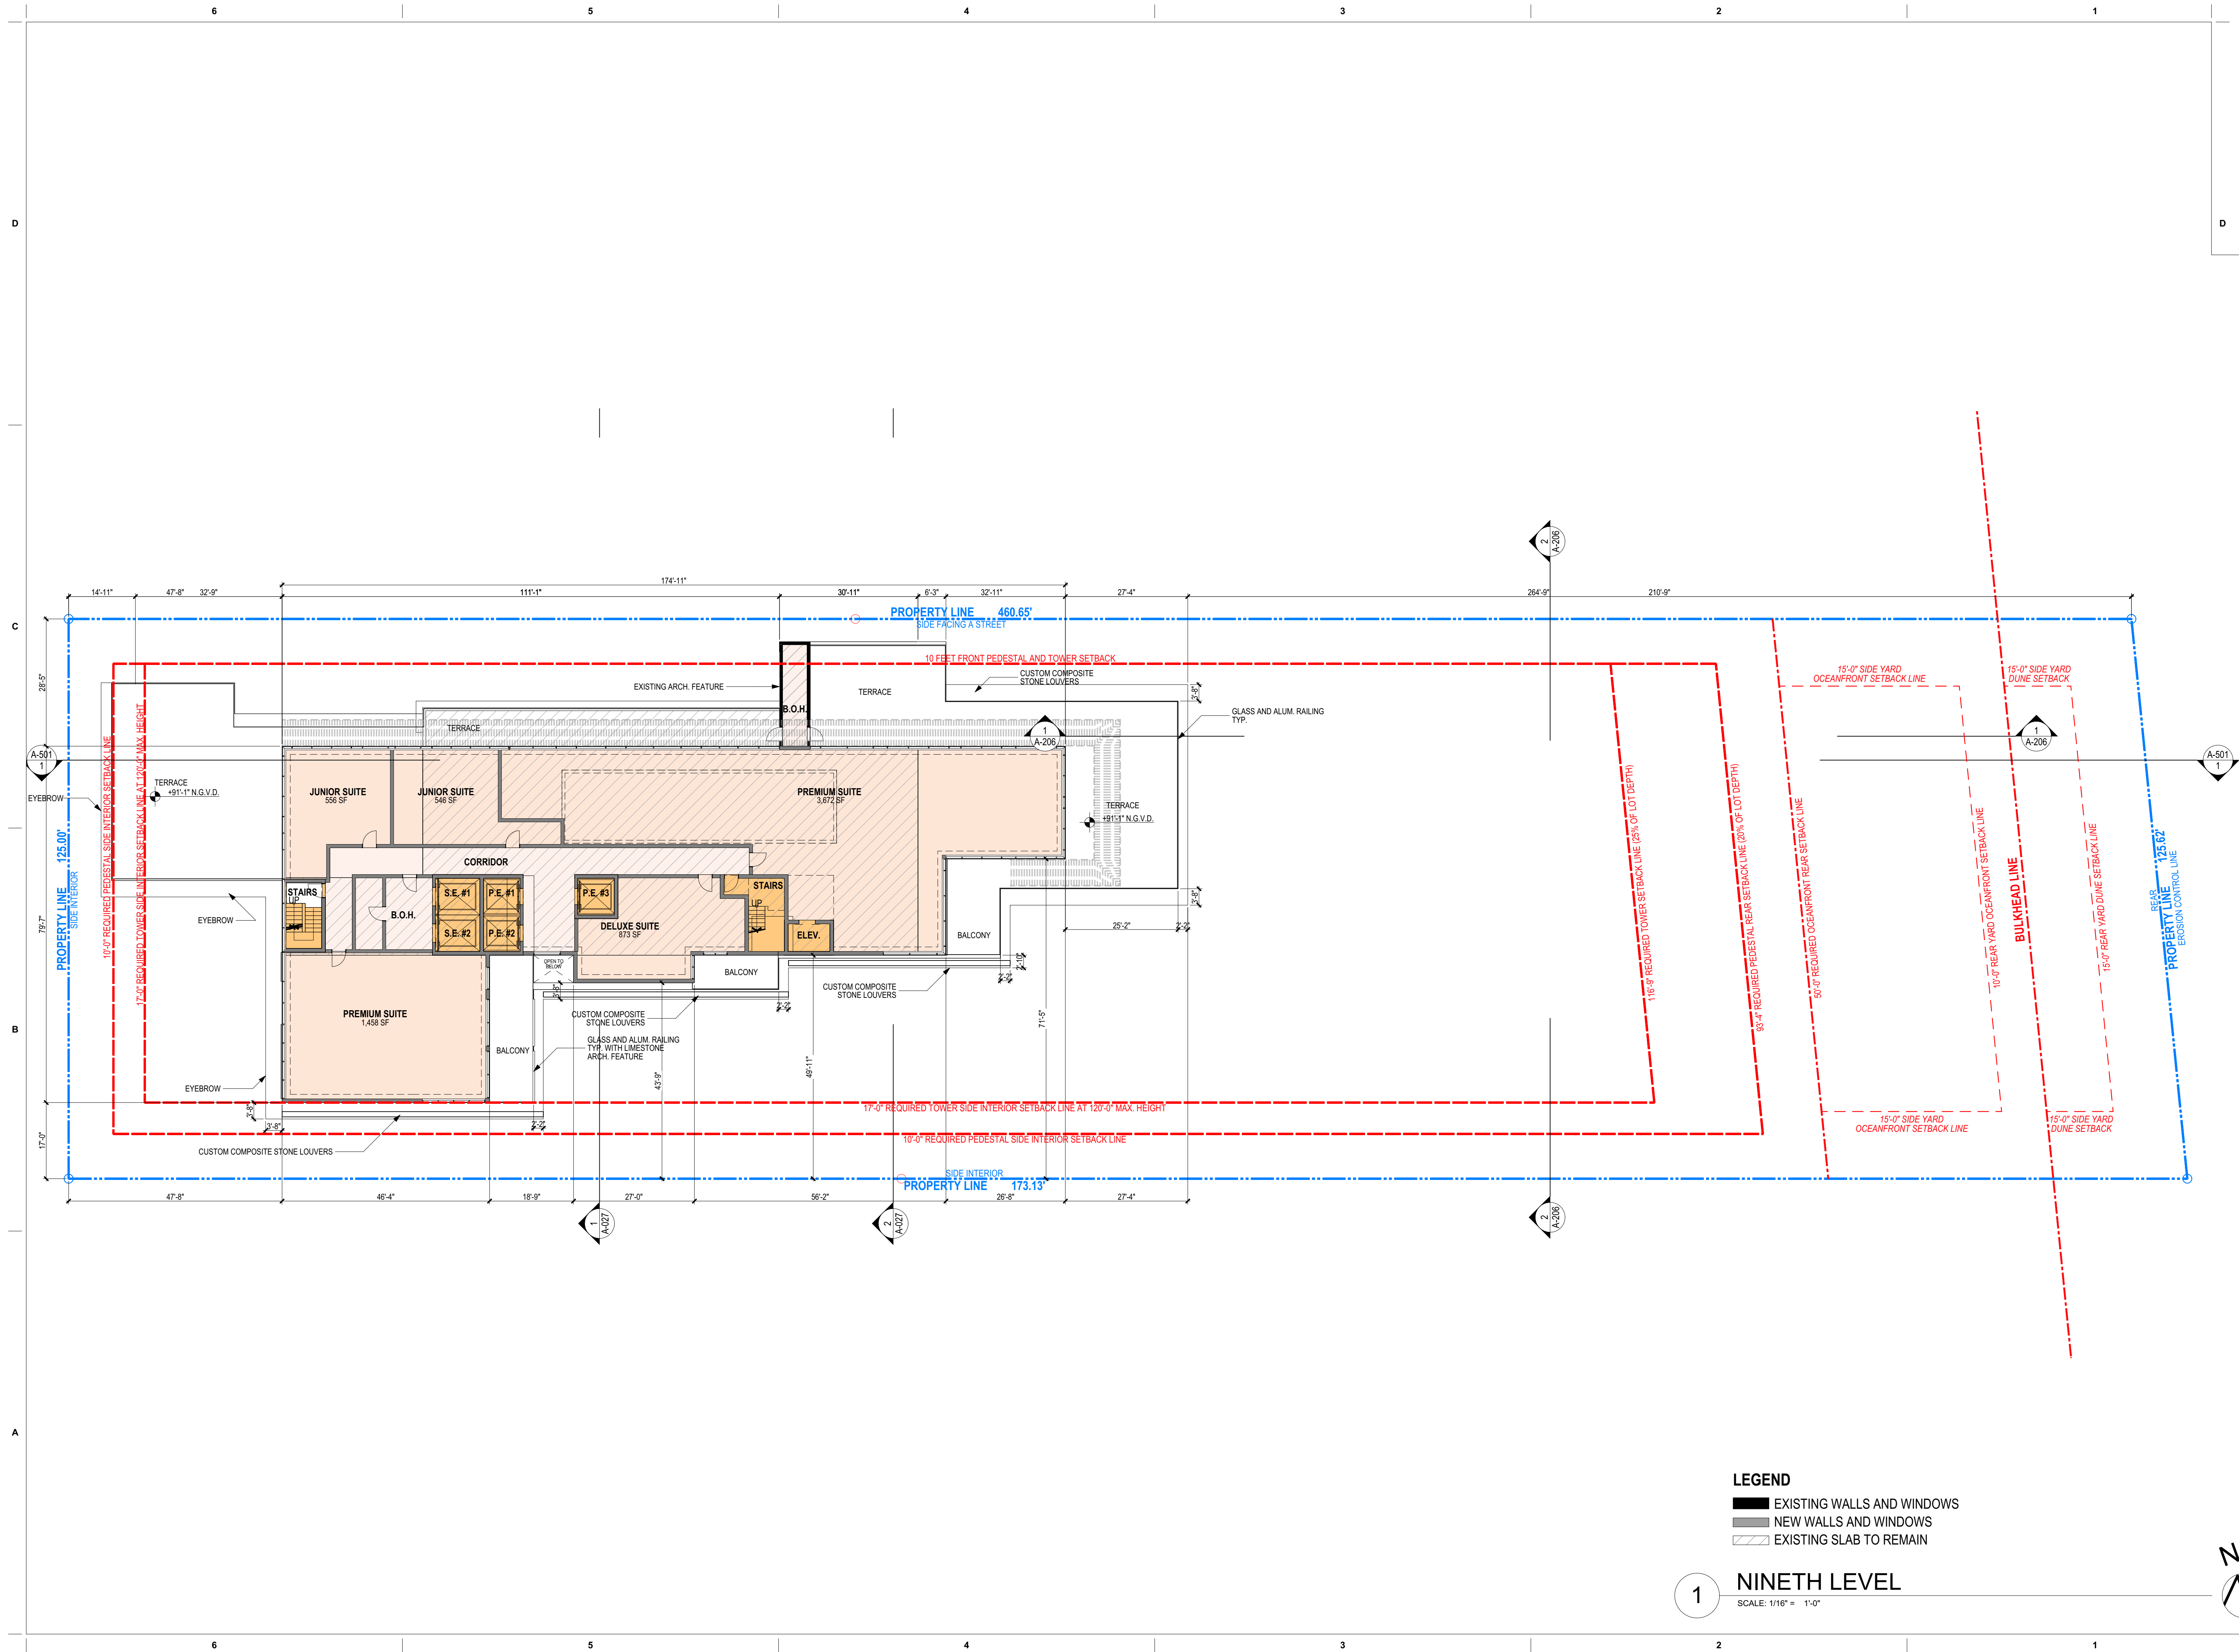

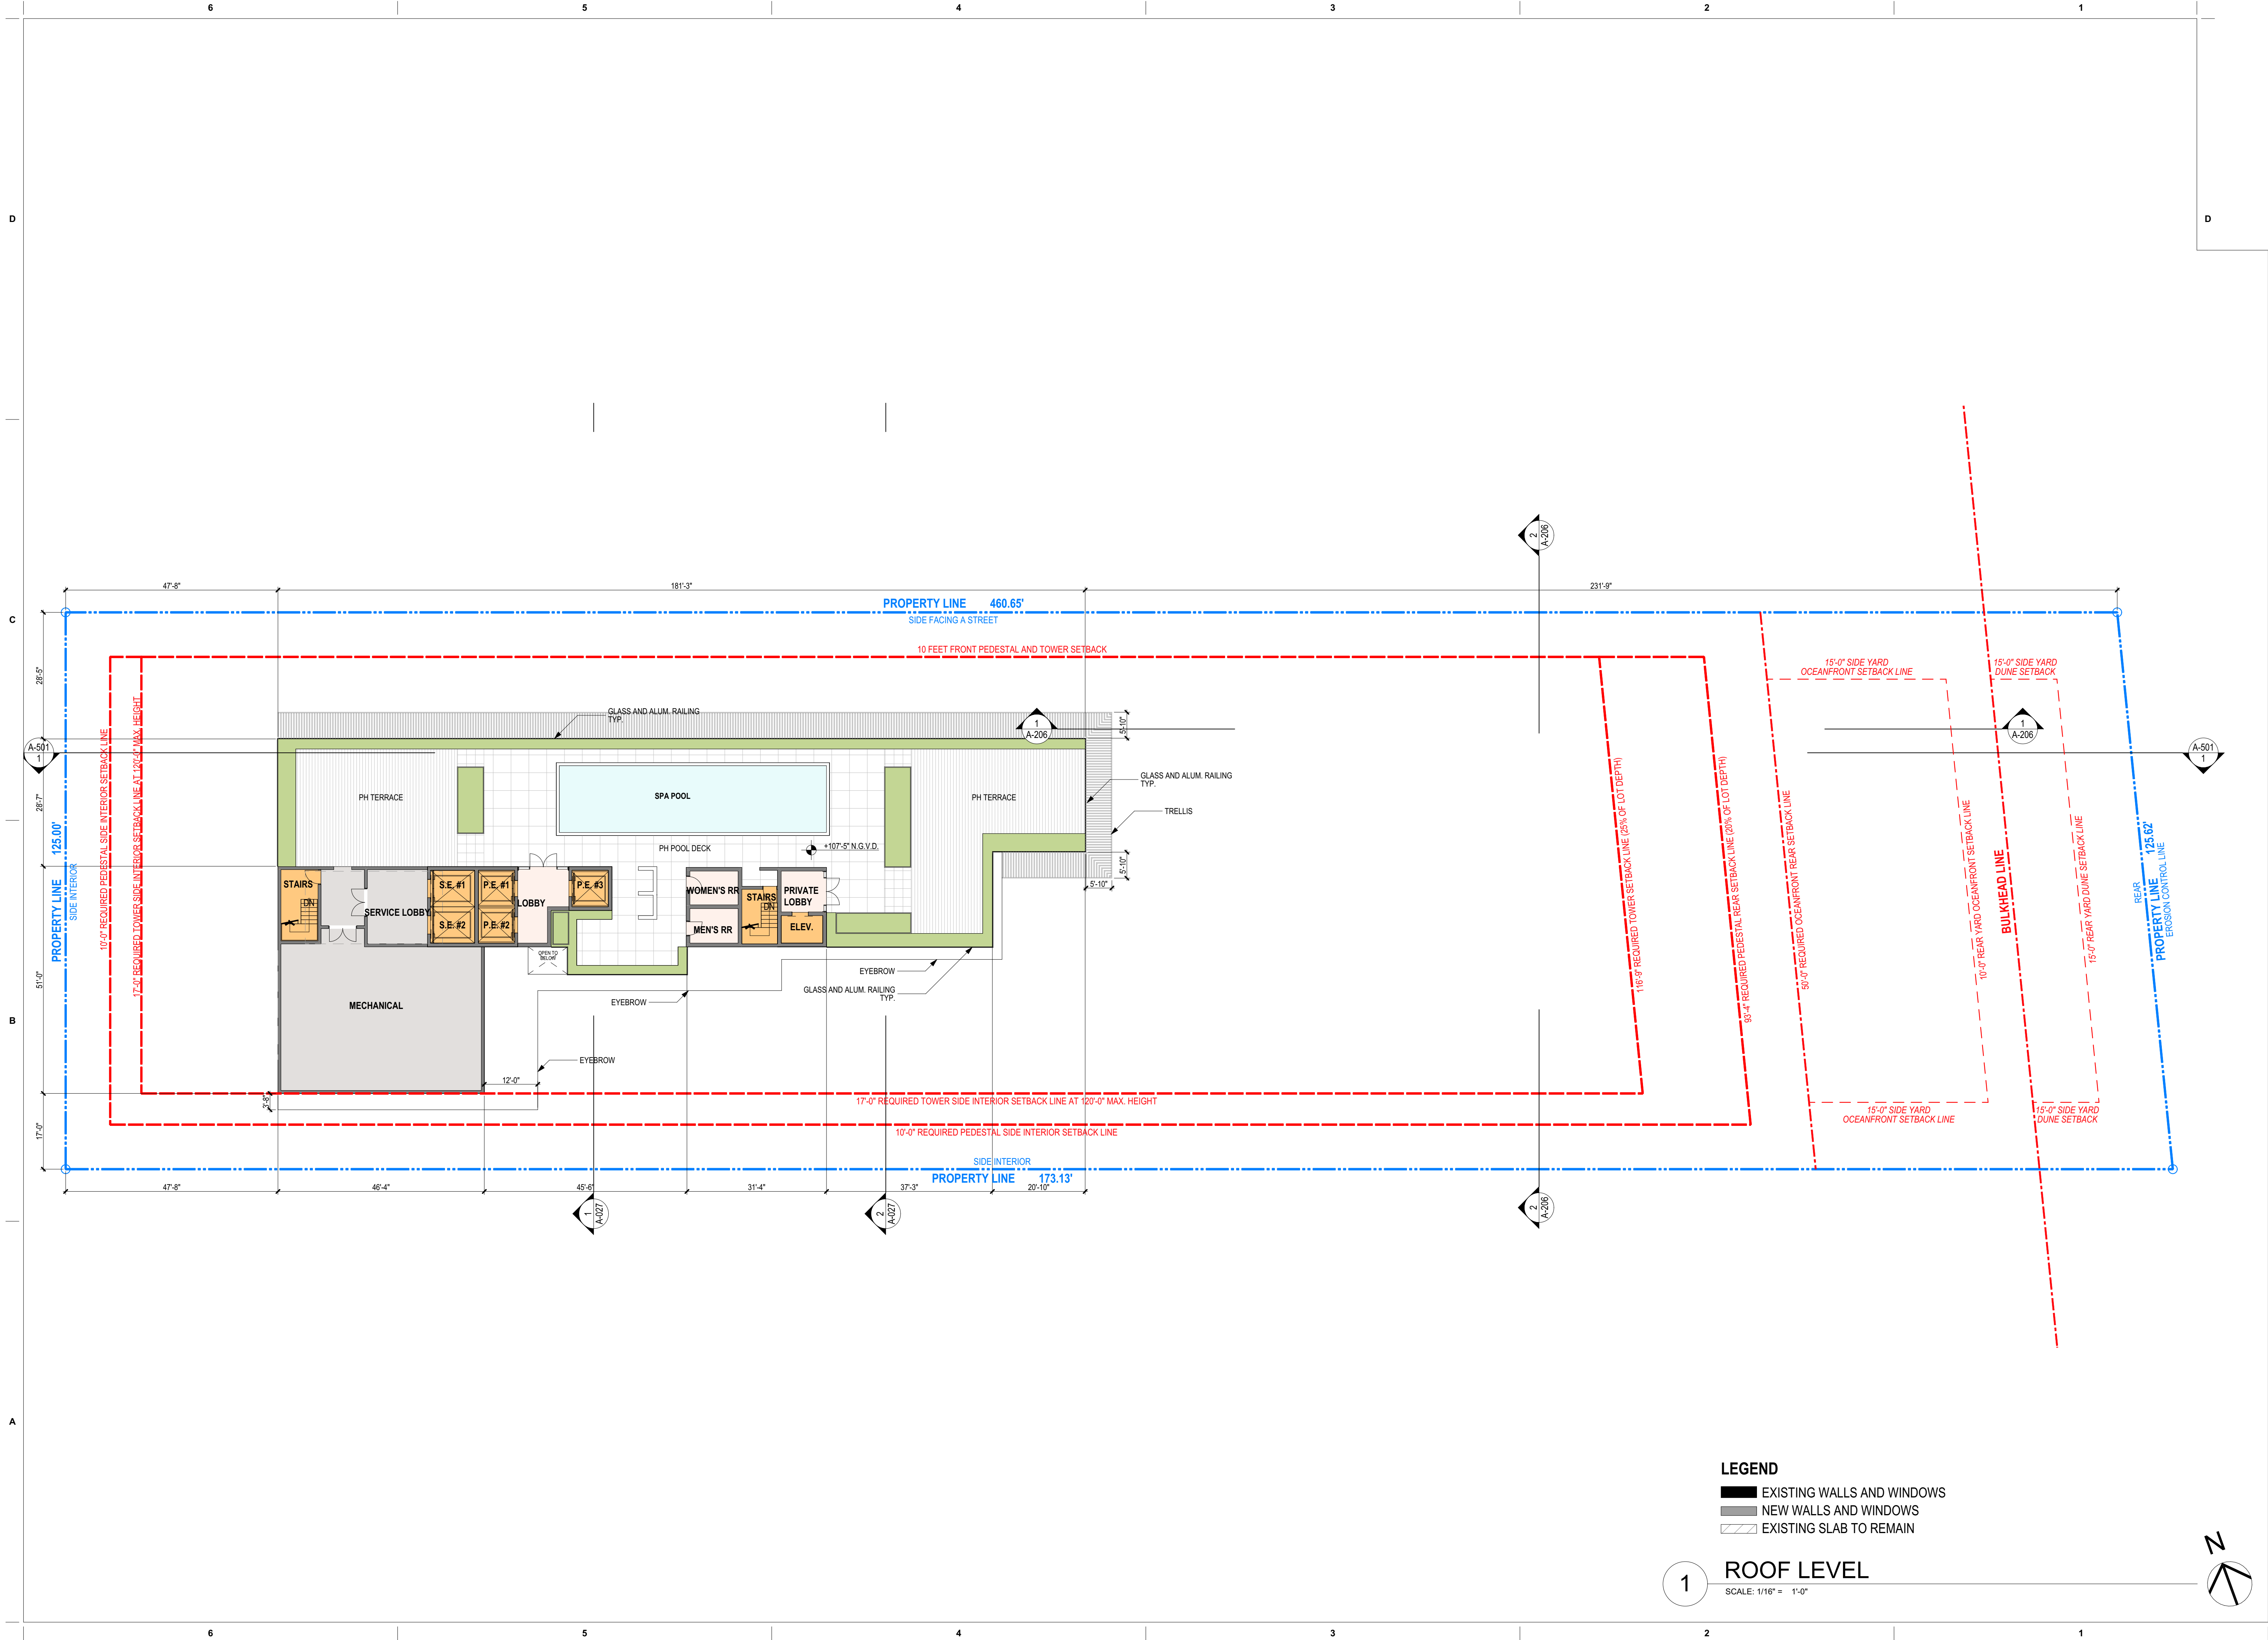

revuelta
architecture
international

Miami
Santiago, Chile

revuelta-architecture.com

2950 SW 27TH AVE
SUITE 110
MIAMI, FL 33135
T: 305.590.5000
F: 305.590.5040

DESIGN ARCHITECT

CITTERIO-VIEL
& PARTNERS

Project

**BVLGARI HOTEL
MIAMI BEACH**
100 21st STREET
MIAMI BEACH, FL 33139

Revisions

Owner Information

BHI Miami Limited Corp.
1521 Alton Rd.
Suite 403
Miami Beach, FL 33139
(786) 785-6504


Consultant


Luis O. Revuelta
AR-0007972

HPB SET





Date
03/05/2021
Scale
AS SHOWN
Project No.
2005
Sheet Name
PROPOSED ROOF DECK
Sheet No.

A-110

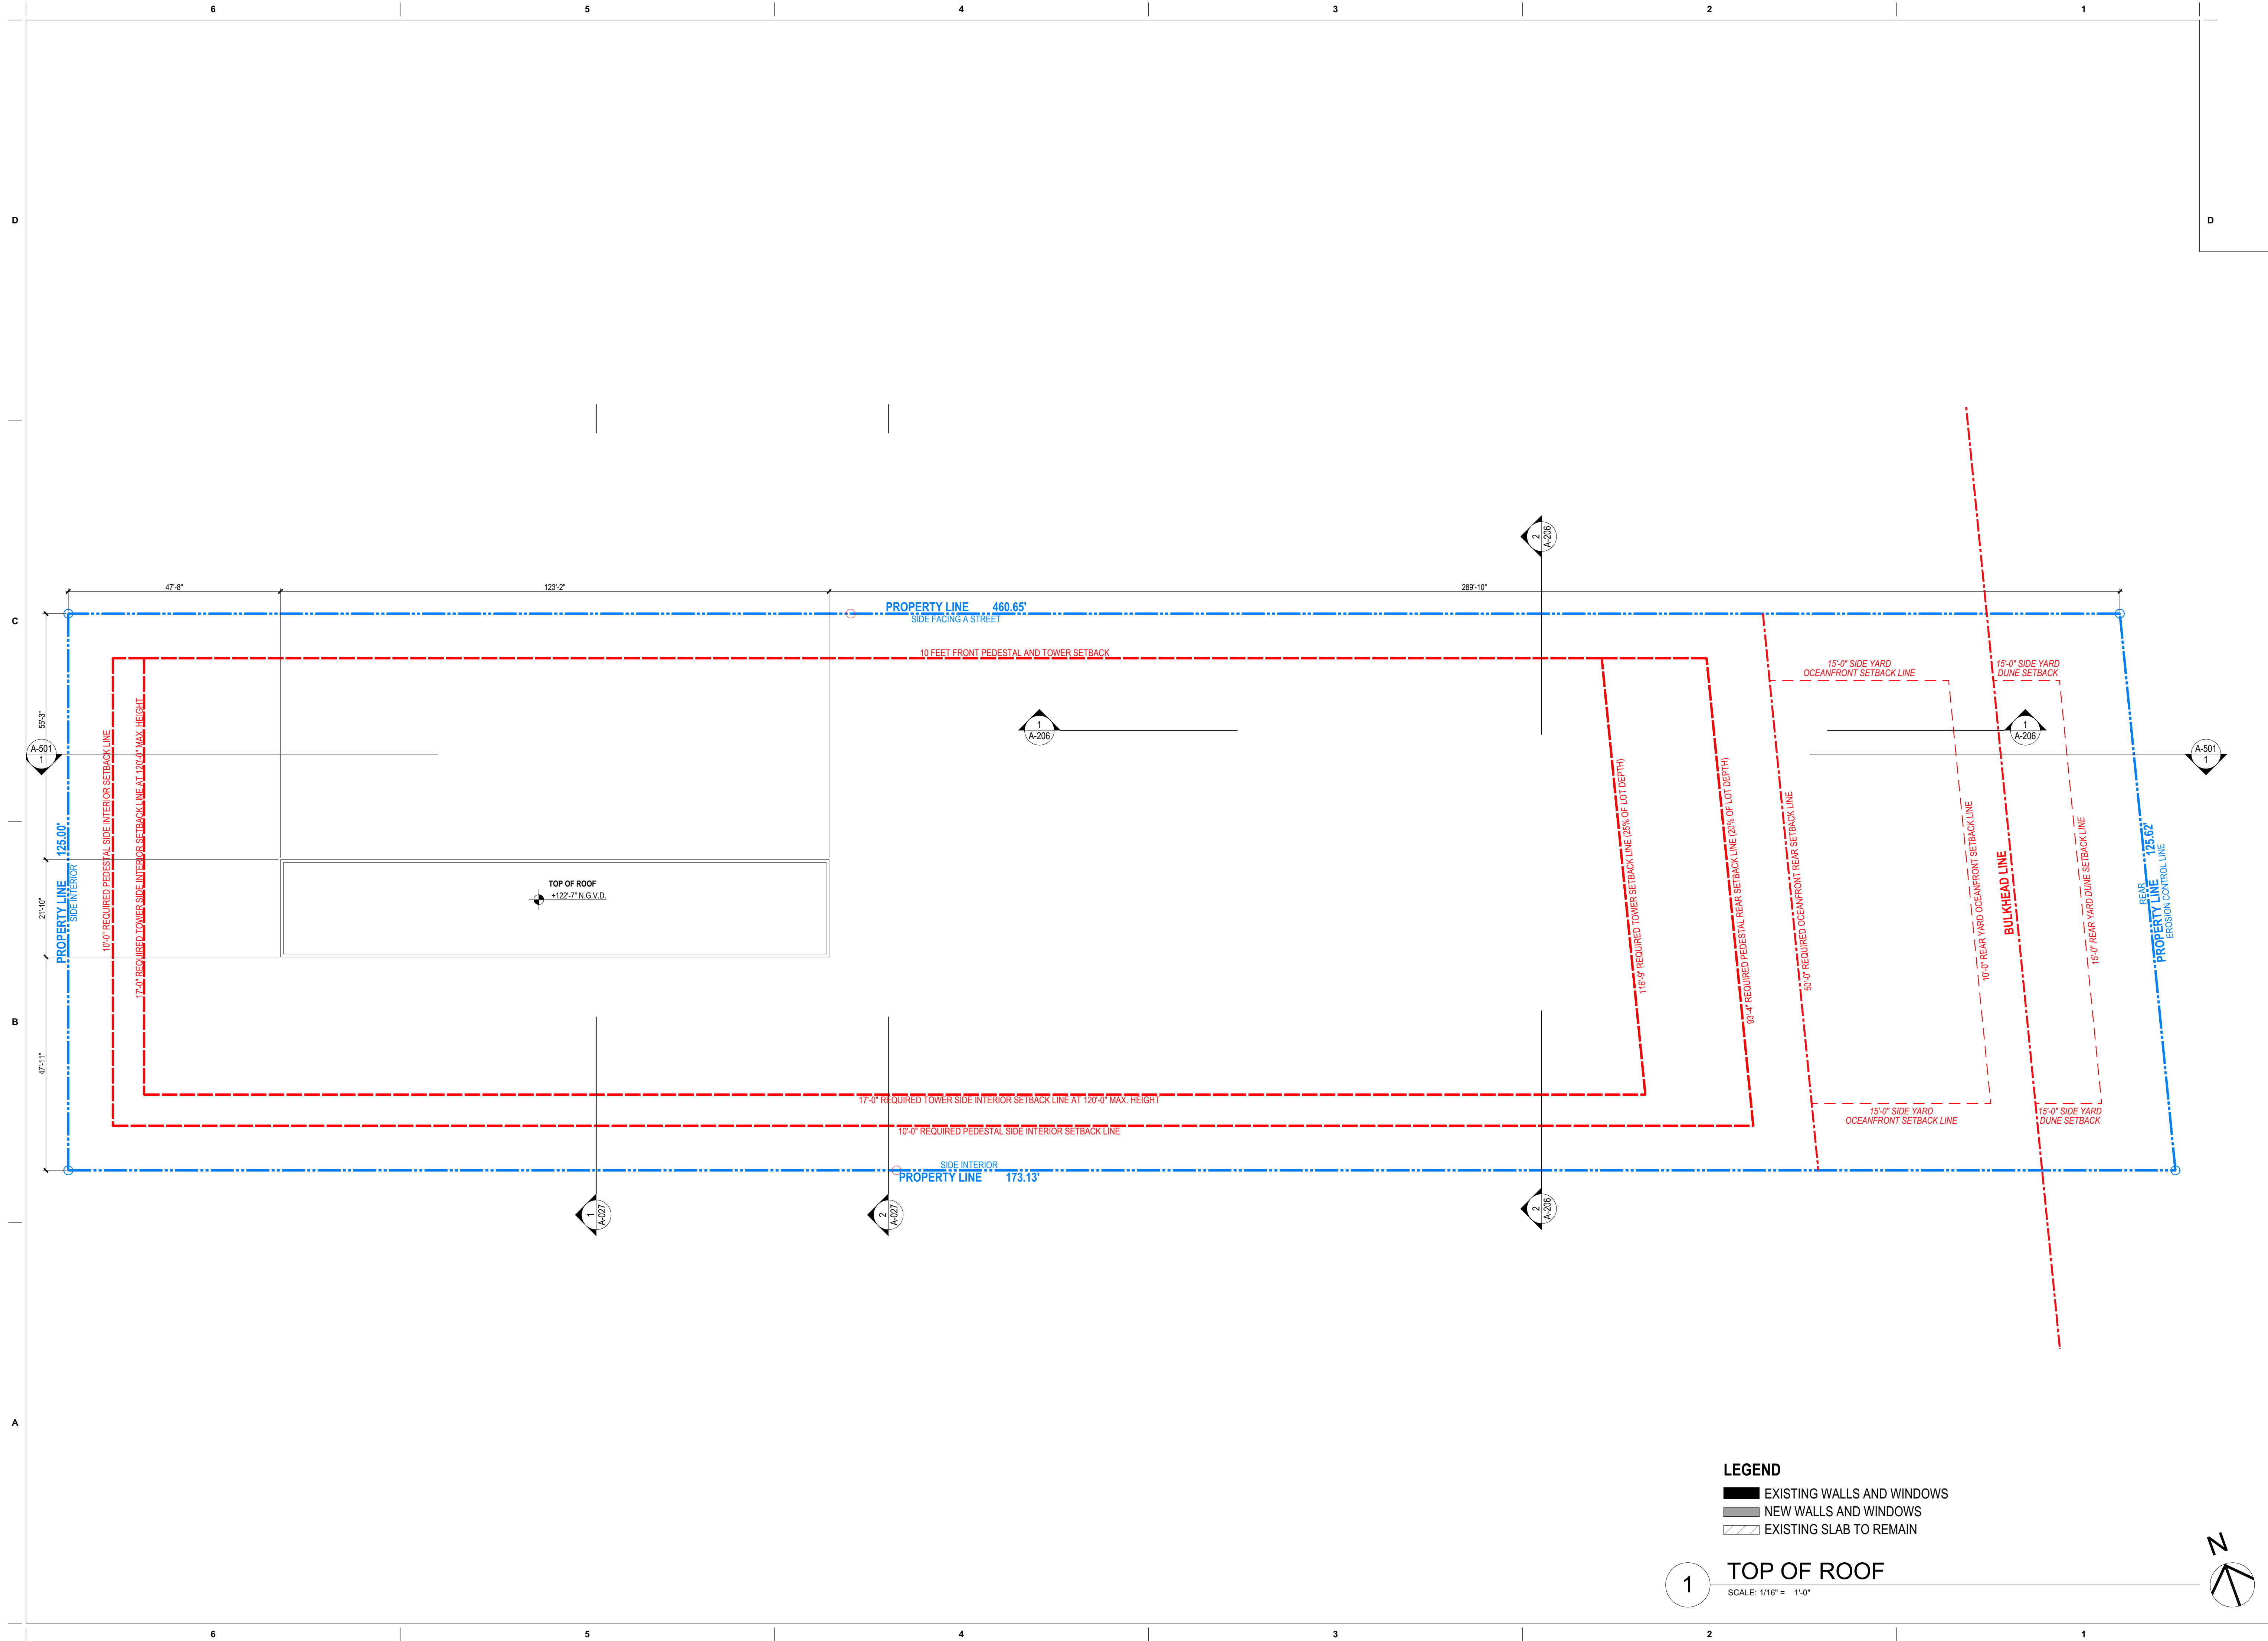

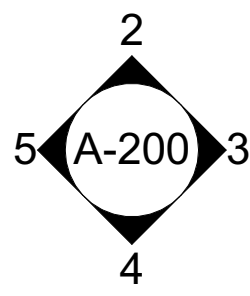

SCALE: 3/16" = 1'-0"

    

Sheet No.



IMAGE 1



IMAGE 2




IMAGE 3



IMAGE 4



IMAGE 5

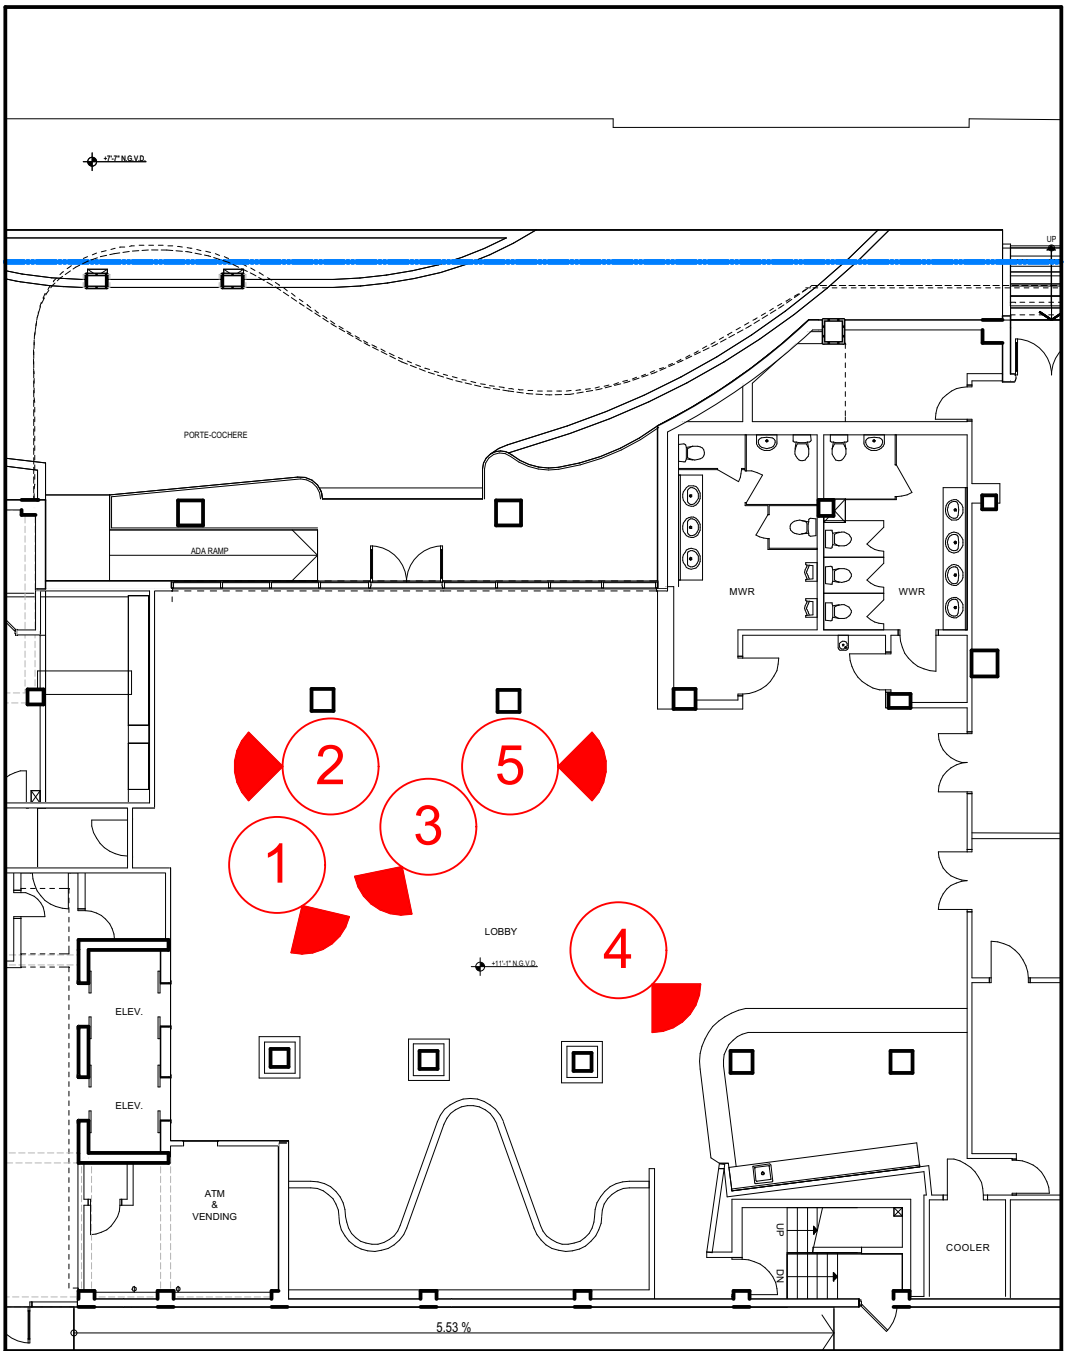

KEY MAP

EXISTING LOBBY IMAGES

revuelta
architecture
international

Miami
Santiago, Chile

revuelta-architecture.com

2350 SW 27TH AVE
SUITE 110
MIAMI, FL 33135
T: 305.590.5000
F: 305.590.5040

DESIGN ARCHITECT

CITTERIO-VIEL
& PARTNERS

Project

**BVLGARI HOTEL
MIAMI BEACH**
100 21st STREET
MIAMI BEACH, FL 33139

Revisions

Owner Information
BHI Miami Limited Corp.
1521 Alton Rd.
Suite 403
Miami Beach, FL 33139
(786) 785-6504

Consultant

Luis O. Revuelta
AR-0007972

HPB SET

Date
03/05/2021
Scale
AS SHOWN
Project No.
2005
Sheet Name
EXISTING LOBBY IMAGES
Sheet No.

A-201



NOT FOR CONSTRUCTION



1 VIEW 1



2 VIEW 2



3 VIEW 3



EXISTING LOUNGE
SCALE: 3/16" = 1'-0"



4 VIEW 4

revuelta
architecture
international

Miami
Santiago, Chile

revuelta-architecture.com

2950 SW 27TH AVE
SUITE 110
MIAMI, FL 33135
T: 305.590.5000
F: 305.590.5040

DESIGN ARCHITECT

CITTERIO-VIEL
& PARTNERS

Project

**BVLGARI HOTEL
MIAMI BEACH**
100 21st STREET
MIAMI BEACH, FL 33139

Revisions

Owner Information

BHI Miami Limited Corp.
1521 Alton Rd.
Suite 403
Miami Beach, FL 33139
(786) 785-6504

Consultant

Luis O. Revuelta
AR-007972

HPB SET

Date

03/05/2021

Scale

AS SHOWN

Project No.

2005


Sheet Name

EXISTING LOUNGE

Sheet No.

A-203

NOT FOR CONSTRUCTION

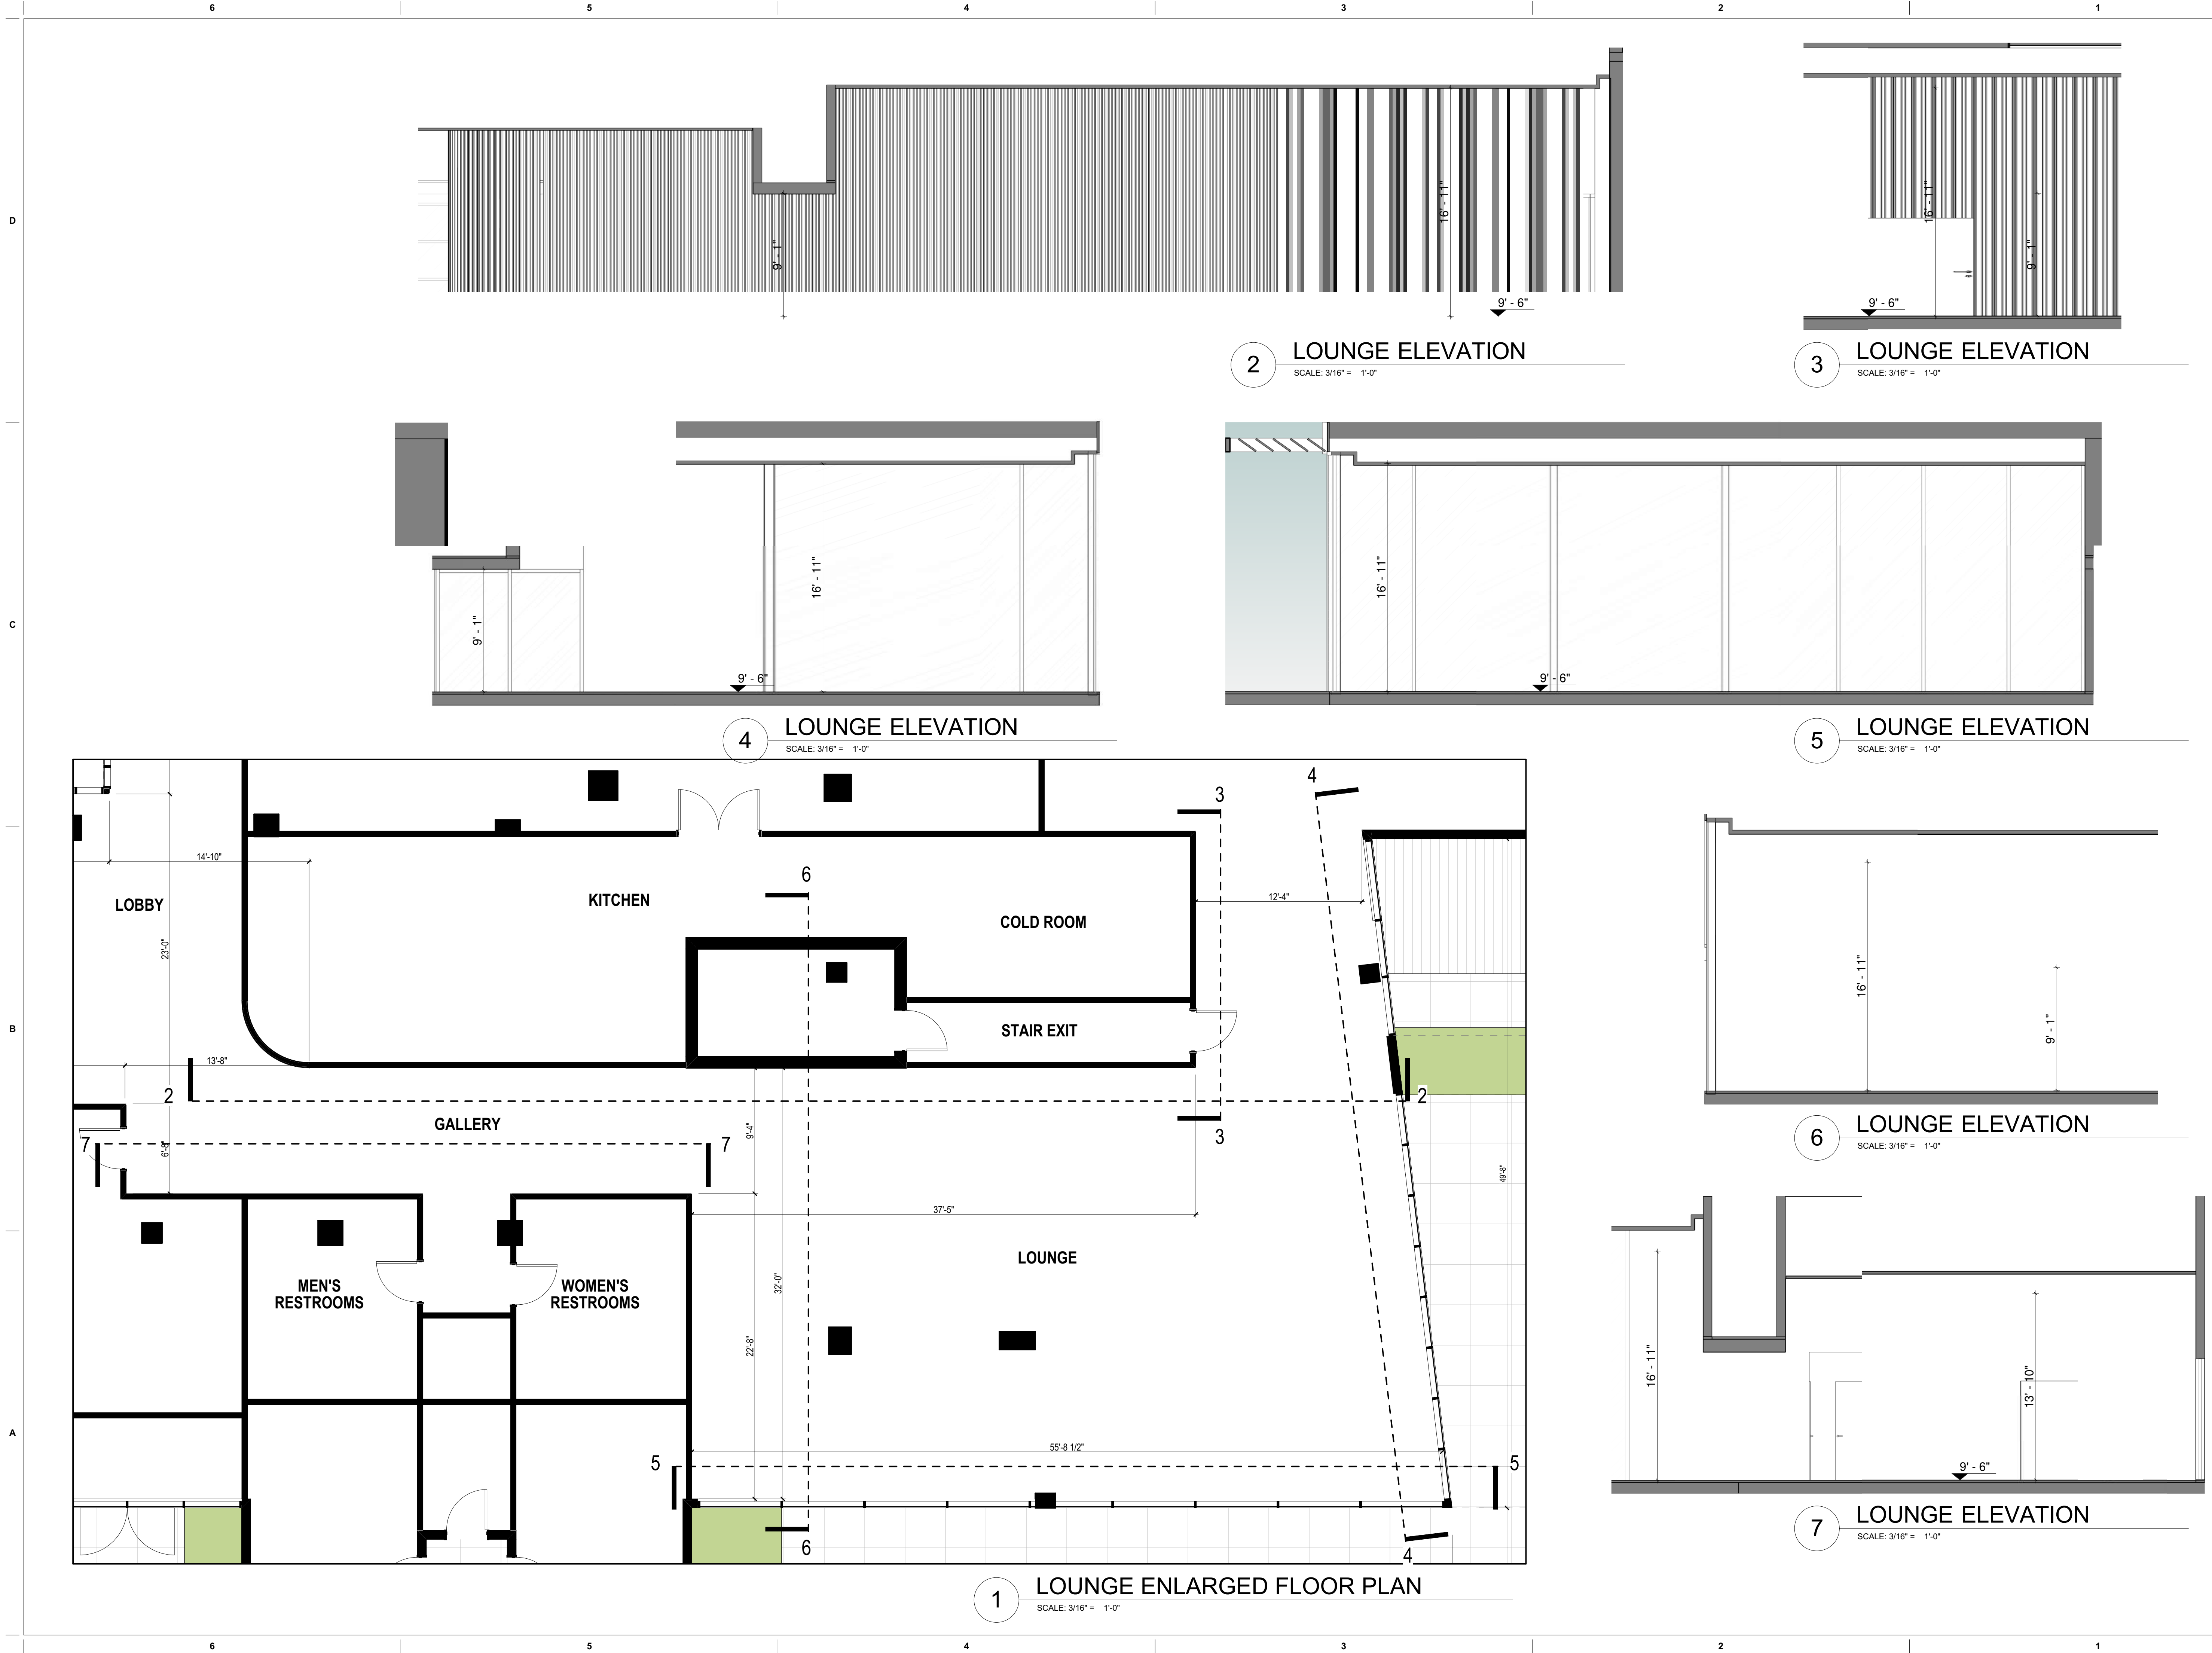

revuelta
architecture
internacional

Miami
Santiago, Chile

revuelta-architecture.com

2950 SW 27TH AVE
SUITE 110
MIAMI, FL 33135
T: 305.590.5000
F: 305.590.5040

DESIGN ARCHITECT

CITTERIO-VIEL
& PARTNERS

Project

**BVLGARI HOTEL
MIAMI BEACH**
100 21st STREET
MIAMI BEACH, FL 33139

Revisions

Owner Information
BHI Miami Limited Corp.
1521 Alton Rd.
Suite 403
Miami Beach, FL 33139
(786) 785-6504

Consultant

Luis O. Revuelta
AR-0007972


HPB SET

Date
03/05/2021
Scale
AS SHOWN
Project No.
2005

Sheet Name
PROPOSED LOUNGE
Sheet No.
A-204

NOT FOR CONSTRUCTION

These Design And Drawings Are The Copyrighted Property Of Revuelta Architecture International, P.A. and May Not Be Reproduced, Copied, or Transmitted in Any Form or by Any Means, Electronic or Mechanical, Without Prior Written Consent of the Architect. The Contractor Must Check And Verify All Dimensions Of The Job And Be Responsible For Same. Reporting Any Discrepancies To The Architects Before Commencing Work. Drawings Not To Be Scaled. This Blueprint Shall Be Used For ARCHITECTURAL PURPOSES ONLY. BY ARCHITECT: DATE 3/26/21

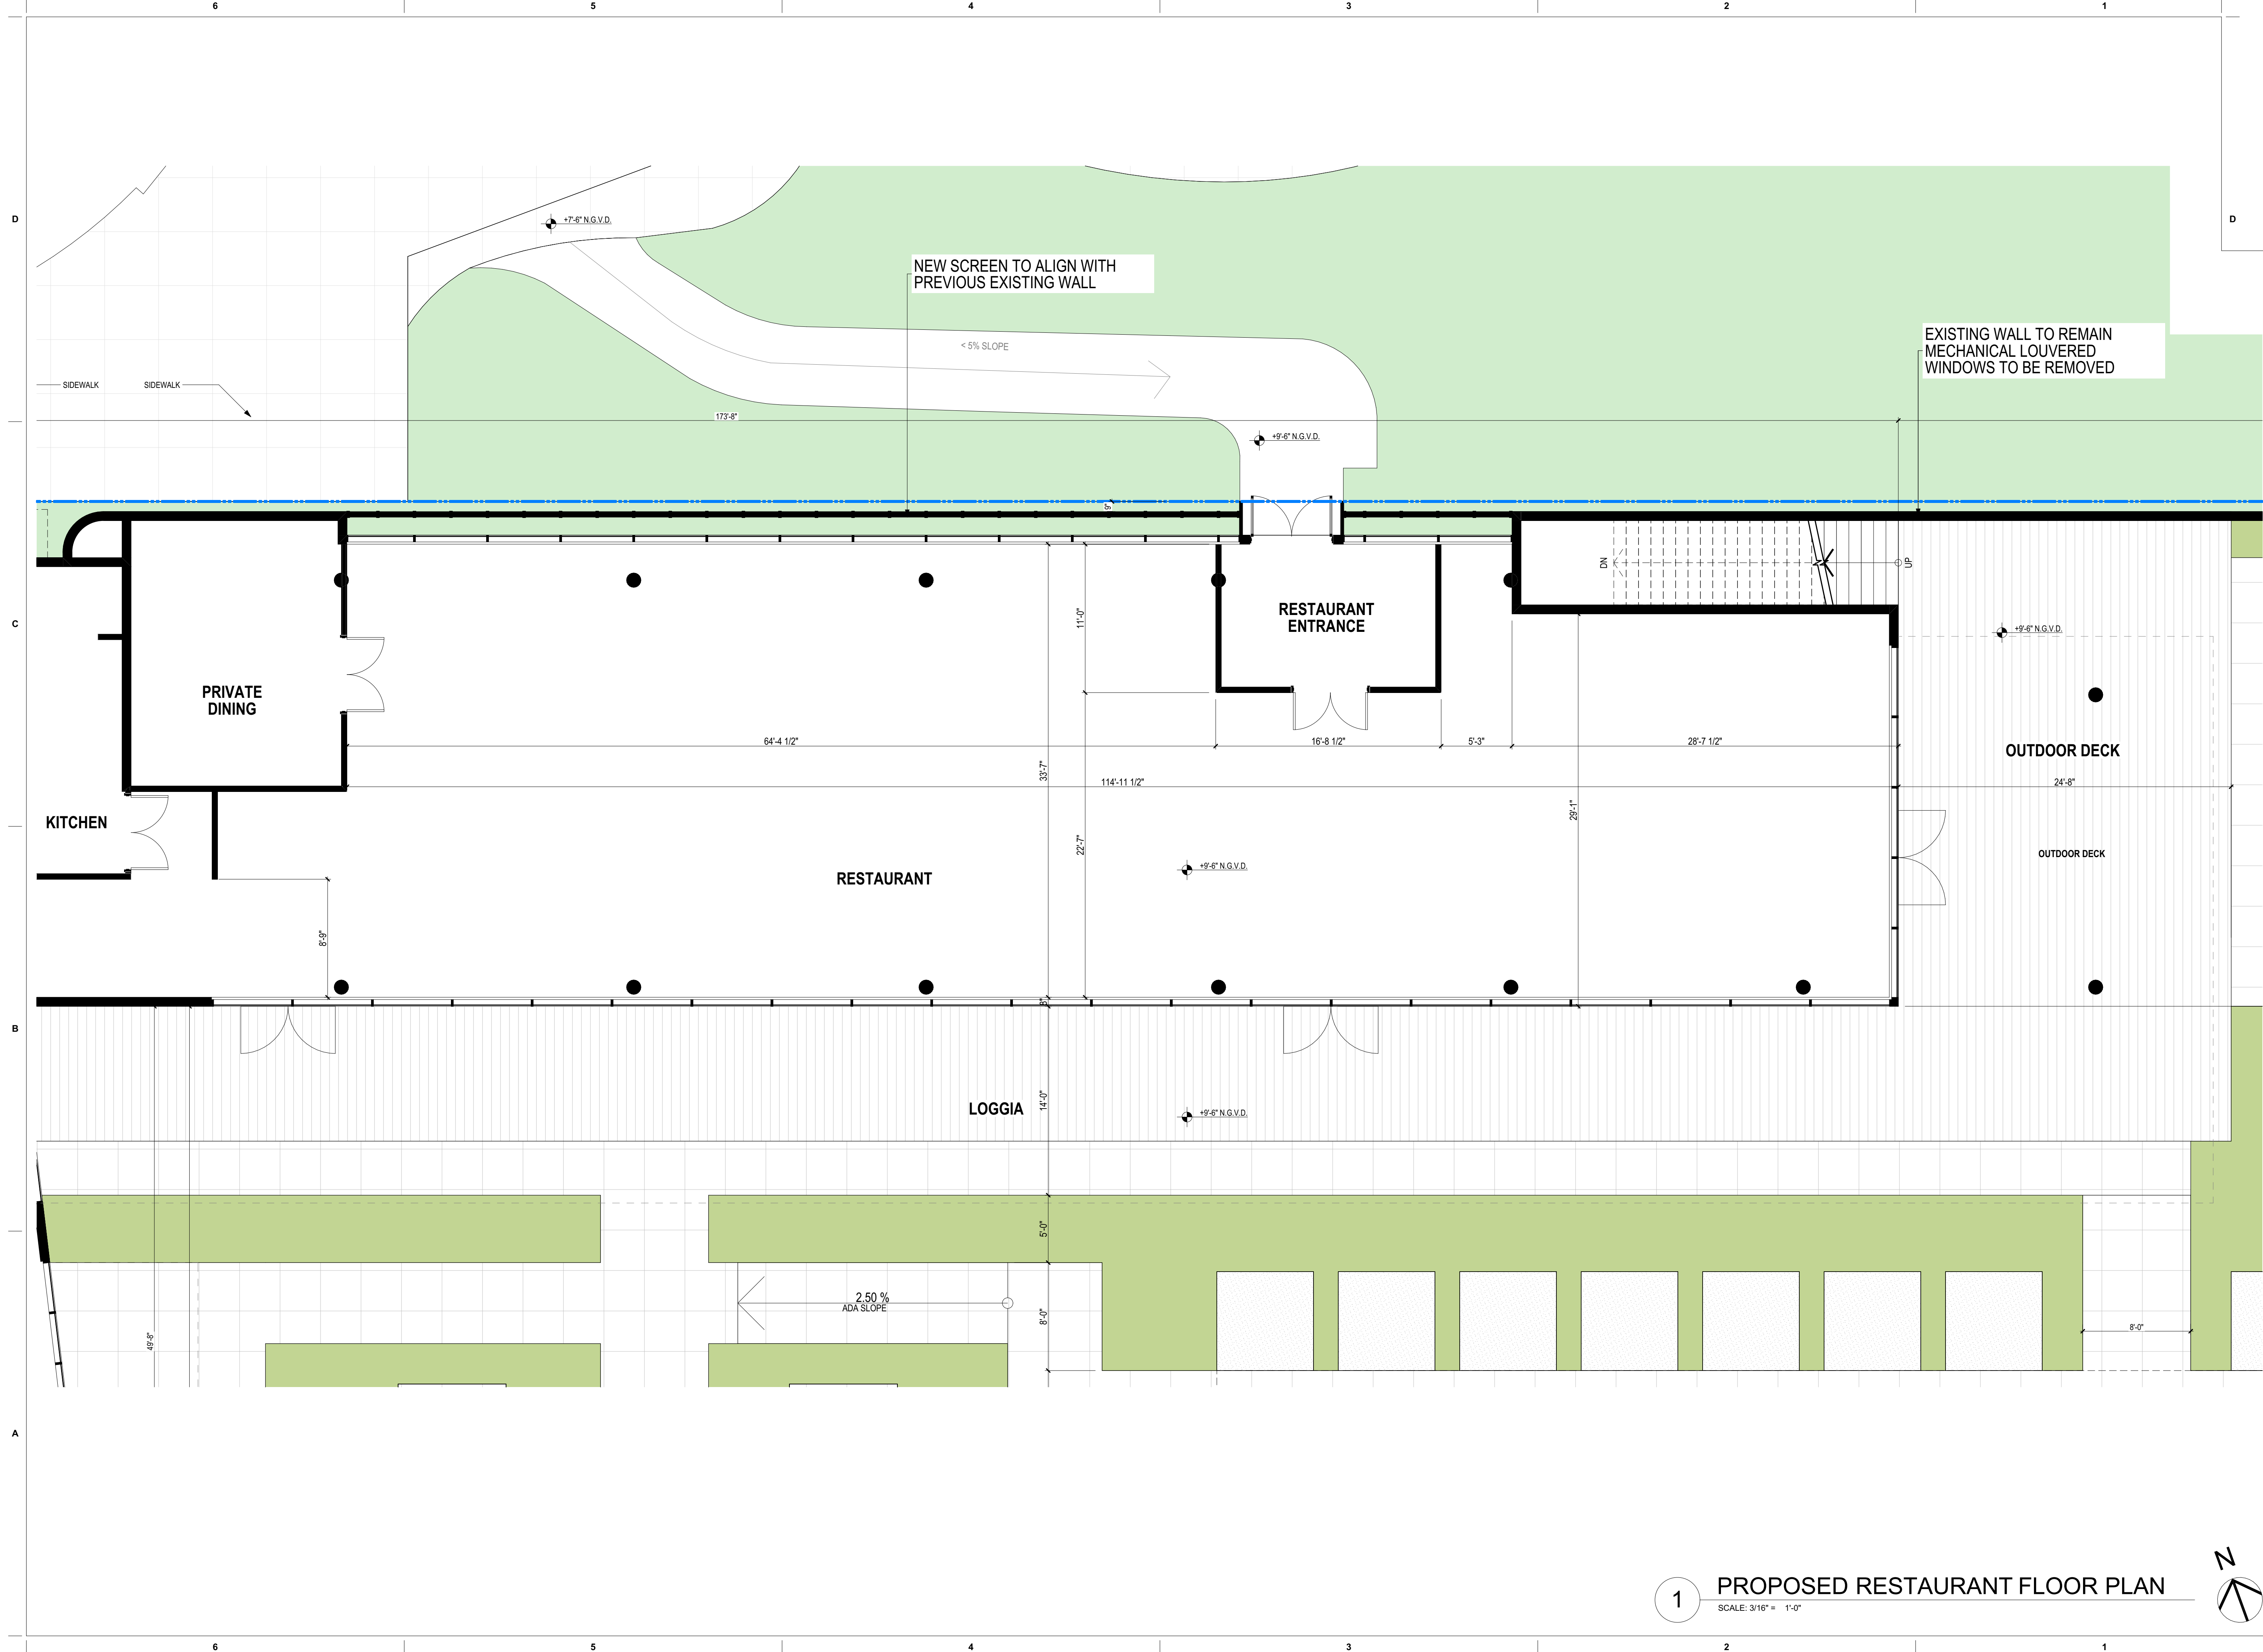

1 PROPOSED RESTAURANT FLOOR PLAN
SCALE: 3/16" = 1'-0"

revuelta
architecture
international

Miami
Santiago, Chile

revuelta-architecture.com

2950 SW 27TH AVE
SUITE 110
MIAMI, FL 33135
T: 305.590.5000
F: 305.590.5040

DESIGN ARCHITECT

CITTERIO-VIEL
& PARTNERS

Project

BVLGARI HOTEL
MIAMI BEACH
100 21st STREET
MIAMI BEACH, FL 33139

Revisions

Owner Information

BHI Miami Limited Corp.
1521 Alton Rd.
Suite 403
Miami Beach, FL 33139
(786) 785-6504

Consultant

Luis O. Revuelta

AR-0007972

HPB SET

Date

03/05/2021

Scale

AS SHOWN

Project No.

2005


Sheet Name

PROPOSED RESTAURANT FLOOR
PLAN


Sheet No.

A-205


NOT FOR CONSTRUCTION

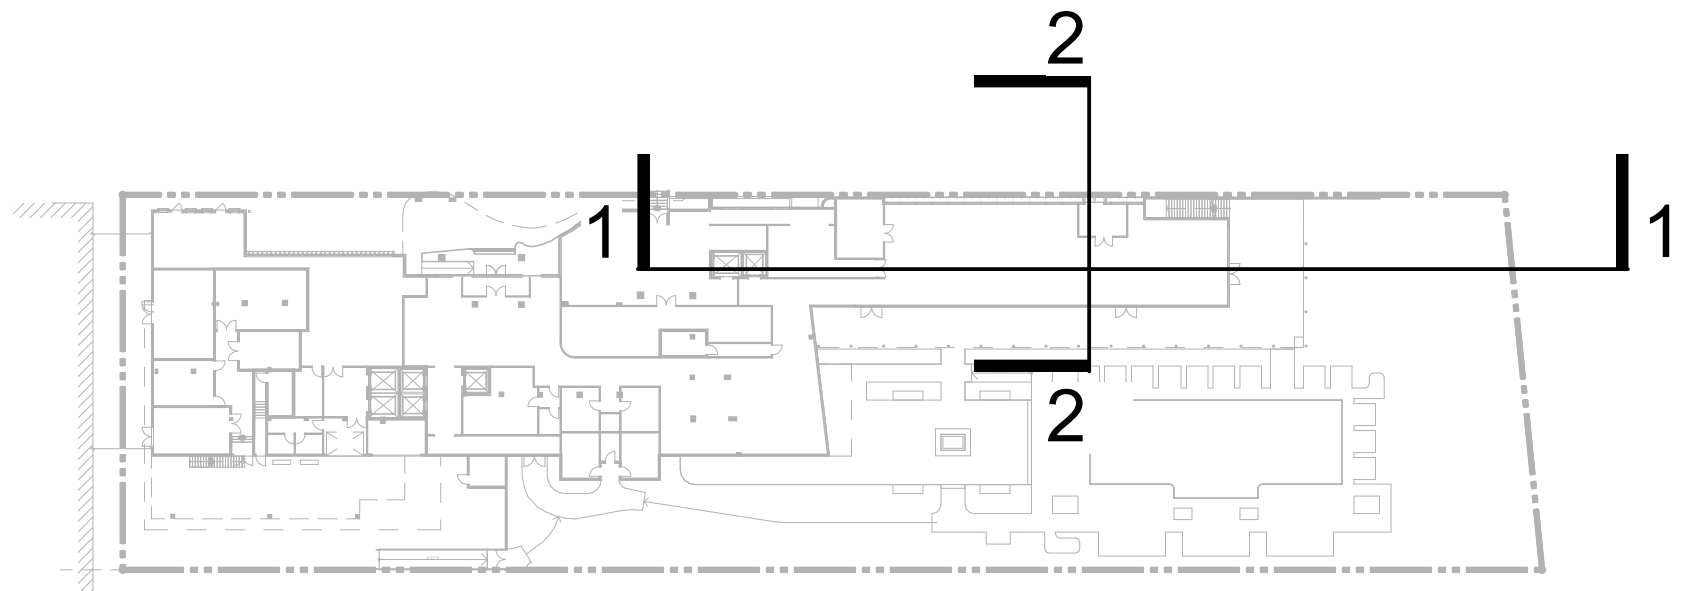

KEY MAP

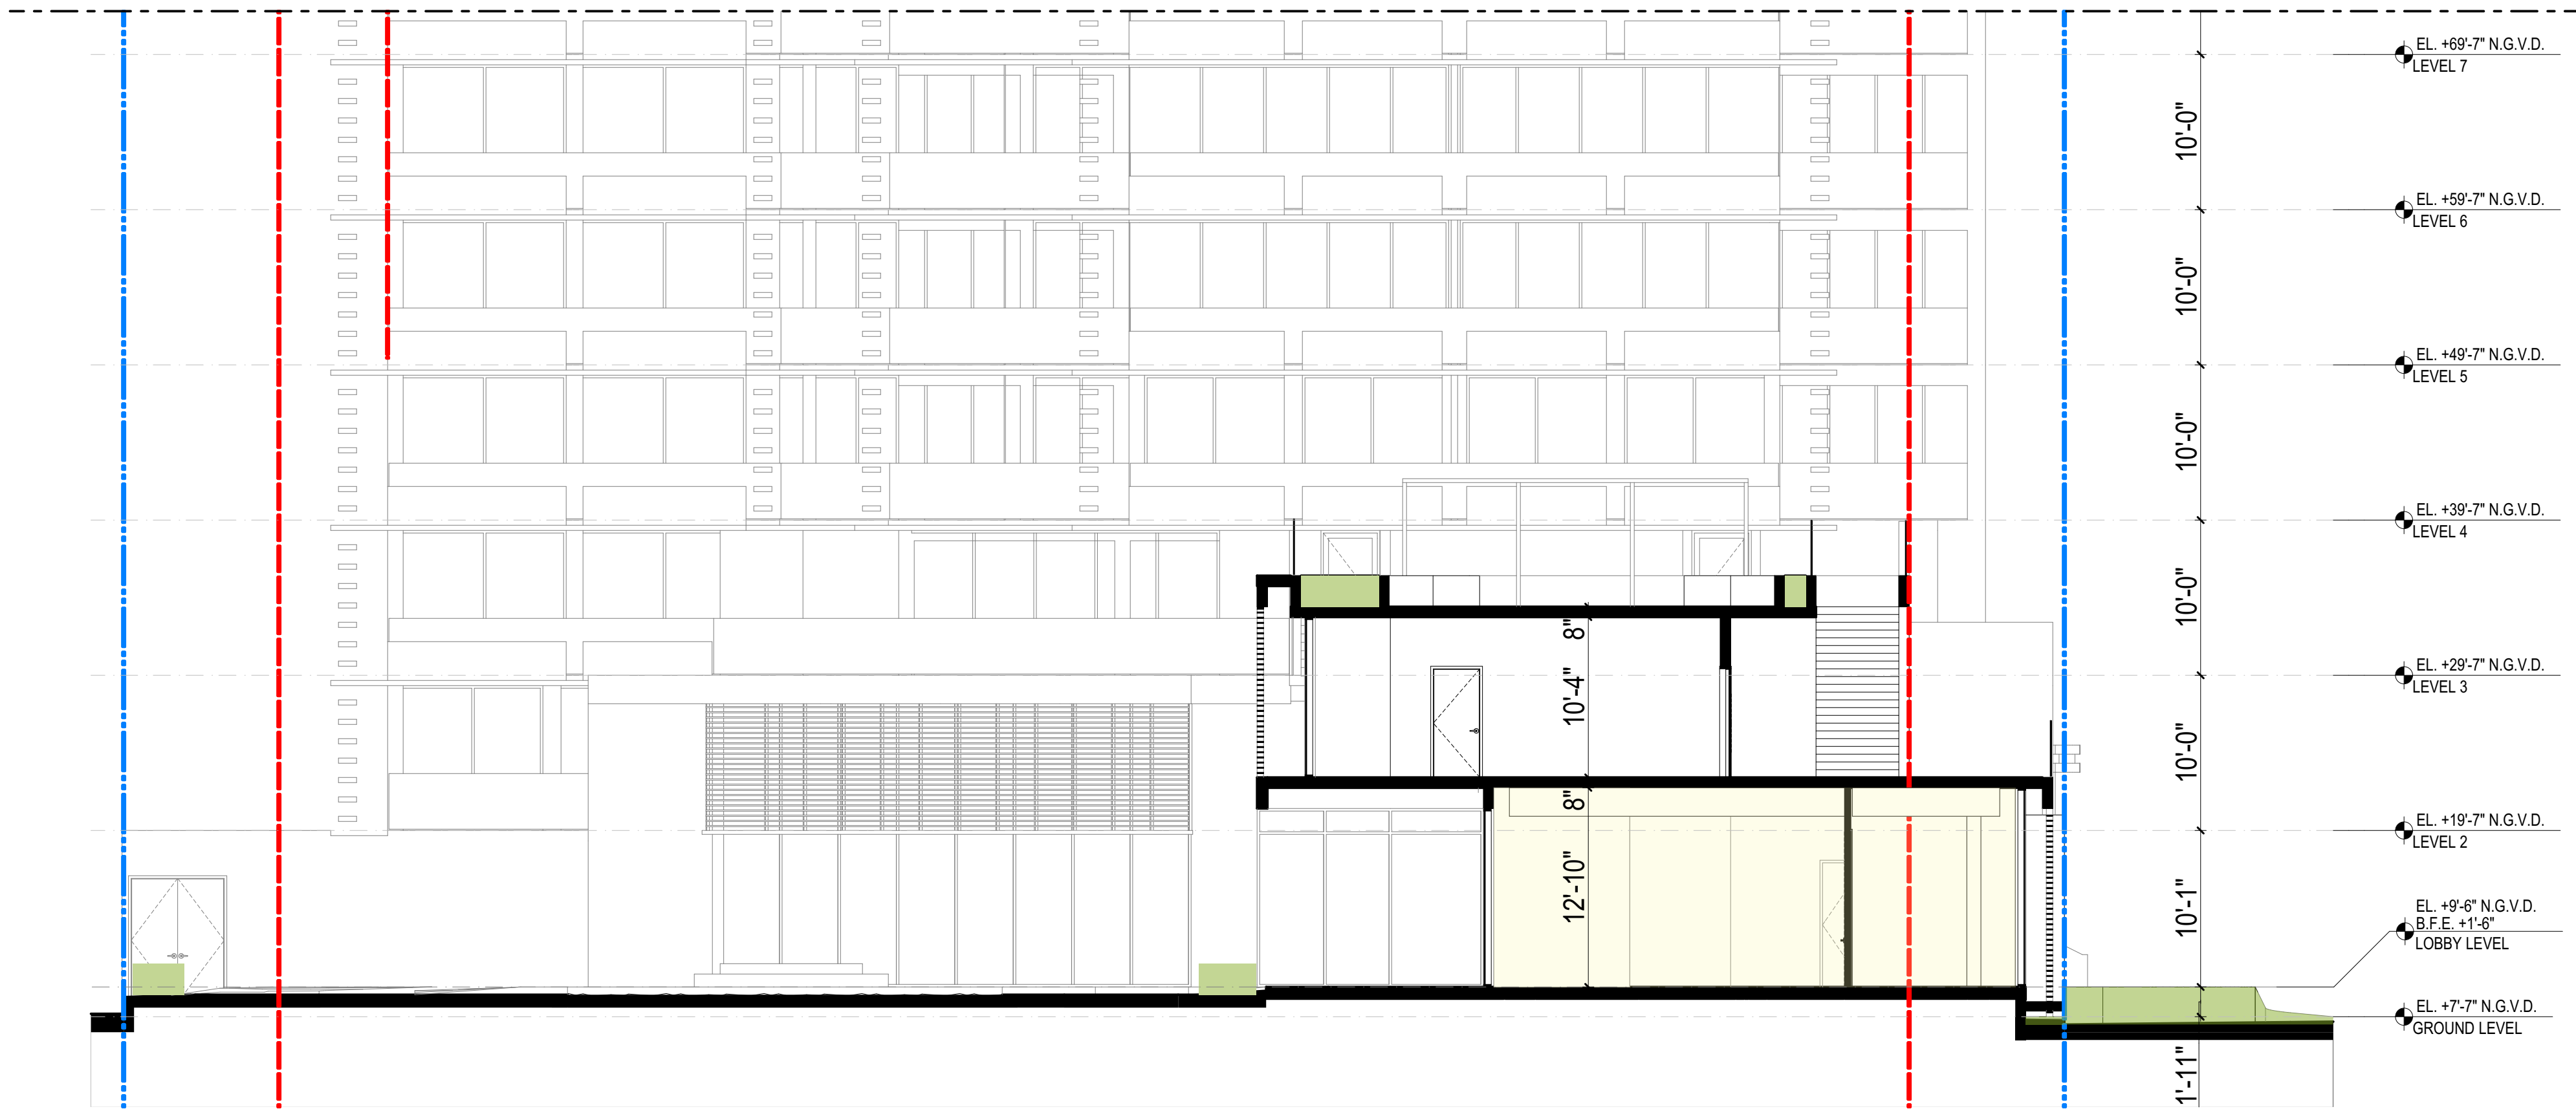

2 PROPOSED RESTAURANT - SECTION 2
SCALE: 1/8" = 1'-0"

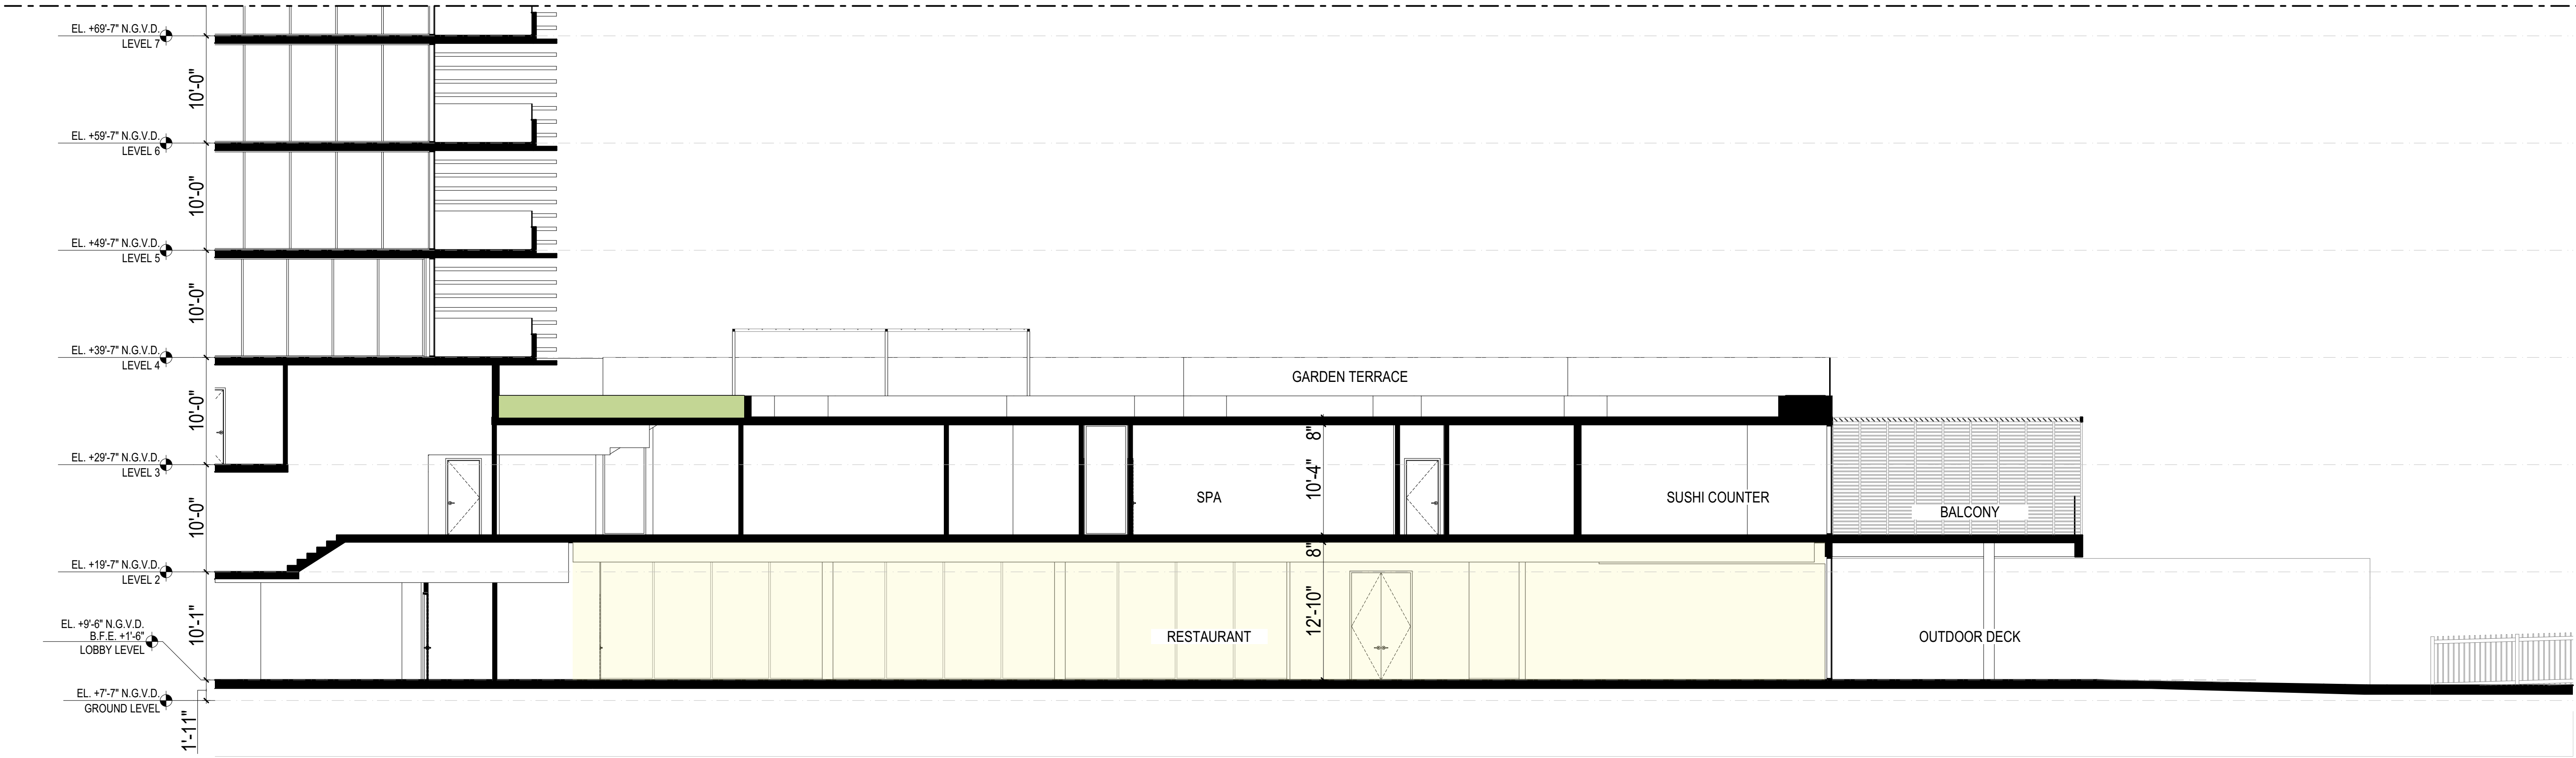

1 PROPOSED RESTAURANT - SECTION 1
SCALE: 1/8" = 1'-0"

revuelta
architecture
international

Miami
Santiago, Chile

revuelta-architecture.com

2350 SW 27TH AVE
SUITE 110
MIAMI, FL 33135
T: 305.590.5000
F: 305.590.5040

DESIGN ARCHITECT

CITTERIO-VIEL
& PARTNERS

Project

**BVLGARI HOTEL
MIAMI BEACH**
100 21st STREET
MIAMI BEACH, FL 33139

Revisions

Owner Information

BHI Miami Limited Corp.
1521 Alton Rd.
Suite 403
Miami Beach, FL 33139
(786) 785-6504

Consultant

Luis O. Revuelta

AR-007972

HPB SET

Date

03/05/2021

Scale

AS SHOWN

Project No.

2005

Sheet Name

PROPOSED RESTAURANT SECTIONS

Sheet No.

A-206

These Design And Drawings Are The Copyrighted Property Of Revuelta Architecture International, P.A. and May Not Be Reproduced Except with Specific Written Consent of the Architect.
The Contractor Must Check And Verify All Dimensions Of The Job And Be Responsible For Same. Reporting Any Discrepancies To The Architects Before Commencing work. Drawings Not to be Scaled.
This Blueprint Shall Be Used For ARCHITECTURAL PURPOSES ONLY. By Approval: Date: 3/5/2021

NOT FOR CONSTRUCTION

D

C

B

A

D

revuelta
architecture
international



Miami
Santiago, Chile

revuelta-architecture.com

2950 SW 27TH AVE
SUITE 110
MIAMI, FL 33135
T: 305.590.5000
F: 305.590.5040

DESIGN ARCHITECT

CITTERIO-VIEL
& PARTNERS

Project

BVLGARI HOTEL
MIAMI BEACH

100 21st STREET
MIAMI BEACH, FL 33139

Revisions

Owner Information

BHI Miami Limited Corp.

1521 Alton Rd.
Suite 403
Miami Beach, FL 33139
(786) 785-6504

Consultant

Luis O. Revuelta

AR-0007972

SCHEMATIC DESIGN

Date

3/5/2021

Scale

AS SHOWN


Project No.

2005

Sheet Name
PROPOSED RESTAURANT
ELEVATIONS (1/2)

Sheet No.

A-207

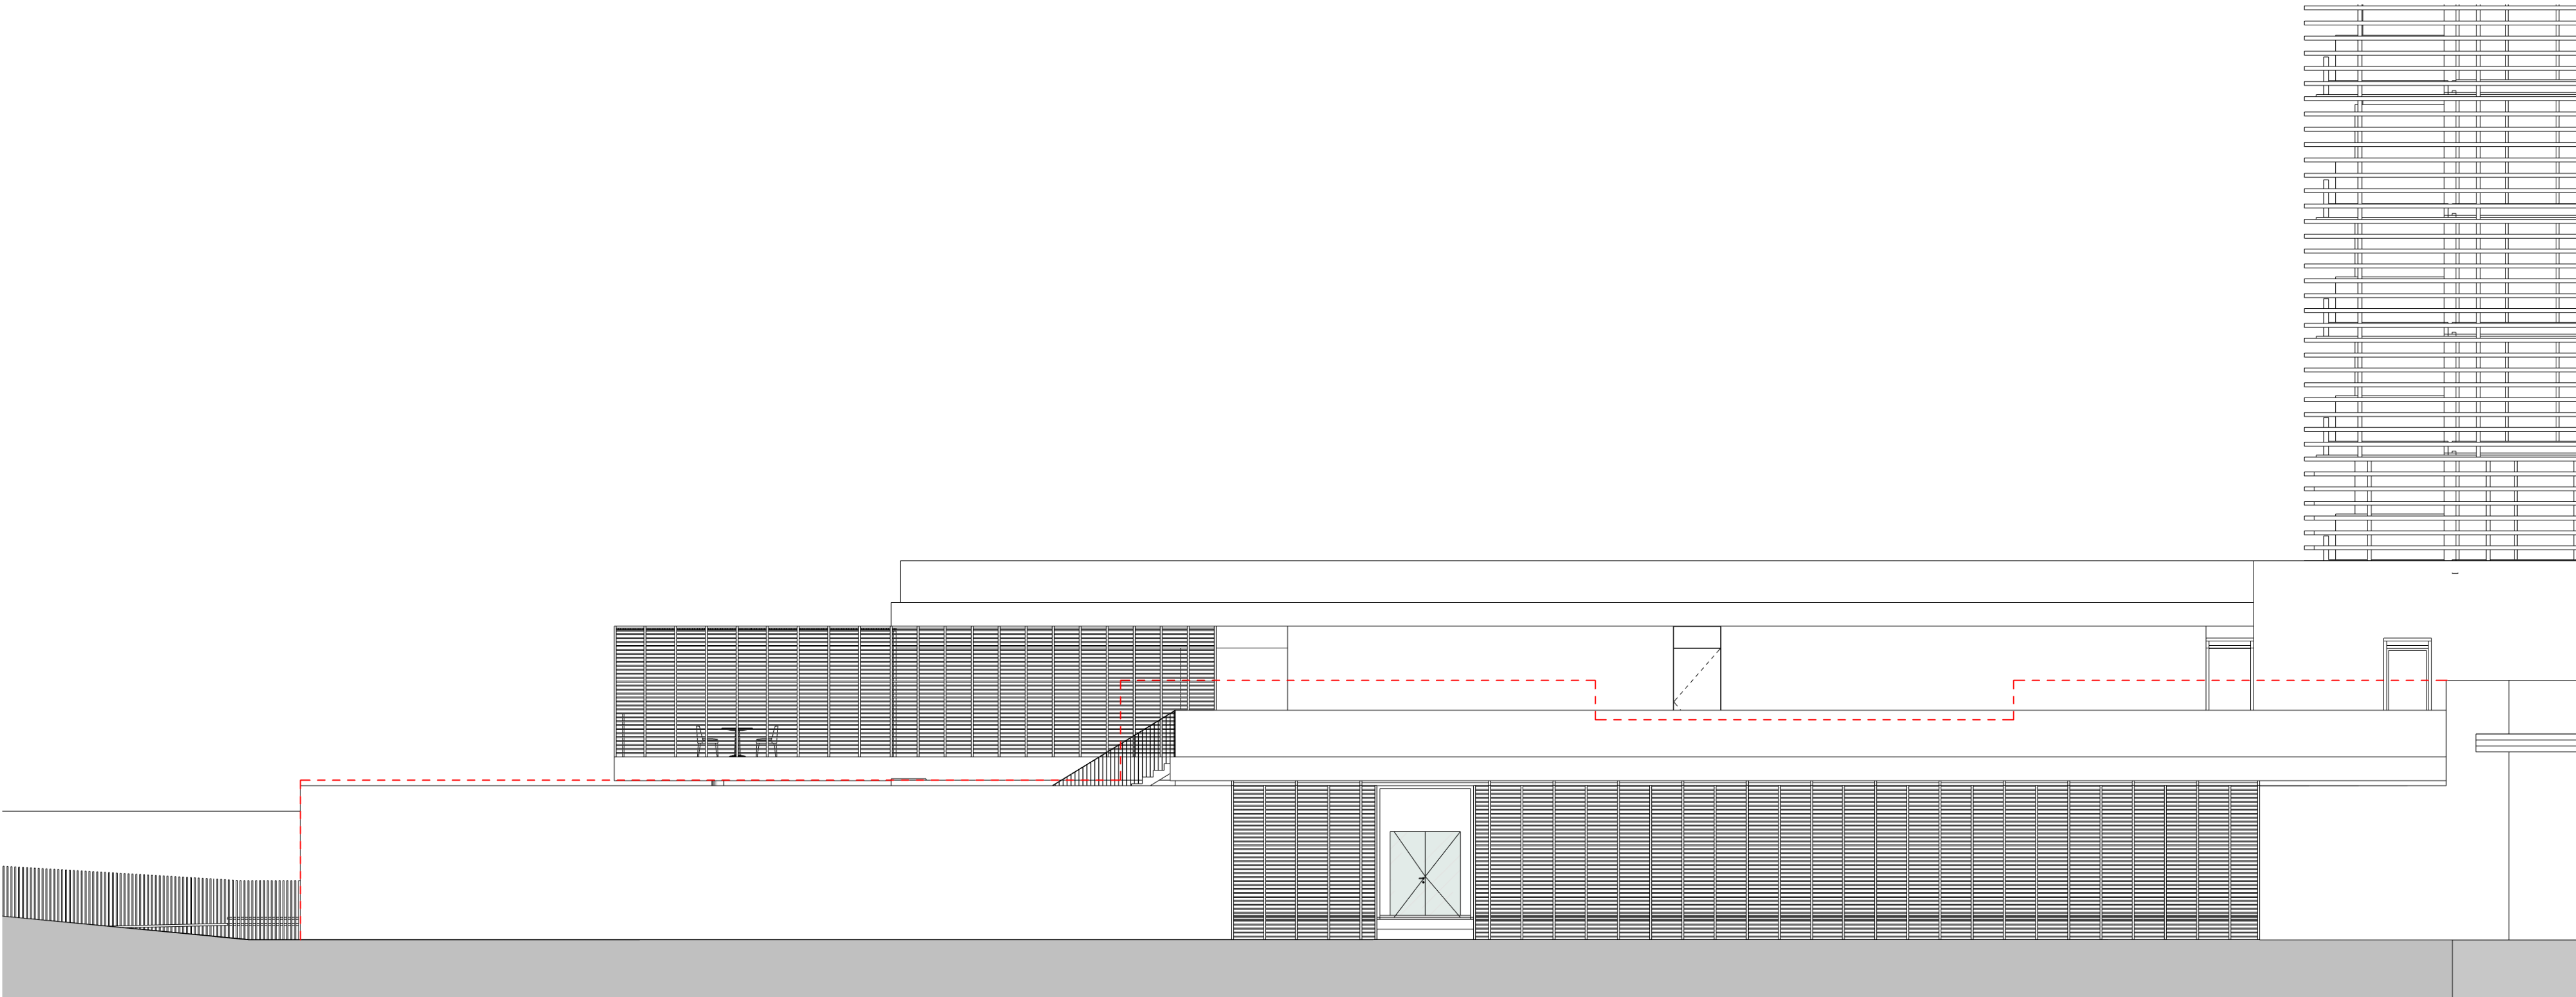

----- EXISTING WALL PROFILE

1

RESTAURANT FACADE ELEVATION

SCALE: 1/8" = 1'-0"

These Design And Drawings Are The Copyrighted Property Of Revuelta Architecture International. P.A. and May Not Be Reproduced Except with Specific Written Consent of the Architect.
The Contractor Must Check And Verify All Dimensions Of The Job And Be Responsible For Same. Reporting Any Discrepancies To The Architects Before Commencing Work. Drawings Not to be Scaled.
This Blueprint Shall Be Used For Construction Purposes Only. It Shall Not Be Used For Any Other Purpose. By Approval: Date: 3/5/2021


NOT FOR CONSTRUCTION

D


C

B

A

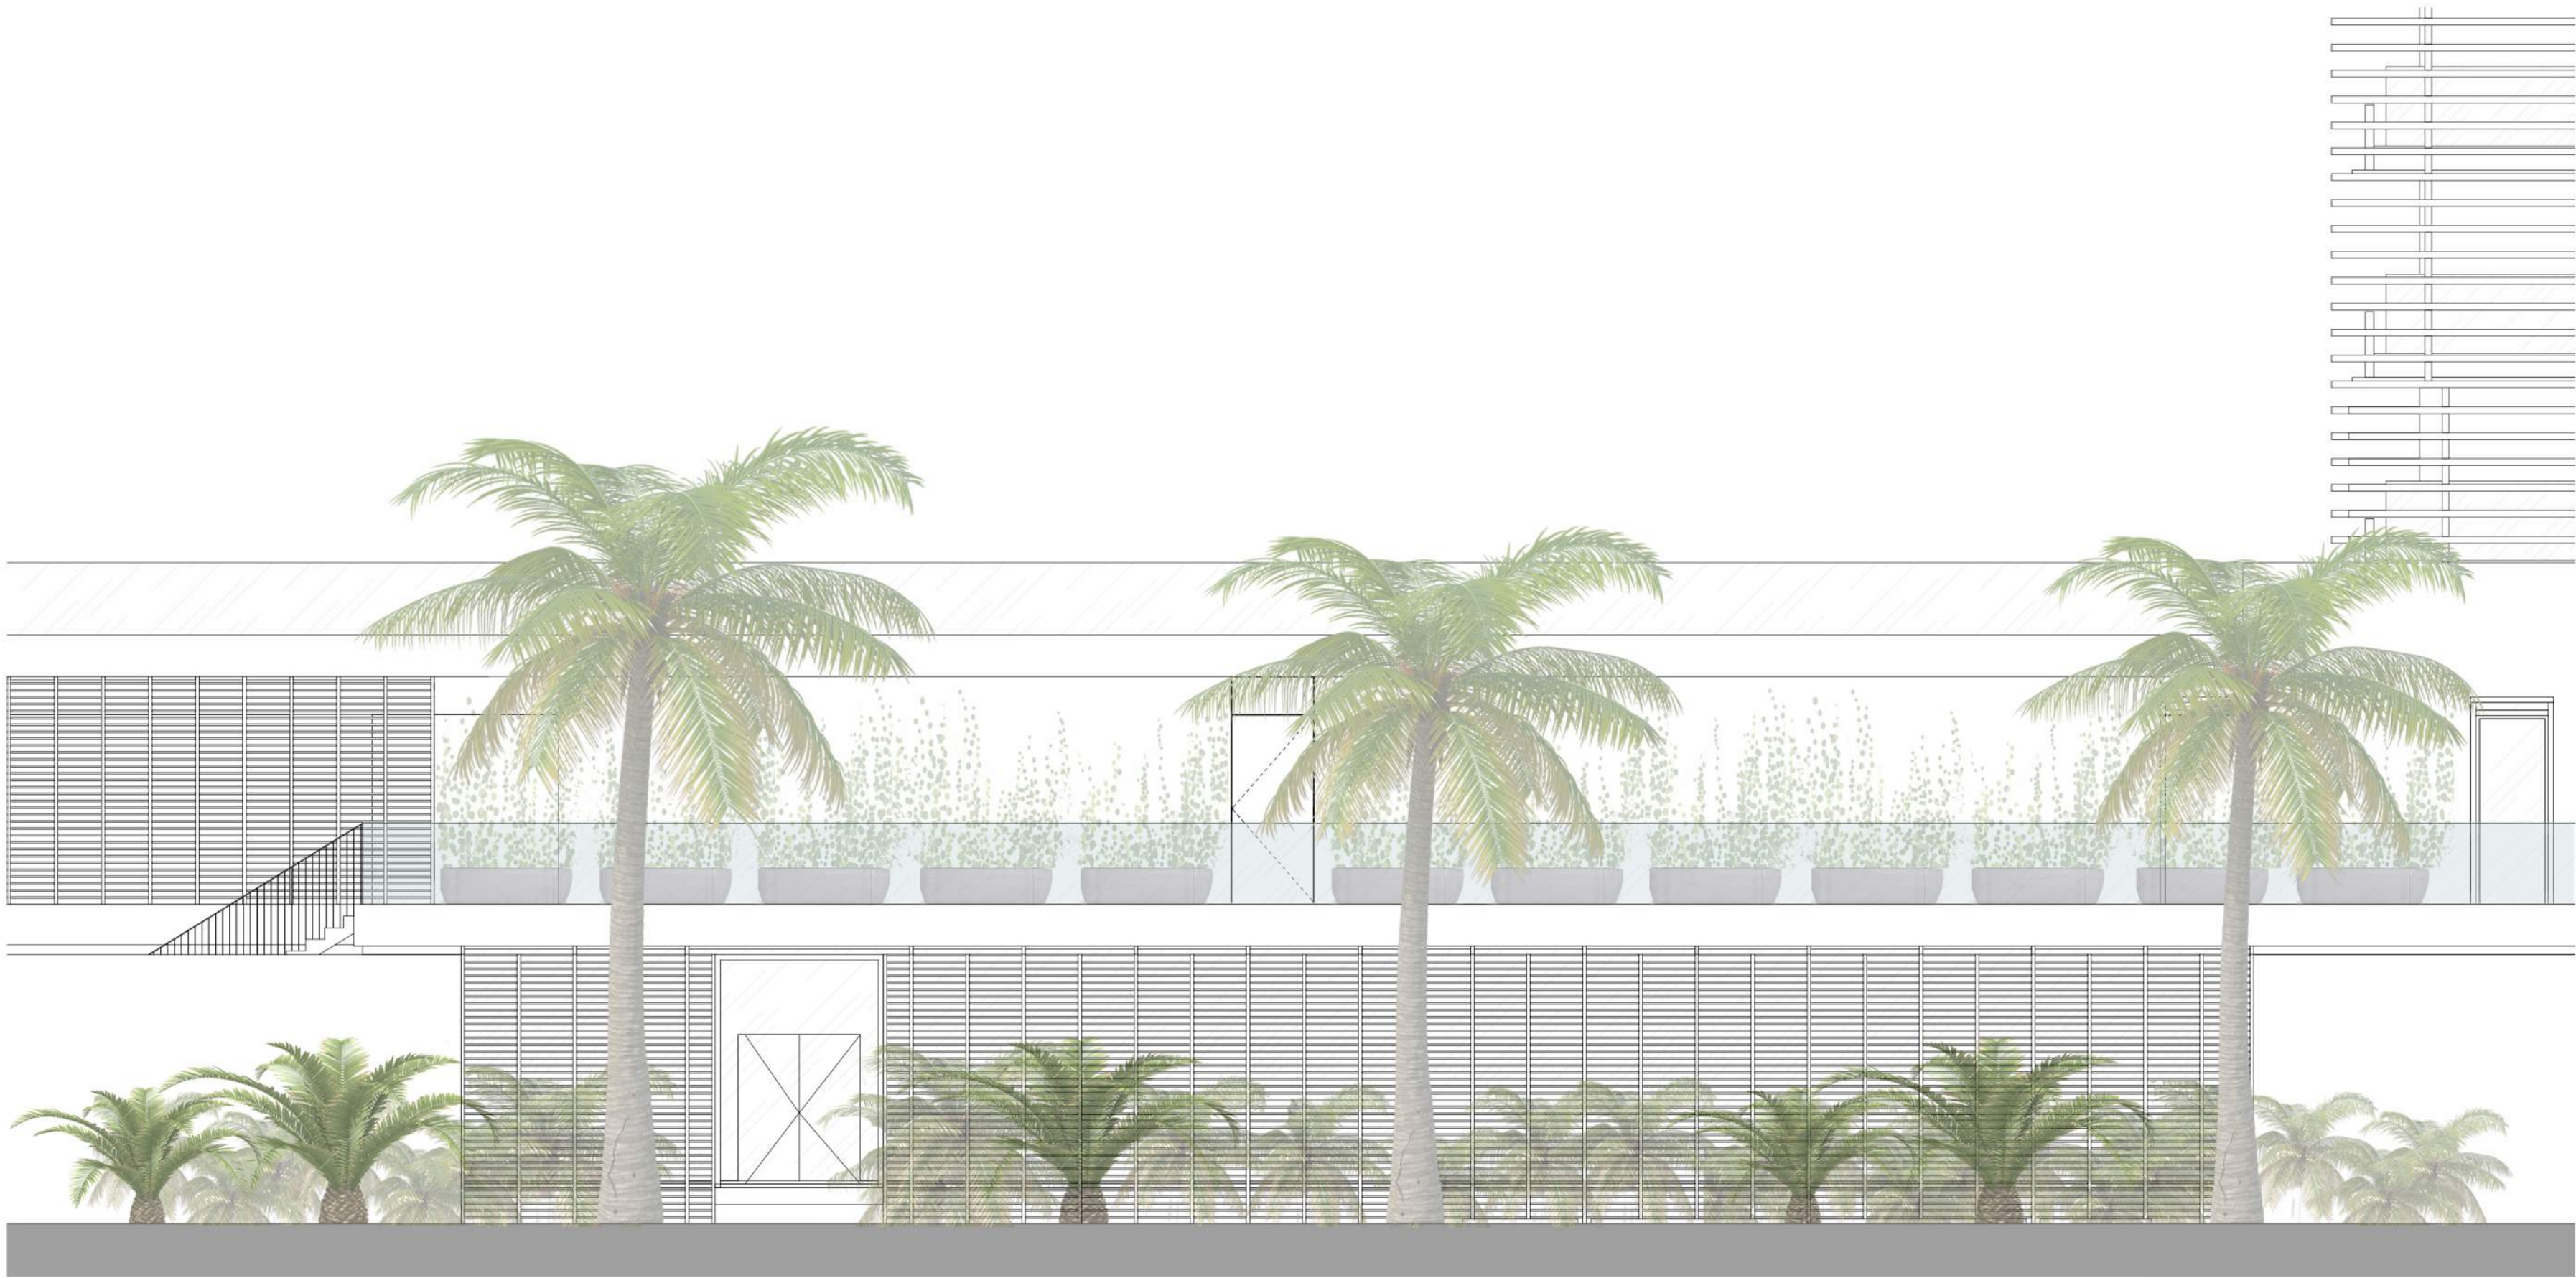

2 RESTAURANT FACADE ELEVATION
NOT TO SCALE

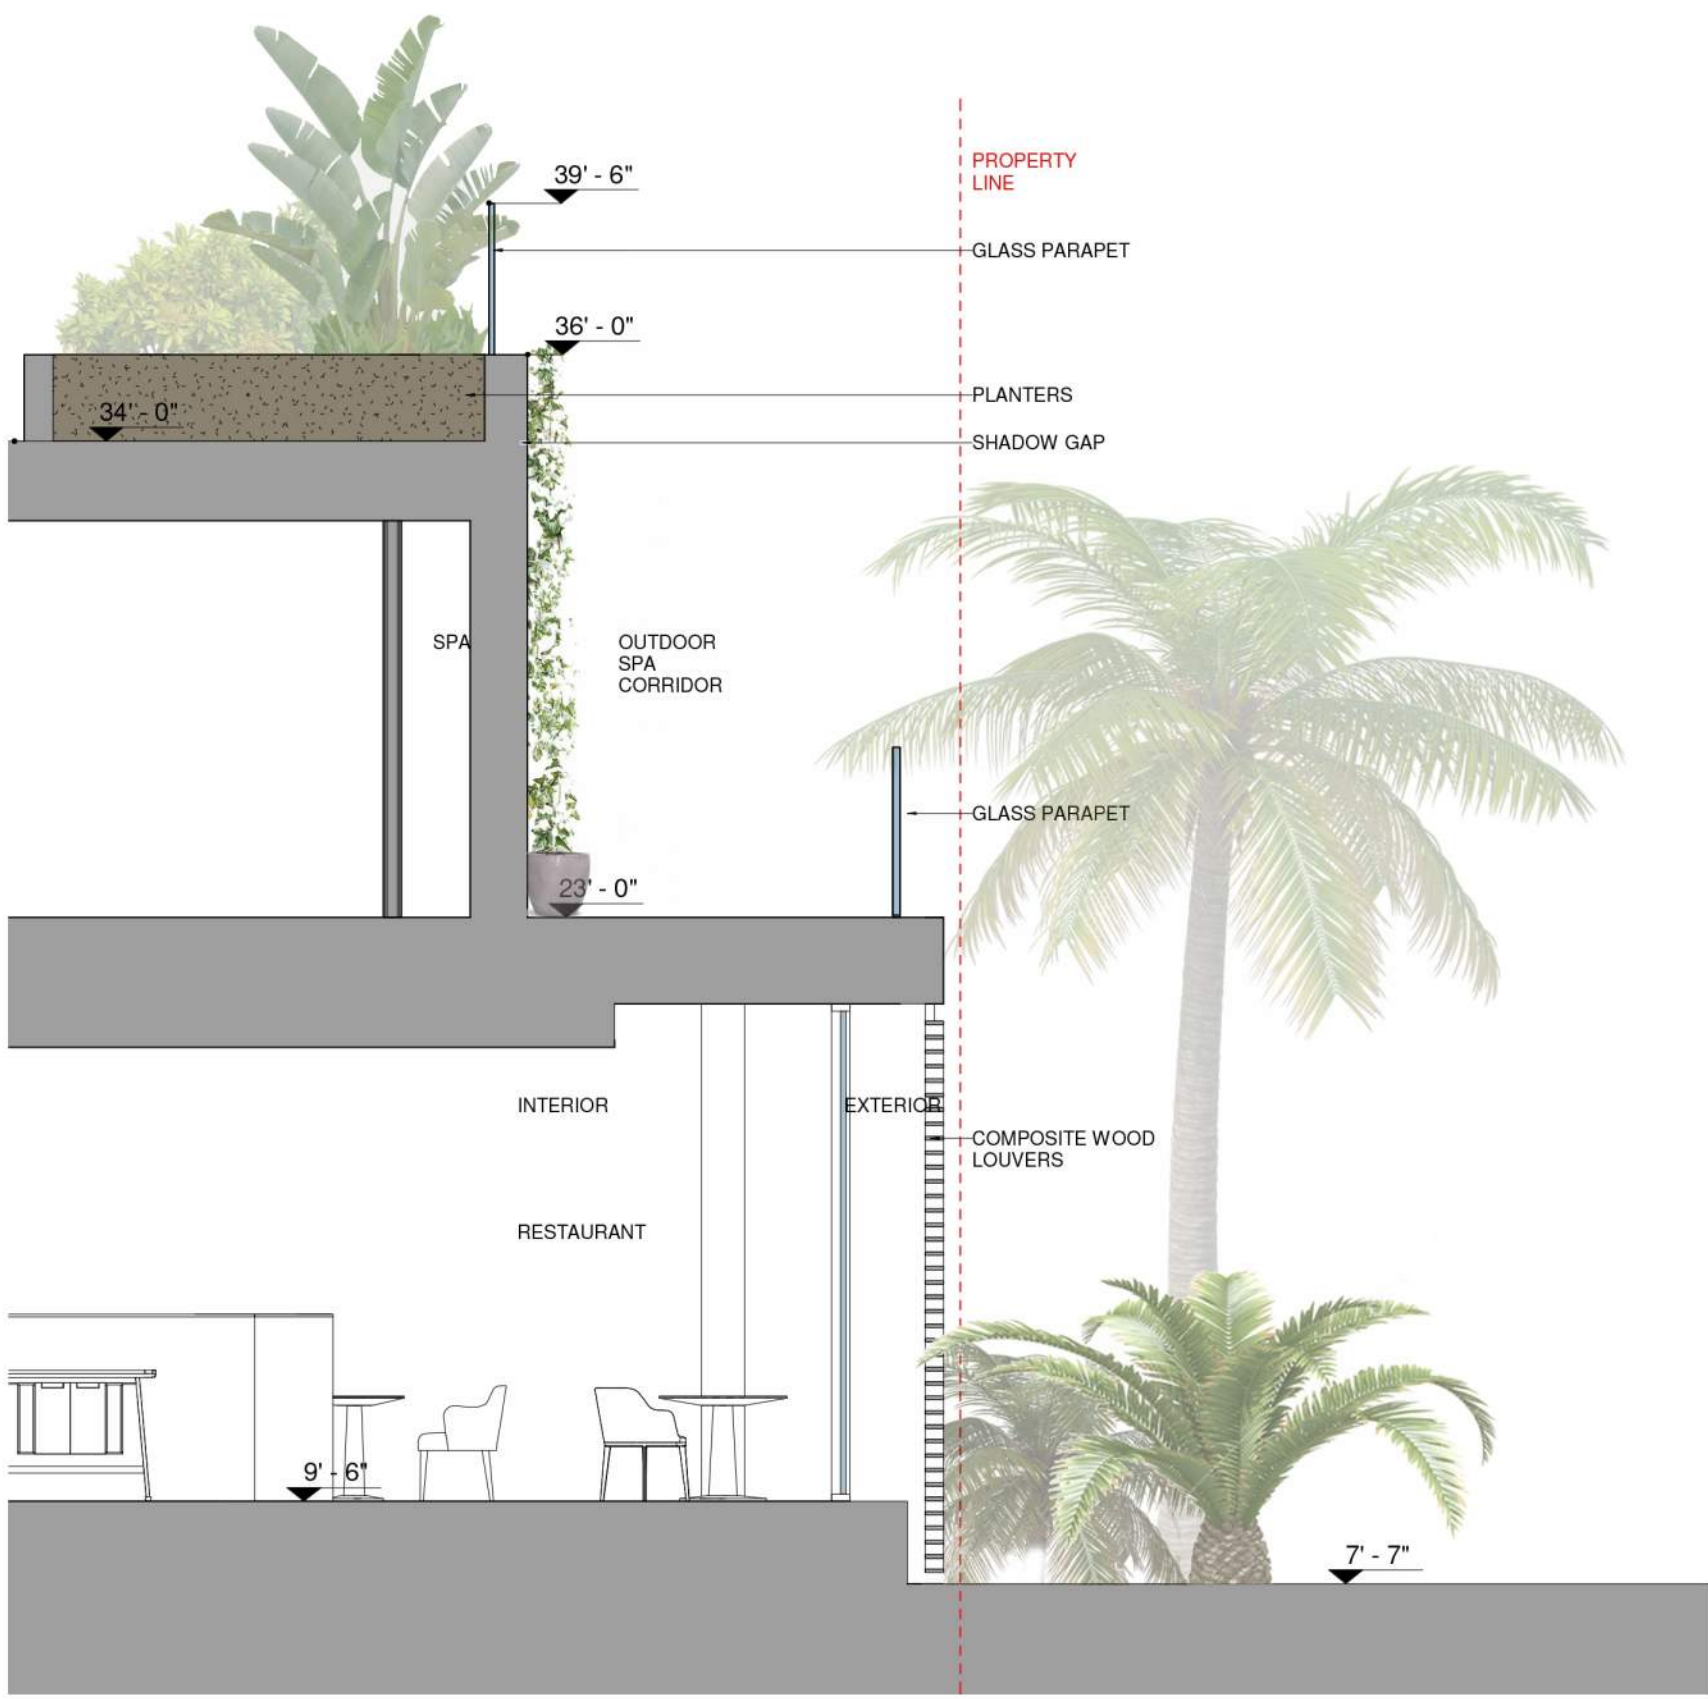

1 RESTAURANT FACADE SECTION AND IMAGE
NOT TO SCALE

revuelta
architecture
international

Miami
Santiago, Chile

revuelta-architecture.com

2350 SW 27TH AVE
SUITE 110
MIAMI, FL 33135
T: 305.590.5000
F: 305.590.5040

DESIGN ARCHITECT

CITTERIO-VIEL
& PARTNERS

Project

**BVLGARI HOTEL
MIAMI BEACH**
100 21st STREET
MIAMI BEACH, FL 33139

Revisions

Owner Information

BHI Miami Limited Corp.
1521 Alton Rd.
Suite 403
Miami Beach, FL 33139
(786) 785-6504

Consultant

Luis O. Revuelta

AR-007972

SCHEMATIC DESIGN

Date

3/5/2021

Scale

AS SHOWN

Project No.

2005

Sheet Name
PROPOSED RESTAURANT
ELEVATIONS (22)

Sheet No.

A-208

These Design And Drawings Are The Copyrighted Property Of Revuelta Architecture International P.A. and May Not Be Reproduced Except with Specific Written Consent of the Architect.
The Contractor Must Check And Verify All Dimensions Of The Job And Be Responsible For Same. Reporting Any Discrepancies To The Architects Before Commencing Work. Drawings Not to be Scaled.
This Blueprint Shall Be Used For ARCHITECTURAL PURPOSES ONLY. It Shall Not Be Used For ANY OTHER PURPOSE. By Approval: Date: 3/5/2021