




	TENSIONED CURTAIN ELITE SCREEN TE 135 HW2
	PROJECTOR LASER OPTOMA ZH 406ST
	TV LG 55"
	J-BOX FOR RGB VIDEO SYSTEM
	RECEPTACLE 110v

TYPE OF SPEAKER	MODEL	COVERAGE
 ACTIVE Line Array	QSC KLA-12	 90°
 ACTIVE Cardioid Subwoofer	QSC KS-12C	 180°
 ACTIVE Subwoofer	QSC KS-12	 360°
 PASSIVE Full Range	QSC E-112	 85°
 ACTIVE Full Range	QSC CP-8	 90°
 PASSIVE Subwoofer	QSC AD-P-SUB	 360°
 PASSIVE Full Range	QSC AD-P-SAT	 360°


 CABLE DATA OUTLET 24V 40A 2-12' OUTLET BOX
FOR HEIGHT MOUNTED REFER TO SOUND TECHNICIAN DRAWINGS.

	TENSIONED CURTAIN ELITE SCREEN TE 135 HW2
	PROJECTOR LASER OPTOMA ZH 406ST
	TV LG 55"
	J-BOX FOR RGB VIDEO SYSTEM
	RECEPTACLE 110v

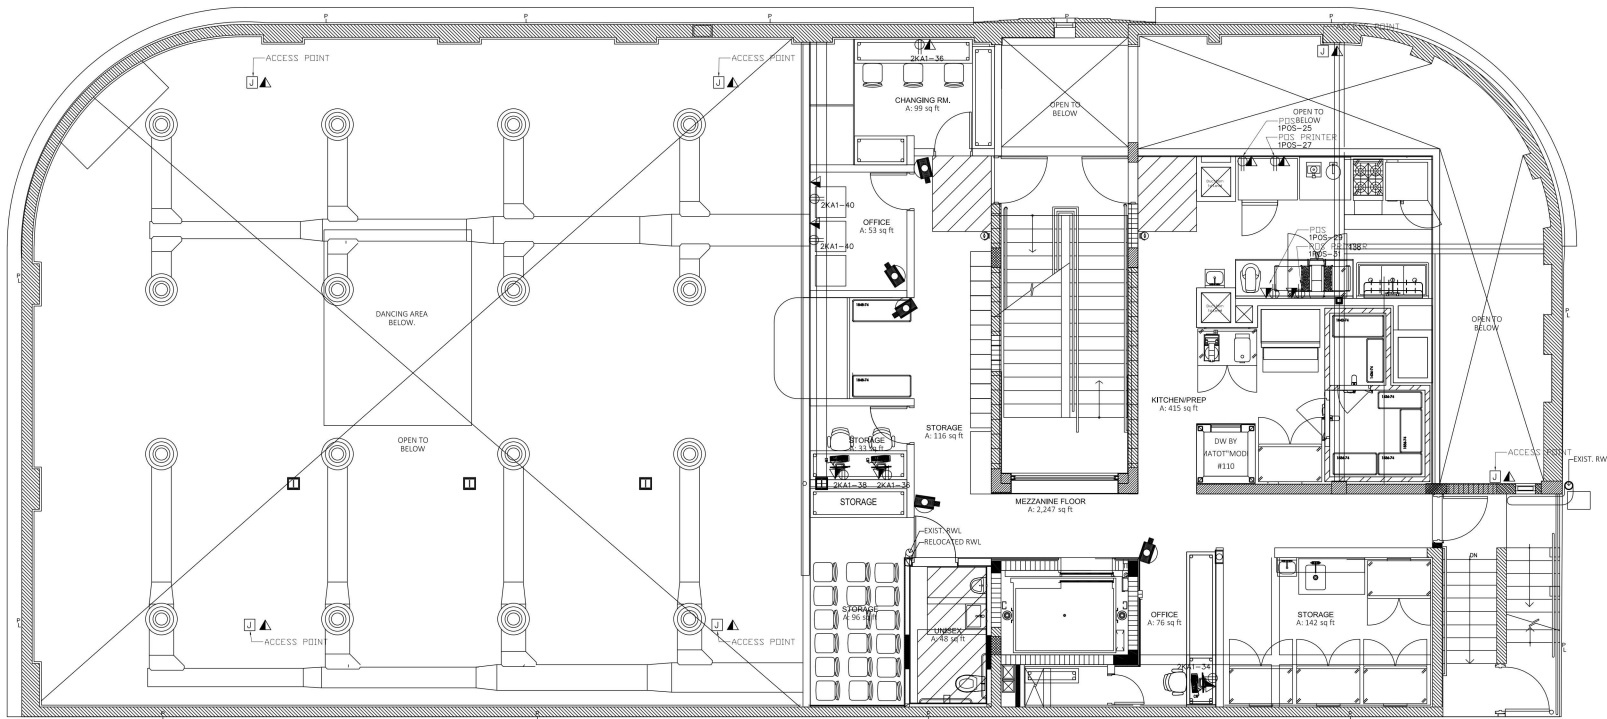

E VIDEO & SOUND AND POS / PRINTERS (WALL AND CEILING MOUNTED) MEZZANINE FLOOR PLAN

SCALE: 1/4" = 1'-0"

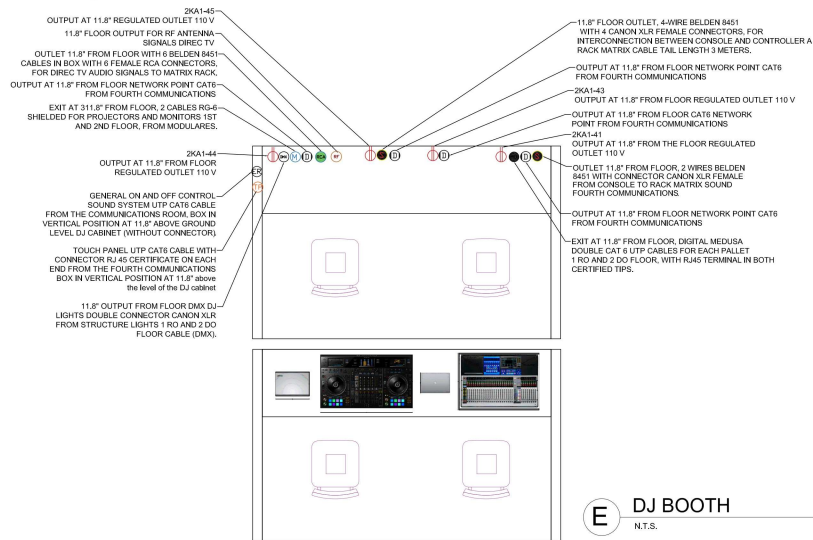

VIDEO SYSTEM SYMBOLS

	TENSIONED CURTAIN ELITE SCREEN TE 135 HW2
	PROJECTOR LASER OPTOMA ZH 406ST
	TV LG 50"
	JBOX FOR RISE VIDEO SYSTEM
	RECEPTACLE 10V

SECURITY SYSTEM SYMBOLS

SYMBOLS	
	CCTV
	DATA
	ELECTRICAL RECEPTACLE (normal 110V)
	ELECTRICAL RECEPTACLE DEDICATED
	CHAUVET Rogue r16b
	CHAUVET Intimidator spot 360

SPEAKER SYSTEM SYMBOLS

TYPE OF SPEAKER	MODEL	COVERAGE
 ACTIVE Line Array	OSC KLA-12	 90°
 ACTIVE Cardoid Subwoofer	OSC K2-10C	 180°
 ACTIVE Subwoofer	OSC K2-112	 360°
 PASSIVE Full Range	OSC E-112	 65°
 ACTIVE Fill Range	OSC CP-8	 90°
 PASSIVE Pendant Subwoofer	OSC AD-P SUB	 360°
 PASSIVE Pendant Fill Range	OSC AD-P SAT	 360°
 CABLE & DATA OUTLET (4" x 1/2" 152" OUTLET BOX) FOR HEIGHT MOUNTED REFER TO SOUND TECHNIC DRAWINGS.		

E DJ BOOTH
N.T.S.



OWNER:
LINCOLN DREXEL, LTD.
AND LINCOLN DREXEL, II
3527 ALTON ROAD #403
MIAMI BEACH, FL 33140

ARCHITECT:
FORM GROUP, INC.
4300 SW 73 AVE. #105
MIAMI, FL 33155
PH: 305-443-4244

INTERIOR DESIGNER:

KITCHEN CONSULTANT:
LACE FOOD SERVICE
10400 NW 20TH STREET,
MIAMI, FL 33172
PH: 305-513-6223

MEP ENGINEER:
LAUREDO ENGINEERING
COMPANY
1605 DREXEL AVENUE
SUITE 100
MIAMI BEACH, FL 33139
E-MAIL: info@laredo.com

STRUCTURAL ENGINEER:

INTERIOR TENANT BUILT-OUT FOR:

ANDRÉS
CARNE DE RES


LINCOLN DREXEL BUILDING
1605 DREXEL AVENUE
MIAMI BEACH, FL 33139

REVISIONS:
1 09/30/21 B.D.C



FORM GROUP, INC.
4300 SW 73 AVE. #105, MIAMI, FL 33155
TEL: 305-443-4244 FAX: 305-443-4200
ARCHITECT OF RECORD FOR ANDRÉS CARNE DE RES

PROJECT NO.: 19-1007
DATE: 5-8-20
SCALE: AS SHOWN
TITLE: VIDEO & SOUND MEZZANINE FLOOR PLAN
DRAWING NO.: E-102.2

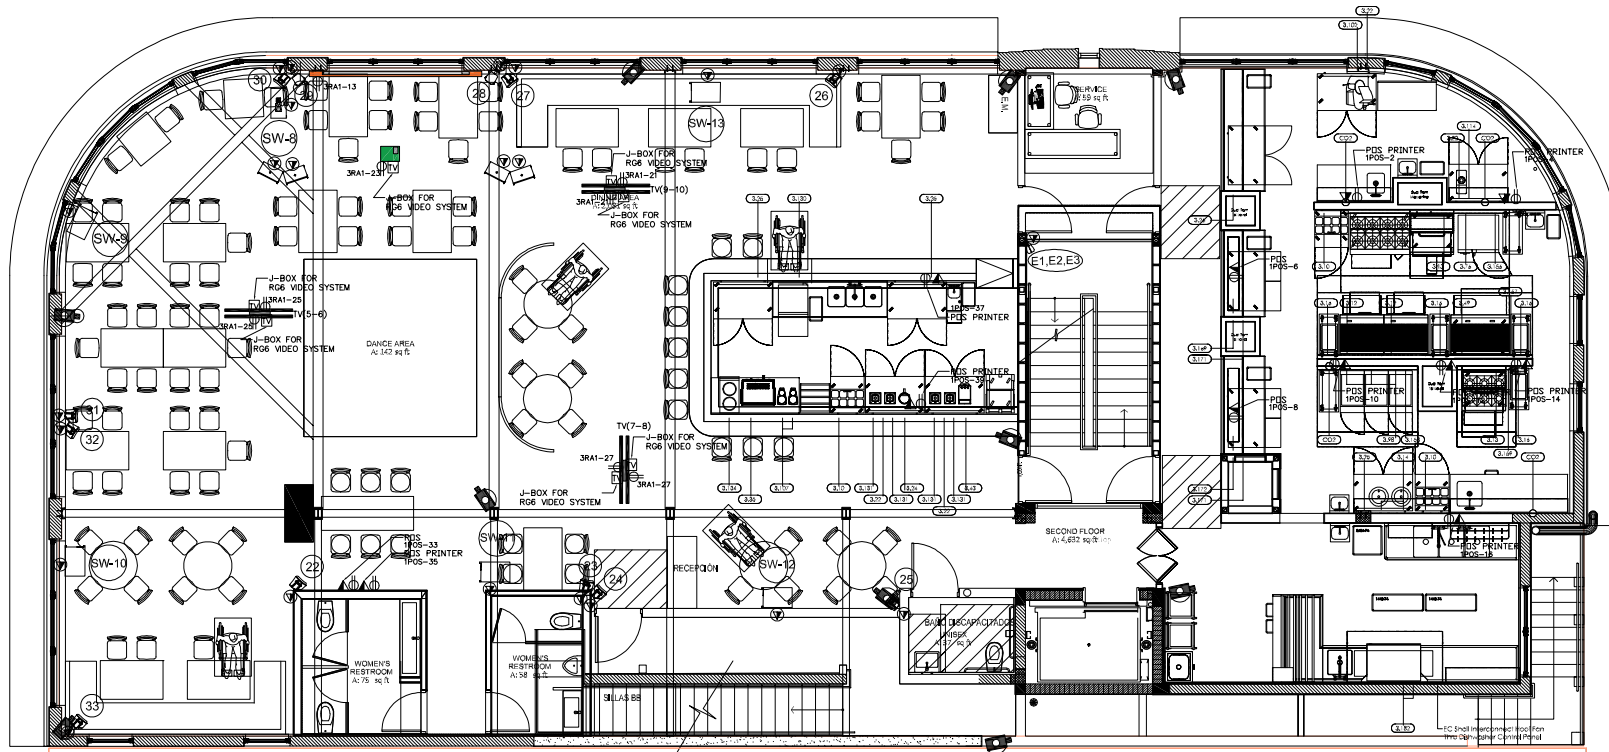

NOTES:
SEE SOUND SPEAKERS REQUIREMENTS NOTE AT SOUND/SPEAKERS DRAWINGS.

E VIDEO & SOUND AND POS / PRINTERS (WALL AND CEILING MOUNTED) POWER SECOND FLOOR PLAN
SCALE: 1/4" = 1'-0"

VIDEO SYSTEM SYMBOLS

	TENBYONES CURTAIN ELITE SCREEN TE 135 1142
	PROJECTOR LASER OPTOMA 2H 4088T
	J-BOX FOR R66 VIDEO SYSTEM
	RECEPTACLE 110V

SECURITY SYSTEM SYMBOLS

SYMBOLS	
	CCTV
	DATA
	ELECTRICAL RECEPTACLE (normal 110V)
	ELECTRICAL RECEPTACLE DEDICATED
	CHAUVET ROPER R-2
	CHAUVET INTIMIDATOR spot 385

SPEAKER SYSTEM SYMBOLS

TYPE OF SPEAKER	MODEL	COVERAGE
	QSC KL-A-12	90°
	QSC KS-212C	180°
	QSC KS-12	360°
	QSC E-112	90°
	QSC CP-8	90°
	QSC AD-P-36B	360°
	QSC AD-P-36AT	360°
	CABLE & DATA OUTLET (12" x 12" OUTLET BOX) FOR HEIGHT ADJUSTED REFER TO SOUND DRAWINGS.	



OWNER:
LINCOLN DREXEL, LTD.
AND LINCOLN DREXEL II,
3851 ALTON ROAD, SUITE 400
MIAMI BEACH, FL 33140

ARCHITECTS:
FORM GROUP INC.
4305 SW 73 AVE., #108
MIAMI, FL 33155
PH: 305-443-4244

INTERIOR DESIGNER:

INTERIOR CONSULTANT:
LACE FOOD SERVICE
1540 NW 20TH STREET,
MIAMI, FL 33172
PH: 305-613-6223

MEP ENGINEER:
LAUREDO ENGINEERING
COMPANY
2000 N.W. 10TH AVE., SUITE 100
MIAMI, FL 33136
PH: 305-581-1111

STRUCTURAL ENGINEER:

INTERIOR TENANT BUILT-OUT FOR:

**ANDRÉS
CARNE DE RES**

LINCOLN DREXEL BUILDING
1650 DREXEL AVENUE
MIAMI BEACH, FL 33139

DATE: 09/30/21 BY: B.D.C.



FORMGROUP
architecture . planning

FORM GROUP, INC.
4305 SW 73 AVE., SUITE 108, MIAMI, FL 33155
TEL: 305-443-4244 FAX: 305-443-4245
ARCHITECT OF RECORD

PROJECT NO.: 19-1007
DATE: 5-8-20
SCALE: AS SHOWN
TITLE: VIDEO & SOUND / SECOND FLOOR PLAN
DRAWING NO.: E-103.2



SCALE: 1/4" = 1'-0"

	TENSIONED CURTAIN ELITE SCREEN E 136 HXW2
	PROJECTOR LASER OPTOMA ZH 408ST
	TV LG 55"
	J-BOX FOR RG6 VIDEO SYSTEM
	RECEPTORI E 110

SYMBOLS	
	CCTV
	DATA
	ELECTRICAL RECEPTACLE (normal 110V)
	ELECTRICAL RECEPTACLE DEDICATE

	CHAUVET Rogue 4fx-b
	CHAUVET Intimidator spot S80

TYPE OF SPEAKER	MODEL	COVERAGE
PASSIVE Line Array	QSC KLA-12	0°
ACTIVE Cardioid Subwoofer	QSC KS-70C	180°
ACTIVE Subwoofer	QSC KS-12	360°
PASSIVE Full Range	QSC E-12	60°
ACTIVE Full Range	QSC E-8	90°
PASSIVE Shaped Subwoofer	QSC AD-P-Sub	360°
PASSIVE Shaped Full Range	QSC AP-P-SAT	360°

 CABLE & DATA RACKS AT 1200 TO 1500 LB (544 TO 680 KG)
 FOR HEIGHT ADJUSTED, REFER TO SCENE TECHNICIAN DRAWINGS.

