

**E VIDEO & SOUND AND POS / PRINTERS ( WALL AND CEILING MOUNTED) GROUND FLOOR PLAN**  
 SCALE: 1/4" = 1'-0"

NOTES:  
 - SEE SOUND SPEAKERS REQUIREMENTS NOTE AT SOUND/SPEAKERS DRAWINGS.

SECURITY SYSTEM SYMBOLS


SYMBOLS	DESCRIPTION
	CCTV
	DATA
	ELECTRICAL RECEPTACLE (normal 110V)
	ELECTRICAL RECEPTACLE DEDICATE
	CHAUVET Rogar rfi-8
	CHAUVET Intimidator spot 300

SPEAKER SYSTEM SYMBOLS

TYPE OF SPEAKER	MODEL	COVERAGE
ACTIVE Line Array	QSC K1-A-12	90°
ACTIVE Cardoid Subwoofer	QSC KS-212C	180°
ACTIVE Subwoofer	QSC KS-112	360°
PASSIVE Full Range	QSC E-112	80°
ACTIVE Full Range	QSC CP-8	90°
PASSIVE Pendant Subwoofer	QSC ADP-SUB	360°
PASSIVE Pendant Full Range	QSC ADP-SAT	360°

VIDEO SYSTEM SYMBOLS

	TENSIONED CURTAIN ELITE SCREEN TE 135 HWZ
	PROJECTOR LASER OPTOMA ZH 401ST
	TV LG 55"
	J-BOX FOR RGB VIDEO SYSTEM
	RECEPTACLE 110V



OWNER:  
 LINCOLN DREXEL LTD  
 AND LINCOLN DREXEL II  
 1655 ALTON ROAD A6B3  
 MIAMI BEACH, FL 33140

ARCHITECT:  
 FORM GROUP, INC  
 4200 SW 73 AVE, #108  
 MIAMI, FL 33156  
 PH: 305-443-4244

INTERIOR DESIGNER:

NOTHING CONSULTANT  
 LAJCE FOOD SERVICE  
 10490 NW 26TH STREET,  
 MIAMI, FL 33172  
 PH: 305-613-5223

MEP ENGINEER:  
 LAUREDO ENGINEERING  
 COMPANY  
 1000 N. MIAMI AVE., SUITE 100  
 MIAMI, FL 33136  
 PH: 305-375-1111  
 E-MAIL: info@le.com

STRUCTURAL ENGINEER:


---

INTERIOR TENANT BUILT-OUT FOR:

## ANDRÉS CARNE DE RES

LINCOLN DREXEL BUILDING  
 1655 DREXEL AVENUE  
 MIAMI BEACH, FL 33139

REVISIONS:  
 1. 09/30/21 B.D.C






FORM GROUP, INC.  
 4200 SW 73 AVE, SUITE 108, MIAMI, FL 33156  
 TEL: 305-443-4244 FAX: 305-443-0300  
 ARCHITECTS OF RECORD


PROJECT NO. 15-1037 TITLE: VIDEO & SOUND GROUND FLOOR PLAN  
 DATE: 3-8-20  
 DRAWN BY: AS SHOWN

E-101.2

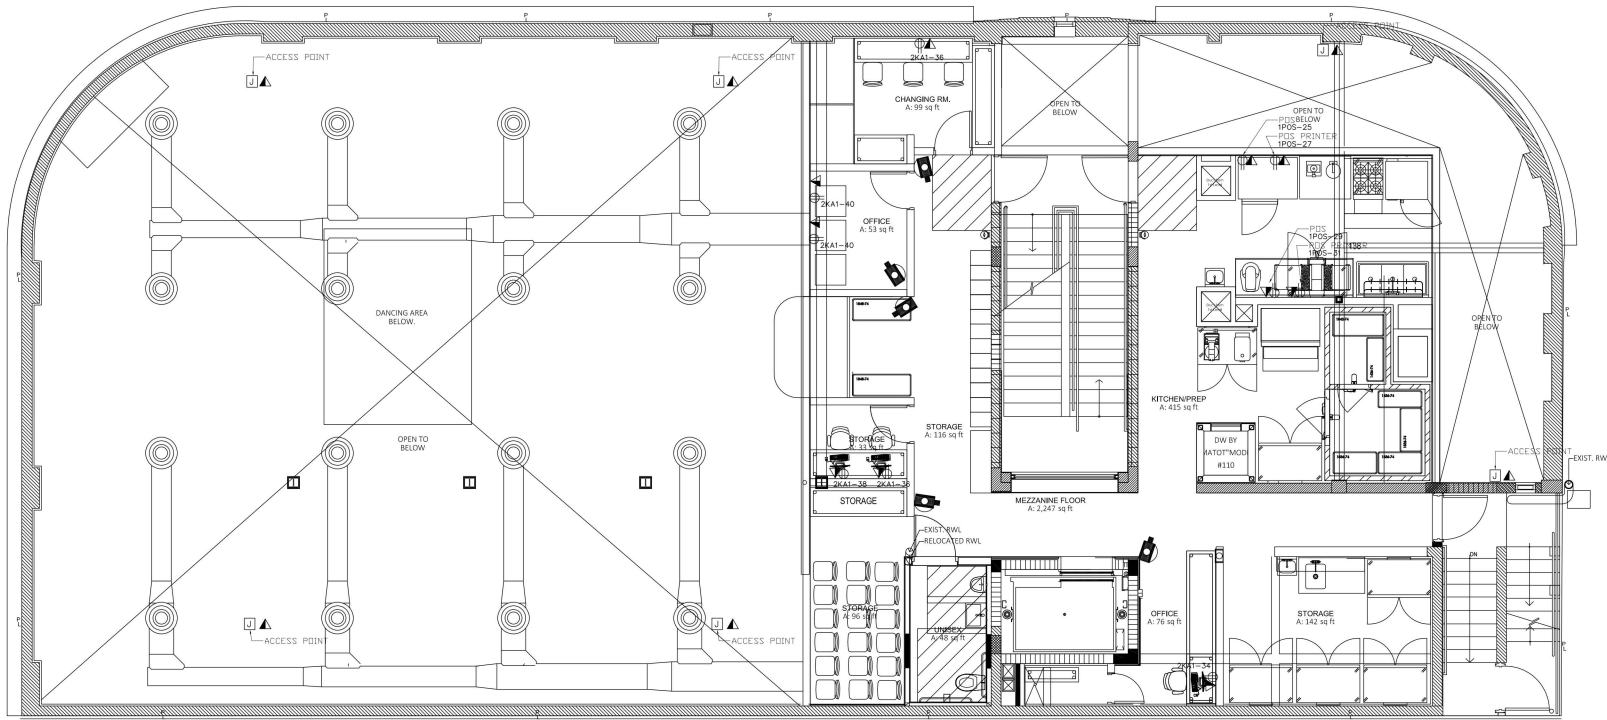

**E VIDEO & SOUND AND POS / PRINTERS ( WALL AND CEILING MOUNTED) MEZZANINE FLOOR PLAN**

SCALE: 1/4" = 1'-0"

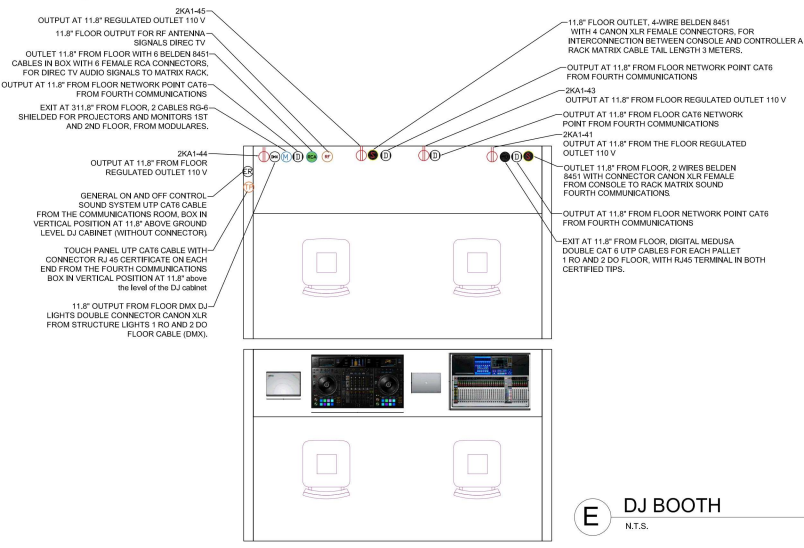

**VIDEO SYSTEM SYMBOLS**

	TENSIONED CURTAIN ELITE SCREEN TE 135 Hx2
	PROJECTOR LASER OPTOMA D1-406ST
	TV LG 55"
	JBOX FOR RSE VIDEO SYSTEM
	RECEPTACLE 110V

**SECURITY SYSTEM SYMBOLS**

	CCTV
	DATA
	ELECTRICAL RECEPTACLE (normal 110V)
	ELECTRICAL RECEPTACLE DEDICATE

**SPEAKER SYSTEM SYMBOLS**

TYPE OF SPEAKER	MODEL	COVERAGE
	OSC KLA-12	90°
	OSC KS-210C	180°
	OSC KS-112	360°
	OSC E-112	90°
	OSC CP-8	90°
	OSC AD-P-SUB	360°
	OSC AD-P-SAT	360°

**E DJ BOOTH**  
N.T.S.



OWNER:  
LINCOLN DREXEL II, LTD  
1502 ALTON ROAD #803  
MIAMI BEACH, FL 33140

ARCHITECT:  
FORM GROUP, INC  
4300 SW 73 AVE #100  
MIAMI, FL 33155  
PH: 305-443-4244

INTERIOR DESIGNER:

KITCHEN CONSULTANT:  
LACE FOOD SERVICE  
15400 NW 28TH STREET,  
MIAMI, FL, 33172  
PH: 305-513-6223

MEP ENGINEER:  
**LAUREDO ENGINEERING**  
COMPANY  
1600 DREXEL AVENUE  
MIAMI BEACH, FL 33139  
P: 305-538-1100  
F: 305-538-1101  
E: M.E. LAUREDO@LAE.COM

STRUCTURAL ENGINEER:

INTERIOR TENANT BUILT-OUT FOR:

**ANDRÉS**  
CARNE DE RES

LINCOLN DREXEL BUILDING  
1600 DREXEL AVENUE  
MIAMI BEACH, FL 33139


REVISION:  
1 09/30/21 B.D.C



**FORMGROUP**  
architecture .planning

FORM GROUP, INC.  
1502 ALTON ROAD #803  
MIAMI BEACH, FL 33140  
ARCHITECT OF RECORD: JUAN MORALES, JAR  
02/01/2016

PROJECT NO.: 19-1007  
DATE: 5-8-20  
SCALE: AS SHOWN  
TITLE: VIDEO & SOUND MEZZANINE FLOOR PLAN  
DRAWING NO.: E-102.2

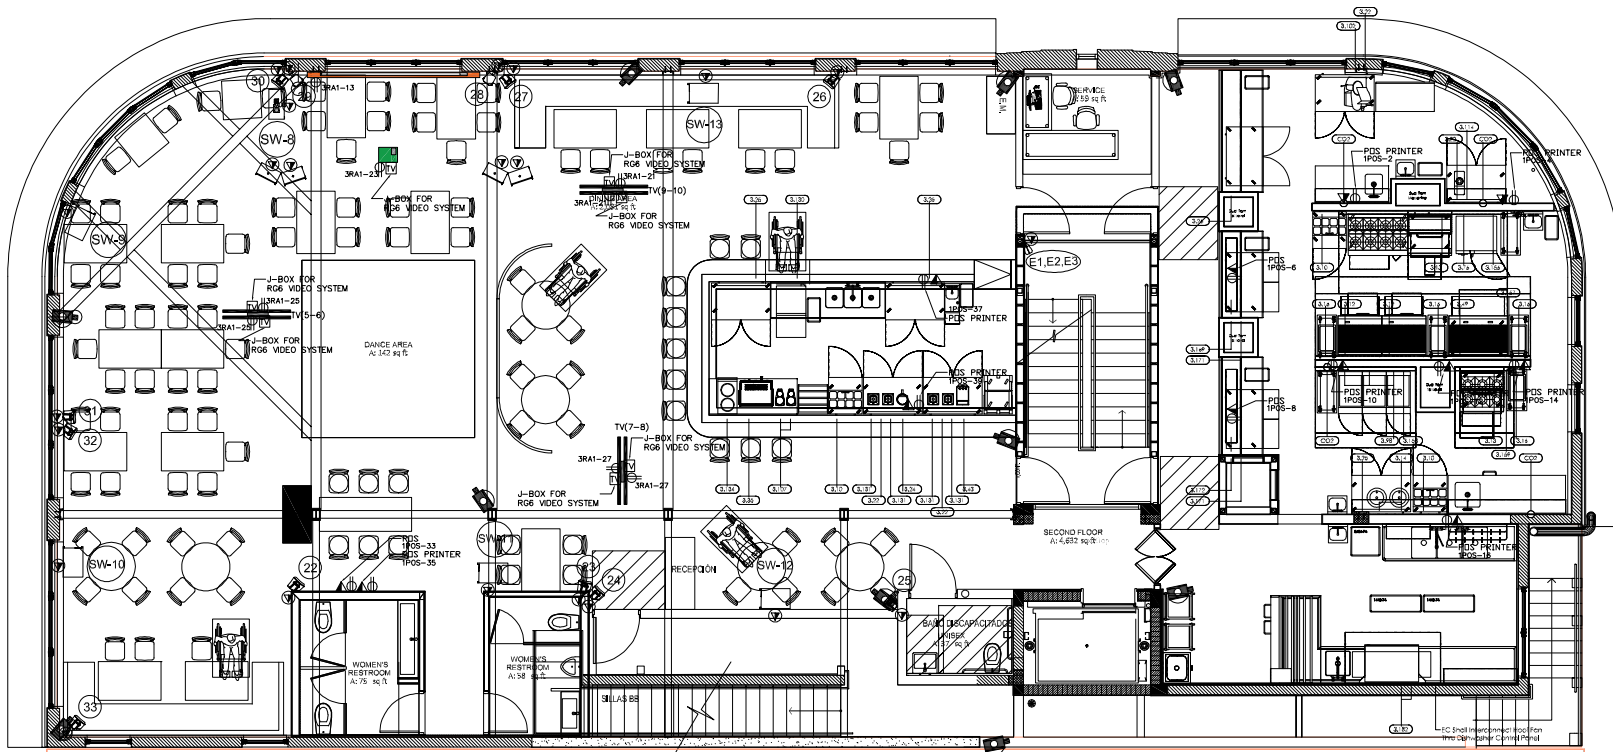

NOTE: SEE SOUND/SPEAKERS REQUIREMENTS NOTE AT SOUND/SPEAKERS DRAWINGS.

**E VIDEO & SOUND AND POS / PRINTERS ( WALL AND CEILING MOUNTED) POWER SECOND FLOOR PLAN**  
SCALE: 1/4" = 1'-0"

VIDEO SYSTEM SYMBOLS

	TENBY/EDS CURTAIN ELITE SCREEN TE 158-1112
	PROJECTOR LASER OPTOMA 2H 4085T
	TV LG 55
	J-BOX FOR R66 VIDEO SYSTEM
	RECEPTACLE 110V

SECURITY SYSTEM SYMBOLS

SYMBOLS	
	CCTV
	DATA
	ELECTRICAL RECEPTACLE (ground 110V)
	ELECTRICAL RECEPTACLE DEDICATE
	CHAUVET Spot R-0
	CHAUVET Intimidator spot 380

SPEAKER SYSTEM SYMBOLS

TYPE OF SPEAKER	MODEL	COVERAGE
	QSC KL1-A-12	90°
	QSC KS-212C	180°
	QSC KS-12	360°
	QSC E-112	90°
	QSC DP-8	90°
	QSC AD-1-SUB	360°
	QSC AD-1-P&T	360°

Ⓢ CABLE & DATA OUTLET (17" x 1/2" 1/2" OUTLET BOX)  
FOR HEIGHT INDICATED REFER TO SOUND TYPING DRAWINGS.

OWNER:  
LINCOLN DREXEL LTD  
AND LINCOLN DREXEL II  
3801 ALTON ROAD #800  
MIAMI BEACH, FL 33140

ARCHITECT:  
FORM GROUP INC  
4305 SW 73 AVE #106  
MIAMI, FL 33195  
PH: 305-443-4244

INTERIOR DESIGNER:  
LACE FOOD SERVICE  
1640 NW 29TH STREET  
MIAMI, FL 33172  
PH: 305-419-4223

MEP ENGINEER:  
LAUREDO ENGINEERING  
COMPANY  
1000 N. W. 10TH AVE  
SUITE 200  
MIAMI, FL 33136  
PH: 305-371-1111

STRUCTURAL ENGINEER:

---

INTERIOR TENANT BUILT-OUT FOR:

**ANDRÉS  
CARNE DE RES**

---

LINCOLN DREXEL BUILDING  
1650 DREXEL AVENUE  
MIAMI BEACH, FL 33139

---

DATE: 09/30/21 B,D,C

**FORMGROUP**  
architecture .planning

---

FORM GROUP, INC.  
4305 SW 73 AVE, SUITE 106, MIAMI, FL 33195  
TEL: 305-443-4244 FAX: 305-443-4245  
WWW.FORMGROUP.COM


---

PROJECT NO: 19-1007  
DATE: 5-8-20  
SCALE: AS SHOWN

TITLE:  
VIDEO & SOUND  
SECOND FLOOR PLAN

DESIGNED BY: [Signature]  
DRAWN BY: [Signature]

**E-103.2**

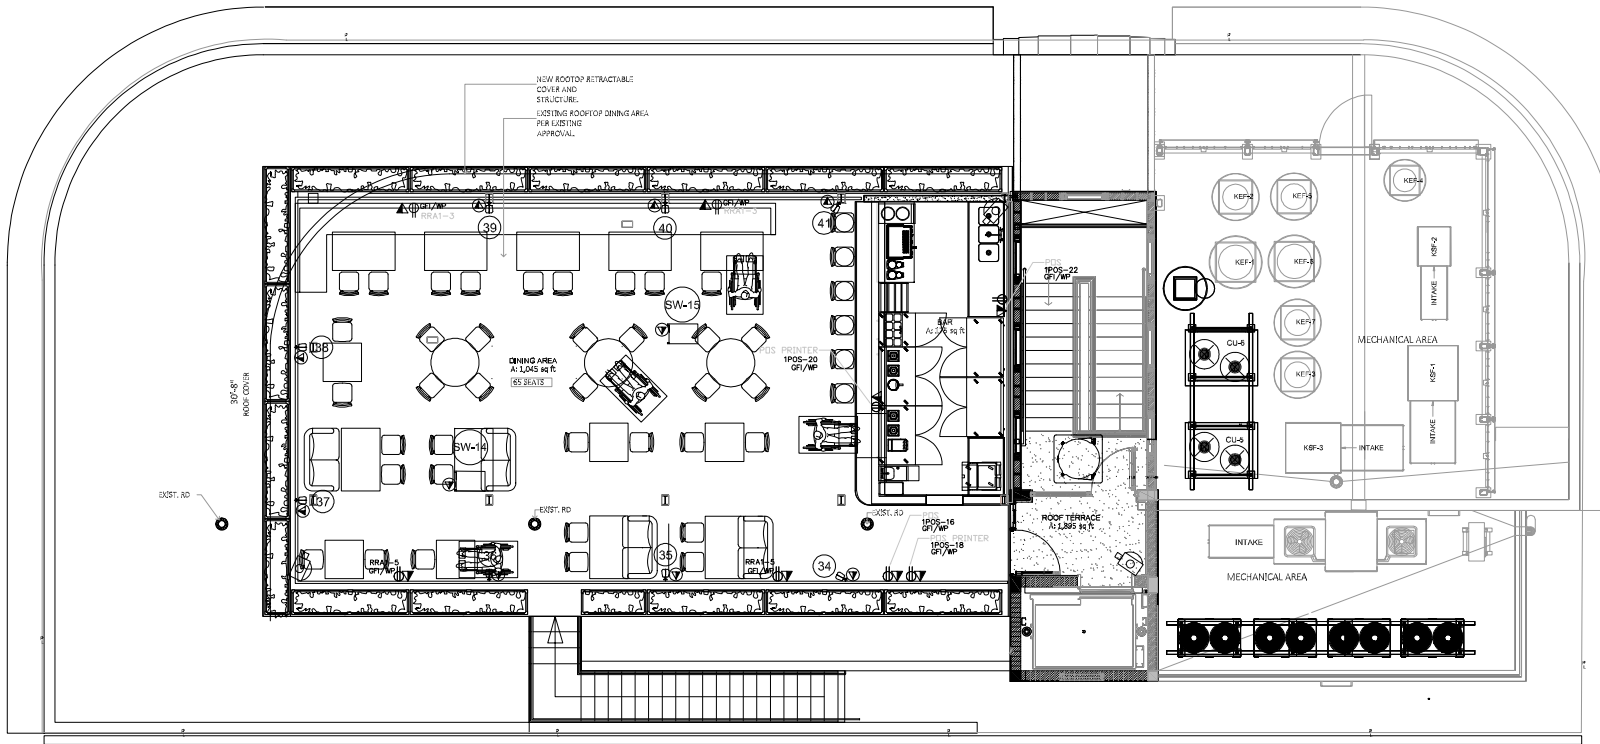

NOTES:  
SEE SOUND SPEAKERS REQUIREMENTS NOTE AT SOUND SPEAKERS DRAWINGS

**E** VIDEO & SOUND AND POS / PRINTERS ( WALL AND CEILING MOUNTED) ROOF PLAN  
SCALE: 1/4" = 1'-0"

VIDEO SYSTEM SYMBOLS

	TENRON CURTAIN ELITE SCRIBER 136 HXQ2
	PROJECTOR/LASER OPTOMA 2h 4085T
	TV LG 55"
	J-BOX FOR RGB VIDEO SYSTEM
	RECEPTACLE HX

SECURITY SYSTEM SYMBOLS

SYMBOLS	
	CCTV
	DATA
	ELECTRICAL RECEPTACLE (normal 110V)
	ELECTRICAL RECEPTACLE DEDICATE

	OHMNET Hgus 8in-6
	OHMNET Hgus 3in-360

SPEAKER SYSTEM SYMBOLS

TYPE OF SPEAKER	MODEL	COVERAGE
	ACTIVE Line Array OSC KLJ-12	90°
	ACTIVE Cardoid Subwoofer OSC KS-210C	180°
	ACTIVE Subwoofer OSC KS-12	360°
	PASSIVE Full Range OSC E-12	90°
	ACTIVE Full Range OSC CP-8	90°
	PASSIVE Pendant Subwoofer OSC ADP-9L-B	360°
	PASSIVE Pendant Full Range OSC ADP-2A-T	360°

CABLE & DATA OUTLET (6x4x2 1/2 OUTLET 300)  
FOR HEIGHT MOUNTED REFER TO SOUND TECH DRAWINGS.



OWNER:  
LINCOLN DREXEL, LTD.  
AND LINCOLN DREXEL II,  
3851 ALTON ROAD #800  
MIAMI BEACH, FL 33143

ARCHITECT:  
FORM GROUP, INC.  
4305 SW 73 AVE. #100  
MIAMI, FL 33155  
PH: 305-413-4244

INTERIOR DESIGNER:

VIDEO CONSULTANT:  
LACE FOOD SERVICE  
1540 NW 29TH STREET,  
MIAMI, FL 33172  
PH: 305-913-6223

MECHANICAL ENGINEER:  
LAUREDO ENGINEERING  
COMPANY  
1000 N. W. 10TH ST.  
MIAMI, FL 33136  
PH: 305-371-1111

STRUCTURAL ENGINEER:

INTERIOR TENANT BUILT-OUT FOR:

**ANDRÉS  
CARNE DE RES**

LINCOLN DREXEL BUILDING  
1600 DREXEL AVENUE  
MIAMI BEACH, FL 33139

DATE: 09/30/21 B.D.C.



**FORMGROUP**  
architecture .planning

FORM GROUP, INC.  
1000 NW 74 AVE. SUITE 100, MIAMI, FL 33156  
TEL: 305-413-4244 FAX: 305-413-4245  
ARCHITECT OF RECORD FOR THIS PROJECT

PROJECT NO: 19-1007  
DATE: 5-8-20  
SCALE: AS SHOWN

**E-104.2**