

FONTAINEBLEAU DEVELOPMENT

4441 Collins Avenue Miami Beach FL 33140

Gensler

M. Arthur Gensler Jr. & Associates
FL Qualifier's Lic. No. AR96486

MAIN OFFICE
45 Fremont Street
Suite 1500
San Francisco, CA 94105
United States

Tel 415.433.3700
Fax 415.836.4599

SATELLITE OFFICE
545 N.W. 26th Street
Suite 250
Miami, FL 33127
United States

Tel 305.350.7070
Fax 305.350.7071

Fontainebleau Development

Ownership
19950 West Country Club
Drive, 10th Floor
Aventura, FL 33180
Tel 305.937.6262

LANGAN

Langan Civil
1221 Brickell Avenue, Suite
1800
Miami, FL 33131
Tel 786.264.7200



Lifescapes (Landscape)
17461 Derian Ave, Suite 202
Irvine, CA 92614
Tel 949.476.8888

DESIMONE

DeSimone
Structural Engineer
100 Biscayne Boulevard, 15th
Floor
Miami, FL 33132
Tel 305.441.0755



Thompson Ehl Company
MEP
2 Sun Ct NW, Suite 450
Peachtree Corners, GA 30092
Tel 770.518.1426



SCOTEC (SL)
Life Safety
260 Palermo Avenue
Coral Gables, FL 33134
Tel 888.224.9911



Crabtree McGrath Associates
Kitchen Consultant
161 West Main Street
Georgetown, MA 01853
Tel 978.352.8500



CLOWARD H2O
Aquatic Engineer
350 S. 400 W., Suite 200
Lindon, Utah 84042
Tel 801.375.1223



Whitewater
Slide Designer
180-6651 Frasewood Pl
Richmond, BC, V6W 1J3
Canada
Tel 604.232.3307



DCL Orlando
Design Build
85 Bowdoin St., Suite 1
Avon, MA 02322
Tel 617.542.8620



Environmental Solutions
Coastal
7620 SW 125th Street
Pinecrest, FL 33156
Tel 305.479.8346



Longitude
Surveyor (GPR - As-built)
1125 Stadium Way
Royal Palm Beach, FL 33411
Tel 305.463.0912



David Plummer
Traffic
1750 Ponce De Leon Blvd
Coral Gables, FL 33134
Tel 305.447.0900

Date	Description



ANAMARIS TORRES SANCHEZ
No. 91085
STATE OF FLORIDA
PROFESSIONAL ENGINEER
07/18/2025
SIGNATURE: ANAMARIS TORRES SANCHEZ DATE SIGNED: 07/18/2025
PROFESSIONAL ENGINEER FL Lic. No. 91085

Project Name

Fontainebleau Exterior Renovation

Project Number

300370701



Description

GRADING AND DRAINAGE KEY MAP

Scale

1" = 20'-0"


C-400

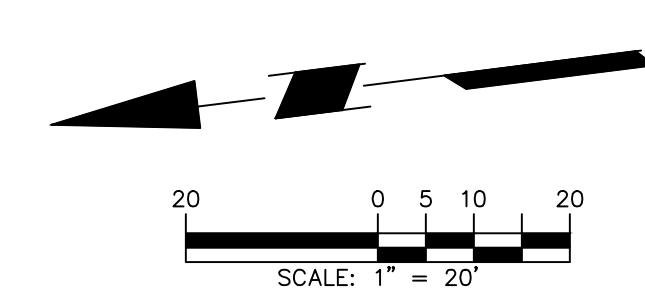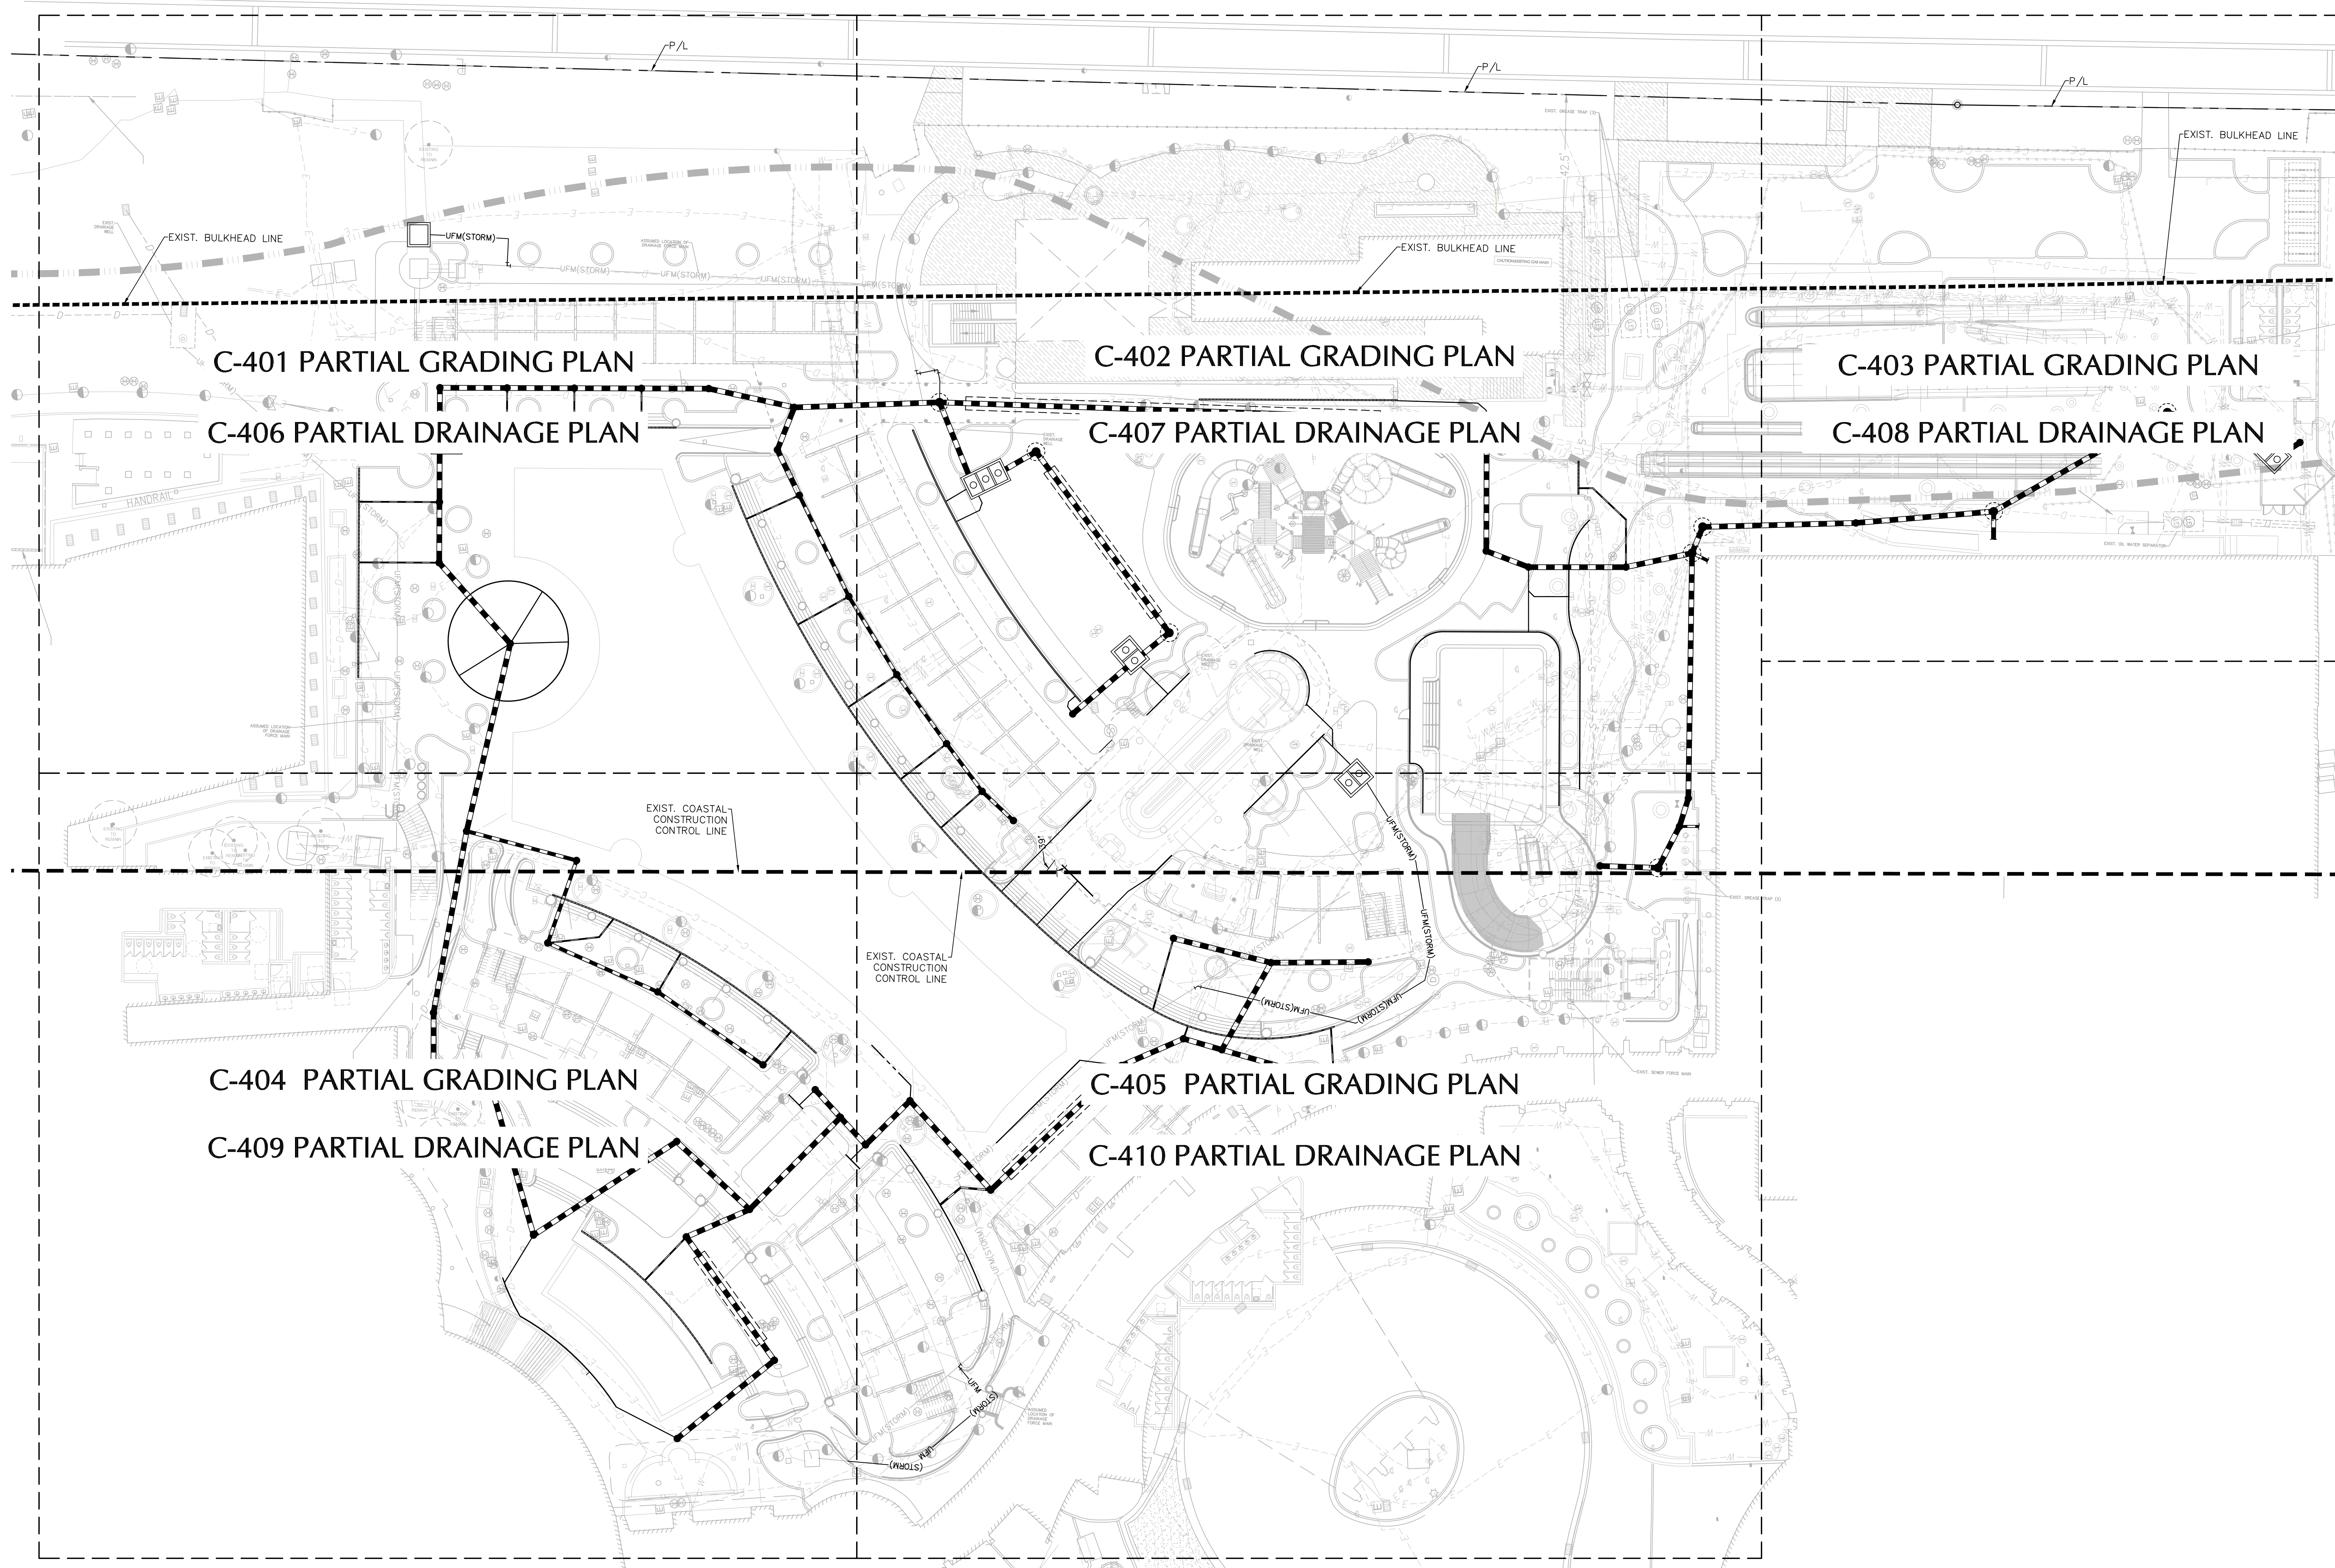

LANGAN

Langan Engineering and
Environmental Services, LLC
1221 Brickell Ave, Suite 1800
Miami, FL 33131

T: 786.264.7200 F: 786.264.7201 www.langan.com
FBPE Registry No. 000066011, 08172X, B8198

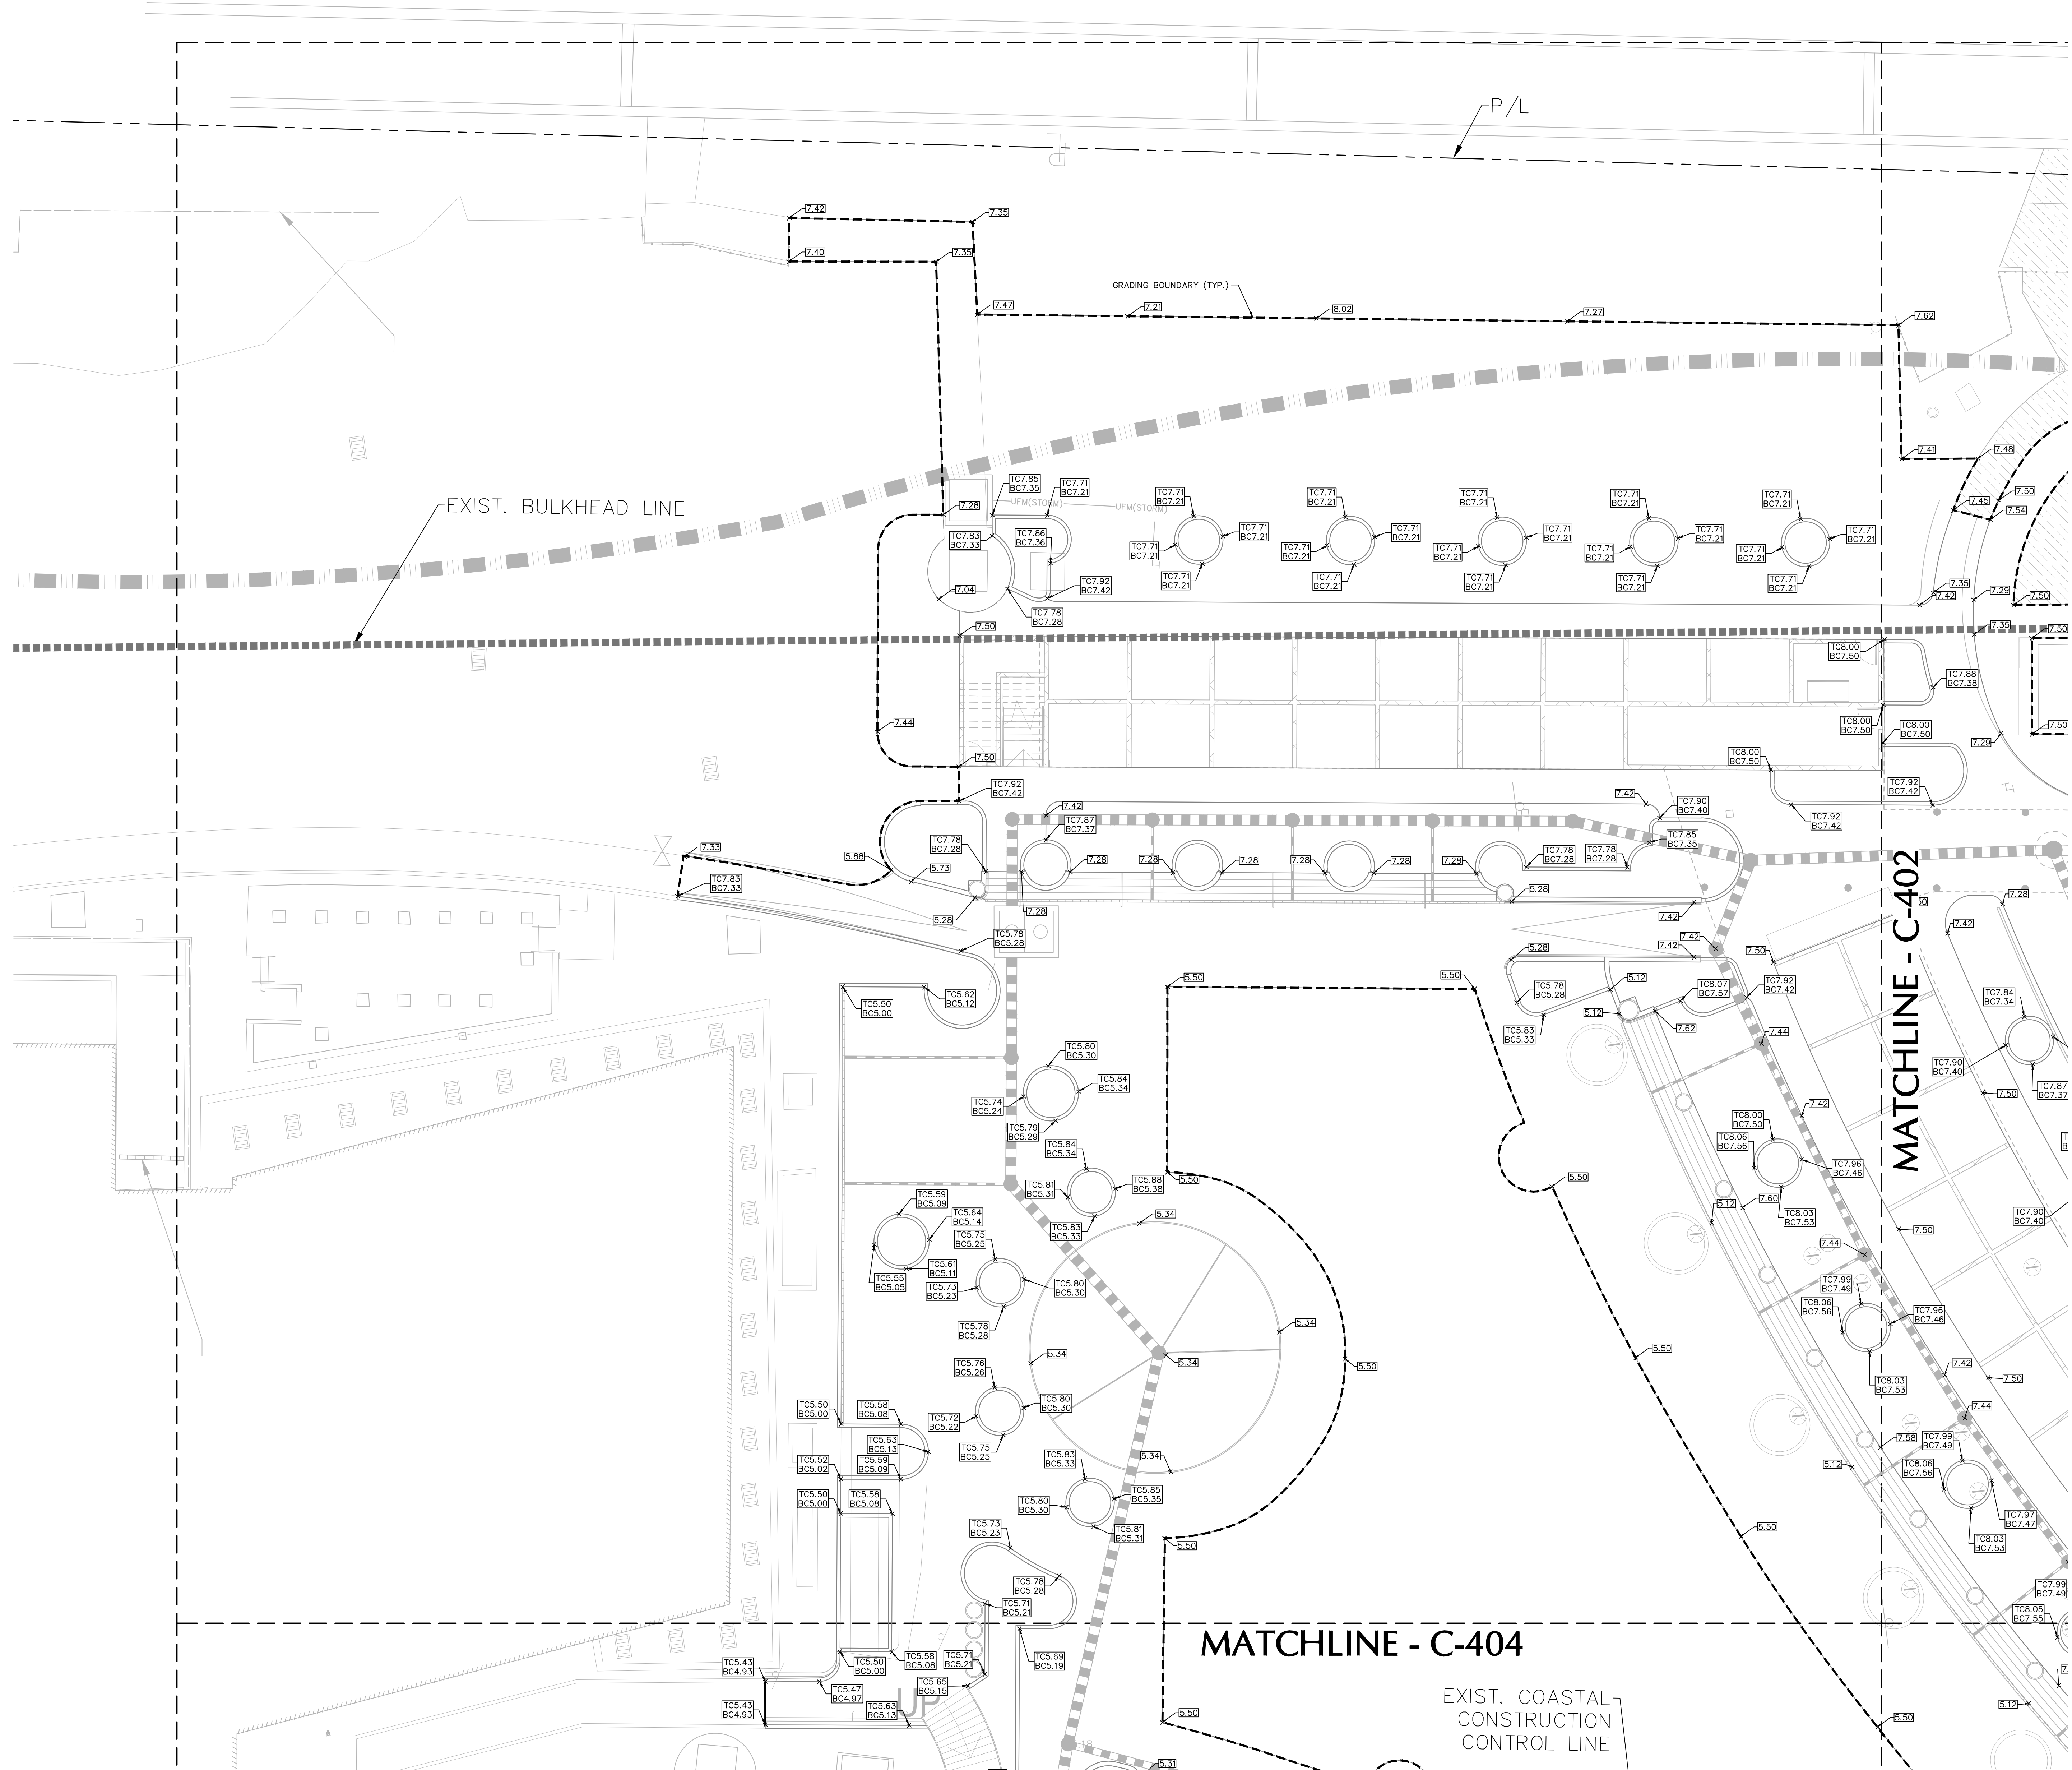

NOTES:
1. ALL ELEVATIONS SHOWN REFERENCE THE NORTH AMERICAN VERTICAL DATUM OF 1988 (NAVD88)

FONTAINEBLEAU DEVELOPMENT

4441 Collins Avenue Miami Beach FL 33140

Gensler
M. Arthur Gensler Jr. & Associates
FL Qualifier's Lic. No. AR96486
Tel 415.433.3700 Fax 415.836.4596
MAIN OFFICE
45 Fremont Street
Suite 1500
San Francisco, CA 94105
United States
SATELLITE OFFICE
545 N.W. 26th Street
Suite 250
Miami, FL 33127
United States
Tel 305.350.7070 Fax 305.350.7071

LANGAN
Fontainebleau Development
Ownership
19950 West Country Club
Drive, 10th Floor
Aventura, FL 33180
Tel 305.937.6262
Langan Civil
1221 Brickell Avenue, Suite
1800
Miami, FL 33131
Tel 786.264.7200

DESIMONE
Lifescapes (Landscape)
17461 Derian Ave, Suite 202
Irvine, CA 92614
Tel 949.476.8888
DeSimone Structural Engineer
100 Biscayne Boulevard, 15th
Floor
Miami, FL 33132
Tel 305.441.0755

SCOTEC
Thompson Ehle Company
MEP
2 Sun Ct NW, Suite 450
Peachtree Corners, GA 30092
Tel 713.518.1426
SCOTEC (SLC)
Life Safety
260 Palermo Avenue
Coral Gables, FL 33134
Tel 888.224.9911

Crabtree McGrath Associates
Kitchen Consultant
161 West Main Street
Georgetown, MA 01853
Tel 978.352.8500
Cloward H2O
Aquatic Engineer
350 S. 400 W., Suite 200
Lindon, Utah 84042
Tel 801.975.1223

Whitewater
Slide Designer
180-6651 Fraserwood Pl
Richmond, BC, V6W 1J3
Canada
Tel 604.232.3307
DCL
DCL Orlando
Design Build
85 Bowdoin St., Suite 1
Avon, MA 02322
Tel 617.542.8620

Environmental Solutions Coastal
7600 SW 125th Street
Pinecrest, FL 33156
Tel 305.479.8346
Longitude
Surveyor (GPR - As-Built)
1128 Stadium Way
Royal Palm Beach, FL 33411
Tel 305.463.0912

David Plummer
Traffic
1750 Ponce De Leon Blvd
Coral Gables, FL 33134
Tel 305.447.0900


Date	Description

Seal / Signature
ANAMARIS TORRES SANCHEZ
No. 91085
STATE OF FLORIDA
PROFESSIONAL ENGINEER
07/18/2025
SIGNATURE: ANAMARIS TORRES SANCHEZ DATE SIGNED: 07/18/2025
PROFESSIONAL ENGINEER FL Lic. No. 91085

Project Name
Fontainebleau Exterior Renovation
Project Number
300370701
Description
PARTIAL GRADING PLAN

Scale
1" = 10'-0"

C-401

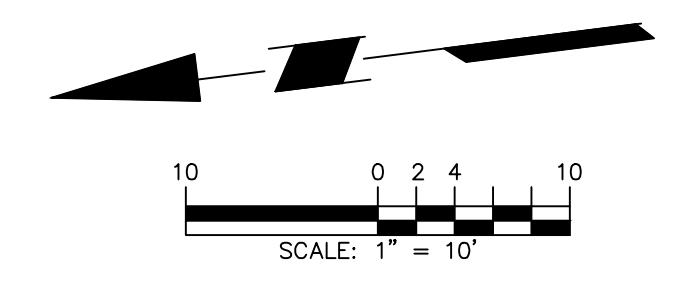

LANGAN
Langan Engineering and
Environmental Services, LLC
1221 Brickell Ave, Suite 1800
Miami, FL 33131
T: 786.264.7200 F: 786.264.7201 www.langan.com
FBPE Registry No. 0000660118917208189

FONTAINEBLEAU DEVELOPMENT

4441 Collins Avenue Miami Beach FL 33140

Gensler

M. Arthur Gensler Jr. & Associates
FL Qualifier's Lic. No. AR96486
MAIN OFFICE
45 Fremont Street
Suite 1500
San Francisco, CA 94105
United States
Tel 415.433.3700
Fax 415.836.4599

SATELLITE OFFICE
545 N.W. 26th Street
Suite 250
Miami, FL 33127
United States
Tel 305.350.7070
Fax 305.350.7071

LANGAN

Fontainebleau Development
Ownership
19950 West Country Club
Drive, 10th Floor
Aventura, FL 33180
Tel 305.937.6262
Langan Civil
1221 Brickell Avenue, Suite
1800
Miami, FL 33131
Tel 786.264.7200

DESIMONE

DeSimone
Structural Engineer
100 Biscayne Boulevard, 15th
Floor
Miami, FL 33132
Tel 305.441.0755
Lifescapes (Landscape)
17461 Derian Ave, Suite 202
Irvine, CA 92614
Tel 949.476.8888

SCOTEC

SCOTEC (SL)
Life Safety
260 Palermo Avenue
Coral Gables, FL 33134
Tel 888.224.9911
Thompson Ehle Company
MEP
2 Sun Ct NW, Suite 450
Peachtree Corners, GA 30092
Tel 715.518.1426

Crabtree McGrath

Crabtree McGrath Associates
Kitchen Consultant
161 West Main Street
Georgetown, MA 01833
Tel 978.352.8500
Cloward H2O
Aquatic Engineer
350 S. 400 W. Suite 200
Lindon, Utah 84042
Tel 801.975.1223

WHITewater

Whitewater
Slide Designer
183-6651 Frieswood Pl
Richmond, BC, V6W 1J5
Canada
Tel 604.232.3307
DCL
DCL Orlando
Design Build
85 Bowditch St. Suite 1
Avon, MA 02322
Tel 617.542.9620

Environmental Solutions

Environmental Solutions
Coastal
7600 SW 125th Street
Pinecrest, FL 33156
Tel 305.479.8346
Longitude
Surveyor (GPR - As-built)
1128 Starcrest Way
Royal Palm Beach, FL 33411
Tel 305.463.0912

David Plummer

David Plummer
Traffic
1750 Ponce De Leon Blvd
Coral Gables, FL 33134
Tel 305.447.0900

Date	Description

Seal / Signature
ANAMARIS TORRES SANCHEZ
LICENSE # 91085
STATE OF FLORIDA
PROFESSIONAL ENGINEER

07/18/2025
DATE SIGNED
ANAMARIS TORRES SANCHEZ
PROFESSIONAL ENGINEER FL Lic. No. 91085

Project Name
Fontainebleau Exterior
Renovation



Project Number
300370701

Description
PARTIAL GRADING PLAN

Scale
1" = 10'-0"

C-402

NOTES:
1. ALL ELEVATIONS SHOWN REFERENCE THE NORTH AMERICAN VERTICAL DATUM OF 1988 (NAVD88)

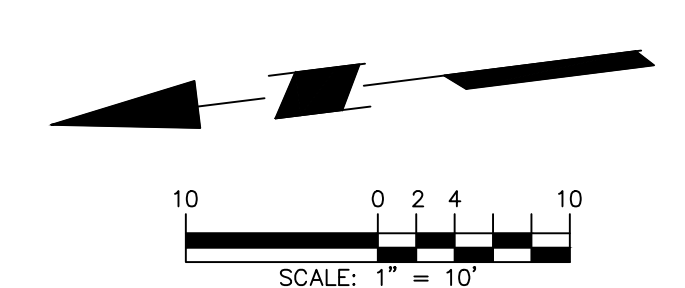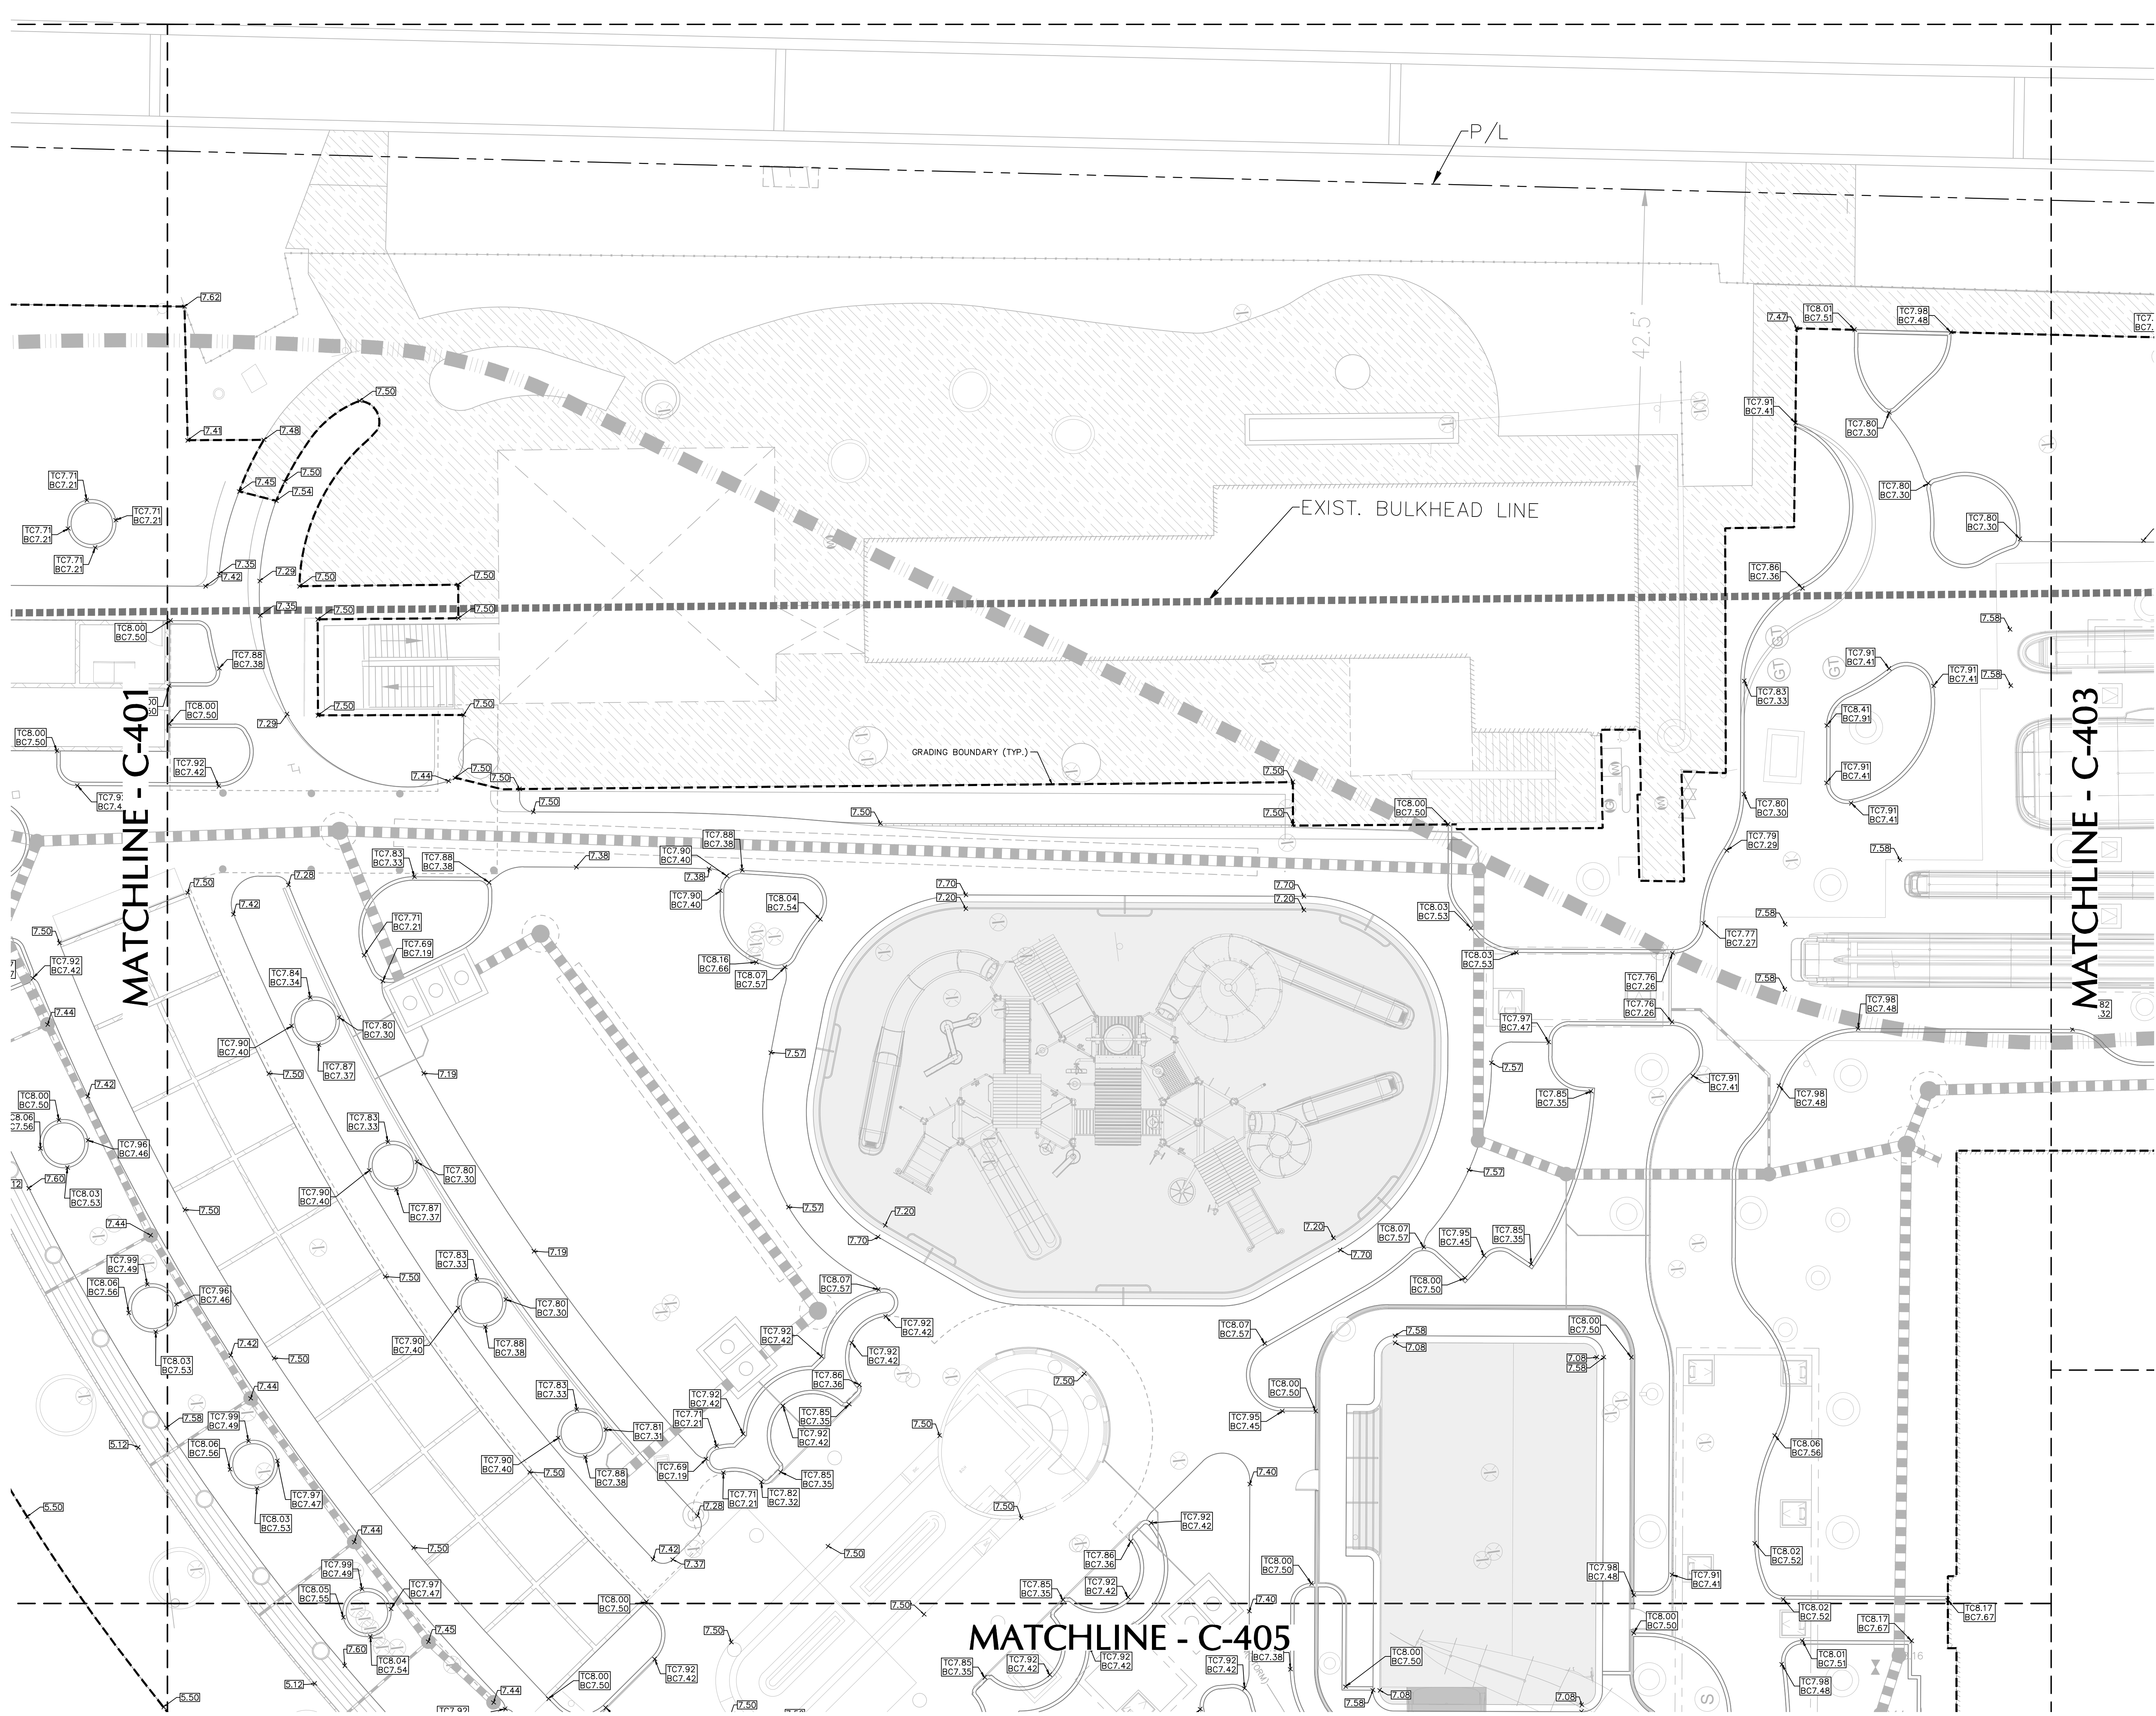

LANGAN
Langan Engineering and
Environmental Services, LLC
1221 Brickell Ave, Suite 1800
Miami, FL 33131
T: 786.264.7200 F: 786.264.7201 www.langan.com
FBPE Registry No. 00006601189172181818

FONTAINEBLEAU DEVELOPMENT

4441 Collins Avenue Miami Beach FL 33140

Gensler

M. Arthur Gensler Jr. & Associates
FL Qualifier's Lic. No. AR96486
MAIN OFFICE
45 Fremont Street
Suite 1500
San Francisco, CA 94105
United States

Tel 415.433.3700
Fax 415.836.4599

SATELLITE OFFICE
545 N.W. 26th Street
Suite 250
Miami, FL 33127
United States

Tel 305.350.7070
Fax 305.350.7071

FONTAINEBLEAU DEVELOPMENT

Fontainebleau Development
Ownership
19950 West Country Club
Drive, 10th Floor
Aventura, FL 33180
Tel 305.937.6262

LANGAN

Langan Civil
1221 Brickell Avenue, Suite
1800
Miami, FL 33131
Tel 786.264.7200



DESIMONE
Lifescapes (Landscape)
17461 Derian Ave, Suite 202
Irvine, CA 92614
Tel 949.476.8888

DESIMONE

DeSimone
Structural Engineer
100 Biscayne Boulevard, 15th
Floor
Miami, FL 33132
Tel 305.441.0755



SCOTEC
Scoloted (SL)S
Life Safety
260 Palermo Avenue
Coral Gables, FL 33134
Tel 888.224.9911



Thompson Ehle Company
MEP
2 Sun Ct NW, Suite 450
Peachtree Corners, GA 30092
Tel 713.518.1426



Crabtree McGrath Associates
Kitchen Consultant
161 West Main Street
Georgetown, MA 01853
Tel 978.352.8500



Cloward H2O
Aquatic Engineer
350 S. 400 W., Suite 200
Lindon, Utah 84042
Tel 801.375.1223



Whitewater
Slide Designer
180-6651 Fraserwood Pl
Richmond, BC, V6W 1J3
Canada
Tel 604.232.3307



DCL Orlando
Design Build
85 Bowdoin St., Suite 1
Avon, MA 02322
Tel 617.542.8620

Environmental Solutions
Coastal
7600 SW 125th Street
Pinecrest, FL 33156
Tel 305.479.8346




Langitude
Surveyor (GPR - As-built)
1128 Starclust Way
Royal Palm Beach, FL 33411
Tel 305.463.0912



David Plummer
Traffic
1750 Ponce De Leon Blvd
Coral Gables, FL 33134
Tel 305.447.0900

Date	Description

Seal / Signature

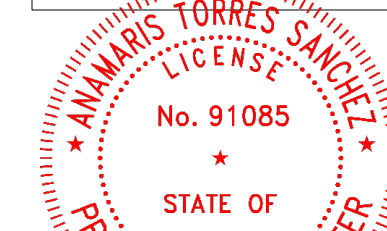

SIGNATURE: ANAMARIS TORRES SANCHEZ DATE SIGNED: 07/18/2025

PROFESSIONAL ENGINEER FL Lic. No. 91085

Project Name

Fontainebleau Exterior Renovation

Project Number

300370701

Description

PARTIAL GRADING PLAN

Scale

1" = 10'-0"

C-404

MATCHLINE - C-401

EXIST. COASTAL CONSTRUCTION CONTROL LINE

EXIST. COASTAL CONSTRUCTION CONTROL LINE

MATCHLINE - C-405

GRADING BOUNDARY (TYP.)



SCALE: 1" = 10'

LANGAN

Langan Engineering and
Environmental Services, LLC
1221 Brickell Ave, Suite 1800
Miami, FL 33131

T: 786.264.7200 F: 786.264.7201 www.langan.com
FBPE Registry No. 000066011891723L8198

FONTAINEBLEAU DEVELOPMENT

4441 Collins Avenue Miami Beach FL 33140

Gensler

M. Arthur Gensler Jr. & Associates
FL Qualifier's Lic. No. AR96486
MAIN OFFICE
45 Fremont Street
Suite 1500
San Francisco, CA 94105
United States

Tel 415.433.3700
Fax 415.836.4599

SATELLITE OFFICE
545 N.W. 26th Street
Suite 250
Miami, FL 33127
United States

Tel 305.350.7070
Fax 305.350.7071

Fontainebleau Development

Ownership
19950 West Country Club
Drive, 10th Floor
Aventura, FL 33180
Tel 305.937.6262

LANGAN

Langan Civil
1221 Brickell Avenue, Suite
1800
Miami, FL 33131
Tel 786.264.7200



Lifescapes (Landscape)
17461 Derian Ave, Suite 202
Irvine, CA 92614
Tel 949.476.8888

DESIMONE

DeSimone Structural Engineer
100 Biscayne Boulevard, 15th
Floor
Miami, FL 33132
Tel 305.441.0755



Thompson Ehle Company
MEP
2 Sun Ct NW, Suite 450
Peachtree Corners, GA 30092
Tel 771.518.1426



SCOTEC
Scotect (SL) Life Safety
260 Palermo Avenue
Coral Gables, FL 33134
Tel 888.224.9911



Crabtree McGrath Associates
Kitchen Consultant
161 West Main Street
Georgetown, MA 01833
Tel 978.352.8500



Cloward H2O
Aquatic Engineer
350 S. 400 W. Suite 200
Lindon, Utah 84042
Tel 801.375.1223



Whitewater
Slide Designer
180-6651 Frasewood Pl
Richmond, BC, V6W 1J3
Canada
Tel 604.232.3307

 


DCL Orlando
Design Build
85 Bowdoin St. Suite 1
Avon, MA 02322
Tel 617.542.8620

Environmental Solutions
Coastal
7800 SW 125th Street
Pincrest, FL 33156
Tel 305.479.8346




Longitude
Surveyor (GPR - As-built)
1128 Starclust Way
Royal Palm Beach, FL 33411
Tel 305.463.0912



David Plummer
Traffic
1750 Ponce De Leon Blvd
Coral Gables, FL 33134
Tel 305.447.0900

Date	Description

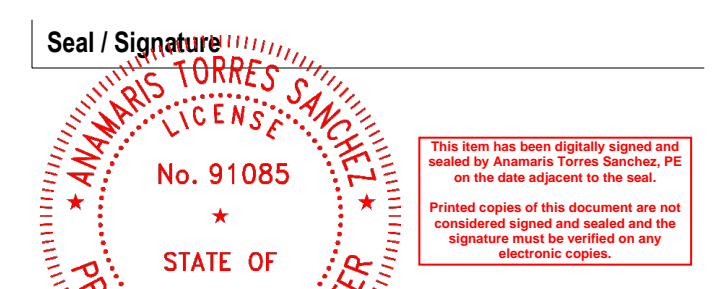


SIGNATURE: ANAMARIS TORRES SANCHEZ DATE SIGNED: 07/18/2025
PROFESSIONAL ENGINEER FL Lic. No. 91085


Project Name
Fontainebleau Exterior Renovation
Project Number
300370701
Description
PARTIAL GRADING PLAN

Scale
1" = 10'-0"

C-405

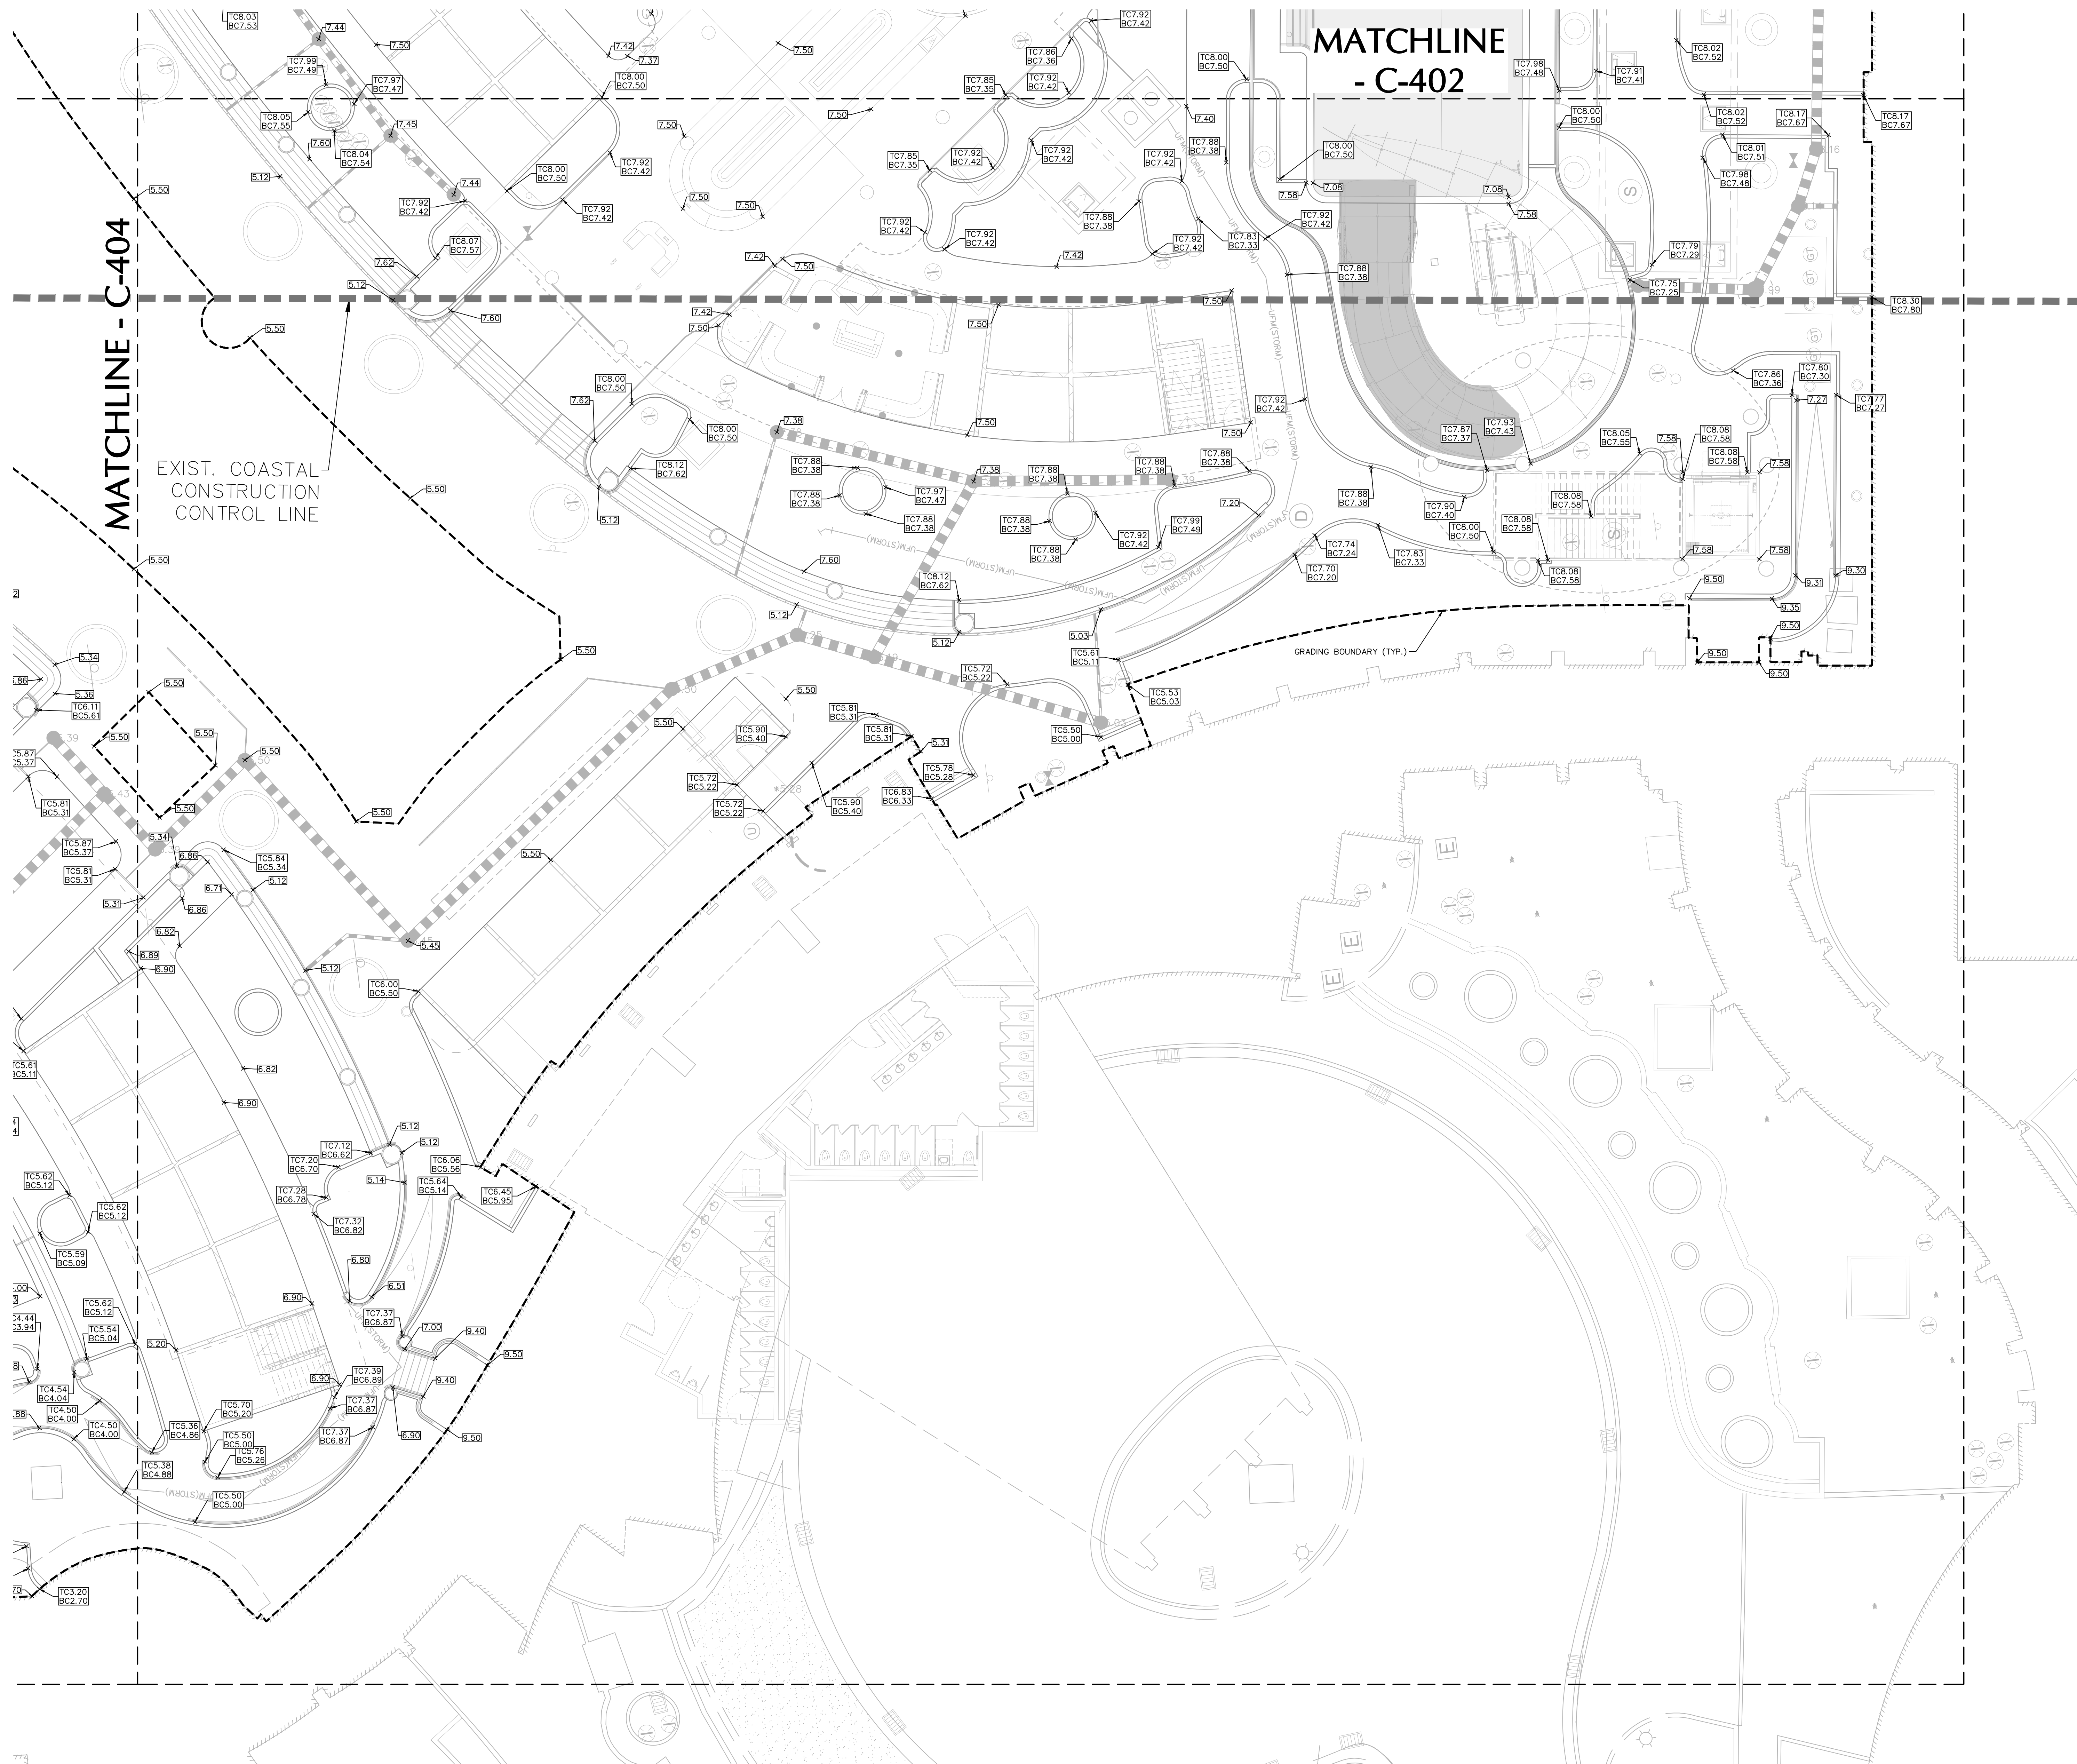

NOTES:
1. ALL ELEVATIONS SHOWN REFERENCE THE NORTH AMERICAN VERTICAL DATUM OF 1988 (NAVD88)

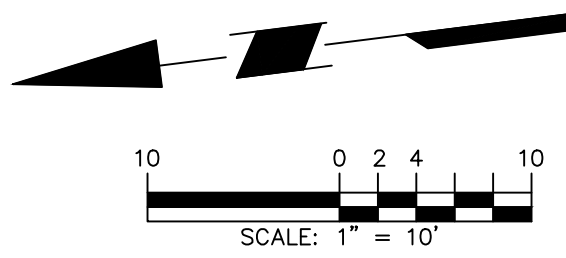

LANGAN
Langan Engineering and
Environmental Services, LLC
1221 Brickell Ave, Suite 1800
Miami, FL 33131

T: 786.264.7200 F: 786.264.7201 www.langan.com
FBPE Registry No. 000066011, 08172X, B8198

FONTAINEBLEAU DEVELOPMENT

4441 Collins Avenue Miami Beach FL 33140

Gensler

M. Arthur Gensler Jr. & Associates
FL Qualifier's Lic. No. AR96486
MAIN OFFICE: 45 Fremont Street, Suite 1500, San Francisco, CA 94105, United States
SATELLITE OFFICE: 545 N.W. 26th Street, Suite 250, Miami, FL 33127, United States
Tel: 415.433.3700, Fax: 415.836.4599
Tel: 305.350.7070, Fax: 305.350.7071

LANGAN

Fontainebleau Development Ownership
19950 West Country Club Drive, 10th Floor, Aventura, FL 33180
Tel: 305.937.6262
Langan Civil: 1221 Brickell Avenue, Suite 1800, Miami, FL 33131
Tel: 786.264.7200

DESIMONE

Lifescapes (Landscape): 17461 Derian Ave., Suite 202, Irvine, CA 92614
Tel: 949.476.8888
DeSimone Structural Engineer: 100 Biscayne Boulevard, 15th Floor, Miami, FL 33132
Tel: 305.441.0755

SCOTEC

Thompson Ehle Company MEP: 2 Sun Ct NW, Suite 450, Peachtree Corners, GA 30092
Tel: 713.518.1426
SCOTEC Scooted (SL) Life Safety: 260 Palermo Avenue, Coral Gables, FL 33134
Tel: 888.224.9911

Crabtree McGrath Associates

Crabtree McGrath Associates: 161 West Main Street, Georgetown, MA 01833
Tel: 978.352.8500
Cloward H2O Aquatic Engineer: 350 S. 400 W., Suite 200, Lindon, Utah 84042
Tel: 801.975.1223

WHITewater

Whitewater Slide Designer: 180-8651 Fraserwood Pl, Richmond, BC, V6W 1J3, Canada
Tel: 604.232.3307
DCL Orlando Design Build: 85 Bowdell St., Suite 1, Avon, MA 02322
Tel: 617.542.9620

Environmental Solutions Coastal

Environmental Solutions Coastal: 7600 SW 125th Street, Pincrest, FL 33156
Tel: 305.479.8346
Longitude Surveyor (GPR - As-built): 1128 Sturtevant Way, Royal Palm Beach, FL 33411
Tel: 305.463.0912

David Plummer

David Plummer Traffic: 1750 Ponce De Leon Blvd, Coral Gables, FL 33134
Tel: 305.447.0900

Date	Description

Seal / Signature: ANAMARIS TORRES SANCHEZ, No. 91085, STATE OF FLORIDA, PROFESSIONAL ENGINEER
SIGNATURE: ANAMARIS TORRES SANCHEZ, DATE SIGNED: 07/18/2025
PROFESSIONAL ENGINEER FL Lic. No. 91085



Project Name: Fontainebleau Exterior Renovation
Project Number: 300370701
Description: PARTIAL DRAINAGE PLAN

Scale: 1" = 10'-0"

C-406

LEGEND

---	EXIST. SEWER FORCE MAIN
---	EXIST. DRAINAGE FORCE MAIN
---	EXIST. DRAINAGE PIPE
---	EXIST. GAS LINE
---	EXIST. COMMUNICATION LINE
---	EXIST. ELECTRIC LINE
---	EXIST. SEWER MAIN/LATERAL
---	EXIST. WATER MAIN/SERVICE
---	UNKNOWN LINE
---	EXIST. EXFILTRATION TRENCH

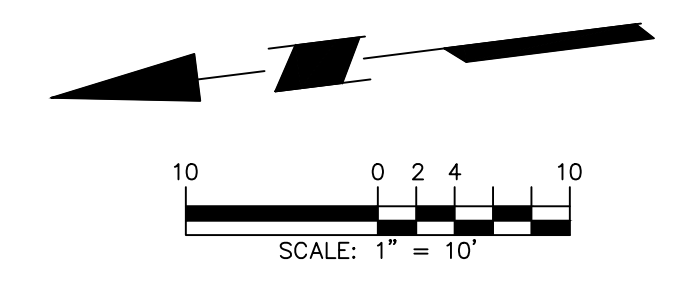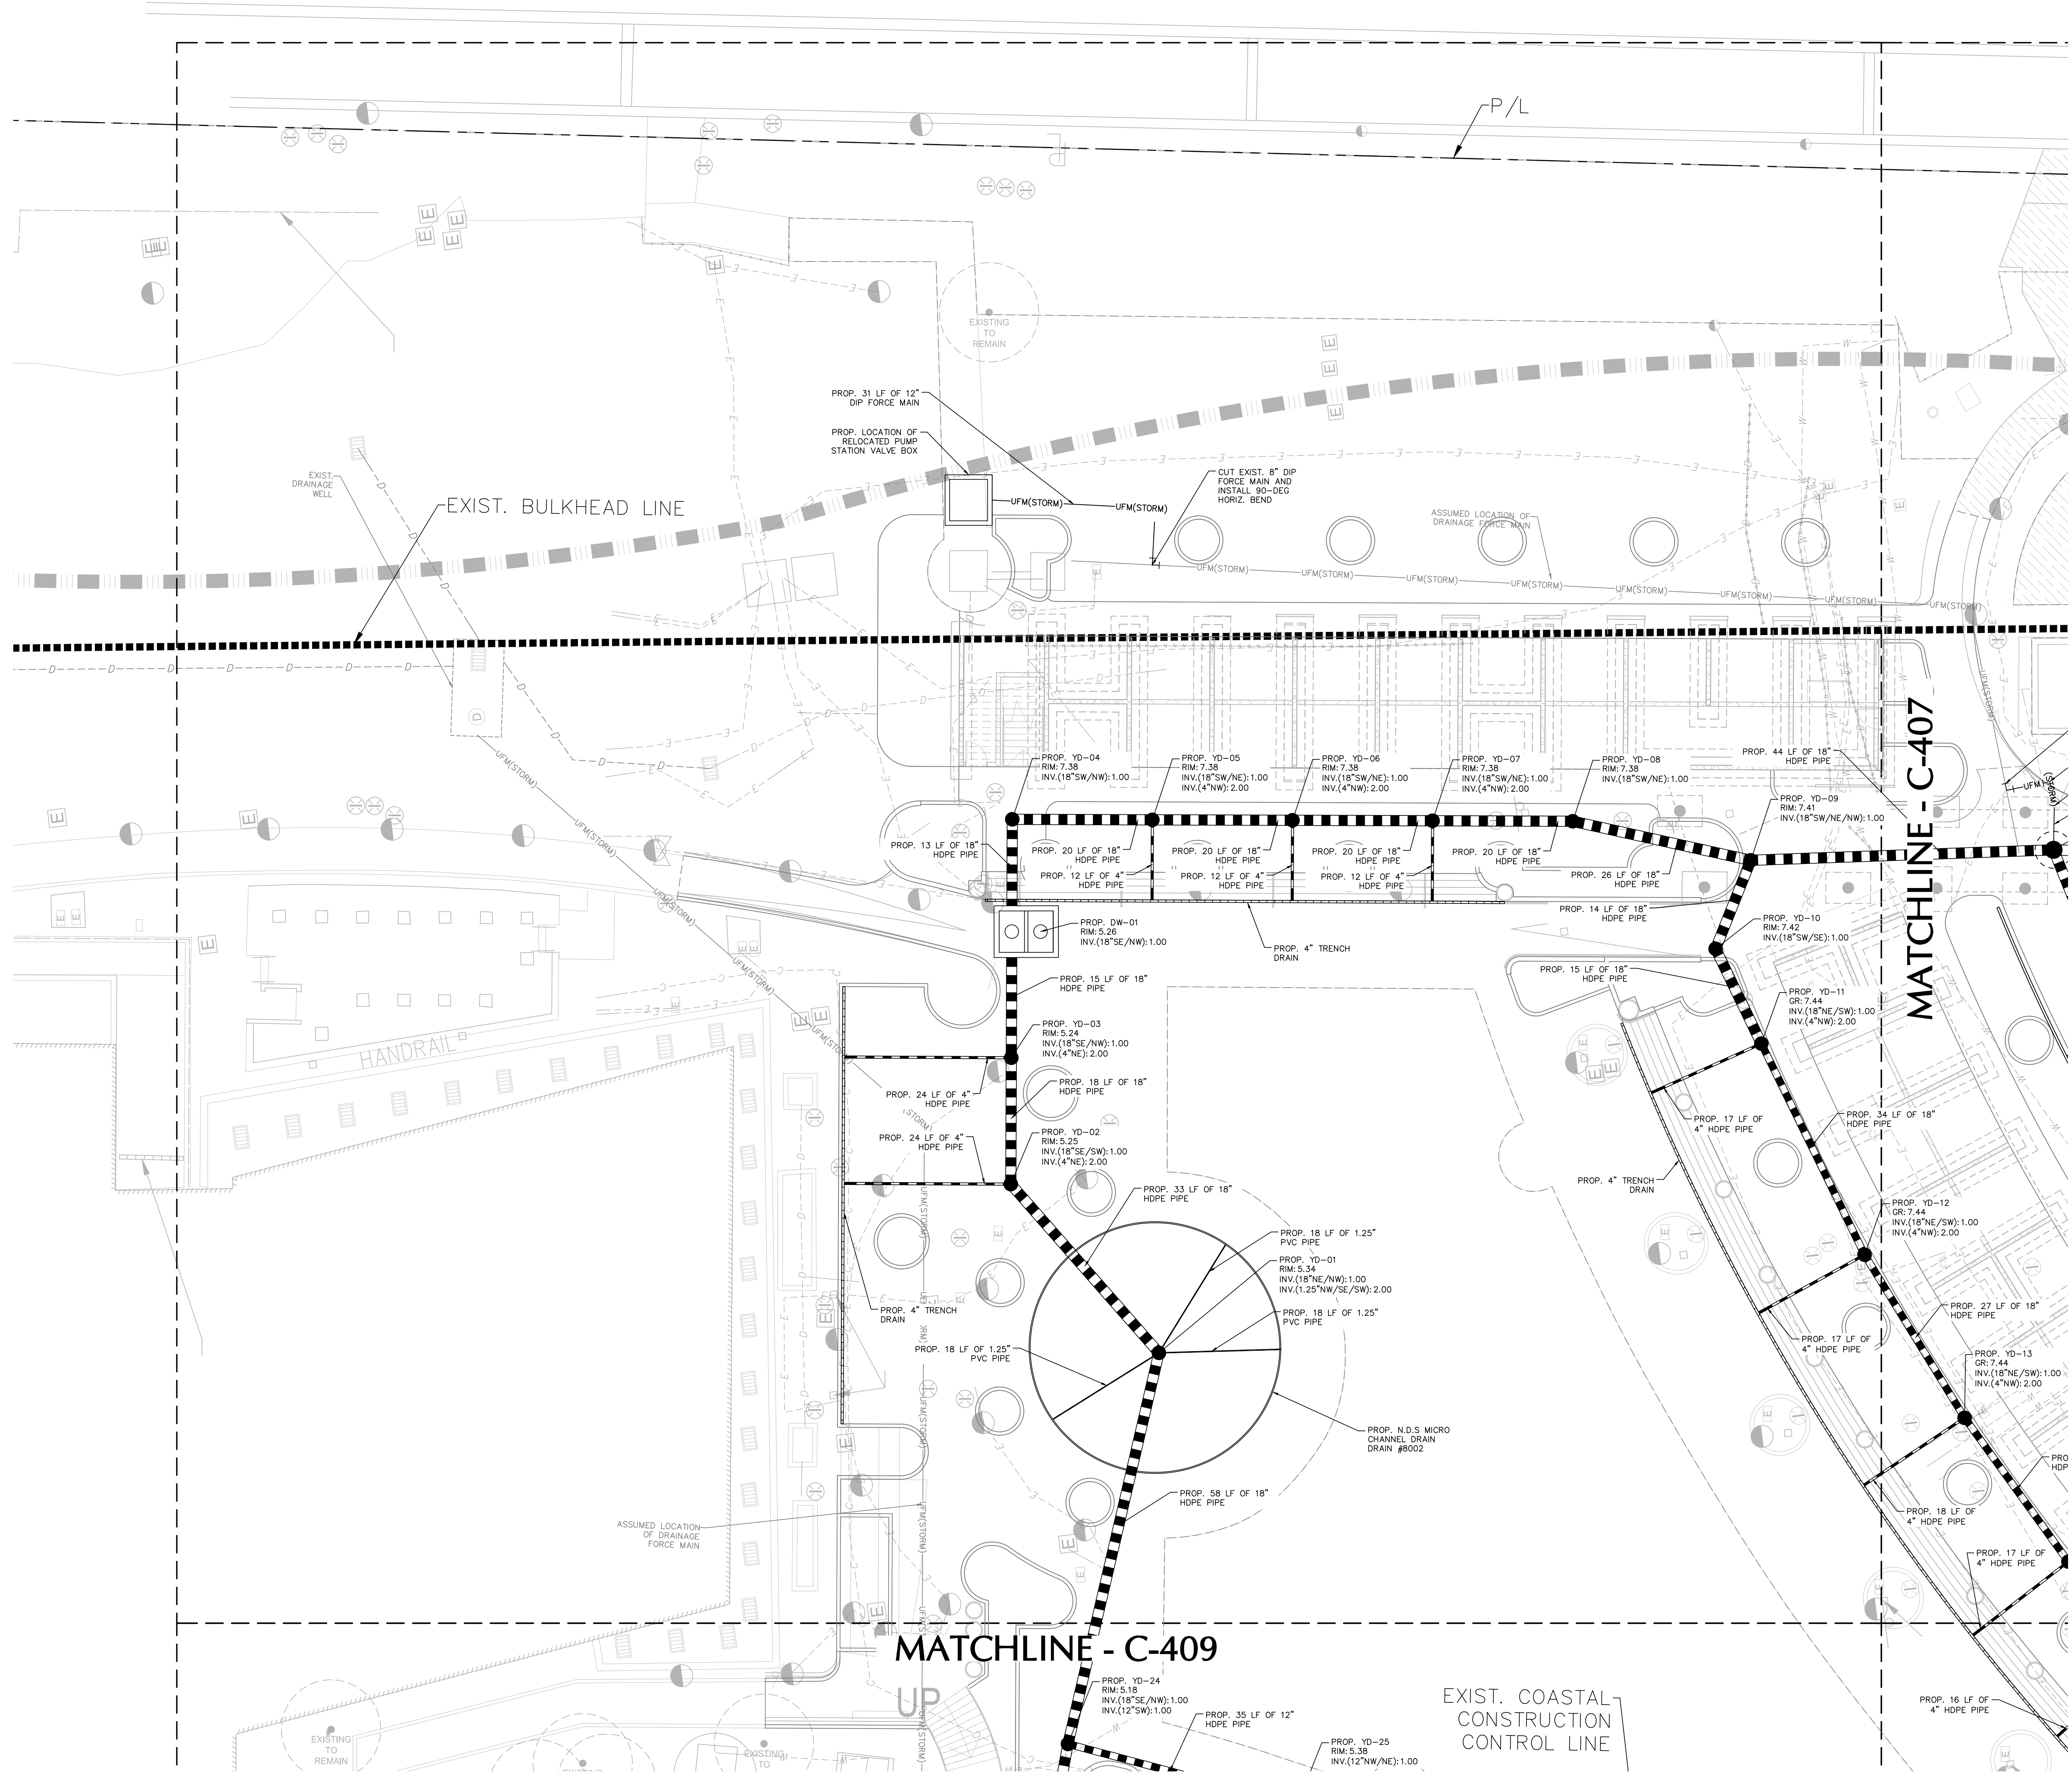

LANGAN
Langan Engineering and Environmental Services, LLC
1221 Brickell Ave., Suite 1800
Miami, FL 33131

T: 786.264.7200 F: 786.264.7201 www.langan.com
FBPE Registry No. 0006601189172X.B8198

FONTAINEBLEAU DEVELOPMENT

4441 Collins Avenue Miami Beach FL 33140

Gensler

M. Arthur Gensler Jr. & Associates
FL Qualifier's Lic. No. AR96486
MAIN OFFICE: 45 Fremont Street, Suite 1500, San Francisco, CA 94105, United States
SATELLITE OFFICE: 545 N.W. 26th Street, Suite 250, Miami, FL 33127, United States
Tel: 415.433.3700, Fax: 415.836.4599
Tel: 305.350.7070, Fax: 305.350.7071

LANGAN

Fontainebleau Development Ownership
19950 West Country Club Drive, 10th Floor, Aventura, FL 33180
Tel: 305.937.6262
Langan Civil: 1221 Brickell Avenue, Suite 1800, Miami, FL 33131
Tel: 786.264.7200

DESIMONE

Lifescapes (Landscape): 17461 Derian Ave., Suite 202, Irvine, CA 92614
Tel: 949.476.8888
DeSimone Structural Engineer: 100 Biscayne Boulevard, 15th Floor, Miami, FL 33132
Tel: 305.441.0755

SCOTEC

Thompson Ehle Company MEP: 2 Sun Ct NW, Suite 450, Peachtree Corners, GA 30092
Tel: 713.518.1426
SCOTEC Life Safety: 260 Palermo Avenue, Coral Gables, FL 33134
Tel: 888.224.9911

Crabtree McGrath Associates

Crabtree McGrath Associates: 161 West Main Street, Georgetown, MA 01833
Tel: 978.352.8500
Cloward H2O Aquatic Engineer: 350 S. 400 W., Suite 200, Lindon, Utah 84042
Tel: 801.375.1223

WHITewater

Whitewater Slide Designer: 180-8651 Friesenwood Pl, Richmond, BC, V6W 1J3, Canada
Tel: 604.232.3307
DCL Design Build: 85 Bowdell St., Suite 1, Avon, MA 02322
Tel: 617.542.9620

Environmental Solutions Coastal

Environmental Solutions Coastal: 7620 SW 125th Street, Pincrest, FL 33156
Tel: 305.479.8346
Longitude Surveyor (GPR - As-built): 1128 Stadiant Way, Royal Palm Beach, FL 33411
Tel: 305.463.0912

David Plummer

David Plummer Traffic: 1750 Ponce De Leon Blvd, Coral Gables, FL 33134
Tel: 305.447.0900

Date	Description

Seal / Signature: ANAMARIS TORRES SANCHEZ, No. 91085, STATE OF FLORIDA, PROFESSIONAL ENGINEER

DATE SIGNED: 07/18/2025
PROFESSIONAL ENGINEER FL Lic. No. 91085

Project Name: Fontainebleau Exterior Renovation

Project Number: 300370701



Description: PARTIAL DRAINAGE PLAN

Scale: 1" = 10'-0"

C-407

LEGEND

---	EXIST. SEWER FORCE MAIN
---	EXIST. DRAINAGE FORCE MAIN
---	EXIST. DRAINAGE PIPE
---	EXIST. GAS LINE
---	EXIST. COMMUNICATION LINE
---	EXIST. ELECTRIC LINE
---	EXIST. SEWER MAIN/LATERAL
---	EXIST. WATER MAIN/SERVICE
---	UNKNOWN LINE
---	EXIST. EXFILTRATION TRENCH

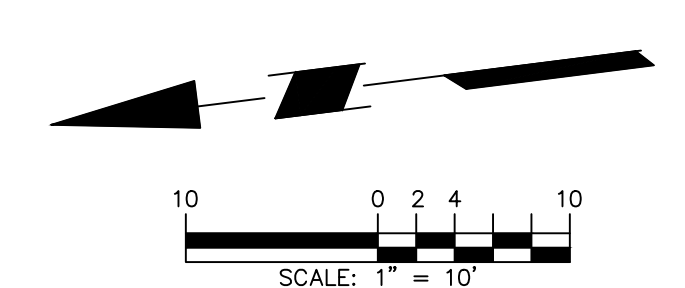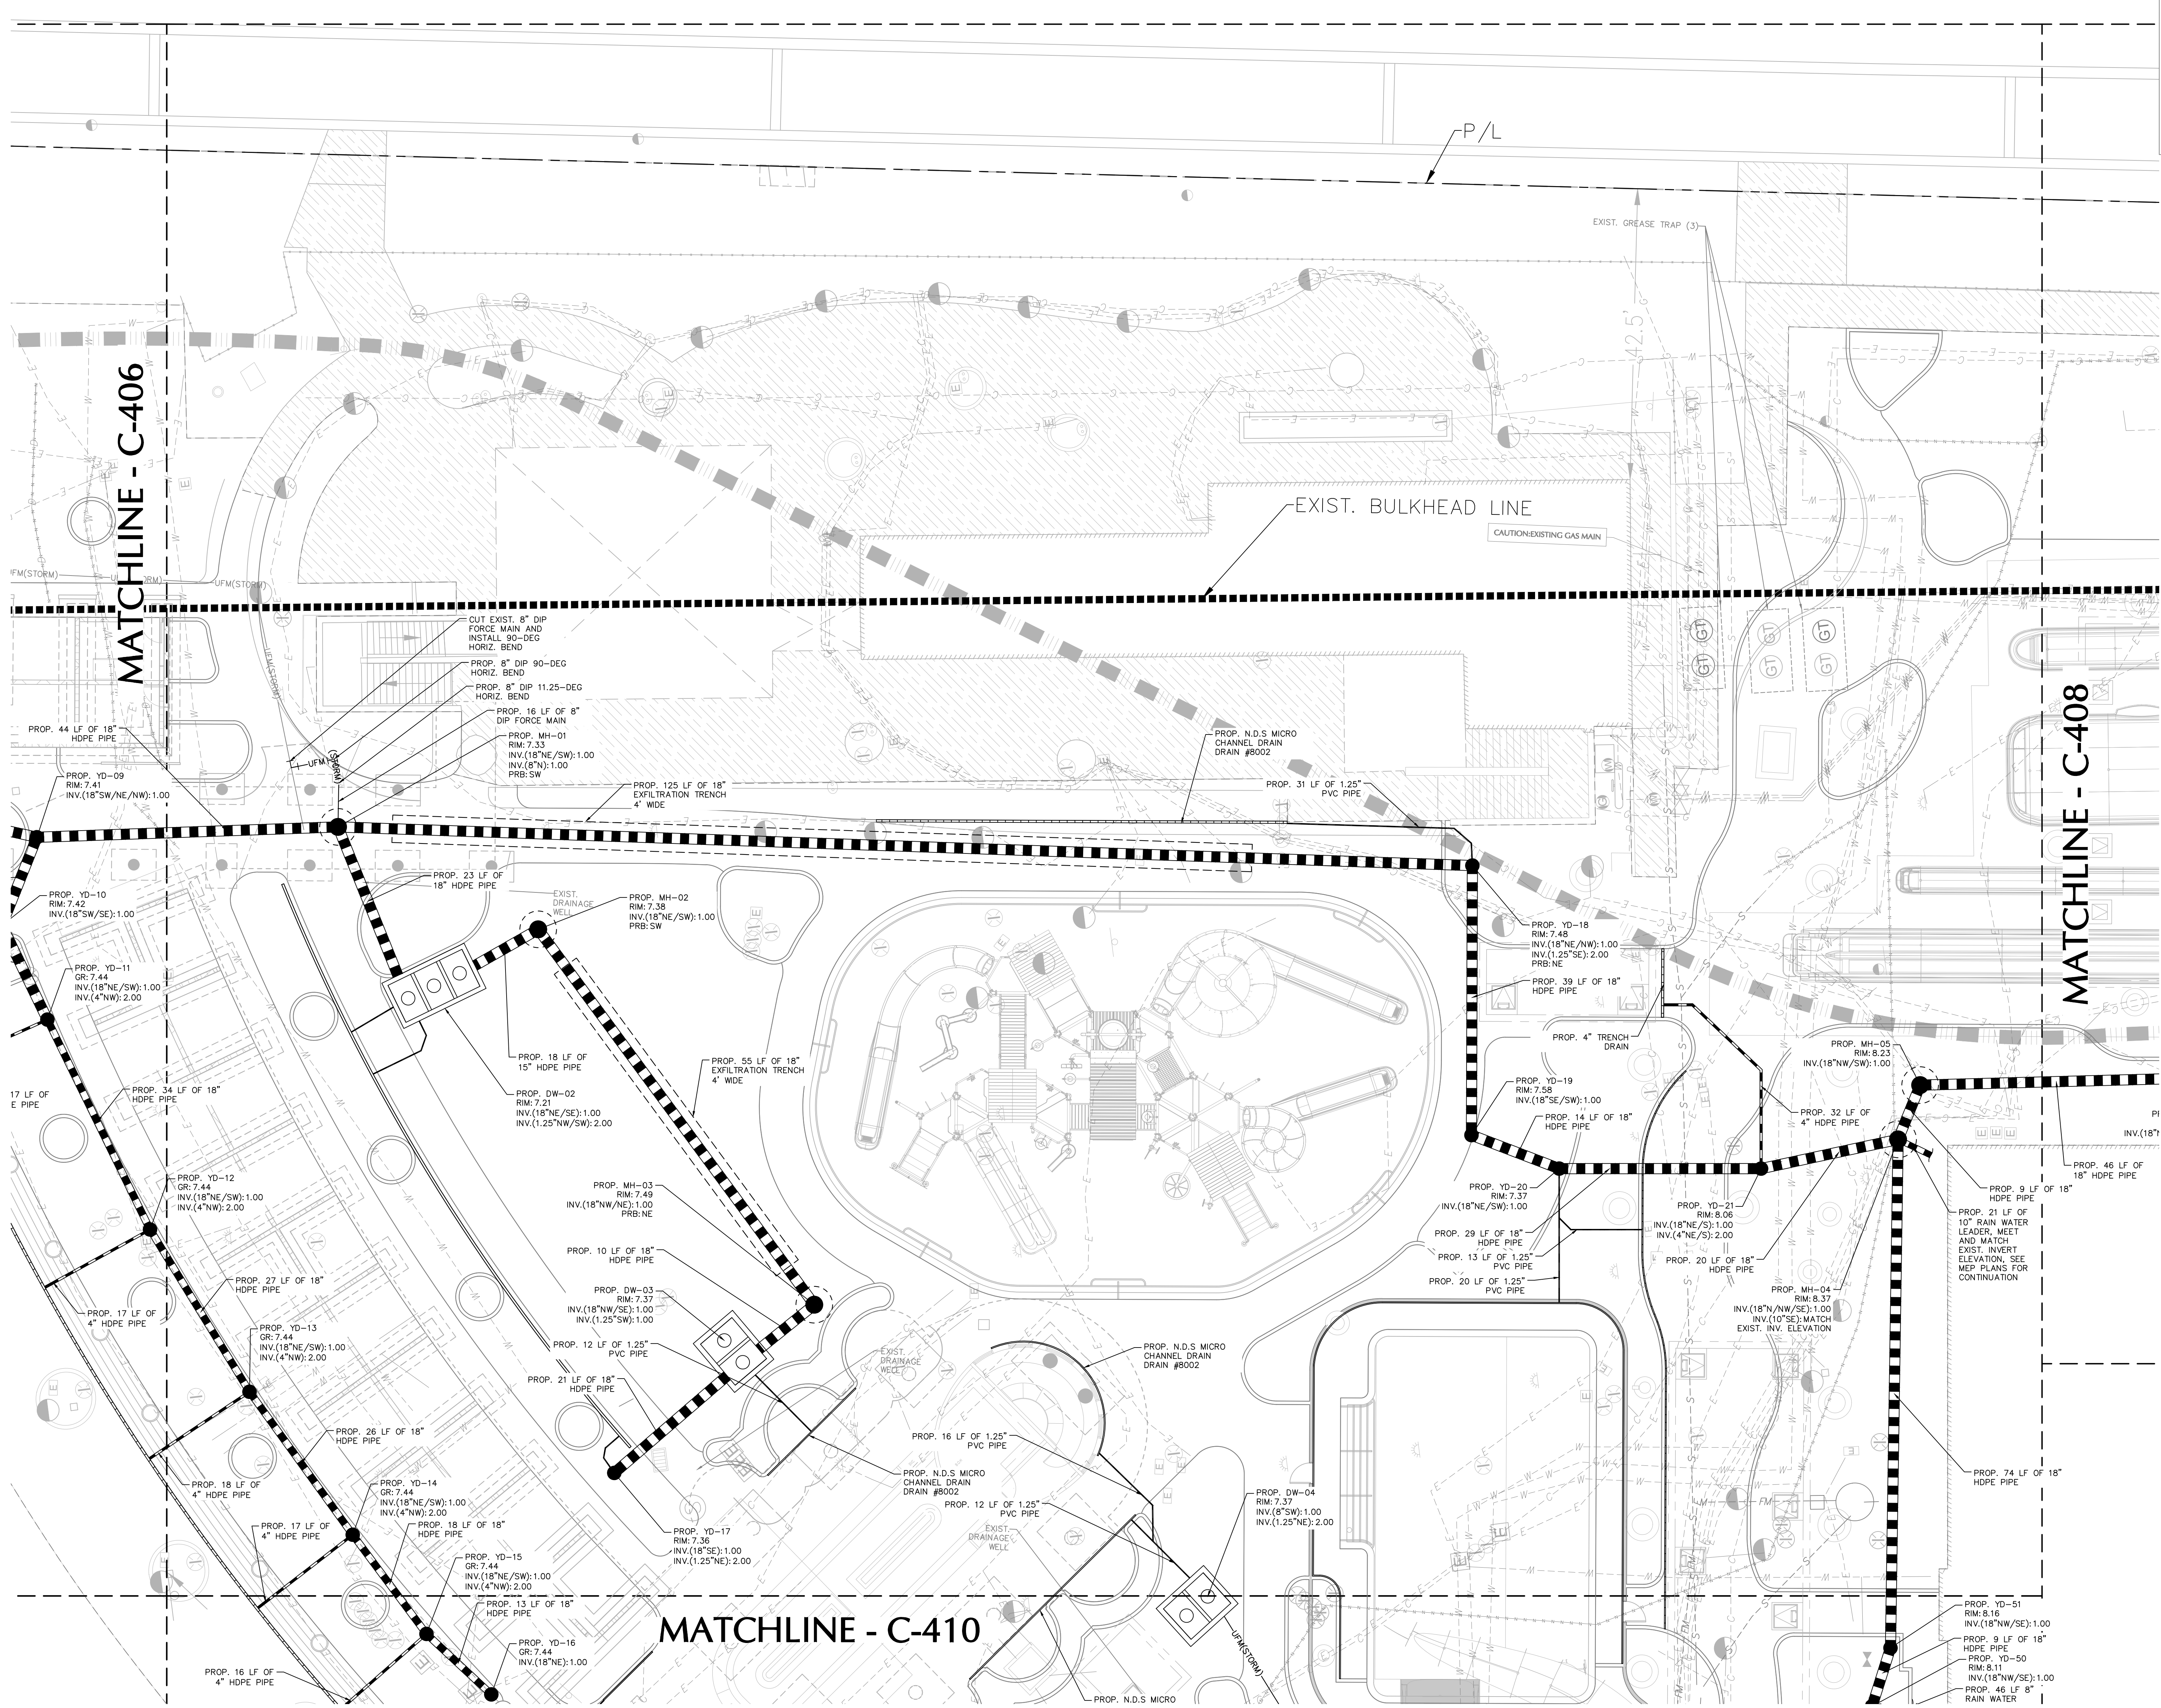

LANGAN
Langan Engineering and Environmental Services, LLC
1221 Brickell Ave, Suite 1800
Miami, FL 33131

T: 786.264.7200 F: 786.264.7201 www.langan.com
FBPE Registry No. 000660118917828818

6/16/2025 3:04:46 PM Autodesk Docs/107931817.000 - Fontainebleau Exterior Renovation/FBE-GEN-SHE-BLD-A.rvt

FONTAINEBLEAU DEVELOPMENT

4441 Collins Avenue Miami Beach FL 33140

Gensler

M. Arthur Gensler Jr. & Associates
FL Qualifier's Lic. No. AR95486
Tel 415.433.3700 Fax 415.836.4599
MAIN OFFICE
45 Fremont Street
Suite 1500
San Francisco, CA 94105
United States
SATELLITE OFFICE
545 N.W. 26th Street
Suite 250
Miami, FL 33127
United States
Tel 305.350.7070 Fax 305.350.7071

LANGAN

Fontainebleau Development
Ownership
19950 West Country Club
Drive, 10th Floor
Aventura, FL 33180
Tel 305.937.6262
Langan
Civil
1221 Brickell Avenue, Suite
1800
Miami, FL 33131
Tel 786.264.7200

DESIMONE

Desimone
Structural Engineer
100 Biscayne Boulevard, 15th
Floor
Miami, FL 33132
Tel 305.441.0755
Lifescapes (Landscape)
17461 Derian Ave, Suite 202
Irvine, CA 92614
Tel 949.476.8888

SCOTEC

Thompson Ehle Company
MEP
2 Sun Ct NW, Suite 450
Peachtree Corners, GA 30092
Tel 713.518.1426
SCOTEC (SLS)
Life Safety
260 Palermo Avenue
Coral Gables, FL 33134
Tel 888.224.9911

Crabtree McGrath

Crabtree McGrath Associates
Kitchen Consultant
161 West Main Street
Georgetown, MA 01833
Tel 978.352.8500
Cloward H2O
Aquatic Engineer
350 S. 400 W, Suite 200
Lindon, Utah 84042
Tel 801.375.1223

WHITewater

Whitewater
Slide Designer
180-8651 Fraserwood Pl
Richmond, BC, V6W 1J3
Canada
Tel 604.232.3307
DCL
DCL Orlando
Design Build
85 Bowwell St, Suite 1
Avon, MA 02322
Tel 617.542.9620

Environmental Solutions Coastal

Environmental Solutions
Coastal
7600 SW 125th Street
Pinecrest, FL 33156
Tel 305.479.8346
Longitude
Surveyor (GPR - As-built)
1128 Starclust Way
Royal Palm Beach, FL 33411
Tel 305.463.0912

David Plummer

David Plummer
Traffic
1750 Ponce De Leon Blvd
Coral Gables, FL 33134
Tel 305.447.0900

Date	Description



Seal / Signature
ANAMARIS TORRES SANCHEZ
LICENSE
No. 91085
STATE OF FLORIDA
PROFESSIONAL ENGINEER
07/18/2025
SIGNATURE: ANAMARIS TORRES SANCHEZ DATE SIGNED: 07/18/2025
PROFESSIONAL ENGINEER FL Lic. No. 91085

Project Name
Fontainebleau Exterior Renovation
Project Number
300370701
Description
PARTIAL DRAINAGE PLAN

Scale
1" = 10'-0"

C-408

LEGEND	
---	EXIST. SEWER FORCE MAIN
---	EXIST. DRAINAGE PIPE
---	EXIST. GAS LINE
---	EXIST. COMMUNICATION LINE
---	EXIST. ELECTRIC LINE
---	EXIST. SEWER MAIN/LATERAL
---	EXIST. WATER MAIN/SERVICE
---	UNKNOWN LINE
---	EXIST. EXFILTRATION TRENCH

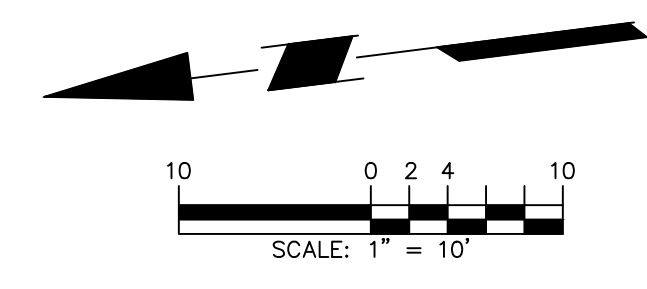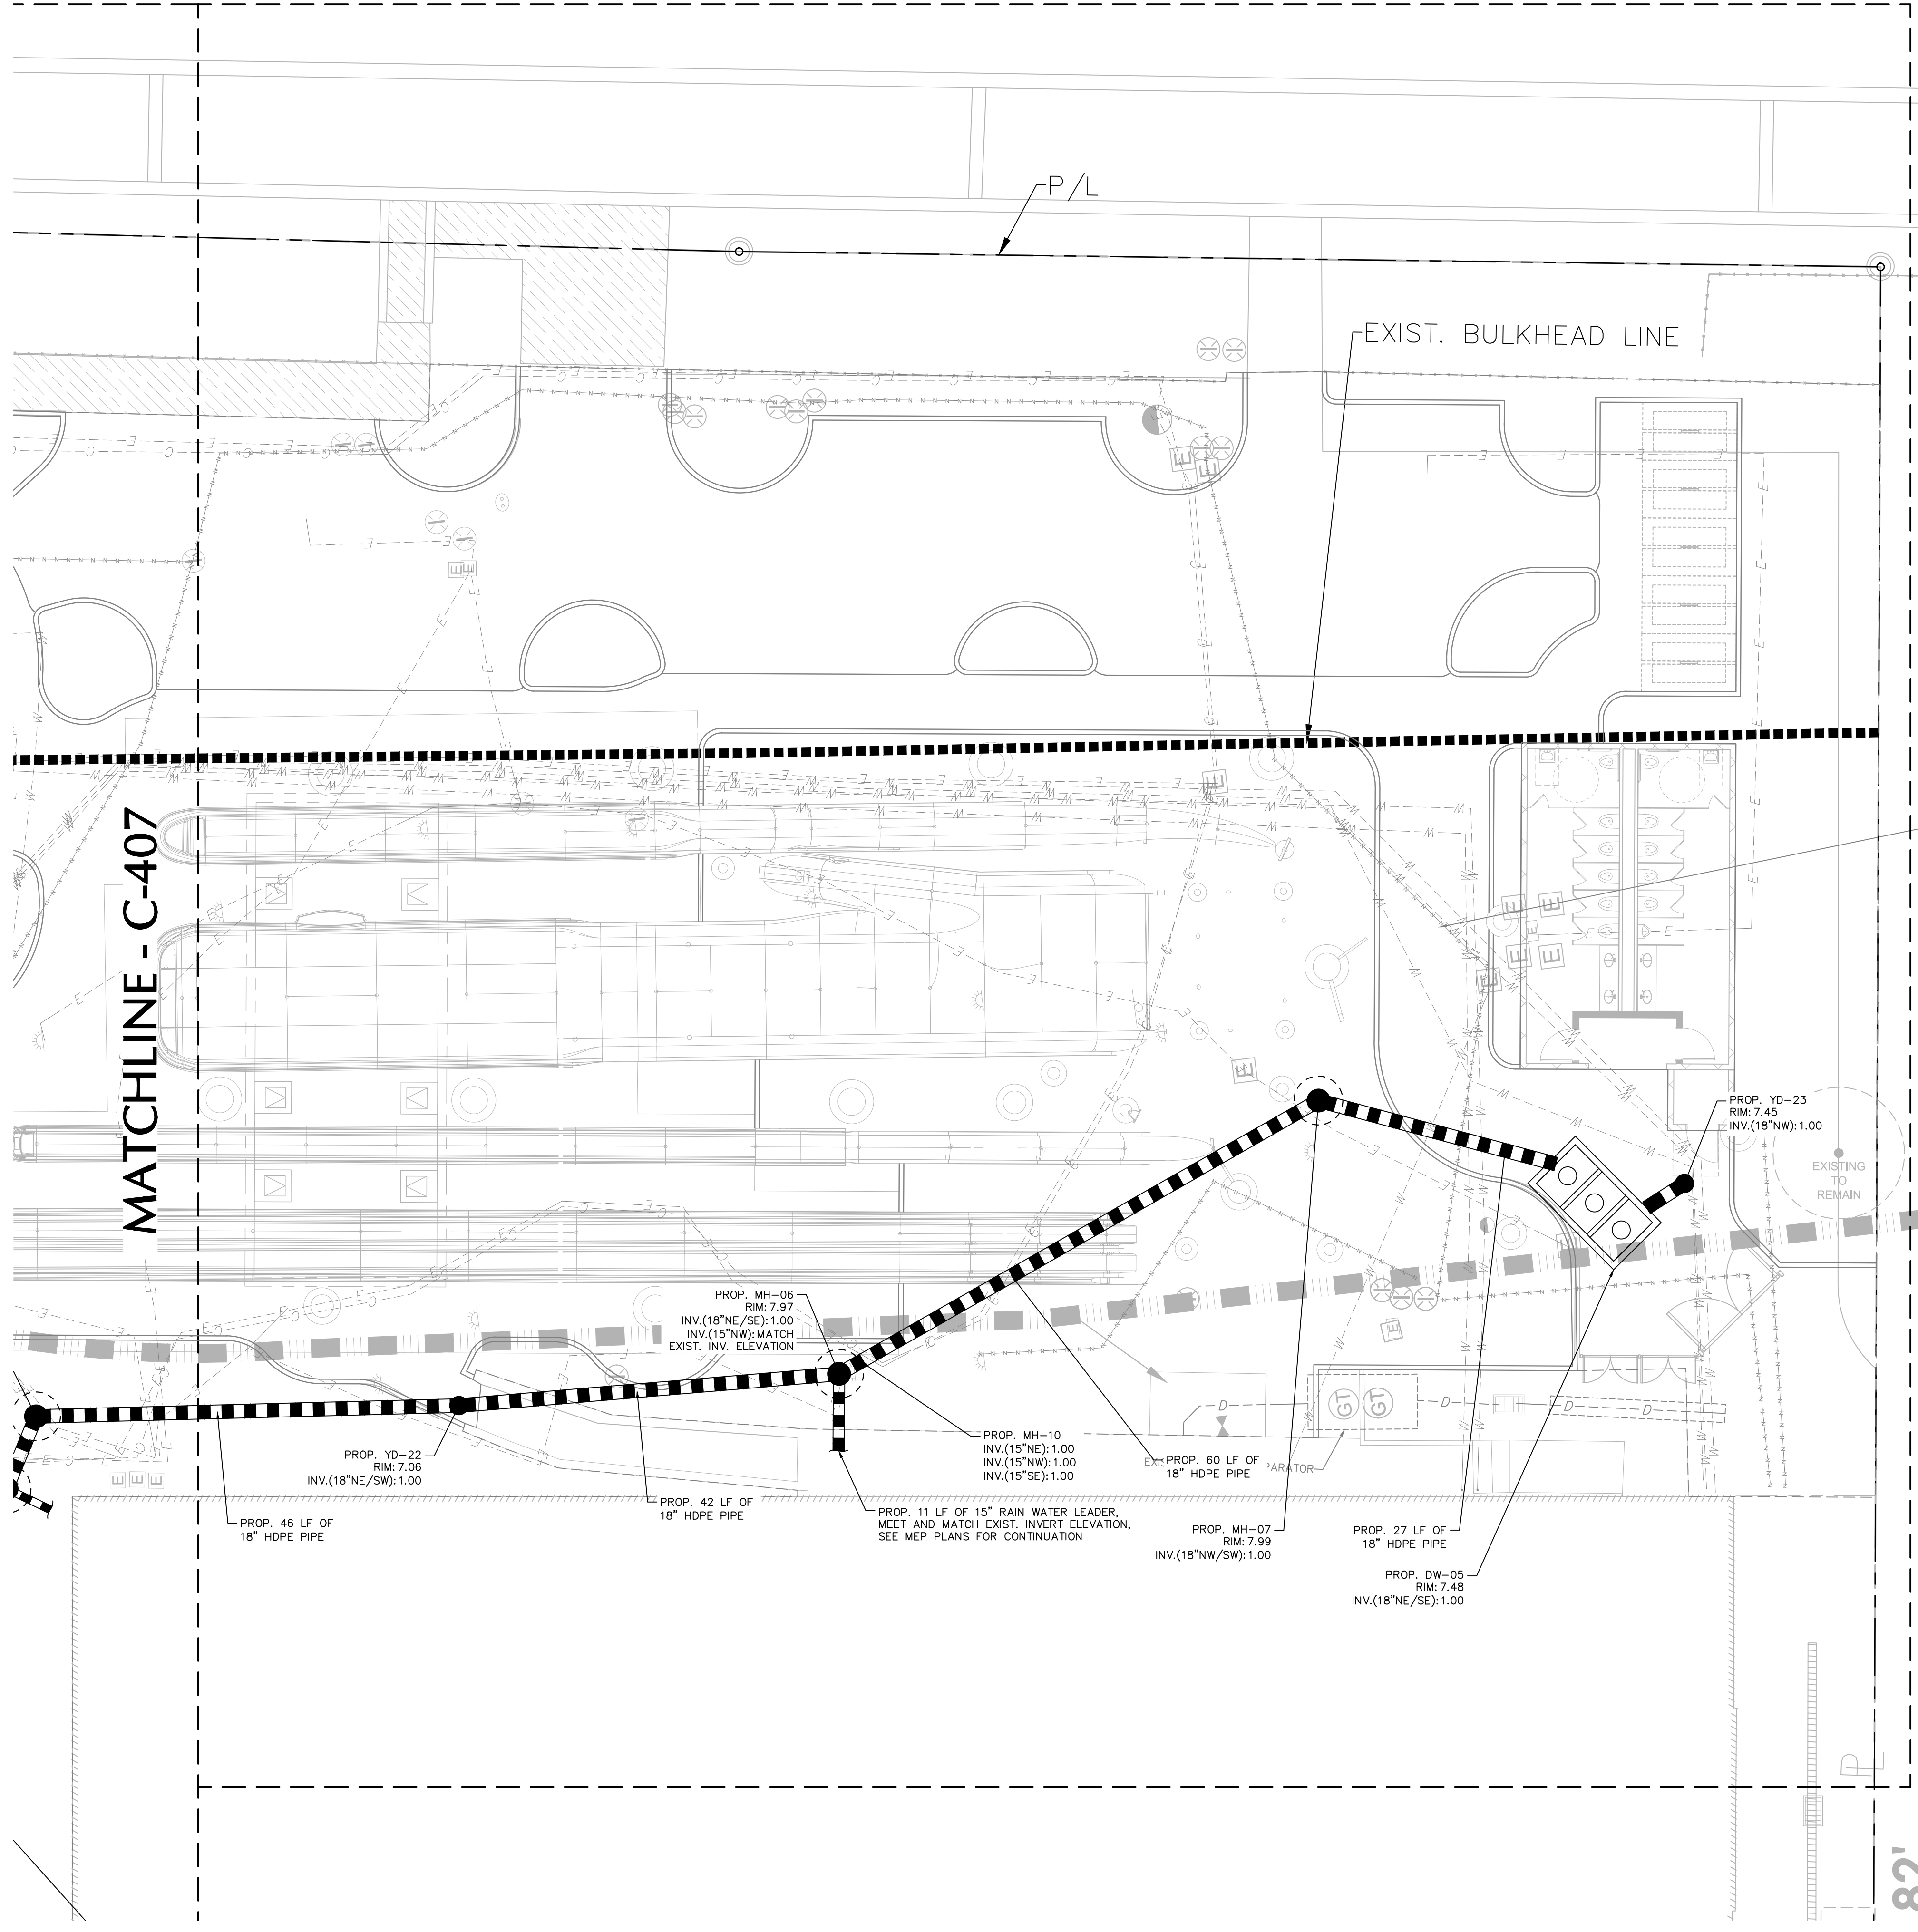

LANGAN
Langan Engineering and
Environmental Services, LLC
1221 Brickell Ave, Suite 1800
Miami, FL 33131

T: 786.264.7200 F: 786.264.7201 www.langan.com
FBPE Registry No. 00006601189172X8B198

FONTAINEBLEAU DEVELOPMENT

4441 Collins Avenue Miami Beach FL 33140

Gensler

M. Arthur Gensler Jr. & Associates
FL Qualifier's Lic. No. AR96486

MAIN OFFICE
45 Fremont Street
Suite 1500
San Francisco, CA 94105
United States

Tel 415.433.3700
Fax 415.836.4599

SATELLITE OFFICE
545 N.W. 26th Street
Suite 250
Miami, FL 33127
United States

Tel 305.350.7070
Fax 305.350.7071

FONTAINEBLEAU DEVELOPMENT

Fontainebleau Development
Ownership

19950 West Country Club
Drive, 10th Floor
Aventura, FL 33180
Tel 305.937.6262

LANGAN

Langan Civil

1221 Brickell Avenue, Suite
1800
Miami, FL 33131
Tel 786.264.7200



Lifescapes (Landscape)
17461 Derian Ave, Suite 202
Irvine, CA 92614
Tel 949.476.8888

DESIMONE

DeSimone
Structural Engineer

100 Biscayne Boulevard, 15th
Floor
Miami, FL 33132
Tel 305.441.0755



Thompson Ehle Company
MEP
2 Sun Ct NW, Suite 450
Peachtree Corners, GA 30092
Tel 713.518.1426



SOCOTEC
Scotced (SL)

Life Safety
260 Palermo Avenue
Coral Gables, FL 33134
Tel 888.224.9911



Crabtree McGrath Associates
Kitchen Consultant
161 West Main Street
Georgetown, MA 01833
Tel 978.352.8500



CLOWARD H2O
Aquatic Engineer

350 S. 400 W., Suite 200
London, Utah 84042
Tel 801.375.1223

 


Whitewater
Slide Designer
180-8651 Fraserwood Pl
Richmond, BC, V6W 1J3
Canada
Tel 604.232.3307




DCL Orlando
Design Build

85 Bowdoin St., Suite 1
Aron, MA 02322
Tel 617.542.9620



 Environmental Solutions
Coastal
7600 SW 125th Street
Pinecrest, FL 33156
Tel 305.479.8346



Longitude
Surveyor (GPR - As-built)

1128 Stardust Way
Royal Palm Beach, FL 33411
Tel 305.463.0912




David Plummer
Traffic

1750 Ponce De Leon Blvd
Coral Gables, FL 33134
Tel 305.447.0900

Date	Description

Seal / Signature

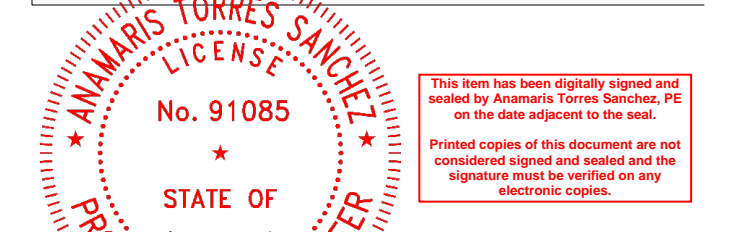

SIGNATURE: ANAMARIS TORRES SANCHEZ DATE SIGNED: 07/18/2025

PROFESSIONAL ENGINEER FL Lic. No. 91085

Project Name

Fontainebleau Exterior Renovation

Project Number

300370701

Description

PARTIAL DRAINAGE PLAN



Scale

1" = 10'-0"

C-409

LEGEND

	EXIST. SEWER FORCE MAIN
	EXIST. DRAINAGE FORCE MAIN
	EXIST. DRAINAGE PIPE
	EXIST. GAS LINE
	EXIST. COMMUNICATION LINE
	EXIST. ELECTRIC LINE
	EXIST. SEWER MAIN/LATERAL
	EXIST. WATER MAIN/SERVICE
	UNKNOWN LINE
	EXIST. EXFILTRATION TRENCH

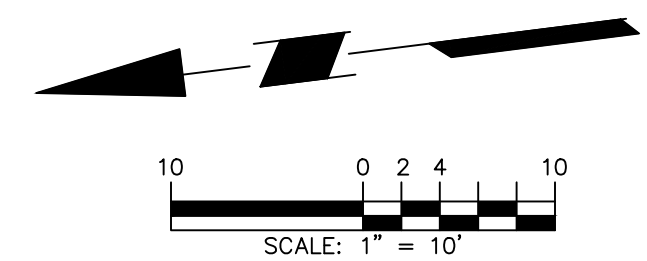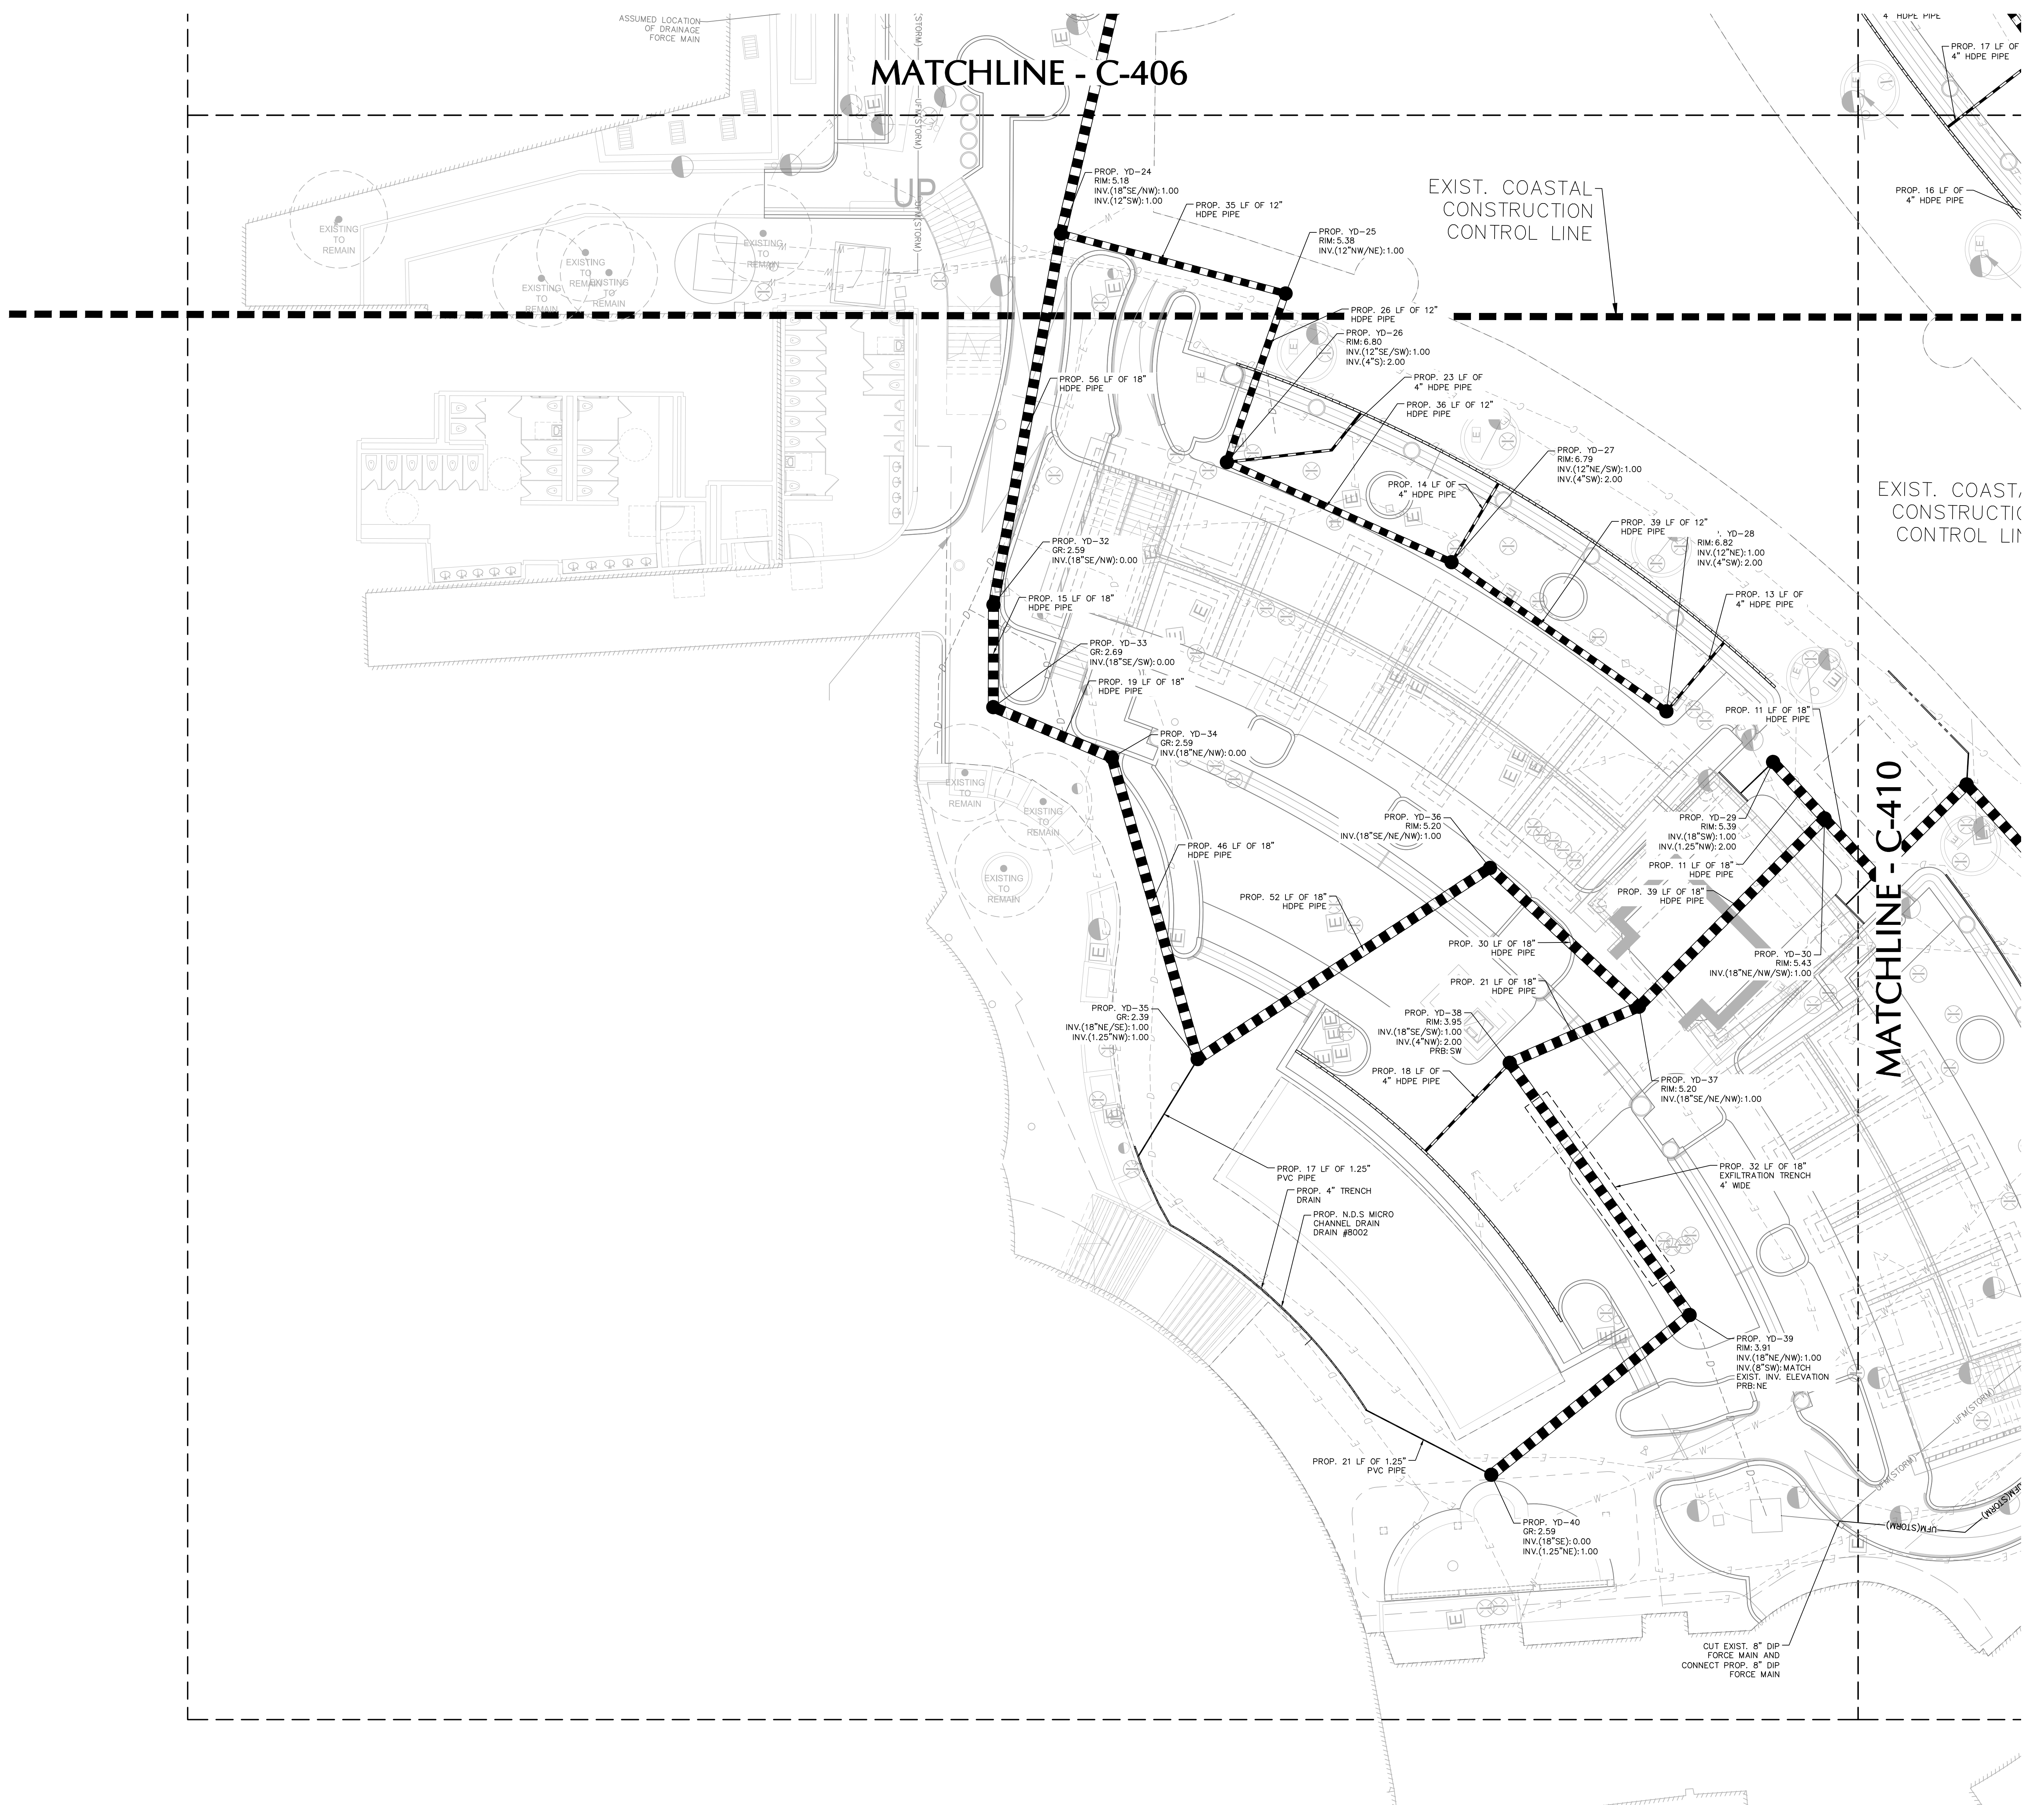

LANGAN
Langan Engineering and
Environmental Services, LLC
1221 Brickell Ave, Suite 1800
Miami, FL 33131

T: 786.264.7200 F: 786.264.7201 www.langan.com
FBPE Registry No. 0006601189172X8198

FONTAINEBLEAU DEVELOPMENT

4441 Collins Avenue Miami Beach FL 33140

Gensler

M. Arthur Gensler Jr. & Associates
FL Qualifier's Lic. No. AR95486

MAIN OFFICE
45 Fremont Street
Suite 1500
San Francisco, CA 94105
United States

Tel 415.433.3700
Fax 415.636.4599

SATELLITE OFFICE
545 N.W. 26th Street
Suite 250
Miami, FL 33127
United States

Tel 305.350.7070
Fax 305.350.7071

Fontainebleau Development
Ownership
19550 West Country Club
Drive, 10th Floor
Aventura, FL 33180
Tel 305.937.6262

LANGAN
Langan Civil
1221 Brickell Avenue, Suite
1800
Miami, FL 33131
Tel 786.264.7200

DESIMONE
Lifescapes (Landscape)
17461 Dorian Ave, Suite 202
Irvine, CA 92614
Tel 949.476.8888

DeSimone
Structural Engineer
100 Biscayne Boulevard, 15th
Floor
Miami, FL 33132
Tel 305.441.0755

Thompson Ehle Company
MEP
2 Sun Ct NW, Suite 450
Peachtree Corners, GA 30092
Tel 770.518.1426

SCOTEC
Scotect (SL) S
Life Safety
260 Palermo Avenue
Coral Gables, FL 33134
Tel 888.224.9911

Crabtree McGrath Associates
Kitchen Consultant
161 West Main Street
Georgetown, MA 01833
Tel 978.352.8500

CLOWARD H2O
Cloward H2O
Aquatic Engineer
350 S. 400 W., Suite 200
Lindon, Utah 84042
Tel 801.375.1223

Whitewater
Slide Designer
180-6651 Fraserwood Pl
Richmond, BC, V6W 1J3
Canada
Tel 604.232.3307

DCL
DCL Orlando
Design Build
85 Bowdoin St., Suite 1
Avon, MA 02322
Tel 617.542.9620

Environmental Solutions
Coastal
1129 Starclust Way
Pincrest, FL 33156
Tel 305.479.8346

LONGJUDE
LongJude
Surveyor (GPR - As-Built)
1129 Starclust Way
Royal Palm Beach, FL 33411
Tel 305.463.0912

dpa
David Plummer
Traffic
1750 Ponce De Leon Blvd
Coral Gables, FL 33134
Tel 305.447.0900

Date	Description

Seal / Signature
ANAMARIS TORRES SANCHEZ
No. 91085
STATE OF FLORIDA
PROFESSIONAL ENGINEER
07/18/2025
DATE SIGNED
PROFESSIONAL ENGINEER FL Lic. No. 91085



Project Name
**Fontainebleau Exterior
Renovation**
Project Number
300370701
Description
PARTIAL DRAINAGE PLAN

Scale
1" = 10'-0"

C-410

LEGEND

---	EXIST. SEWER FORCE MAIN
---	EXIST. DRAINAGE FORCE MAIN
---	EXIST. DRAINAGE PIPE
---	EXIST. GAS LINE
---	EXIST. COMMUNICATION LINE
---	EXIST. ELECTRIC LINE
---	EXIST. SEWER MAIN/LATERAL
---	EXIST. WATER MAIN/SERVICE
---	UNKNOWN LINE
---	EXIST. EXFILTRATION TRENCH

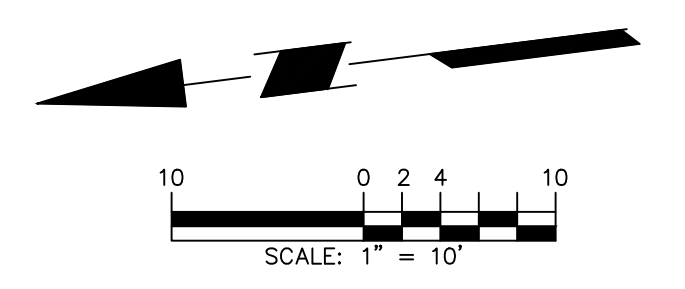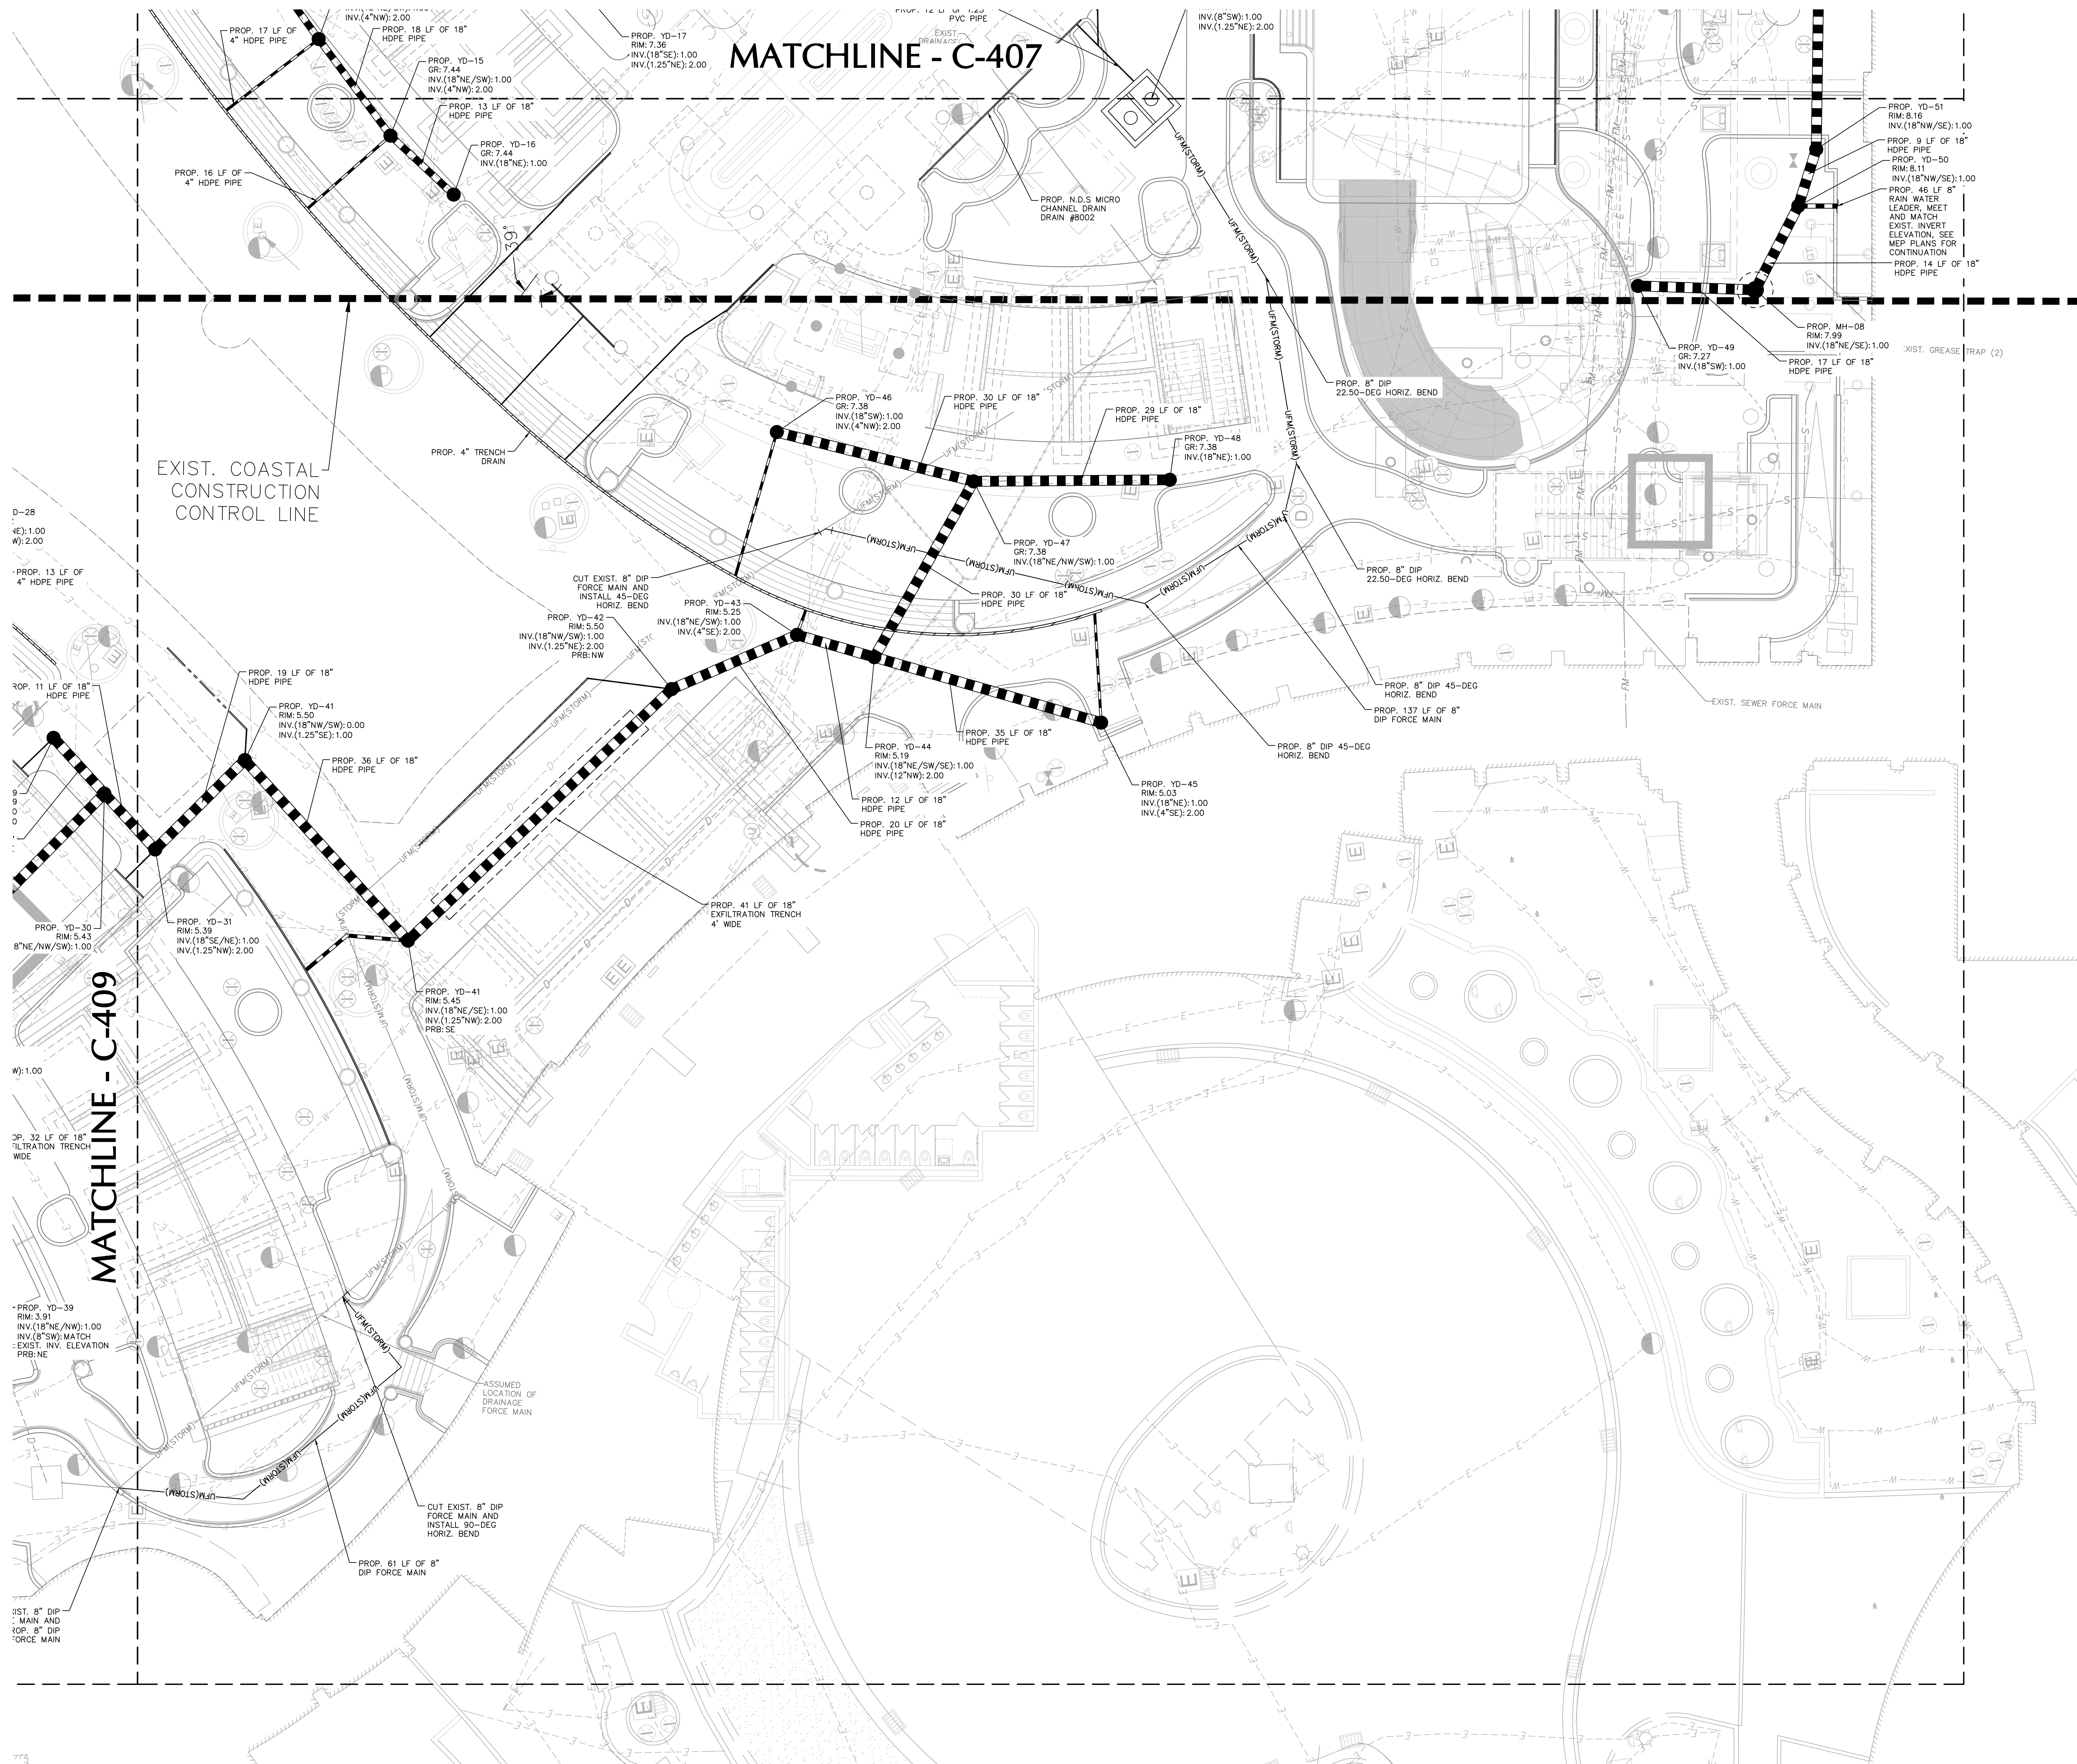

LANGAN
Langan Engineering and
Environmental Services, LLC
1221 Brickell Ave, Suite 1800
Miami, FL 33131

T: 786.264.7200 F: 786.264.7201 www.langan.com
FBPE Registry No. 00006601189172X2B198

FONTAINEBLEAU DEVELOPMENT

4441 Collins Avenue Miami Beach FL 33140

Gensler

M. Arthur Gensler Jr. & Associates
FL Qualifier's Lic. No. AR96486
MAIN OFFICE: 45 Fremont Street, Suite 1500, San Francisco, CA 94105, United States. Tel: 415.433.3700, Fax: 415.836.4599
SATELLITE OFFICE: 545 N.W. 26th Street, Suite 250, Miami, FL 33127, United States. Tel: 305.350.7070, Fax: 305.350.7071

LANGAN

Fontainebleau Development Ownership
19950 West Country Club Drive, 10th Floor, Aventura, FL 33180
Tel: 305.937.6262

DESIMONE

Desimone Structural Engineer
100 Biscayne Boulevard, 15th Floor, Miami, FL 33132
Tel: 305.441.0755

SOCOTEC

SOCOTEC (SLS) Life Safety
260 Palermo Avenue, Coral Gables, FL 33134
Tel: 888.224.9911

CLWARD H2O

Clward H2O Aquatic Engineer
350 S. 400 W., Suite 200, Lindon, Utah 84042
Tel: 801.375.1223

DCL

DCL Orlando Design Build
85 Bowdell St., Suite 1, Avon, MA 02322
Tel: 617.542.8620

LONGITUDE

Longitude Surveyor (GPR - As-built)
1128 St. Lucie Way, Royal Palm Beach, FL 33411
Tel: 305.463.0912

DAVID PLUMMER

David Plummer Traffic
1750 Ponce De Leon Blvd, Coral Gables, FL 33134
Tel: 305.447.0900

Date	Description





Seal / Signature

ANAMARIS TORRES SANCHEZ
PROFESSIONAL ENGINEER FL Lic. No. 91085






Project Name: Fontainebleau Exterior Renovation
Project Number: 300370701
Description: CUT/FILL EXHIBIT

Scale: 1" = 40'-0"

EXH-1

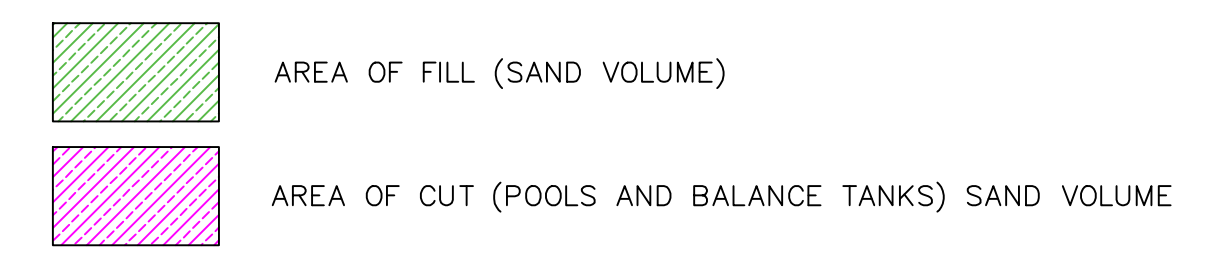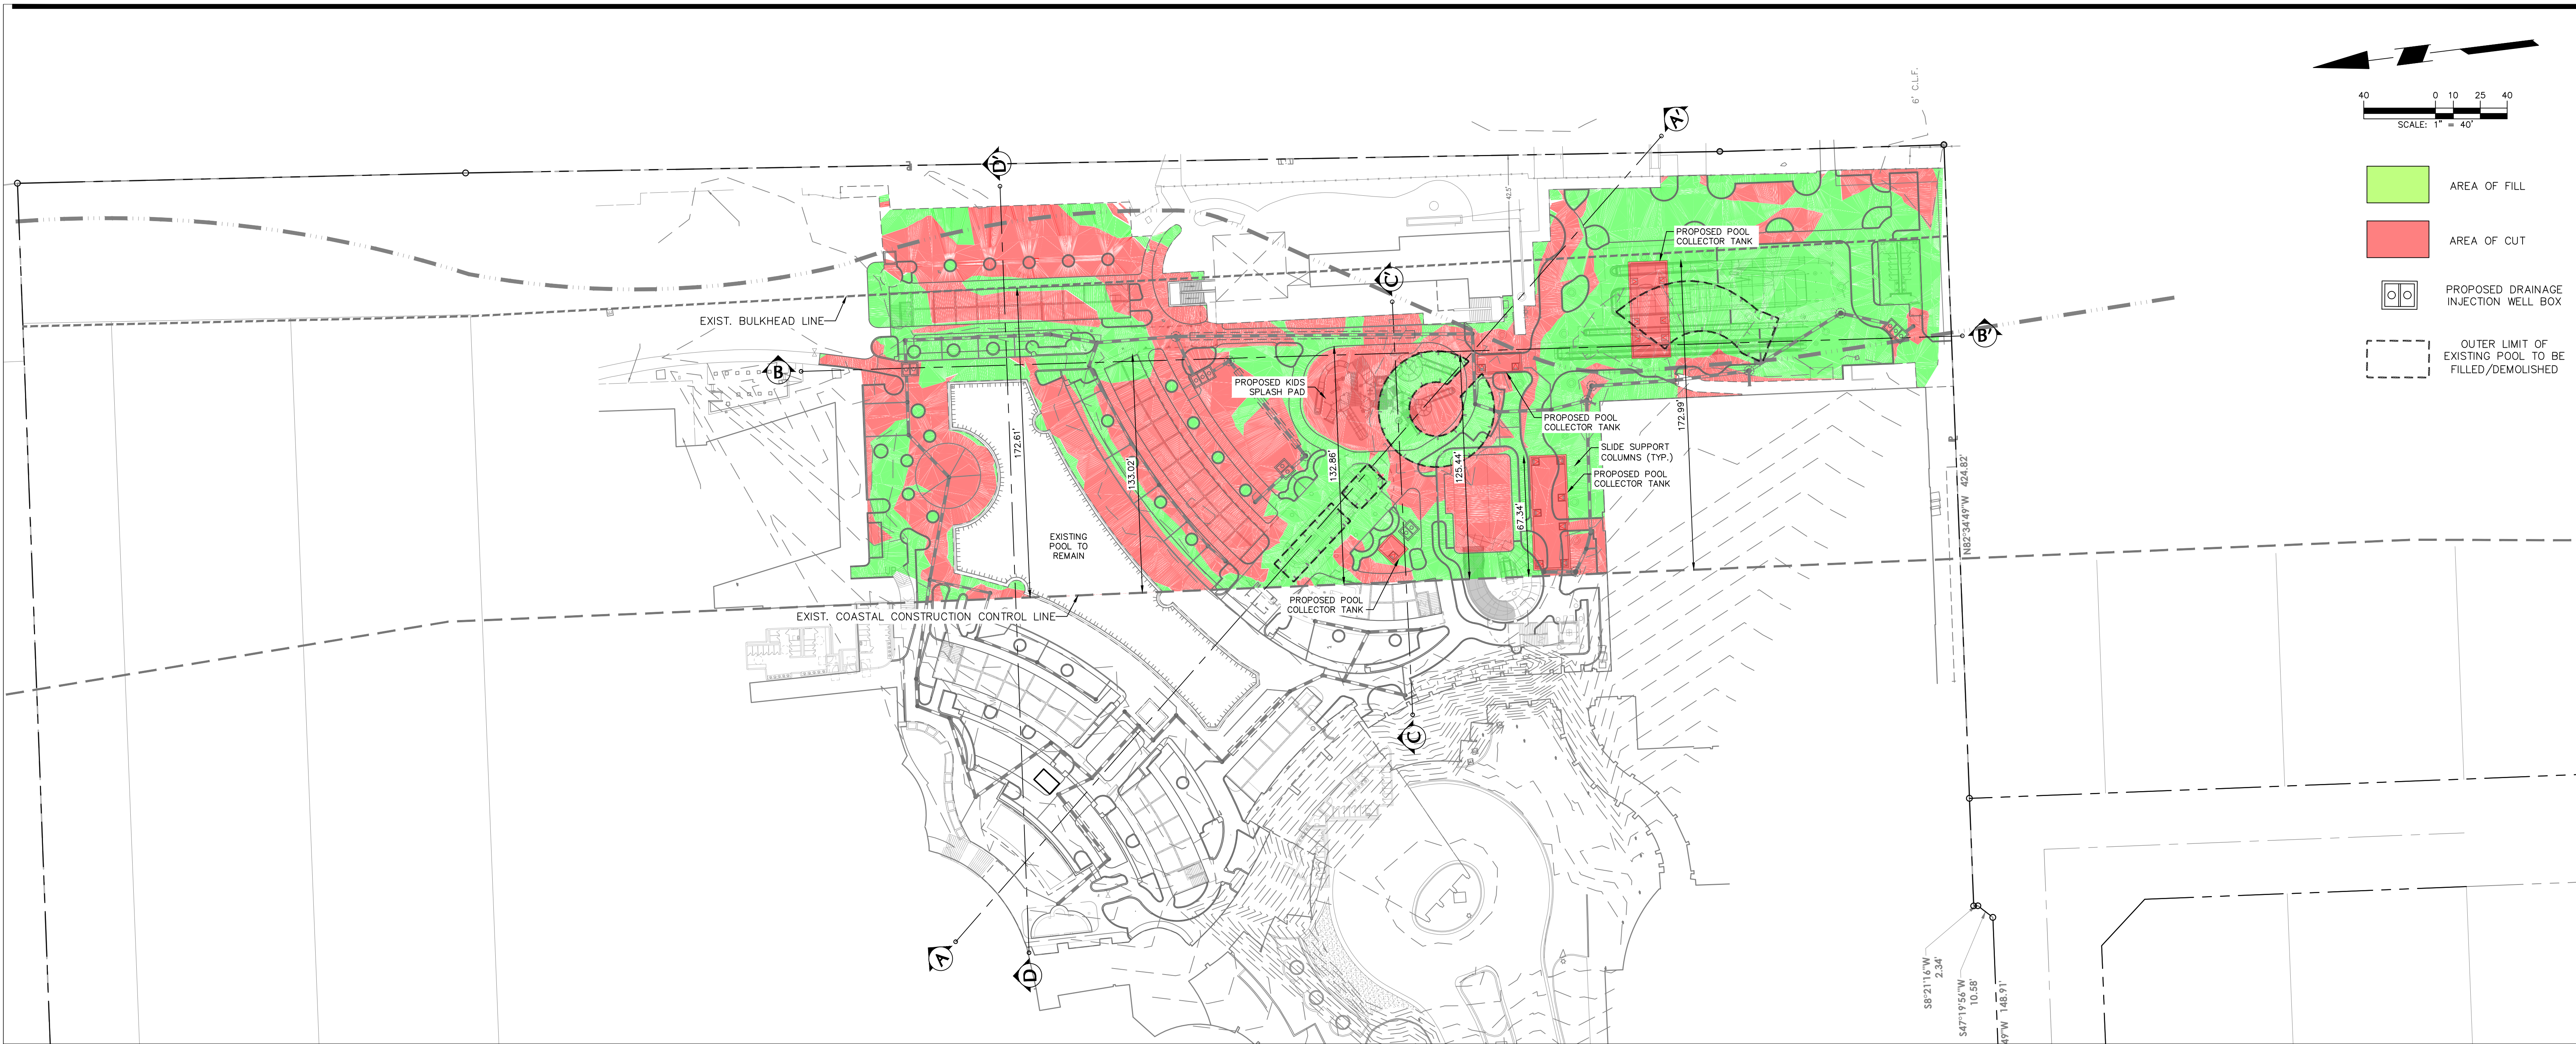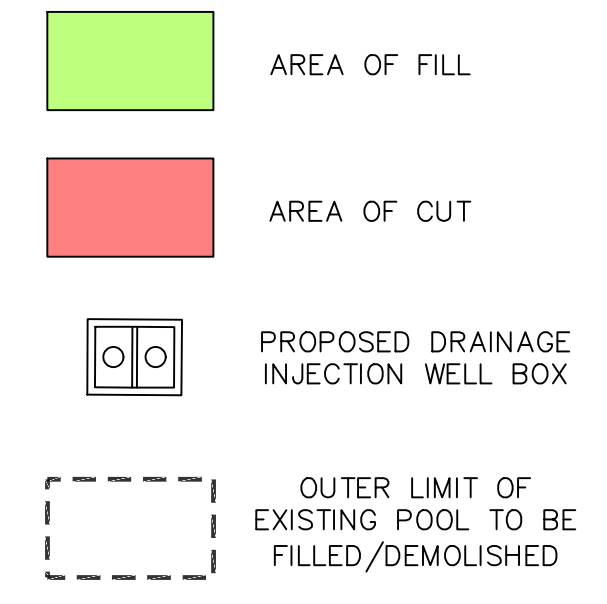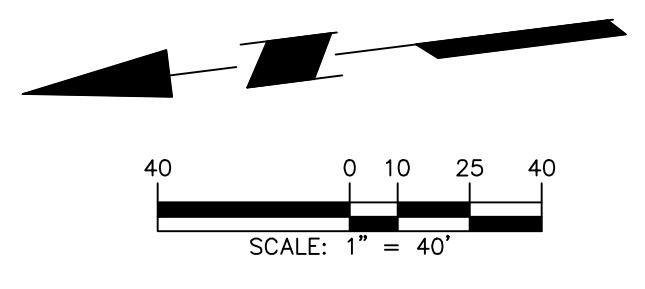

CUT & FILL CALCULATION TABULATION		
CUT FROM POOLS AND BALANCE TANKS	1,400	cu.yds.
CUT FROM SLIDE SUPPORT FOUNDATIONS (PILE CAP+PILES)	11,500	cu.yds.
CUT FROM CABANA AND ELEVATED POOL FOUNDATIONS	200	cu.yds.
CUT FROM DRAINAGE STRUCTURES	80	cu.yds.
TOTAL GROSS CUT VOLUME EAST OF CCCL (SANDY MATERIAL ONLY)	13,180	cu.yds.
LESS VOLUME OF FILL (SANDY MATERIAL) TO BE FILLED/DEMOLISHED	300	cu.yds.
LESS VOLUME OF FILL (SANDY MATERIAL) TO BE TAKEN OFFSITE	12,880	cu.yds.
TOTAL NET NET EXCAVATION VOLUME	0	cu.yds.

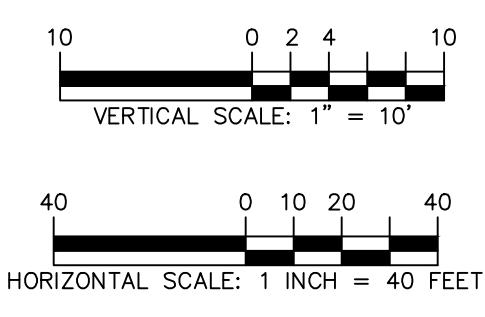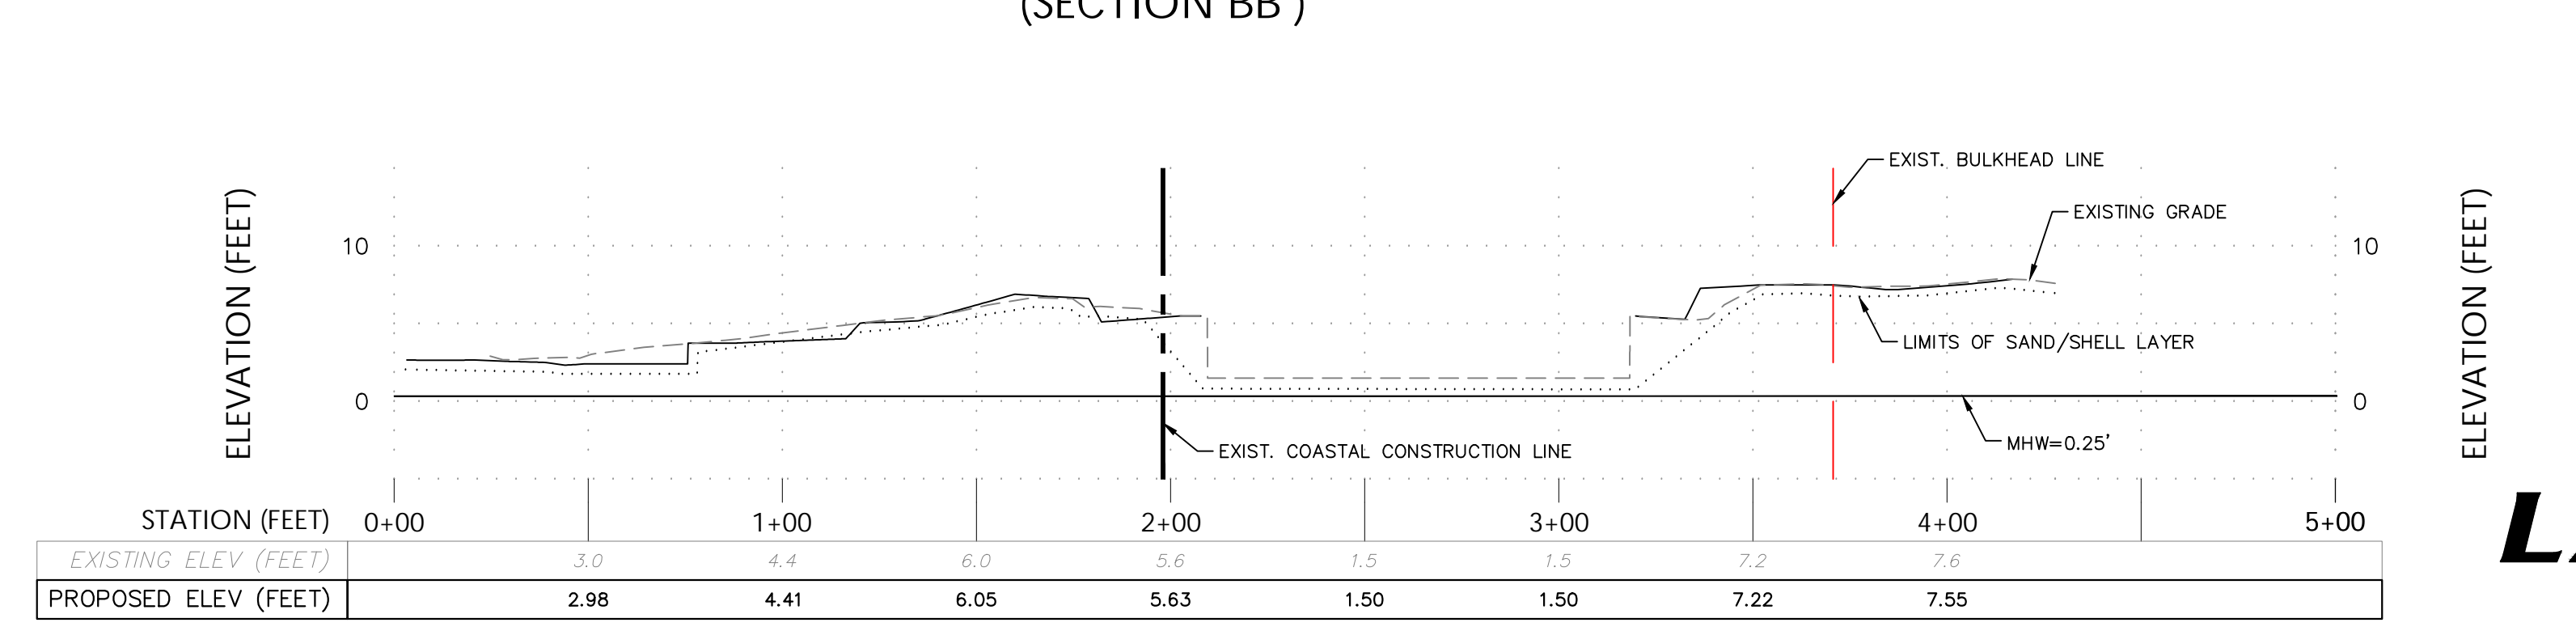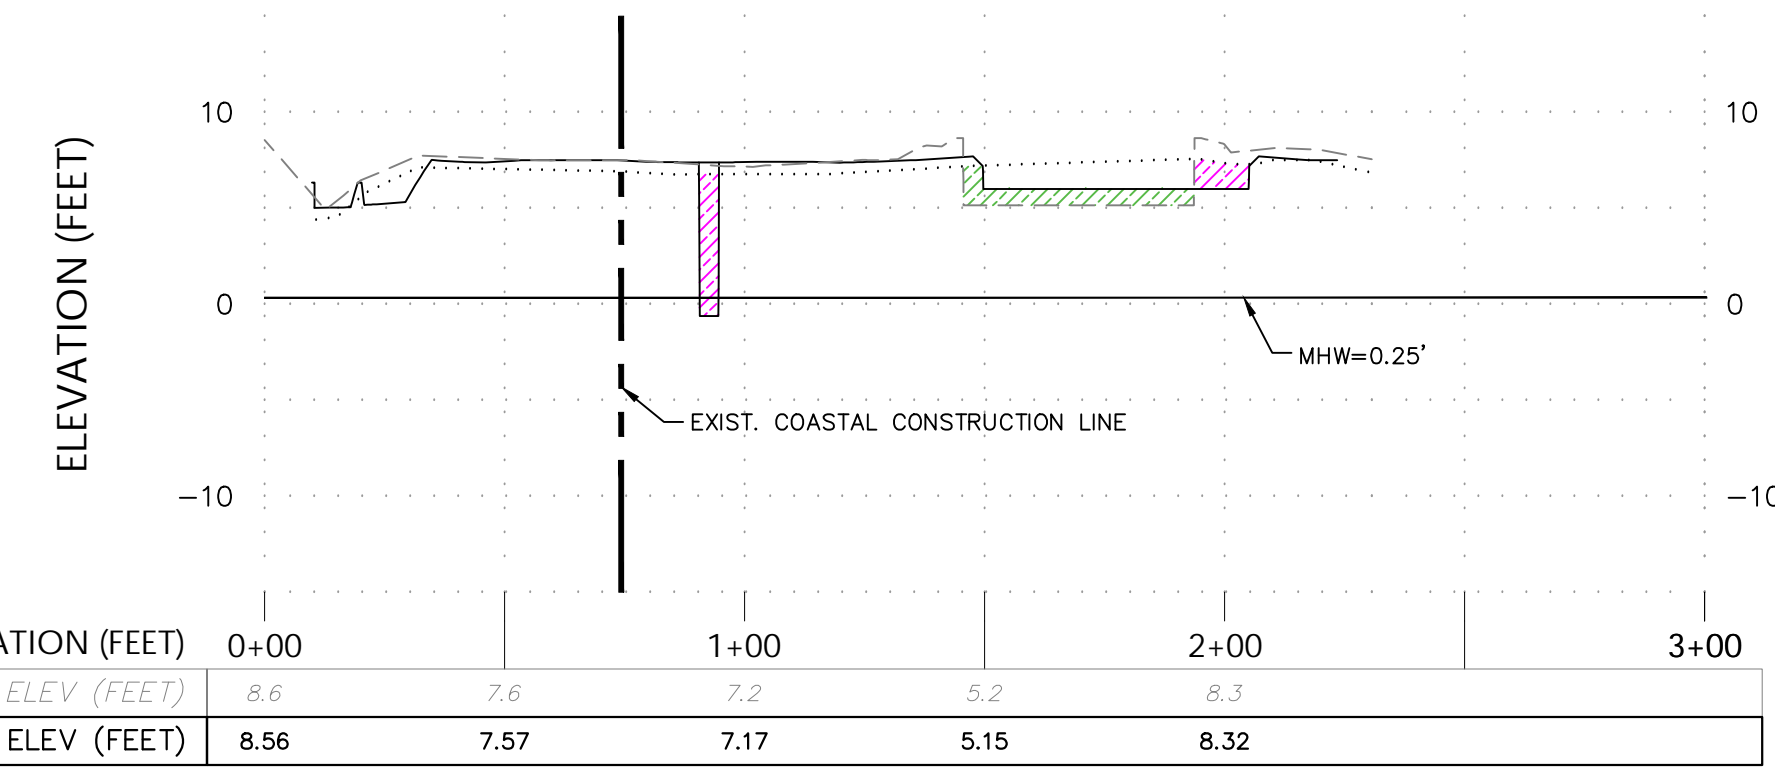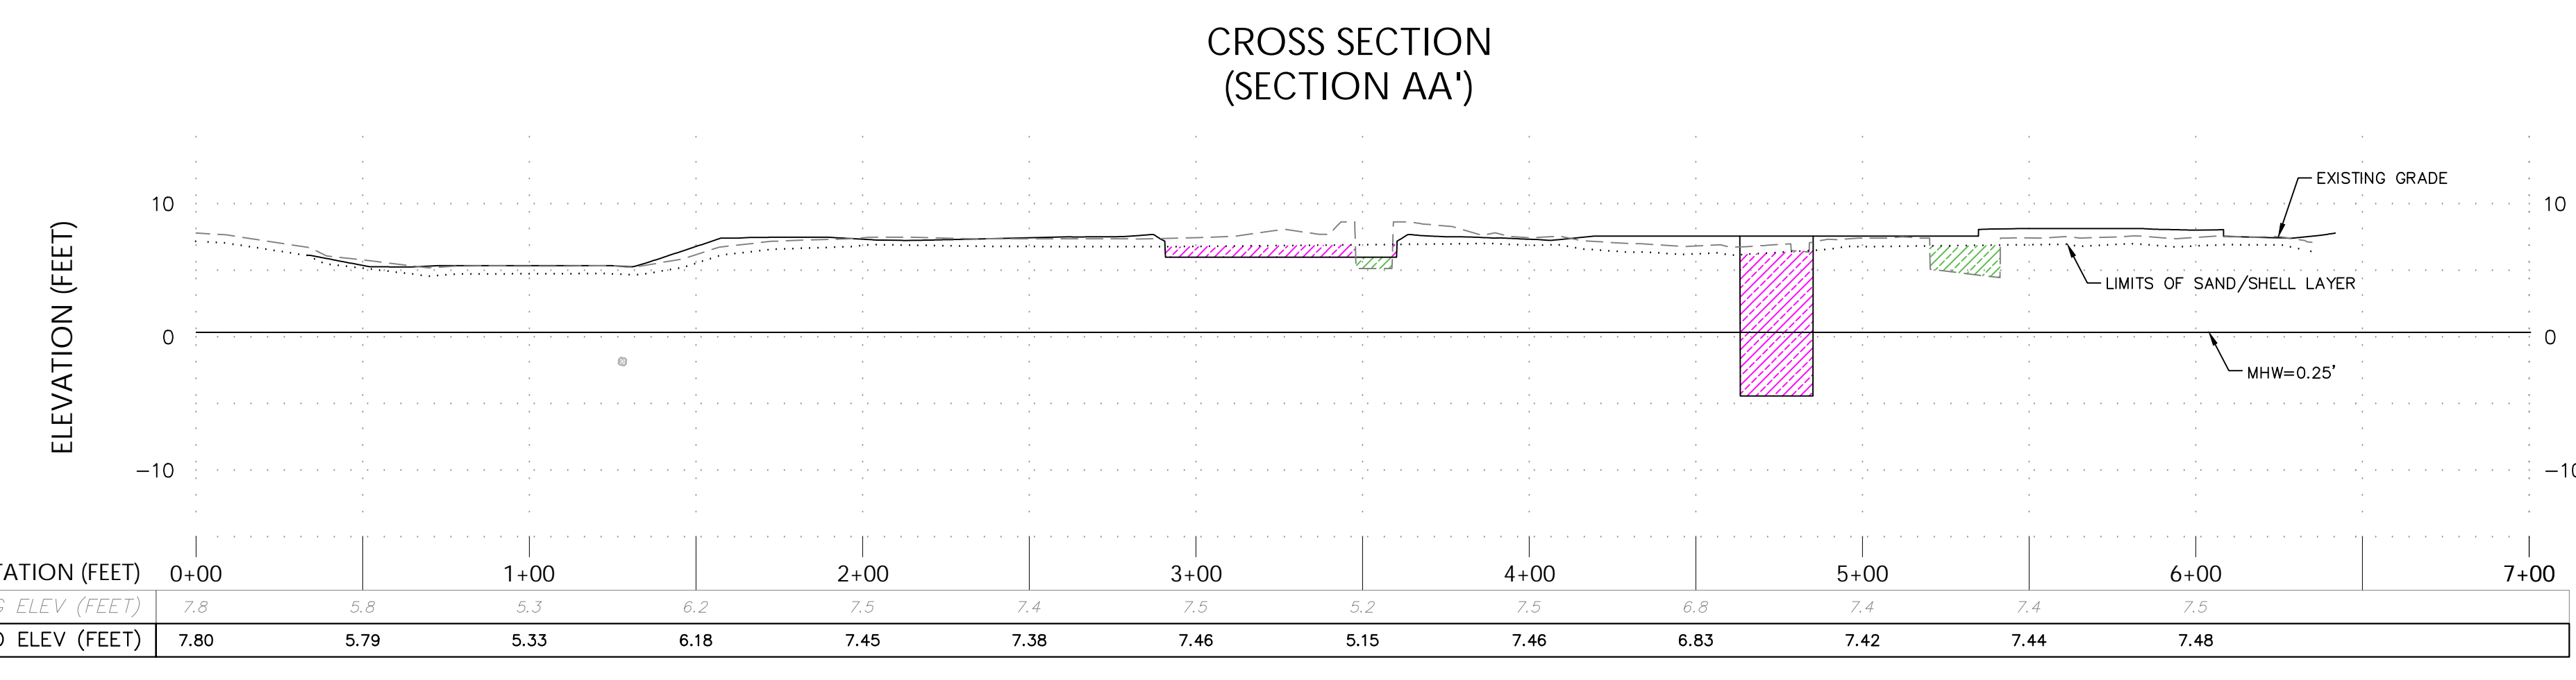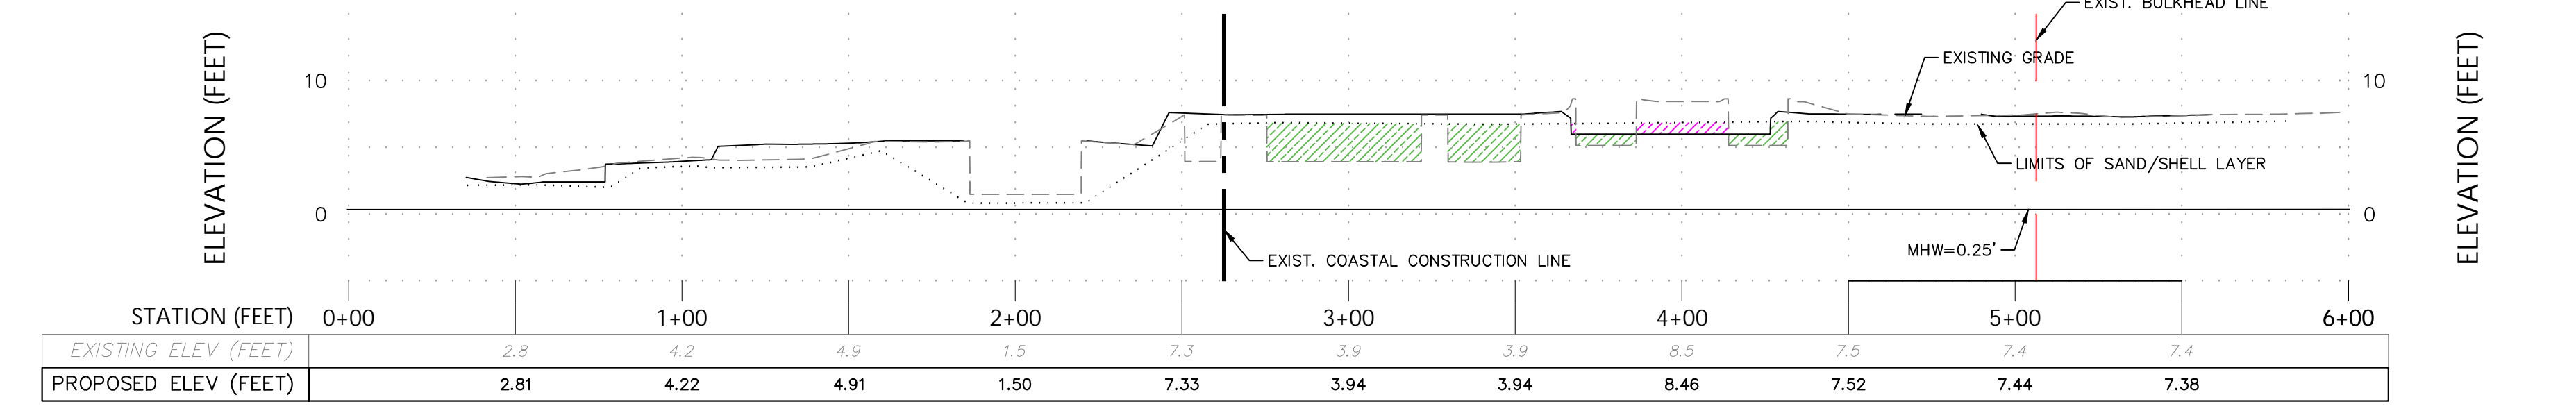

LANGAN

Langan Engineering and Environmental Services, LLC
1221 Brickell Ave, Suite 1800, Miami, FL 33131
T: 786.264.7200 F: 786.264.7201 www.langan.com
FBPE Registry No. 000666011, 081723, 08198

Date: 7/18/2025 Time: 13:36 User: itococorin Style Table: 18/2022 Langan EXH-1 Document Code: 300370701-0501-CG101-01