









**GENERAL LIGHTING NOTES**

A REFER TO MARRAS LIGHTING DESIGN'S FIXTURE SCHEDULE AND CUT-SHEETS FOR FIXTURE INFORMATION

**KEYNOTES**

**REVISIONS**

NO. DATE

LIGHTING KEY	
	VINTAGE CHANDELIER
	CEILING DECORATIVE
	RECESSED DOWNLIGHT
	LUMINOUS LED PANEL
	WALL SCONCE
	SURFACE MOUNTED MONOPOINT
	LINEAR LED
	TABLE LAMP
	STANDING LAMP

**INTERNATIONAL INN**

**INTERIOR LIGHTING  
CONCEPT PLAN**

Title: LOBBY LIGHTING CONCEPT  
 Design: JCM, RC  
 Drafted: ST  
 Submission Date: 05/08/23  
 Submitted To: Historic Preservation Board  
 Sheet: 1  
 LP.01


**GENERAL LIGHTING NOTES**








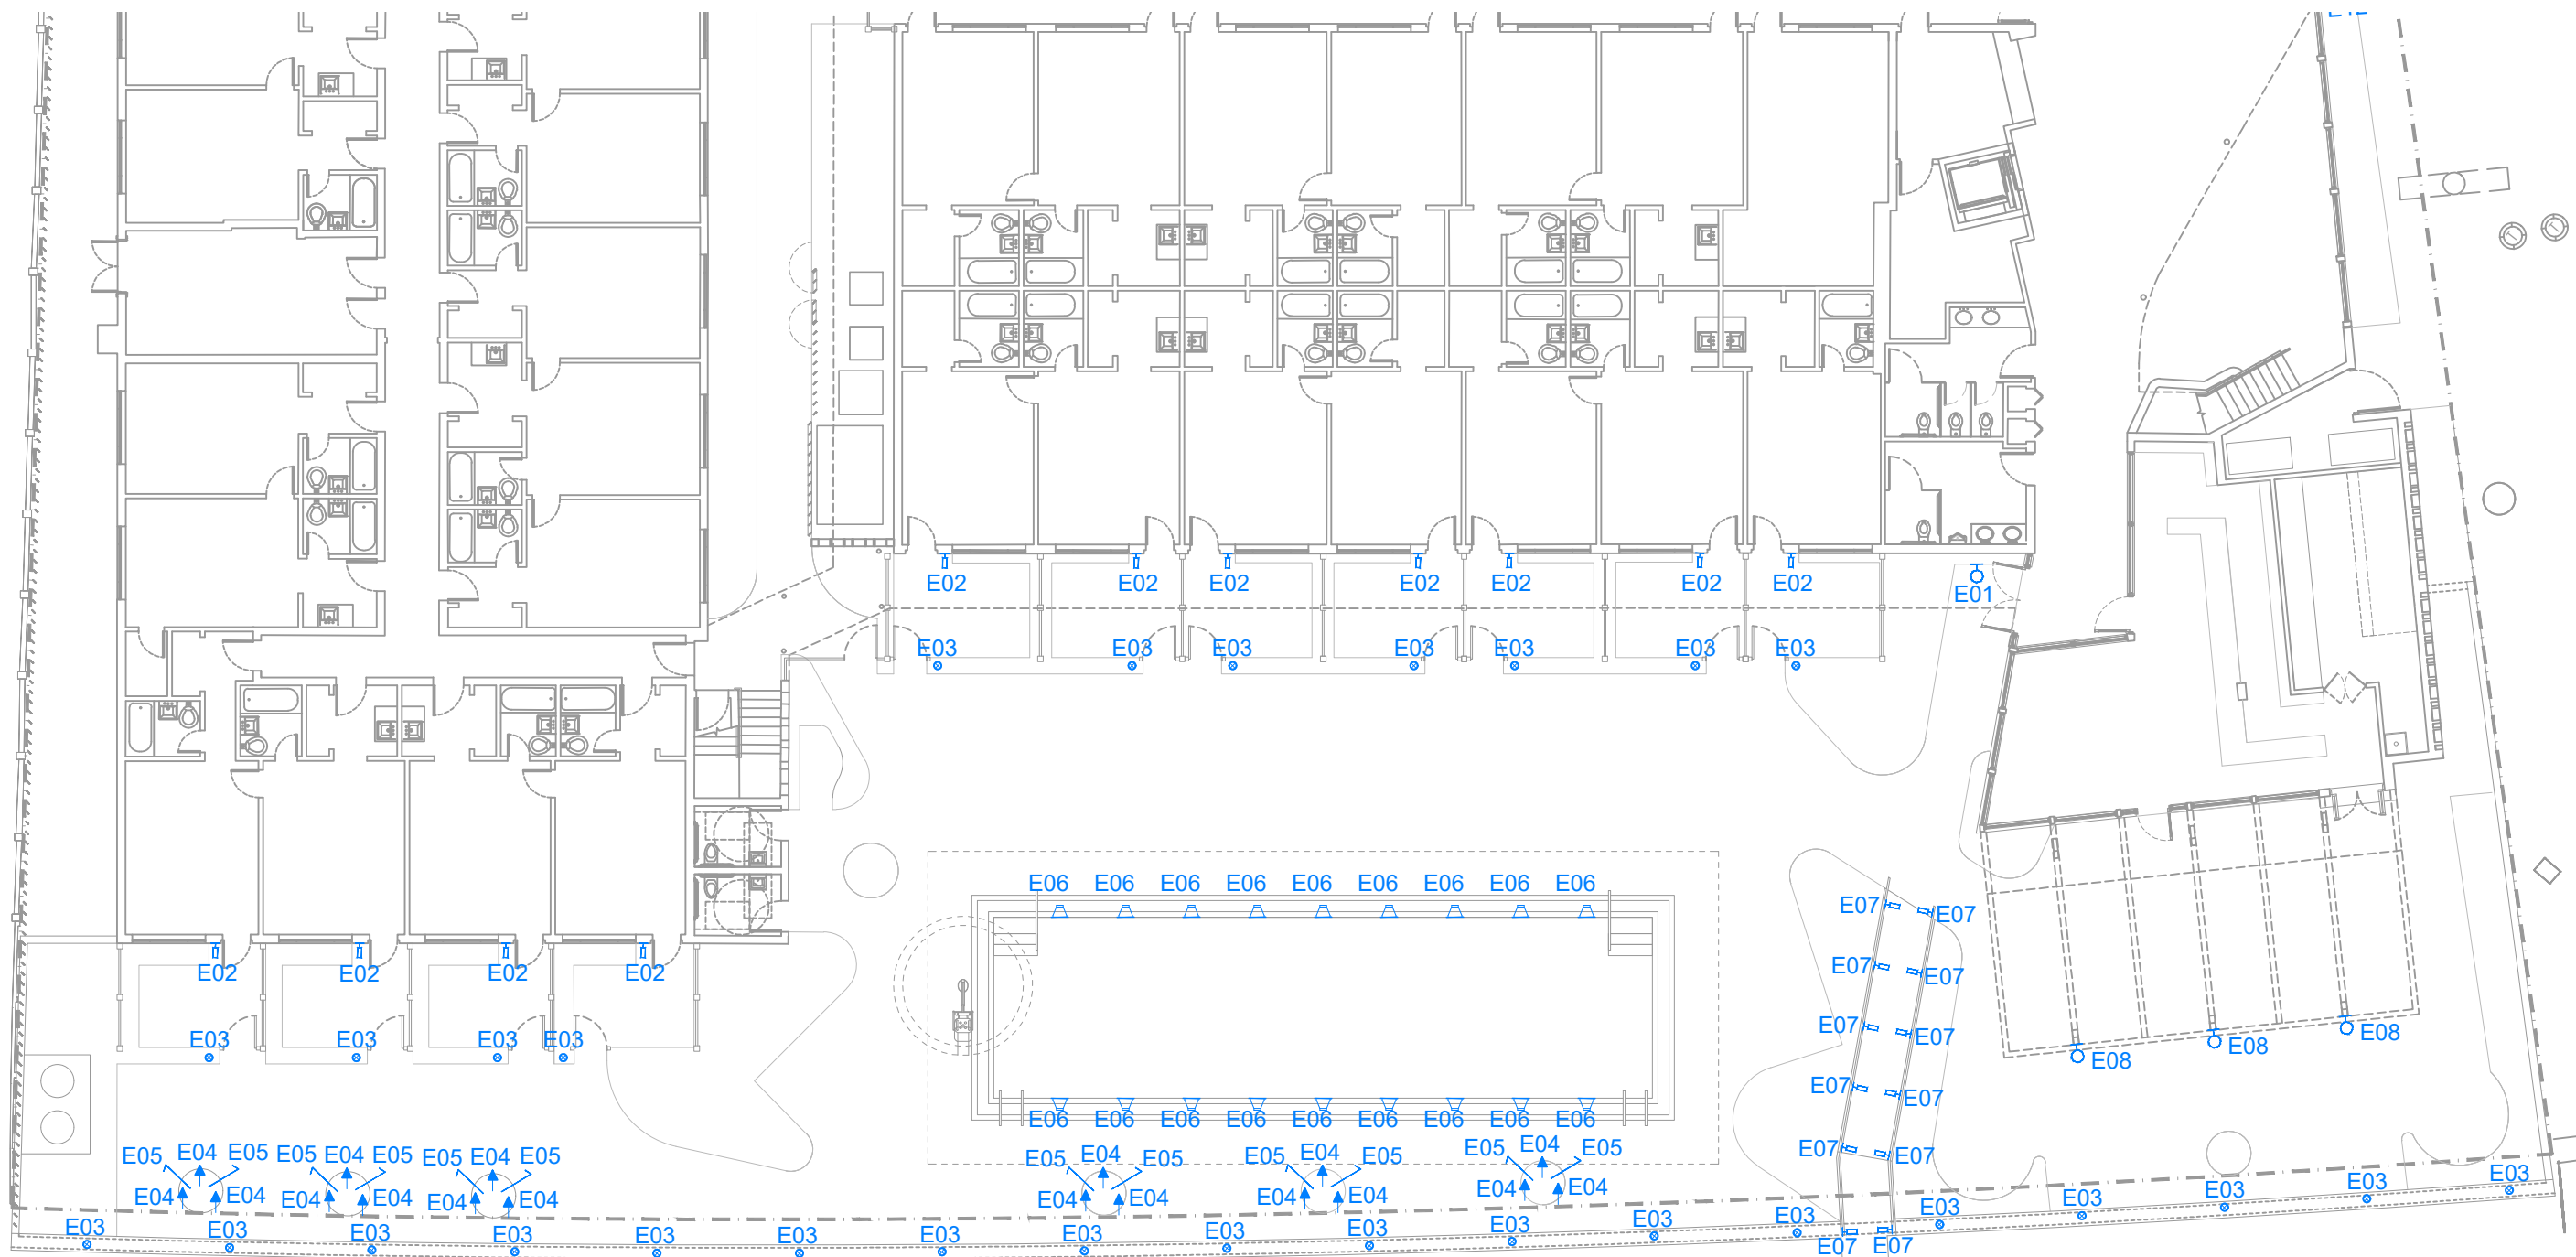


A REFER TO MARRAS LIGHTING DESIGN'S  
FIXTURE SCHEDULE AND CUT-SHEETS  
FOR FIXTURE INFORMATION

**KEYNOTES**

 **REVISIONS**

NO. DATE



LIGHTING KEY	
	RECESSED LUMINAIRE
	WALLWASHER LUMINAIRE
	TREE MOUNTED UPLIGHT
	TREE MOUNTED DOWNLIGHT
	DECORATIVE CEILING LUMINAIRE
	LINEAR LED HORIZONTAL
	WALL SCONCE
	WALL MOUNTED LUMINAIRE
	POOL LIGHT
	OUTDOOR STANDING LAMP

**INTERNATIONAL  
INN**

**EXTERIOR LIGHTING  
CONCEPT PLAN**

Title: EXTERIOR GROUND FLOOR CONCEPT PLAN

Design: JCM, RC

Drafted: ST

Submission Date: 05/08/23

Submitted To: Historic Preservation Board

Sheet: 1

EL.01











**GENERAL LIGHTING NOTES**

A REFER TO MARRAS LIGHTING DESIGN'S  
FIXTURE SCHEDULE AND CUT-SHEETS  
FOR FIXTURE INFORMATION

**KEYNOTES**

**REVISIONS**

NO. DATE

LIGHTING KEY	
	RECESSED LUMINAIRE
	WALLWASHER LUMINAIRE
	TREE MOUNTED UPLIGHT
	TREE MOUNTED DOWNLIGHT
	DECORATIVE CEILING LUMINAIRE
	LINEAR LED HORIZONTAL
	WALL SCONCE
	WALL MOUNTED LUMINAIRE
	POOL LIGHT
	OUTDOOR STANDING LAMP

**INTERNATIONAL  
INN**

**EXTERIOR LIGHTING  
CONCEPT PLAN**

Title: EXTERIOR AWNING GROUND FLOOR CONCEPT PLAN

Design: JCM, RC


Drafted: ST

Submission Date: 05/08/23

Submitted To: Historic Preservation Board

Sheet: 2

EL.03

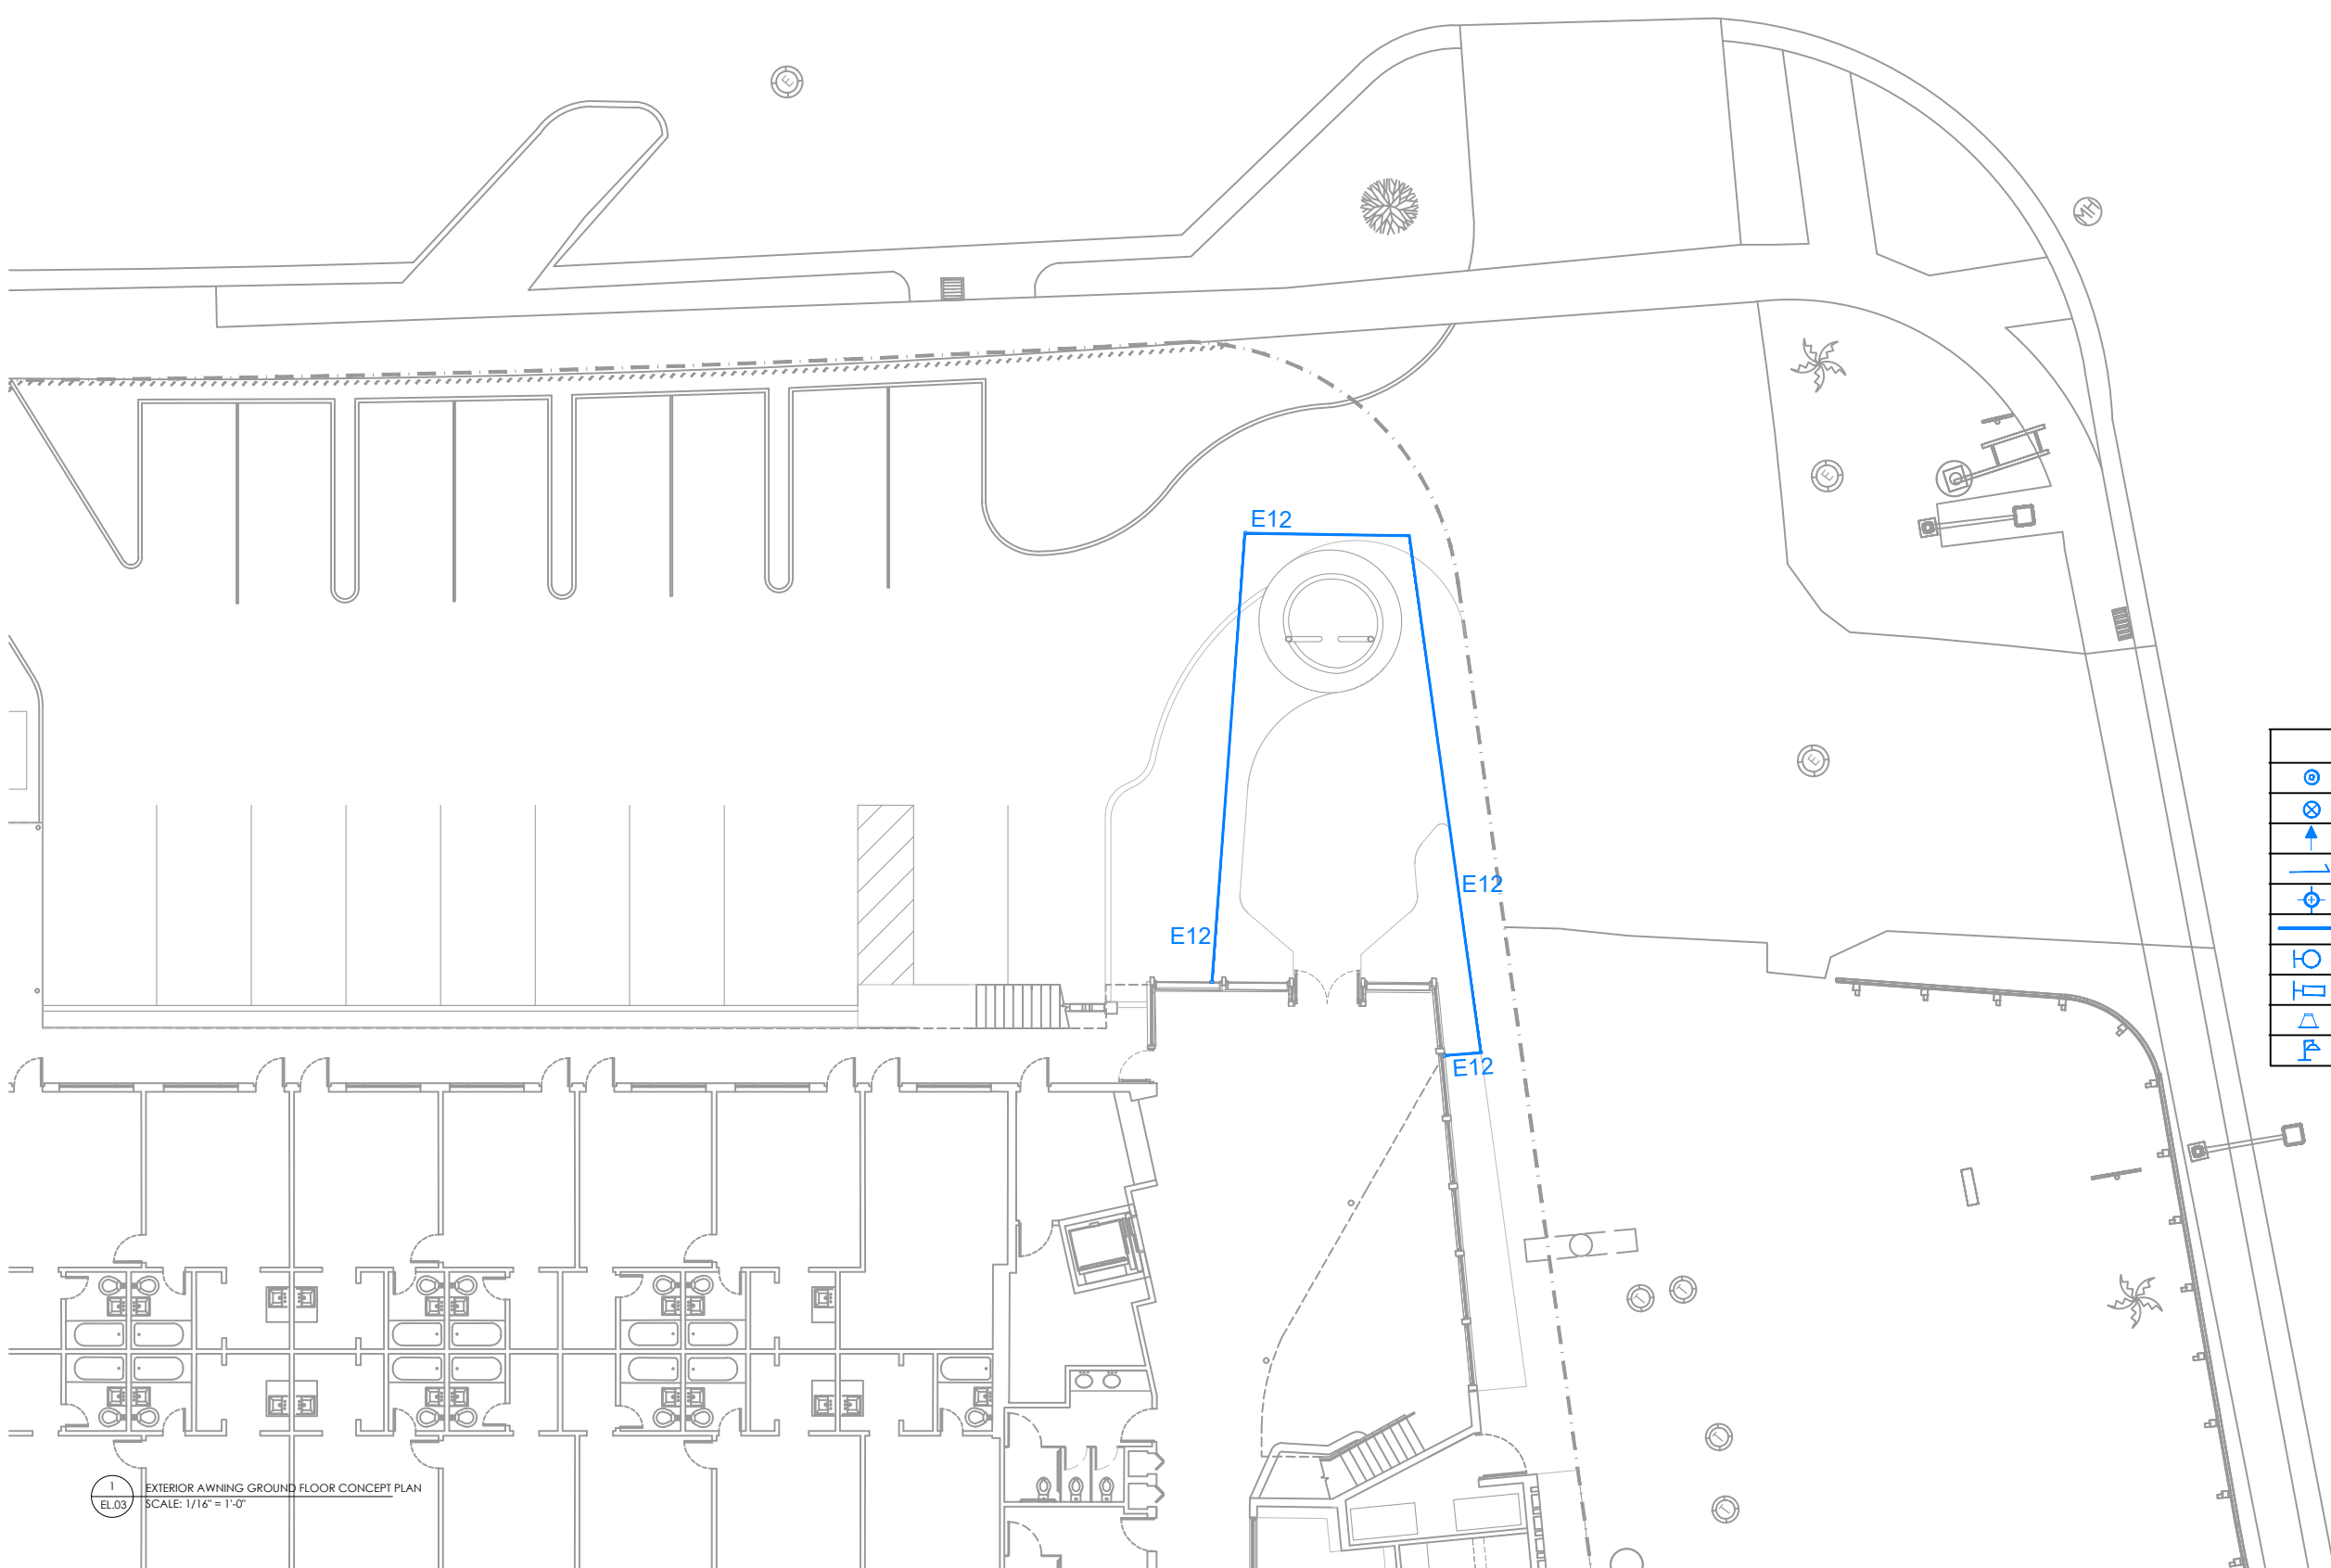

1 EXTERIOR AWNING GROUND FLOOR CONCEPT PLAN  
SCALE: 1/16" = 1'-0"

**GENERAL LIGHTING NOTES**











A REFER TO MARRAS LIGHTING DESIGN'S  
FIXTURE SCHEDULE AND CUT-SHEETS  
FOR FIXTURE INFORMATION

**KEYNOTES**

**REVISIONS**

NO. DATE



LIGHTING KEY	
	RECESSED LUMINAIRE
	WALLWASHER LUMINAIRE
	TREE MOUNTED UPLIGHT
	TREE MOUNTED DOWNLIGHT
	DECORATIVE CEILING LUMINAIRE
	LINEAR LED HORIZONTAL
	WALL SCONCE
	WALL MOUNTED LUMINAIRE
	POOL LIGHT
	OUTDOOR STANDING LAMP

**INTERNATIONAL  
INN**

**EXTERIOR LIGHTING  
CONCEPT PLAN**

Title: EXTERIOR SECOND FLOOR CONCEPT PLAN

Design: JCM, RC

Drafted: ST

Submission Date: 05/08/23

Submitted To: Historic Preservation Board

Sheet: 3

EL.03


**GENERAL LIGHTING NOTES**









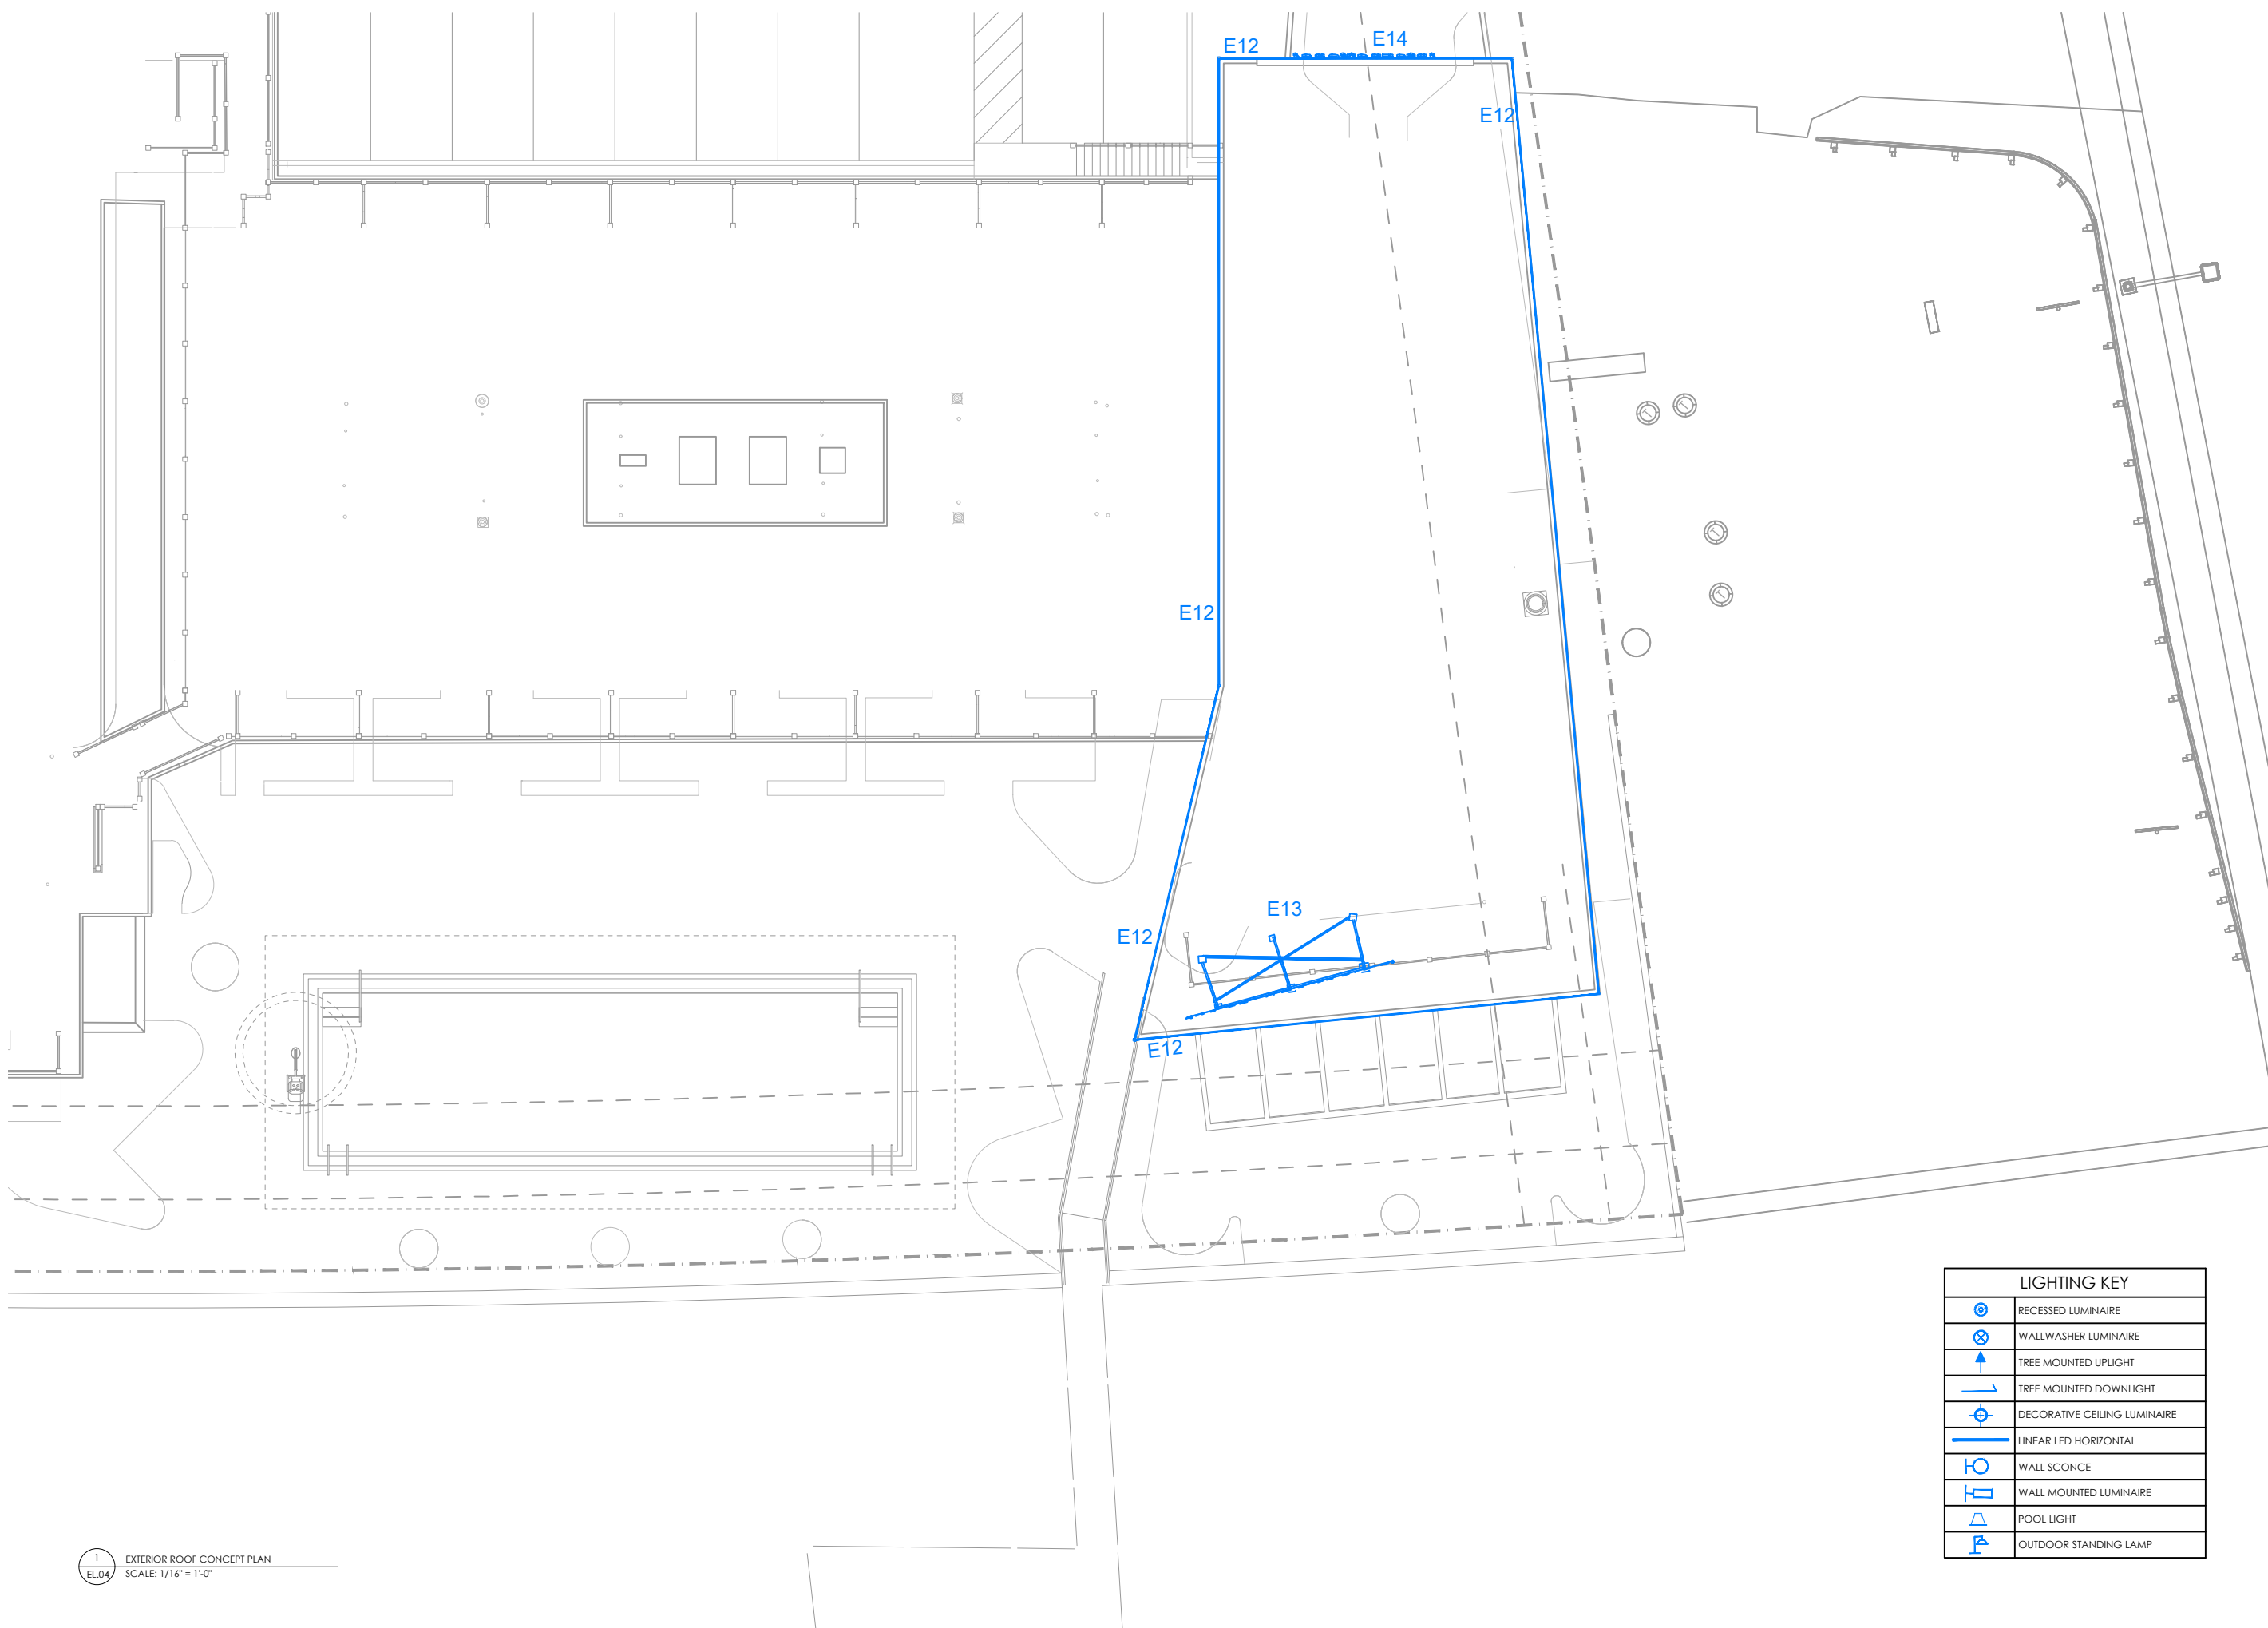

A REFER TO MARRAS LIGHTING DESIGN'S  
FIXTURE SCHEDULE AND CUT-SHEETS  
FOR FIXTURE INFORMATION

**KEYNOTES**

**REVISIONS**

NO. DATE



LIGHTING KEY	
	RECESSED LUMINAIRE
	WALLWASHER LUMINAIRE
	TREE MOUNTED UPLIGHT
	TREE MOUNTED DOWNLIGHT
	DECORATIVE CEILING LUMINAIRE
	LINEAR LED HORIZONTAL
	WALL SCONCE
	WALL MOUNTED LUMINAIRE
	POOL LIGHT
	OUTDOOR STANDING LAMP

**INTERNATIONAL  
INN**

**EXTERIOR LIGHTING  
CONCEPT PLAN**

Title: EXTERIOR ROOF CONCEPT PLAN  
 Design: JCM, RC  
 Drafted: ST  
 Submission Date: 05/08/23  
 Submitted To: Historic Preservation Board  
 Sheet: 4  
 EL.04

**GENERAL LIGHTING NOTES**

REFER TO MARRAS LIGHTING DESIGN'S  
A FIXTURE SCHEDULE AND CUT-SHEETS  
FOR FIXTURE INFORMATION

**KEYNOTES**

**REVISIONS**

NO. DATE

**INTERNATIONAL  
INN**

**EXTERIOR LIGHTING**

**CONCEPT PLAN**

Title: ROOF SIGN LIGHTING

Design: JCM, RC





Drafted: ST

Submission Date: 05/08/23

Submitted To: Design & Build Teams

Sheet: 5

EL.05

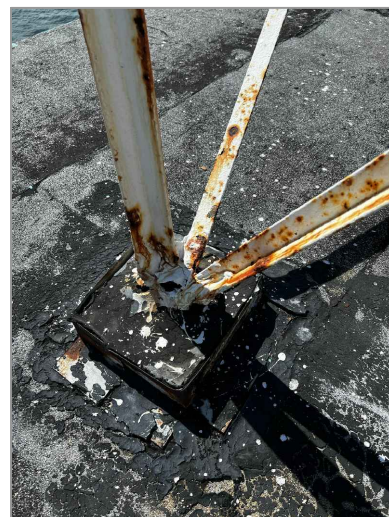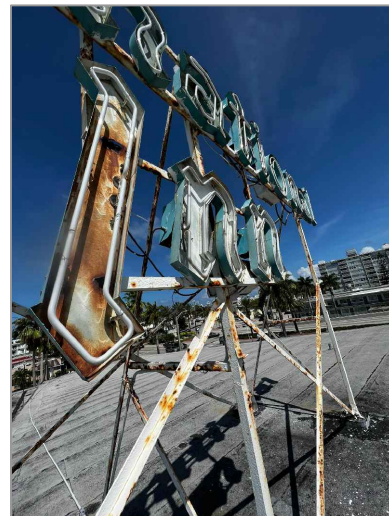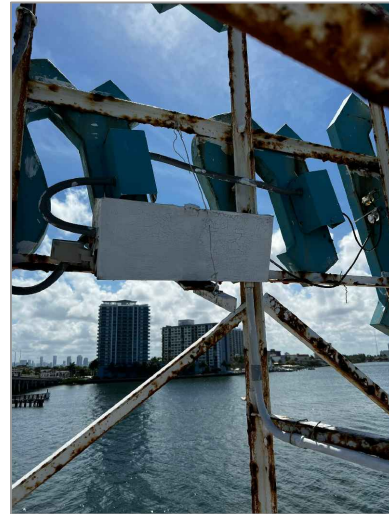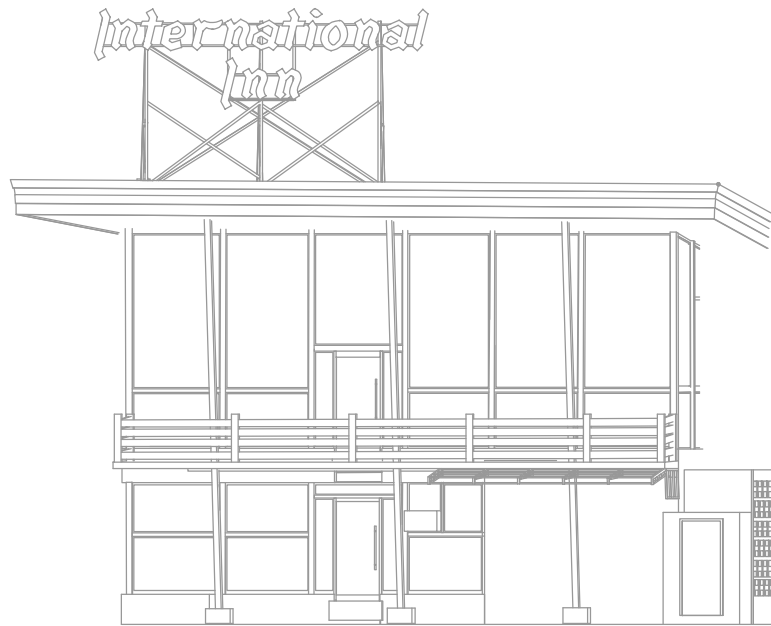

**HanleyLED**

KESTREL SERIES: KS-2100 & KS2100W24V SPEC SHEET

 
**Our Most Affordable Solution**

**Kestrel Series  
KS-2100 & KS-2100W24V**



**Specifications**

Viewing Angle	180° Kestrel Optics
Input Voltage	12vDC (KS-2100) 24vDC (KS-2100W24V)
Watts	1w/mod (1.5w/ft)
Luminous Efficacy	165 (lm/W)
Modules/Foot	1.5/ft (fully stretched)
Protection Grade	IP65 waterproof
Packaging KS-2100 (12V)	Anti-static bag, 80 modules (53ft)/bag, 7 bags/inner carton, 14 bags/outer carton
Packaging KS-2100W24V	Anti-static bag, 60 modules (40ft)/bag, 7 bags/inner carton, 14 bags/outer carton
Warranty	10 Year (Product) / 5 Year (Labor)
Operating Temp.	-40° ~ +60°C   -40° ~ +140°F
Storage Temp.	-40° ~ -70°C   -40° ~ +158°F
KS-2100 Cascade	20 mods single-ended power feed 40 mods double-ended power feed
KS-2100W24V Cascade	30 mods single-ended power feed 60 mods double-ended power feed




MAX Power Supply Load							
Model	35W	60W	100W	120W	150W	180W	240W
KS-2100 (12V)	35 mods	60 mods	100 mods	120 mods	240 mods	180 mods	240 mods

MAX Power Supply Load							
Model	35W	60W	96W	100W	150W	240W	288W
KS-2100W24V	35 mods	60 mods	96 mods	100 mods	150 mods	240 mods	288 mods

Color	Part #	Color Temp	Lumens
Pure White	HLED-KS2100W	7500K	165 lm/mod (247 lm/ft)
Pure White	HLED-KS2100W24V	7500K	165 lm/mod (247 lm/ft)
Cool White	HLED-KS2100W10K	10000K	165 lm/mod (247 lm/ft)

**Profile Drawings**

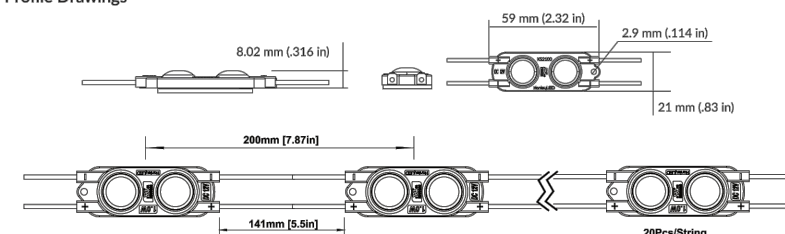

hanleyledsolutions.com | US 800.542.9941 | CA 800.263.1421 | International 305.885.0088

King Signs and Neons Inc.  
12584 SW 128 Street Miami FL 33186  
305-298-2072  
Sales@kingsignsmiami.com  
www.kingsignsmiami.com

To: Marras Lighting Design,  
149 West 27th Street 4th Floor New York New York 10001

Dear Jon Carlo,

This letter serves to inform you and International Inn on the Bay at 2301 Normandy Dr Miami Beach FL 33141 that the sign facing the west elevation, was inspected for damage to the structural metal and overall quality of the sign, and it was deemed not to be reusable. The Metal is more than 50% deteriorated with high likeliness that fasteners are also more than 50% deteriorated. Photos are being attached as proof of said damage. If any questions arise, please contact us directly at our phone number listed above.

Warm regards,

**Manuel Sagot**  
VP KING SIGNS AND NEONS