




RITZ-SAGAMORE

HPB23-0574

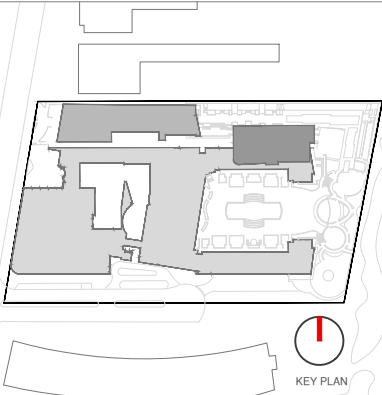

Rev.	Date	Rev.	Date

ALL DRAWINGS AND WRITTEN MATERIAL APPEARING HEREIN CONSTITUTE THE ORIGINAL AND UNPUBLISHED WORK OF KOB KARP AIA, AND MAY NOT BE DUPLICATED, USED, OR DISCLOSED WITHOUT THE EXPRESS WRITTEN CONSENT OF KOB KARP ARCHITECTURE & INTERIOR DESIGN, INC. AIA (c) 2020.

HPB

FINAL SUBMITTAL

Ritz-Sagamore
1 Lincoln Road
Miami Beach, FL 33139

Owner:
Name: Di Lido Beach Resort LLC.
Address: EBJ Sagamore LLC.
Address: Sobe Sky Development LLC.
Tel: Di Lido Beach Resort Hotel Corporation
Email:

Consultant:
Name: STUDIO MUNGE.
Address: 25 Wingold Avenue.
Address: Toronto, ON Canada M6B 1P8
Tel: 416.588.1668
Email:

Consultant: LANDSCAPE ARCHITECT
Name: Naturalifical.
Address: 6915 Red Road, Suite 224
Address: Coral Gables, FL 33143
Tel: 786.717.6564
Email:

Consultant: MEP
Name: MG Engineering.
Address: 6915 Red Road, Suite 224
Address: 2800 Biscayne Blvd
Tel: Miami, FL, 33137
Email: 305.755.3833

Consultant:
Name: Desimore Consulting Engineering
Address: 800 Brickell Avenue, 6th Floor
Address: Miami, FL 33131
Tel: 305.441.0755
Email:

Architect:
Kobi Karp Architecture and Interior Design, Inc.
571 NW 28TH ST
Miami, Florida 33137 USA
Tel: +1(305) 573 1818
Fax: +1(305) 573 3766

K O B I
K A R P

K O B I K A R P
Lic. # AR0012578

COVER

RITZ-SAGAMORE


Date	05-08-2023	Sheet No.
Scale	-	A0.00
Project	2018	

ARCHITECTURE PLANS	
SHEET	TITLE
A0.00	COVER
A0.01	INDEX
A0.02	SURVEY
A0.03	PROJECT DATA
A0.04	LOCATION PLAN
A0.05	AERIAL VIEW
A0.06	CONTEXT AERIAL VIEW
A0.07	CONTEXT SURROUNDING BUILDINGS
A0.30	EXISTING IMAGES
A0.31	EXISTING IMAGES
A0.32	EXISTING IMAGES
A0.33	EXISTING IMAGES
A0.50	SCOPE OF WORK
A0.51	SCOPE OF WORK
A0.52	SCOPE OF WORK
A0.53	SCOPE OF WORK
A0.54	SCOPE OF WORK
A0.54.1	SCOPE OF WORK
A0.55	CANTILEVER EXHIBIT
A0.56	CANTILEVER EXHIBIT
A0.57	HISTORIC OVERVIEW
A0.58	HISTORIC ADDITION EXHIBIT
A0.59	HISTORIC ADDITION EXHIBIT
A0.60	EXTERIOR BLDG. RENDERING
A0.61	EXTERIOR BLDG. RENDERING
A0.62	EXTERIOR BLDG. RENDERING
A0.63	EXTERIOR BLDG. RENDERING
A0.64	EXTERIOR BLDG. RENDERING
A0.65	EXTERIOR BLDG. RENDERING
A0.66	EXTERIOR BLDG. RENDERING
A0.67	EXTERIOR BLDG. RENDERING
A0.68	EXTERIOR BLDG. RENDERING
A0.69	EXTERIOR BLDG. RENDERING
A0.70	EXTERIOR BLDG. RENDERING
A0.71	EXTERIOR BLDG. RENDERING
A0.72	EXTERIOR BLDG. RENDERING
A0.73	EXTERIOR BLDG. RENDERING
A0.74	EXTERIOR BLDG. RENDERING
A0.75	EXTERIOR BLDG. RENDERING
A0.76	EXTERIOR BLDG. RENDERING
A0.80	INTERIOR RENDERING
A0.81	INTERIOR RENDERING
A0.82	INTERIOR RENDERING
A0.83	INTERIOR RENDERING
A0.84	INTERIOR RENDERING
A0.85	INTERIOR. RENDERING
A0.86	INTERIOR. RENDERING
A1.00	EXISTING FAR BASEMENT PLAN
A1.01	EXISTING FAR GROUND FLOOR PLAN
A1.02	EXISTING FAR 2ND FLOOR PLAN
A1.03	EXISTING FAR 3RD FLOOR PLAN
A1.04	EXISTING FAR 4TH FLOOR PLAN
A1.05	EXISTING FAR 5TH FLOOR PLAN
A1.06	EXISTING FAR 6TH FLOOR PLAN
A1.07	EXISTING FAR 7TH FLOOR PLAN
A1.08	EXISTING FAR 8TH FLOOR PLAN
A1.09	EXISTING FAR 9TH FLOOR PLAN
A1.10	EXISTING FAR 10TH FLOOR PLAN
A1.11	EXISTING FAR 11TH FLOOR PLAN
A1.20	PROPOSED FAR BASEMENT PLAN

ARCHITECTURE PLANS	
SHEET	TITLE
A1.21	PROPOSED FAR GROUND FLOOR PLAN
A1.22	PROPOSED FAR 2ND FLOOR PLAN
A1.23	PROPOSED FAR 3RD FLOOR PLAN
A1.24	PROPOSED FAR 4TH FLOOR PLAN
A1.25	PROPOSED FAR 5TH FLOOR PLAN
A1.26	PROPOSED FAR 6TH FLOOR PLAN
A1.27	PROPOSED FAR 7TH FLOOR PLAN
A1.28	PROPOSED FAR 8TH FLOOR PLAN
A1.29	PROPOSED FAR 9TH FLOOR PLAN
A1.30	PROPOSED FAR 10TH FLOOR PLAN
A1.31	PROPOSED FAR 11TH FLOOR PLAN
A1.32	PROPOSED FAR 12TH FLOOR PLAN
A1.33	PROPOSED FAR 13TH FLOOR PLAN
A1.34	PROPOSED FAR 14TH FLOOR PLAN
A1.35	PROPOSED FAR 15TH FLOOR PLAN
A1.36	PROPOSED FAR 16TH FLOOR PLAN
A1.50	SITE PLAN
A2.00	OVERALL BASEMENT
A2.01	OVERALL GROUND FLOOR
A2.02	OVERALL 2ND FLOOR
A2.03	OVERALL 3RD FLOOR
A2.04	OVERALL 4TH FLOOR
A2.05	OVERALL 5TH FLOOR
A2.06	OVERALL 6TH FLOOR
A2.07	OVERALL 7TH FLOOR
A2.08	OVERALL 8TH FLOOR
A2.09	OVERALL 9TH FLOOR
A2.10	OVERALL 10TH FLOOR
A2.11	OVERALL 11TH FLOOR
A2.12	OVERALL 12TH FLOOR
A2.13	OVERALL 13TH FLOOR
A2.14	OVERALL 14TH FLOOR
A2.15	OVERALL 15TH FLOOR
A2.16	OVERALL 16TH FLOOR
A2.20	ENLARGED SAGAMORE BASEMENT PLAN
A2.21	ENLARGED SAGAMORE GROUND FLOOR
A2.22	ENLARGED SAGAMORE 2ND FLOOR
A2.23	ENLARGED SAGAMORE 3RD FLOOR
A2.24	ENLARGED SAGAMORE 4TH FLOOR
A2.25	ENLARGED SAGAMORE 5TH FLOOR
A2.26	ENLARGED SAGAMORE 6TH FLOOR
A2.27	ENLARGED SAGAMORE 7TH FLOOR
A2.30	ENLARGED TOWER GROUND FLOOR PLAN
A2.31	ENLARGED TOWER 2ND FLOOR PLAN
A2.32	ENLARGED TOWER 3RD FLOOR PLAN
A2.33	ENLARGED TOWER 4TH FLOOR PLAN
A2.34	ENLARGED TOWER 5TH FLOOR PLAN
A2.35	ENLARGED TOWER 6TH FLOOR PLAN
A2.36	ENLARGED TOWER 7TH FLOOR PLAN
A2.37	ENLARGED TOWER 8TH FLOOR PLAN
A2.38	ENLARGED TOWER 9TH FLOOR PLAN
A2.39	ENLARGED TOWER 10TH FLOOR PLAN
A2.40	ENLARGED TOWER 11TH FLOOR PLAN
A2.41	ENLARGED TOWER 12TH FLOOR PLAN
A2.42	ENLARGED TOWER 13TH FLOOR PLAN
A2.43	ENLARGED TOWER 14TH FLOOR PLAN
A2.44	ENLARGED TOWER 15TH FLOOR PLAN
A2.45	ENLARGED TOWER ROOF
A4.00	EXISTING SAGAMORE ELEVATIONS
A4.01	EXISTING RITZ NORTH & SOUTH ELEVATIONS

ARCHITECTURE PLANS	
SHEET	TITLE
A4.02	EXISTING RITZ EAST & WEST ELEVATIONS
A4.03	OVERALL PROPOSED ELEVATIONS
A4.04	OVERALL PROPOSED ELEVATIONS
A4.05	OVERALL PROPOSED COLOR ELEVATIONS
A4.06	OVERALL PROPOSED COLOR ELEVATIONS
A4.07	OVERALL COMPARATIVE NORTH ELEVATIONS
A4.08	OVERALL COMPARATIVE SOUTH ELEVATIONS
A4.09	OVERALL COMPARATIVE EAST ELEVATIONS
A4.10	OVERALL COMPARATIVE WEST ELEVATIONS
A4.11	ENLARGED COMPARATIVE NORTH SAGAMORE ELEVATIONS
A4.12	ENLARGED COMPARATIVE SOUTH SAGAMORE ELEVATIONS
A4.13	ENLARGED COMPARATIVE EAST & WEST SAGAMORE ELEVATIONS
A4.14	LOBBY COMPARATIVE ELEVATIONS
A4.15	LOBBY COMPARATIVE FLOOR PLANS
A4.20	ENLARGED EAST GROUND ELEVATIONS
A4.20.1	ENLARGED EAST GROUND ELEVATIONS
A4.20.2	ENLARGED EAST GROUND ELEVATIONS
A4.21	ENLARGED WEST GROUND ELEVATIONS
A4.22	ENLARGED NORTH GROUND ELEVATIONS
A4.23	ENLARGED BAR ELEVATIONS
A4.30	ENLARGED NORTH TOWER ELEVATION
A4.31	ENLARGED SOUTH TOWER ELEVATIONS
A4.32	ENLARGED EAST TOWER ELEVATIONS
A4.33	ENLARGED WEST TOWER ELEVATIONS
A5.00	OVERALL SECTION AA
A5.01	OVERALL SECTION BB
A5.02	OVERALL SECTION CC
A6.00	SAGAMORE RAILING DETAILS
A6.01	NEW TOWER RAILING DETAILS
A6.05	TRELLIS DETAILS
A6.06	TRELLIS DETAILS
A6.07	TRELLIS DETAILS
A6.09	SAGAMORE REAR ELEVATION DETAILS
A6.10	MECH SCREENING DETAILS
A6.11	SAGAMORE HISTORIC FRONT ELEVATION
A6.12	SAGAMORE HISTORIC PLAN
A6.13	RITZ VALET DROP OFF EXHIBIT
A6.14	OVERALL HARDSCAPE PLAN
A6.15	REAR YARD AREA DIAGRAMS
D1.00	DEMOLITION BASEMENT FLOOR PLAN
D1.01	DEMOLITION GROUND FLOOR PLAN
D1.02	DEMOLITION 2ND FLOOR PLAN
D1.03	DEMOLITION 3RD FLOOR PLAN
D1.04	DEMOLITION 4TH FLOOR PLAN
D1.05	DEMOLITION 5TH FLOOR PLAN
D1.06	DEMOLITION 6TH FLOOR PLAN
D1.07	DEMOLITION 7TH FLOOR PLAN
D1.08	DEMOLITION 8TH FLOOR PLAN
D1.09	DEMOLITION 9TH FLOOR PLAN
D1.10	DEMOLITION 10TH FLOOR PLAN
D1.11	DEMOLITION 11TH FLOOR PLAN
D4.00	DEMOLITION SAGAMORE ELEVATIONS
D4.01	DEMOLITION RITZ ELEVATION

LANDSCAPE PLANS	
L0.00	COVER SHEET
L0.00A	SITE TABULATIONS
L0.00B	ILUSTRATIVE SITE PLAN
L0.01	SITE SURVEY
L0.02	SITE SURVEY TREE LIST
L1.10	OVERALL HARDSCAPE PLAN
L1.11	REAR PERVIOUS AREA DIAGRAM
L3.00	OVERALL TREE DISPOSITION PLAN
L3.00A	EXISTING PLANTING AREAS DIAGRAM
L3.01	TREE DISPOSITION LIST
L3.02	TREE DISPOSITION LIST
L3.03	TREE DISPOSITION LIST
L3.04	TREE DISPOSITION LIST
L3.10	OVERALL LANDSCAPE PLANS
L3.11	ENLARGED LANDSCAPE PLANS 'A'
L3.12	ENLARGED LANDSCAPE PLANS 'B'
L3.13	ENLARGED LANDSCAPE PLANS 'C'
L3.14	ENLARGED LANDSCAPE PLANS 'D'
L3.15	LANDSCAPE PLANT LIST
L3.16	PLANTING REFERENCE IMAGES
L3.17	PLANTING REFERENCE IMAGES
L3.30	GENERAL PLANTING DETAILS
L4.10	OVERALL LIGHTING PLAN
L5.10	OVERALL IRRIGATION PLAN

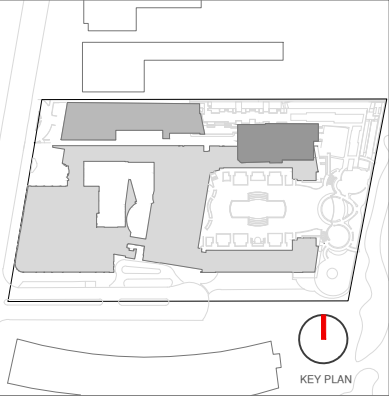

Rev.	Date	Rev.	Date

ALL DRAWINGS AND WRITTEN MATERIAL APPEARING HEREIN CONSTITUTE THE ORIGINAL AND UNPUBLISHED WORK OF Kobi Karp AIA, AND MAY NOT BE DUPLICATED, USED, OR DISCLOSED WITHOUT THE EXPRESS WRITTEN CONSENT OF Kobi Karp Architecture & Interior Design, INC. AIA (U.S.A.)

HPB

FINAL SUBMITTAL

Ritz-Sagamore
1 Lincoln Road
Miami Beach, FL 33139

Owner: Di Lido Beach Resort LLC.
Name EBJ Sagamore LLC.
Address Sobe Sky Development LLC.
Address Di Lido Beach Resort Hotel Corporation
Tel:
Email


Consultant: STUDIO MUNGE.
Name 25 Wingold Avenue,
Address Toronto, ON Canada M6B 1P8
Address 416.588.1668
Tel:
Email

Consultant: LANDSCAPE ARCHITECT
Name Naturalifical.
Address 6915 Red Road, Suite 224
Address Coral Gables, FL 33143
Tel: 786.717.6564
Email

Consultant: MEP
Name MG Engineering.
Address 6915 Red Road, Suite 224
Address 2800 Biscayne Blvd
Tel: Miami, FL, 33137
Email 305.755.3833

Consultant: Desimore Consulting Engineering
Name 800 Brickell Avenue, 6th Floor
Address Miami, FL 33131
Address 305.441.0755
Tel:
Email

Architect: Kobi Karp Architecture and Interior Design, Inc.
Name 571 NW 28TH ST
Address Miami, Florida 33137 USA
Address Tel: +1(305) 573 1818
Tel: Fax: +1(305) 573 3766
Email

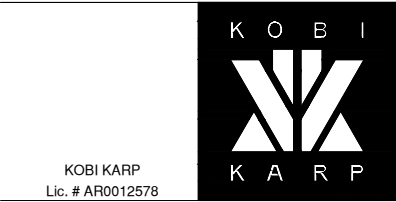


DRAWING INDEX

RITZ-SAGAMORE

Date	05-08-2023	Sheet No.
Scale	-	A0.01
Project	2018	


** 1/2 of the basement included in the calculation

Seating / O.C.C Chart / Parking					
RITZ					
Floor Level	Room Name	Area	Existing Seats/Occupants	Proposed Seats/Occupants	Parking Required
Ground	New Retail from 1999 Permit	2,819 SF			8
	Lobby Bar	In Historic Ritz	51 Occupants	52 Occupants	N/A
	New Beach Side Restaurant	In Historic Ritz	60 Seats	180 Seats	45
	Restaurant	In Historic Ritz	564 Occupants	565 Occupants	N/A
Level 2	All Day Restaurant/Pool Deck	In Historic Ritz	203 Seats	204 Seats	N/A
Totals					
SAGAMORE					
Floor Level	Room Name	Area	Existing Seats/Occupants	Proposed Seats/Occupants	Parking Required
Ground	Book Store/Coffee Shop	In Historic Sagamore	N/a	10 Seats	N/A
	Cigar Lounge	In Historic Sagamore	N/A	20 Seats	N/A
	Pool Restaurant	In Historic Sagamore	N/A		
	Restaurant	In Historic Sagamore	142 Seats	60 Seats	N/A
Totals					
UNIT PARKING REQUIREMENTS					
Unit Type	Proposed Density	Area	Existing Seats/Occupants		Parking Required
Hotel (Ritz)	374 Existing	New rooms from 1999 Permit	N/A	.5/unit x 173	87
Hotel (Sagamore)	60	In Historic Sagamore	N/A	N/A	N/A
550-999 SF	0	New Tower	N/A	1	0
1000-1200 SF	12	New Tower	N/A	1.5	18
+ 1200 SF	38	New Tower	N/A	2	76
Total					234
Grand Total 234 Spaces					

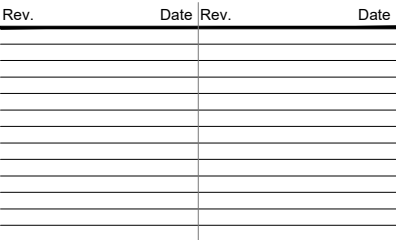



FINAL SUBMITTAL

 Architect:
Kobi Karp Architecture and Interior Design, Inc.
571 NW 28TH ST
Miami, Florida 33137 USA
Tel: +1(305) 573 1818
Fax: +1(305) 573 3766



RITZ-SAGAMORE

Date	05-08-2023	Sheet No. A0.03
Scale	-	
Project	2018	

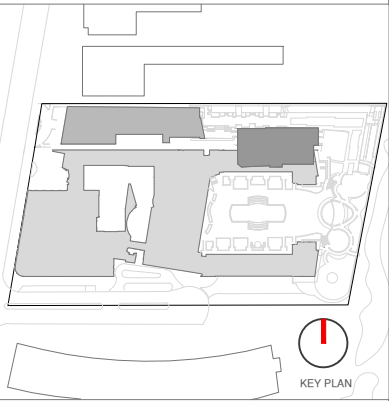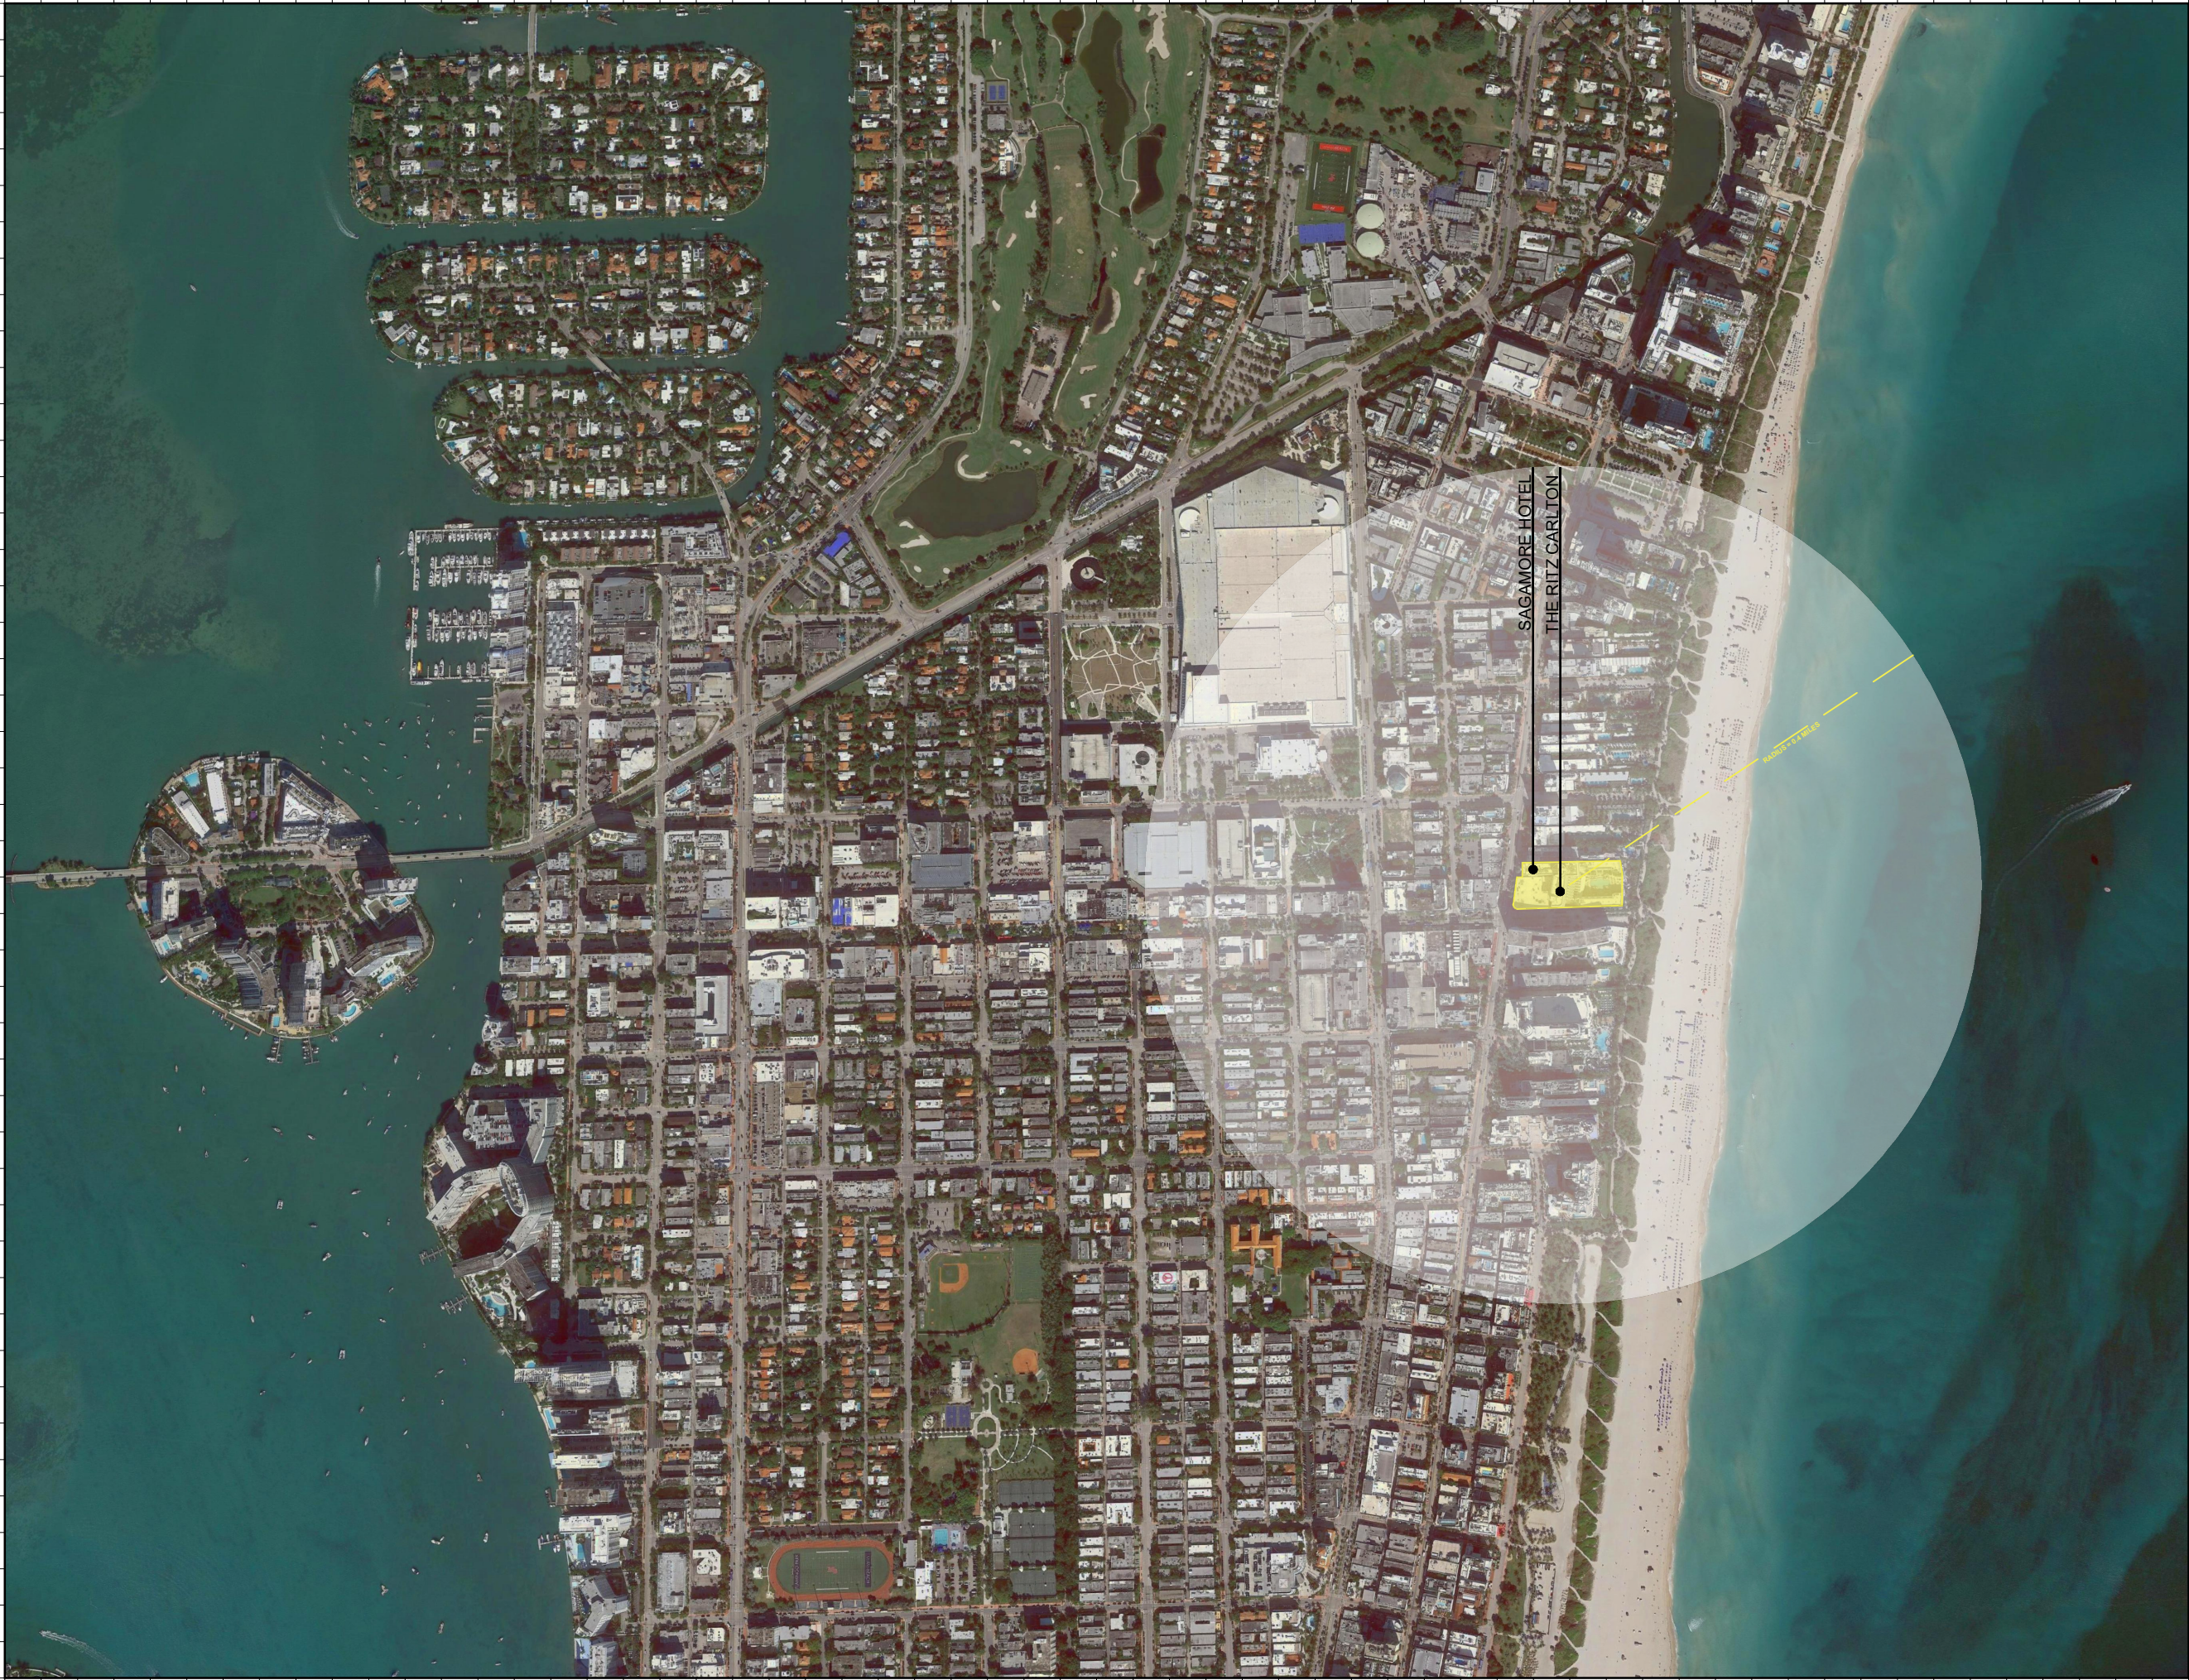

Rev.	Date	Rev.	Date

ALL DRAWINGS AND WRITTEN MATERIAL APPEARING HEREIN CONSTITUTE THE ORIGINAL AND UNPUBLISHED WORK OF KOB KARP AIA, AND MAY NOT BE DUPLICATED, USED OR DISCLOSED WITHOUT THE EXPRESS WRITTEN CONSENT OF KOB KARP ARCHITECTURE & INTERIOR DESIGN, INC. AIA (© 2020)

HPB

FINAL SUBMITTAL

Ritz-Sagamore
1 Lincoln Road
Miami Beach, FL 33139

Owner: Di Lido Beach Resort LLC.
Name: EBJ Sagamore LLC.
Address: Sobe Sky Development LLC.
Tel: Di Lido Beach Resort Hotel Corporation
Email:


Consultant: STUDIO MUNGE.
Name: 25 Wingold Avenue.
Address: Toronto, ON Canada M6B 1P8
Tel: 416.588.1668
Email:

Consultant: LANDSCAPE ARCHITECT
Name: Naturalifical.
Address: 6915 Red Road, Suite 224
Tel: Coral Gables, FL 33143
Email: 786.717.6564

Consultant: MEP
Name: MG Engineering.
Address: 6915 Red Road, Suite 224
Tel: 2800 Biscayne Blvd
Email: Miami, FL, 33137
305.755.3833

Consultant: Desimore Consulting Engineering
Name: 800 Brickell Avenue, 6th Floor
Address: Miami, FL 33131
Tel: 305.441.0755
Email:

Architect: Kobi Karp Architecture and Interior Design, Inc.
571 NW 26TH ST
Miami, Florida 33137 USA
Tel: +1(305) 573 1818
Fax: +1(305) 573 3766

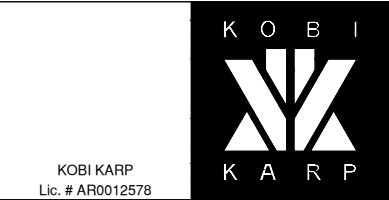

LOCATION PLAN/ AERIAL VIEW

RITZ-SAGAMORE

Date	05-08-2023	Sheet No.
Scale	NTS	A0.04
Project	2018	

EXISTING
SAGAMORE HOTEL

EXISTING RITZ
CARLTON HOTEL

EXISTING SAGAMORE
CABANAS TO BE REMOVED

EXISTING OUTDOOR
RESTAURANT AND EVENT SPACE

1 EXISTING

RESTORED
SAGAMORE HOTEL

EXISTING RITZ
CARLTON HOTEL

NEW RESIDENTIAL TOWER AND
ASOCIATED EXTERIOR SPACES


RENOVATED OUTDOOR
RESTAURANT AND EVENT SPACE

NEW RITZ CARLTON ENTRY
CANOPY

REDEVELOPED 100 BLOCK
ROADWAY AND BEACH ACCESS

FOR REDEVELOPED 100 BLOCK
ROADWAY AND BEACH ACCESS
SEE HPB APPLICATION #(PENDING)

2 PROPOSED

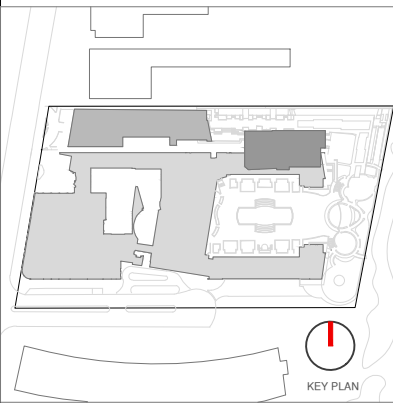

Rev.	Date	Rev.	Date

ALL DRAWINGS AND WRITTEN MATERIAL APPEARING HEREIN CONSTITUTE THE ORIGINAL AND UNPUBLISHED WORK OF KOB KARP AIA, AND MAY NOT BE DUPLICATED, USED, OR DISCLOSED WITHOUT THE EXPRESS WRITTEN CONSENT OF KOB KARP ARCHITECTURE & INTERIOR DESIGN, INC. AIA (U.S.A.)

HPB

FINAL SUBMITTAL

Ritz-Sagamore
1 Lincoln Road
Miami Beach, FL 33139

Owner: Di Lido Beach Resort LLC.
Name: EBJ Sagamore LLC.
Address: Sobe Sky Development LLC.
Tel: Di Lido Beach Resort Hotel Corporation
Email:


Consultant: STUDIO MUNGE.
Name: 25 Wingold Avenue,
Address: Toronto, ON Canada M6B 1P8
Tel: 416.588.1668
Email:

Consultant: LANDSCAPE ARCHITECT
Name: Naturalifical.
Address: 6915 Red Road, Suite 224
Tel: Coral Gables, FL 33143
Email: 786.717.6564

Consultant: MEP
Name: MG Engineering.
Address: 6915 Red Road, Suite 224
Tel: 2800 Biscayne Blvd
Email: Miami, FL, 33137
305.755.3833

Consultant: Desimore Consulting Engineering
Name: 800 Brickell Avenue, 6th Floor
Address: Miami, FL 33131
Tel: 305.441.0755
Email:

Architect: Kobi Karp Architecture and Interior Design, Inc.
Address: 571 NW 28TH ST
Tel: Miami, Florida 33137 USA
Fax: +1(305) 573 1818
+1(305) 573 3766

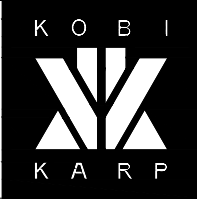


KOBI KARP
Lic. # AR0012578

PROPOSED VS EXISTING

RITZ-SAGAMORE

Date	05-08-2023	Sheet No.
Scale	NTS	A0.05
Project	2018	

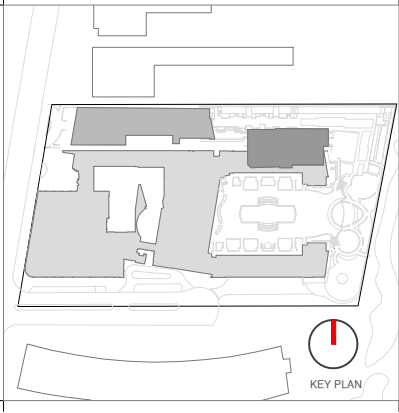

Rev.	Date	Rev.	Date


ALL DRAWINGS AND WRITTEN MATERIAL APPEARING HEREIN CONSTITUTE THE ORIGINAL AND UNPUBLISHED WORK OF KOBİ KARP AIA, AND MAY NOT BE DUPLICATED, USED, OR DISCLOSED WITHOUT THE EXPRESS WRITTEN CONSENT OF KOBİ KARP ARCHITECTURE & INTERIOR DESIGN, INC. AIA (U.S.A.)

HPB
FINAL SUBMITTAL

Ritz-Sagamore
1 Lincoln Road
Miami Beach, FL 33139

Owner:	Di Lido Beach Resort LLC.
Name:	EBJ Sagamore LLC.
Address:	Sobe Sky Development LLC.
Tel:	Di Lido Beach Resort Hotel Corporation
Email:	
Consultant:	STUDIO MUNGE.
Name:	25 Wingold Avenue.
Address:	Toronto, ON Canada M6B 1P8
Tel:	416.588.1668
Email:	
Consultant:	LANDSCAPE ARCHITECT
Name:	Naturalifical.
Address:	6915 Red Road, Suite 224
Tel:	Coral Gables, FL 33143
Email:	786.717.8564
Consultant:	MEP
Name:	MG Engineering.
Address:	6915 Red Road, Suite 224
Tel:	2800 Biscayne Blvd
Email:	Miami, FL, 33137
	305.755.3833
Consultant:	Desimore Consulting Engineering
Name:	800 Brickell Avenue, 6th Floor
Address:	Miami, FL 33131
Tel:	305.441.0755
Email:	

Architect:
Kobi Karp Architecture and Interior Design, Inc.
571 NW 28TH ST
Miami, Florida 33137 USA
Tel: +1(305) 573 1818
Fax: +1(305) 573 3766

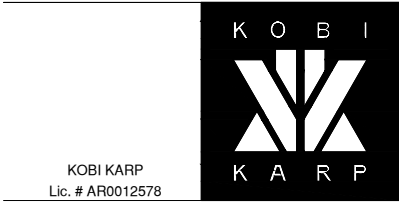

CONTEXT
SURROUNDING BUILDINGS

Date	05-08-2023	Sheet No.
Scale	NTS	A0.06
Project	2018	






THE DECOPLAGE - COLISH & GROSSMAN, 1965



THE DELANO HOTEL - ROBERT SWARTBURG, 1947



NATIONAL HOTEL - ROY FRANCE, 1940

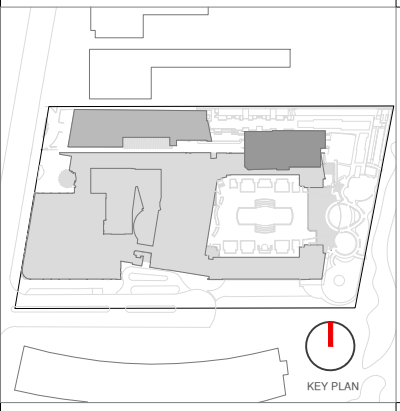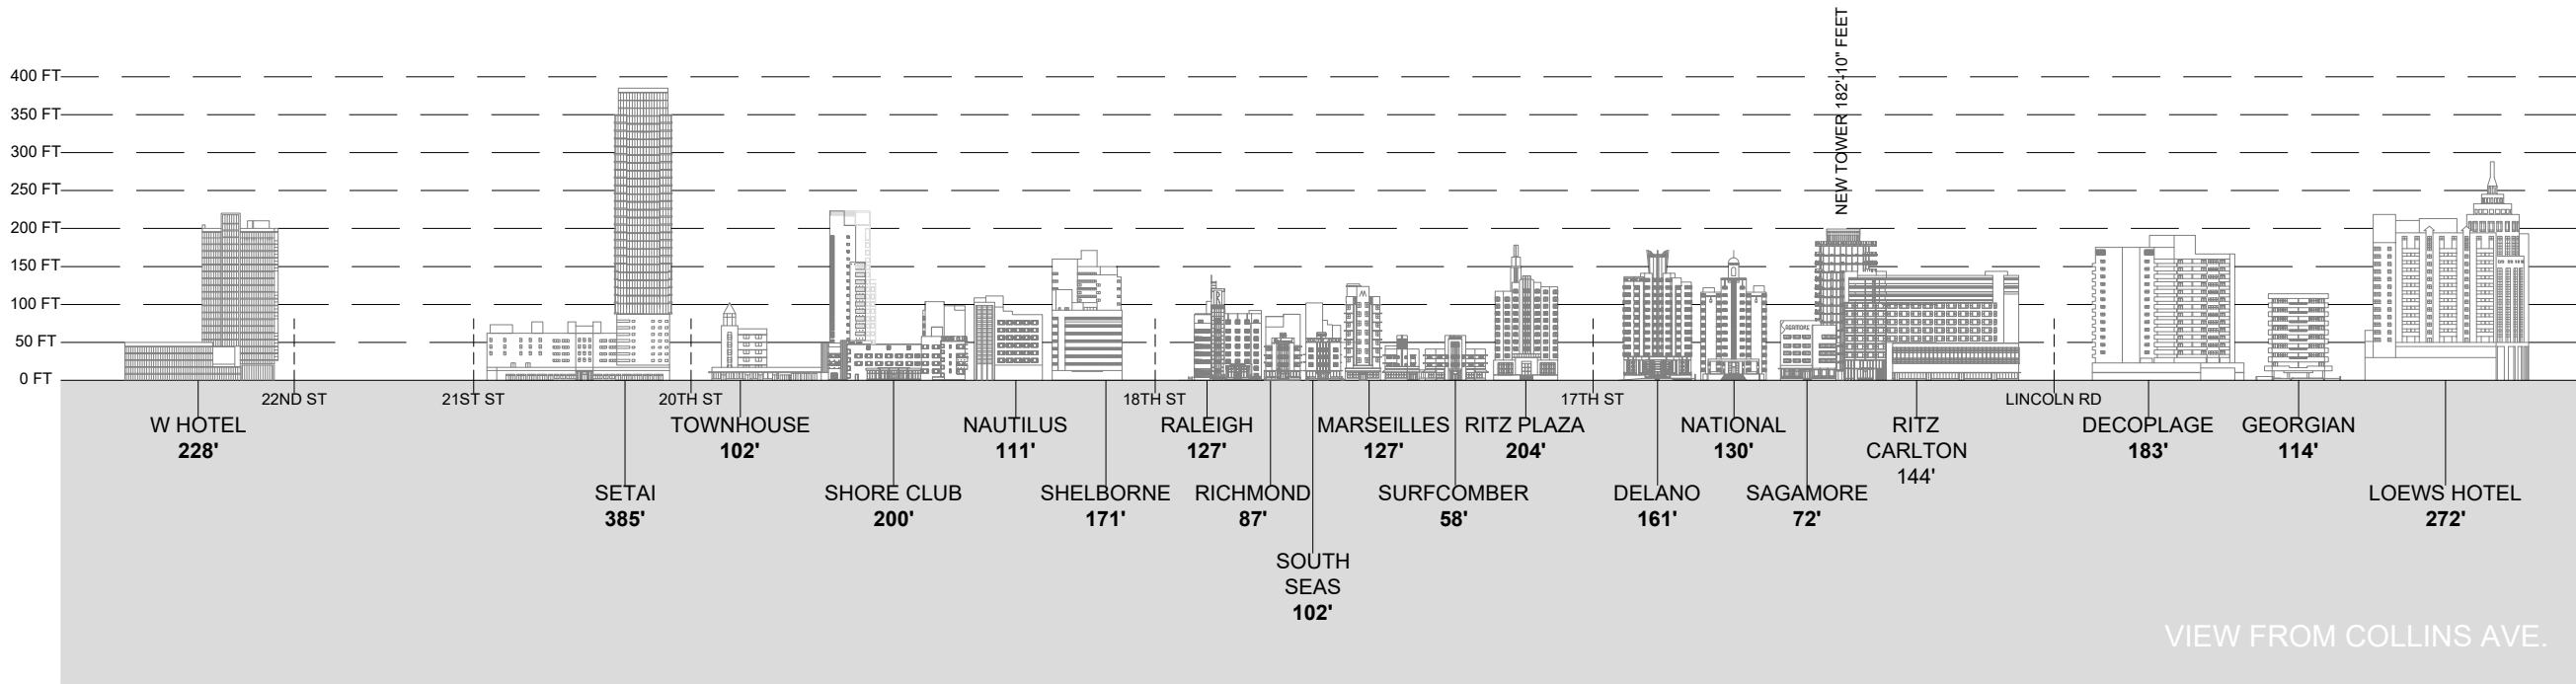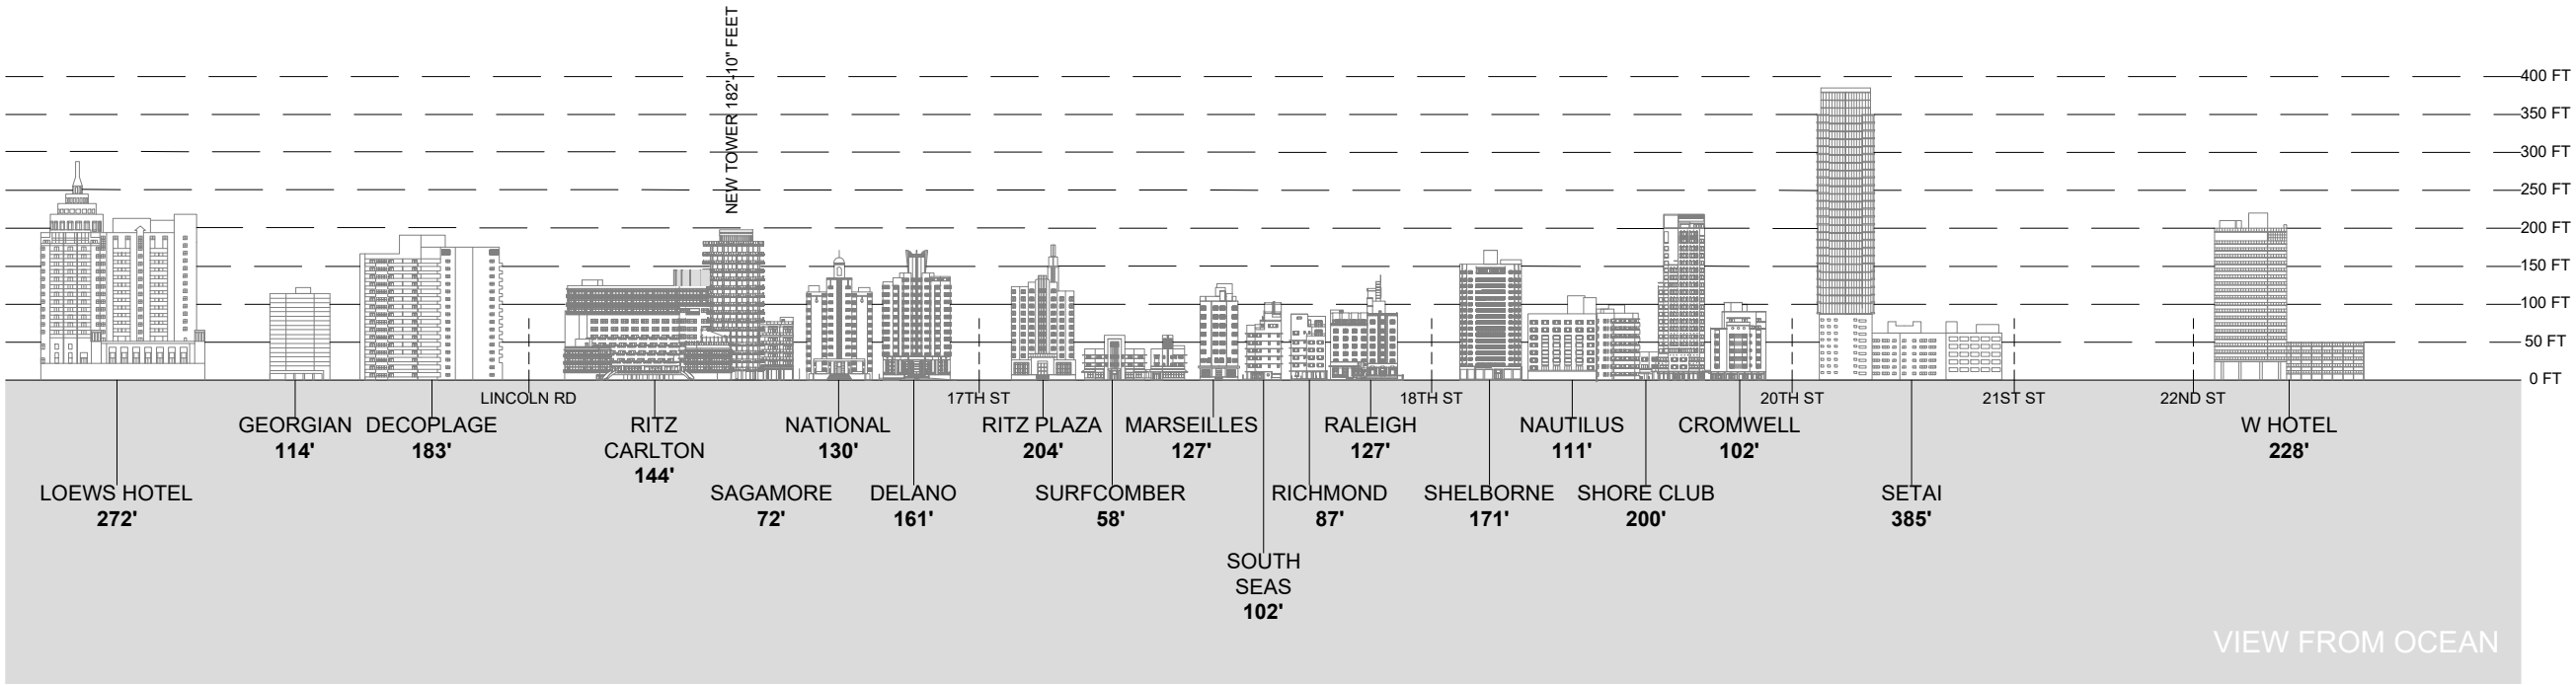

Rev.	Date	Rev.	Date

ALL DRAWINGS AND WRITTEN MATERIAL APPEARING HEREIN CONSTITUTE THE ORIGINAL AND UNPUBLISHED WORK OF KOBİ KARP AIA, AND MAY NOT BE DUPLICATED, USED, OR DISCLOSED WITHOUT THE EXPRESS WRITTEN CONSENT OF KOBİ KARP ARCHITECTURE & INTERIOR DESIGN, INC. AIA (U.S.A.)

HPB
FINAL SUBMITTAL

Ritz-Sagamore
1 Lincoln Road
Miami Beach, FL 33139

Owner: Di Lido Beach Resort LLC.
Name: EBJ Sagamore LLC.
Address: Sobe Sky Development LLC.
Tel: Di Lido Beach Resort Hotel Corporation
Email:

Consultant: STUDIO MUNGE.
Name: 25 Wingold Avenue,
Address: Toronto, ON Canada M6B 1P8
Tel: 416.588.1668
Email:

Consultant: LANDSCAPE ARCHITECT
Name: Naturalifical.
Address: 6915 Red Road, Suite 224
Tel: Coral Gables, FL 33143
Email: 786.717.8564



Consultant: MEP
Name: MG Engineering.
Address: 6915 Red Road, Suite 224
Tel: 2800 Biscayne Blvd
Email: Miami, FL, 33137
305.755.3833

Consultant: Desimore Consulting Engineering
Name: 800 Brickell Avenue, 6th Floor
Address: Miami, FL 33131
Tel: 305.441.0755
Email:

Architect: Kobi Karp Architecture and Interior Design, Inc.
Name: 571 NW 28TH ST
Address: Miami, Florida 33137 USA
Tel: +1(305) 573 1818
Fax: +1(305) 573 3766



KOBİ KARP Lic. # AR0012578		
CONTEXT ELEVATIONS		
RITZ-SAGAMORE		
Date	05-08-2023	Sheet No.
Scale	NTS	A0.07
Project	2018	

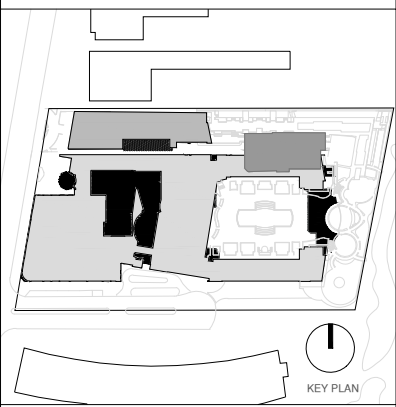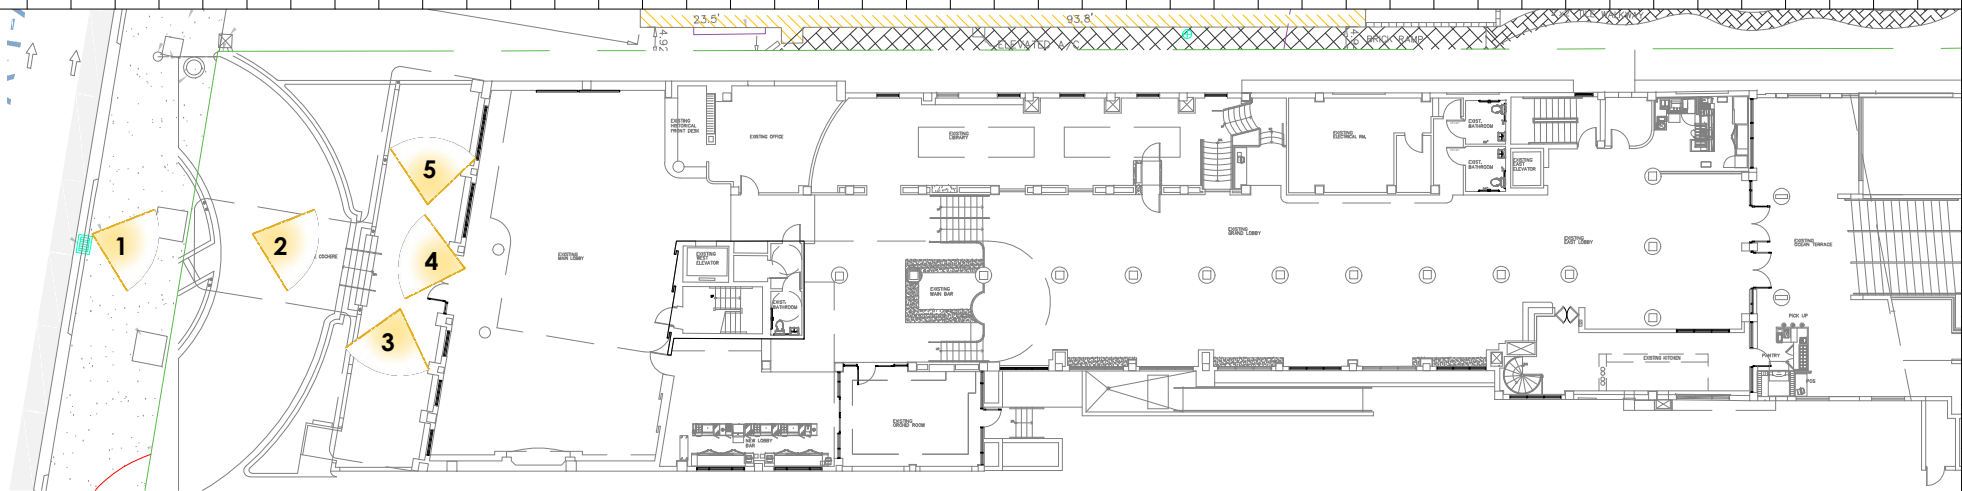

Rev.	Date	Rev.	Date

ALL DRAWINGS AND WRITTEN MATERIAL APPEARING HEREIN CONSTITUTE THE ORIGINAL AND UNPUBLISHED WORK OF KOBİ KARP AIA, AND MAY NOT BE DUPLICATED, USED, OR DISCLOSED WITHOUT THE EXPRESS WRITTEN CONSENT OF KOBİ KARP ARCHITECTURE & INTERIOR DESIGN, INC. AIA (U.S.A.)

HPB

FINAL SUBMITTAL

Ritz-Sagamore
1 Lincoln Road
Miami Beach, FL 33139

Owner:
Name: Di Lido Beach Resort LLC.
Address: EBJ Sagamore LLC,
Address: Sobe Sky Development LLC.
Tel: Di Lido Beach Resort Hotel Corporation
Email:

Consultant:
Name: STUDIO MUNGE.
Address: 25 Wingold Avenue,
Address: Toronto, ON Canada M6B 1P8
Tel: 416.588.1668
Email:

Consultant:
Name: LANDSCAPE ARCHITECT
Address: Naturaliffical,
Address: 6915 Red Road, Suite 224
Tel: Coral Gables, FL 33143
Email: 786.717.6564

Consultant:
Name: MEP
Address: MG Engineering,
Address: 6915 Red Road, Suite 224
Tel: 2800 Biscayne Blvd
Email: Miami, FL, 33137
305.755.3833

Consultant:
Name: Desimore Consulting Engineering
Address: 800 Brickell Avenue, 6th Floor
Tel: Miami, FL 33131
Email: 305.441.0755

Architect:
Kobi Karp Architecture and Interior Design, Inc.
571 NW 28TH ST
Miami, Florida 33137 USA
Tel: +1(305) 573 1818
Fax: +1(305) 573 3766



EXISTING CONDITIONS

SAGAMORE


Date	05-08-2023	Sheet No.
Scale	NTS	A0.30
Project	2018	



1
VIEW FROM COLLINS AVENUE



2
PORTE COCHERE TOWARDS LOBBY

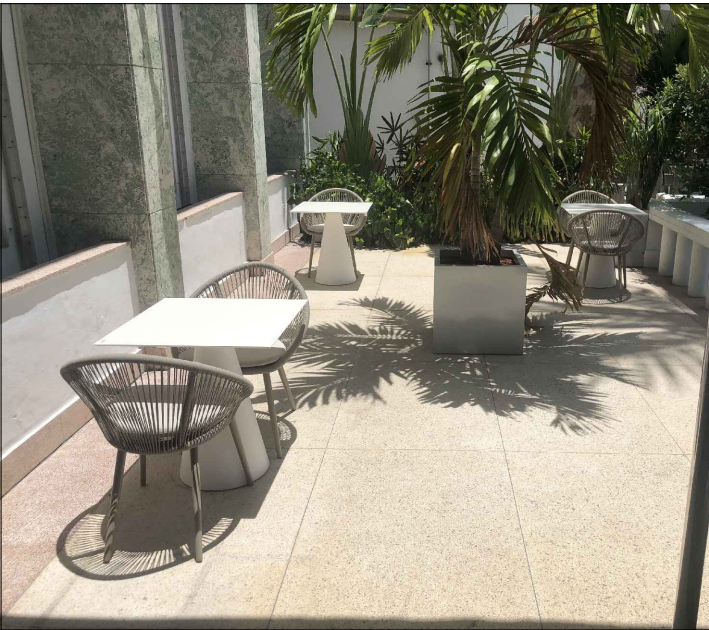



3
EXTERIOR LOBBY LOUNGE TOWARDS THE RITZ



4
LOBBY TOWARDS PORTE COCHERE



5
EXTERIOR LOBBY LOUNGE TOWARDS THE NATIONAL

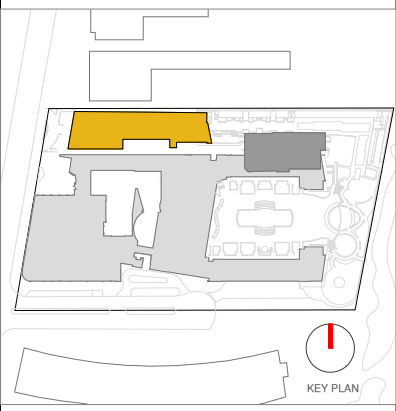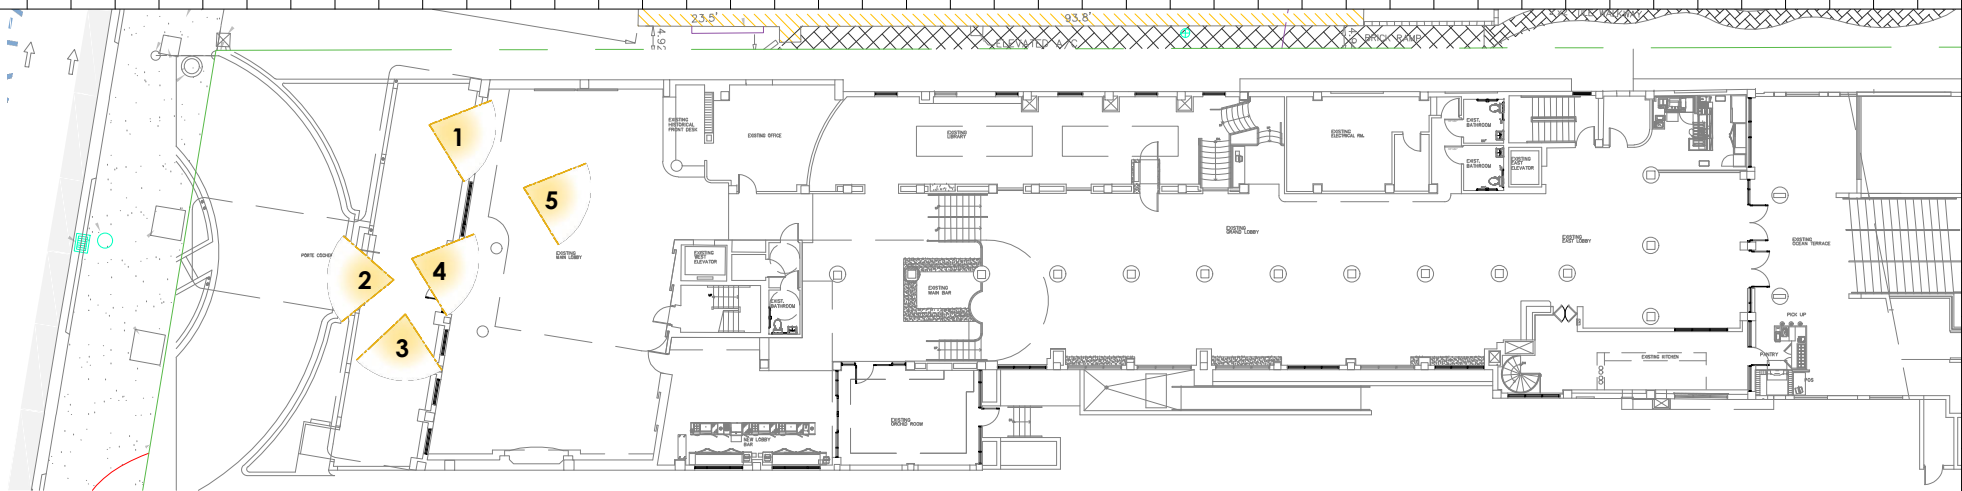

Rev.	Date	Rev.	Date

ALL DRAWINGS AND WRITTEN MATERIAL APPEARING HEREIN CONSTITUTE THE ORIGINAL AND UNPUBLISHED WORK OF KOBİ KARP AIA, AND MAY NOT BE DUPLICATED, USED, OR DISCLOSED WITHOUT THE EXPRESS WRITTEN CONSENT OF KOBİ KARP ARCHITECTURE & INTERIOR DESIGN, INC. AIA (U.S.A.)

HPB

FINAL SUBMITTAL

Ritz-Sagamore
1 Lincoln Road
Miami Beach, FL 33139

Owner: Di Lido Beach Resort LLC.
Name: EBJ Sagamore LLC.
Address: Sobe Sky Development LLC.
Address: Di Lido Beach Resort Hotel Corporation
Tel:
Email:


Consultant: STUDIO MUNGE.
Name: 25 Wingold Avenue,
Address: Toronto, ON Canada M6B 1P8
Address: 416.588.1668
Tel:
Email:

Consultant: LANDSCAPE ARCHITECT
Name: Naturalifical.
Address: 6915 Red Road, Suite 224
Address: Coral Gables, FL 33143
Tel: 786.717.6564
Email:

Consultant: MEP
Name: MG Engineering.
Address: 6915 Red Road, Suite 224
Address: 2800 Biscayne Blvd
Tel: Miami, FL, 33137
Email: 305.755.3833

Consultant: Desimore Consulting Engineering
Name: 800 Brickell Avenue, 6th Floor
Address: Miami, FL 33131
Address: 305.441.0755
Tel:
Email:

Architect: Kobi Karp Architecture and Interior Design, Inc.
571 NW 28TH ST
Miami, Florida 33137 USA
Tel: +1(305) 573 1818
Fax: +1(305) 573 3766

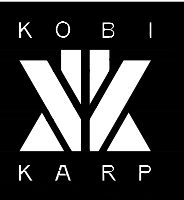

EXISTING CONDITIONS

SAGAMORE

Date	05-08-2023	Sheet No.
Scale	NTS	A0.31
Project	2018	



1
HISTORIC LOBBY



2
ENTRANCE FACING COLLINS AVENUE





3
LOBBY LOUNGE



4
ENTRANCE FACING COLLINS AVENUE



5
LOBBY CORRIDOR

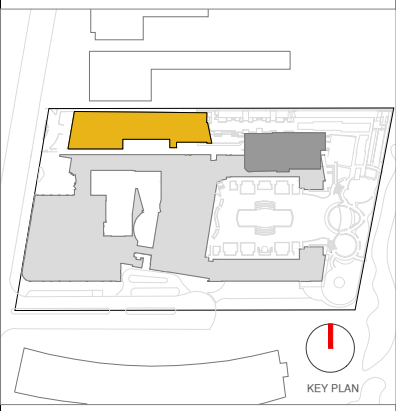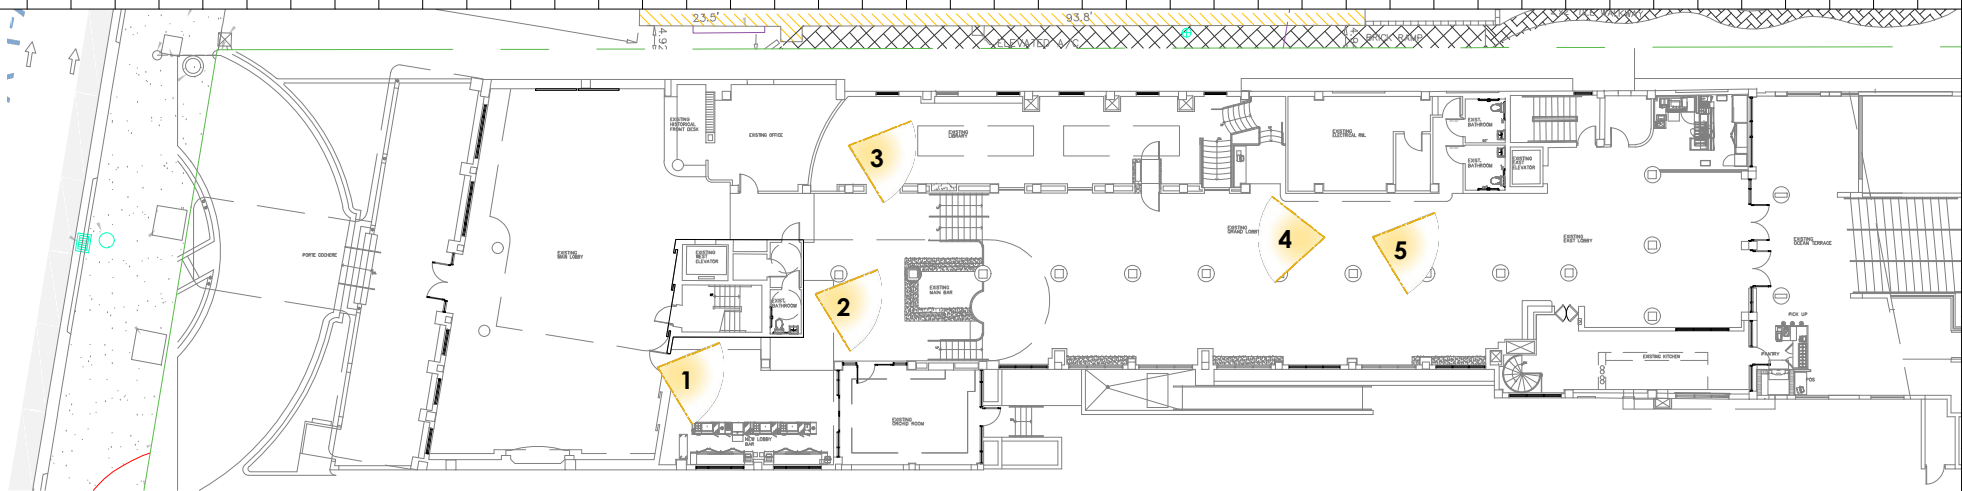

Rev.	Date	Rev.	Date

ALL DRAWINGS AND WRITTEN MATERIAL APPEARING HEREIN CONSTITUTE THE ORIGINAL AND UNPUBLISHED WORK OF KOBİ KARP AIA, AND MAY NOT BE DUPLICATED, USED, OR DISCLOSED WITHOUT THE EXPRESS WRITTEN CONSENT OF KOBİ KARP ARCHITECTURE & INTERIOR DESIGN, INC. AIA (U.S.A.)

HPB

FINAL SUBMITTAL

Ritz-Sagamore
1 Lincoln Road
Miami Beach, FL 33139

Owner:
Name: Di Lido Beach Resort LLC.
Address: EBJ Sagamore LLC.
Address: Sobe Sky Development LLC.
Tel: Di Lido Beach Resort Hotel Corporation
Email:

Consultant:
Name: STUDIO MUNGE.
Address: 25 Wingold Avenue.
Address: Toronto, ON Canada M6B 1P8
Tel: 416.588.1668
Email:

Consultant:
Name: LANDSCAPE ARCHITECT
Address: Naturalisical.
Address: 6915 Red Road, Suite 224
Tel: Coral Gables, FL 33143
Email: 786.717.8564

Consultant:
Name: MEP
Address: MG Engineering.
Address: 6915 Red Road, Suite 224
Tel: 2800 Biscayne Blvd
Email: Miami, FL 33137
305.755.3833

Consultant:
Name: Desimore Consulting Engineering
Address: 800 Brickell Avenue, 6th Floor
Tel: Miami, FL 33131
Email: 305.441.0755

Architect:
Kobi Karp Architecture and Interior Design, Inc.
571 NW 28TH ST
Miami, Florida 33137 USA
Tel: +1(305) 573 1818
Fax: +1(305) 573 3766




KOBİ KARP
Lic. # AR0012578


EXISTING CONDITIONS

SAGAMORE

Date	05-08-2023	Sheet No.
Scale	NTS	A0.32
Project	2018	

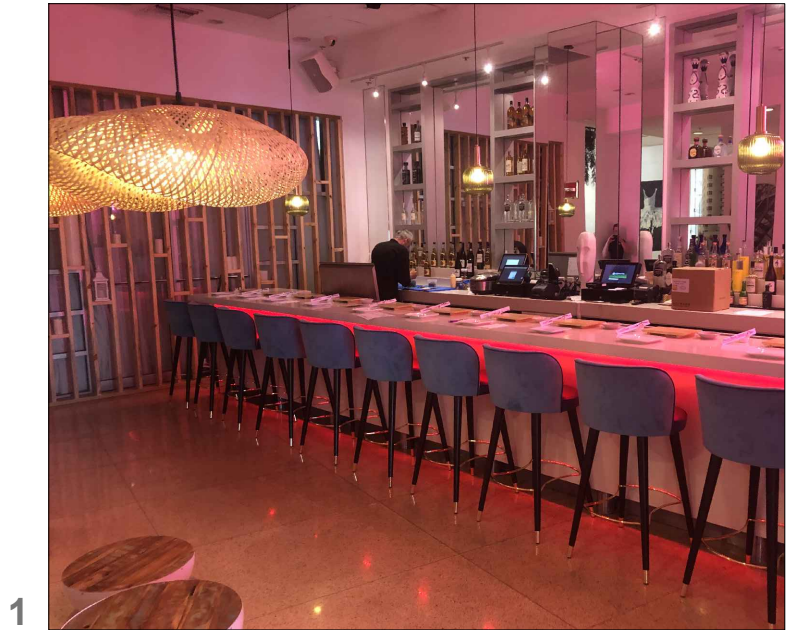


1 LOBBY BAR ADJACENT TO ORCHID ROOM

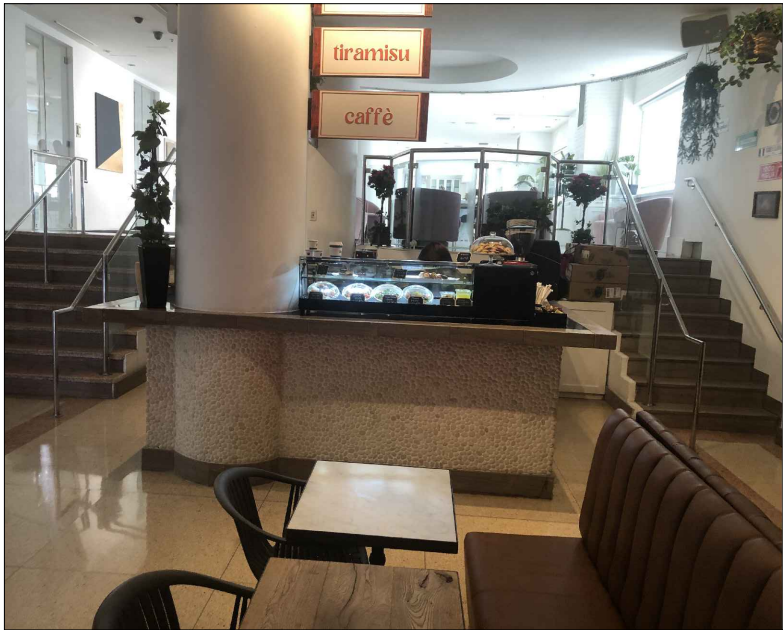

2 MAIN BAR





3 LIBRARY

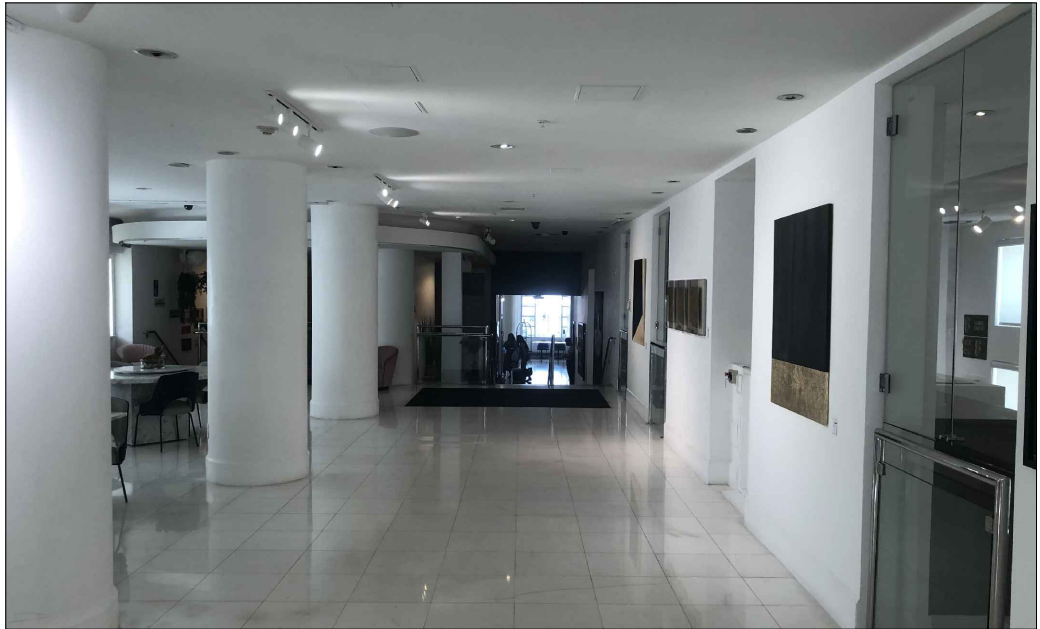

4 GRAND LOBBY TOWARDS COLLINS AVENUE



5 GRAND LOBBY TOWARDS POOL

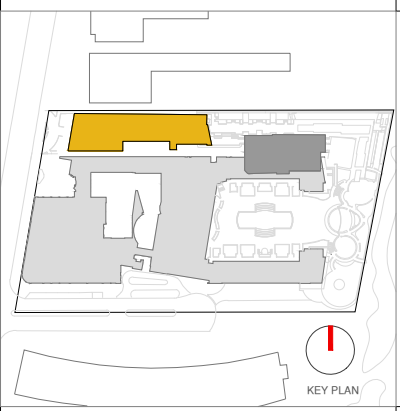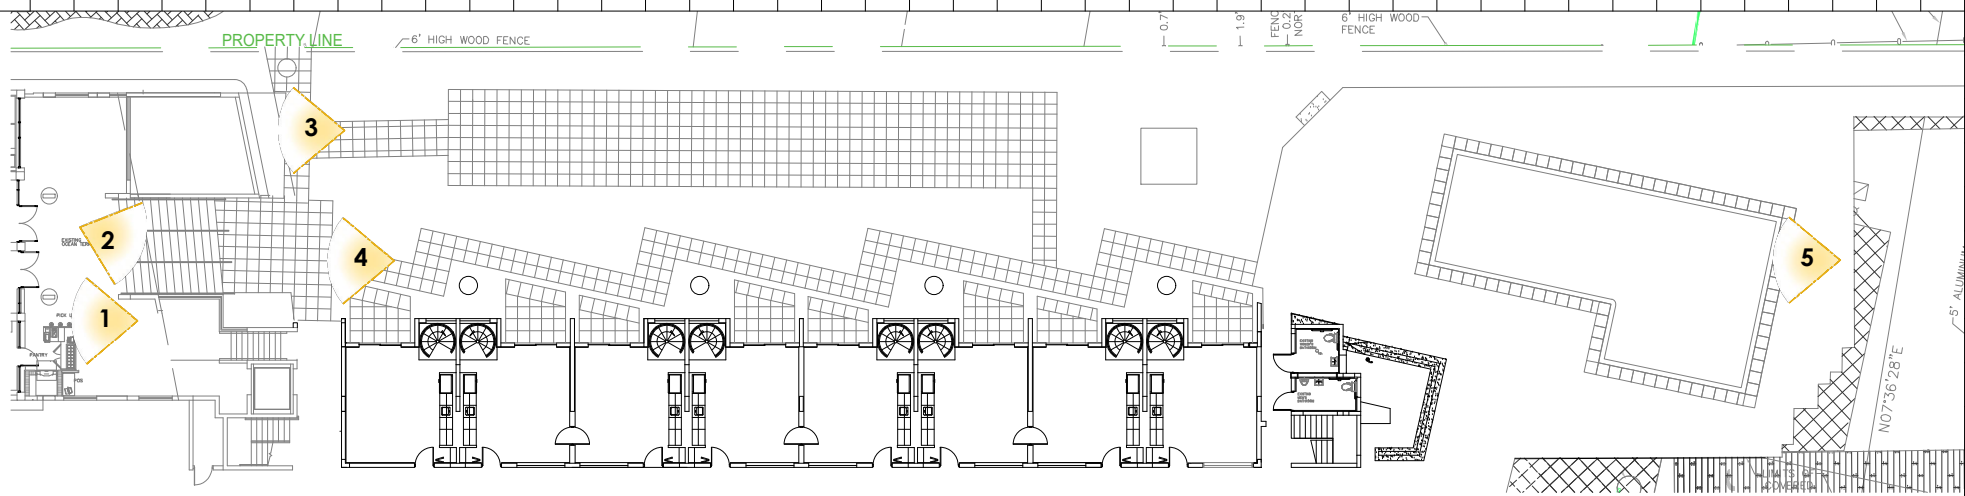

Rev.	Date	Rev.	Date

ALL DRAWINGS AND WRITTEN MATERIAL APPEARING HEREIN CONSTITUTE THE ORIGINAL AND UNPUBLISHED WORK OF Kobi Karp AIA, and MAY NOT BE DUPLICATED, USED, OR DISCLOSED WITHOUT THE EXPRESS WRITTEN CONSENT OF Kobi Karp Architecture & Interior Design, Inc. AIA (01/2020)

HPB

FINAL SUBMITTAL

Ritz-Sagamore
1 Lincoln Road
Miami Beach, FL 33139

Owner: Di Lido Beach Resort LLC.
Name: EBJ Sagamore LLC.
Address: Sobe Sky Development LLC.
Address: Di Lido Beach Resort Hotel Corporation
Tel:
Email:


Consultant: STUDIO MUNGE.
Name: 25 Wingold Avenue.
Address: Toronto, ON Canada M6B 1P8
Address:
Tel: 416.588.1668
Email:

Consultant: LANDSCAPE ARCHITECT
Name: Naturalifical.
Address: 6915 Red Road, Suite 224
Address: Coral Gables, FL 33143
Tel: 786.717.8564
Email:

Consultant: MEP
Name: MG Engineering.
Address: 6915 Red Road, Suite 224
Address: 2800 Biscayne Blvd
Tel: Miami, FL, 33137
Email: 305.755.3833

Consultant: Desimore Consulting Engineering
Name: 800 Brickell Avenue, 6th Floor
Address: Miami, FL 33131
Address:
Tel: 305.441.0755
Email:

Architect: Kobi Karp Architecture and Interior Design, Inc.
Name: 571 NW 28TH ST
Address: Miami, Florida 33137 USA
Tel: +1(305) 573 1818
Fax: +1(305) 573 3786

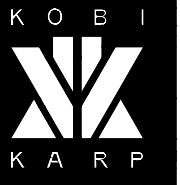

KOBI KARP
Lic. # AR0012578

EXISTING CONDITIONS

SAGAMORE

Date	05-08-2023	Sheet No.
Scale	NTS	A0.33
Project	2018	



1
PANTRY



2
OCEAN TERRACE TOWARDS POOL




3
GYM



4
OCEAN TERRACE TOWARDS COLLINS AVENUE




5
POOL TOWARDS COLLINS AVENUE

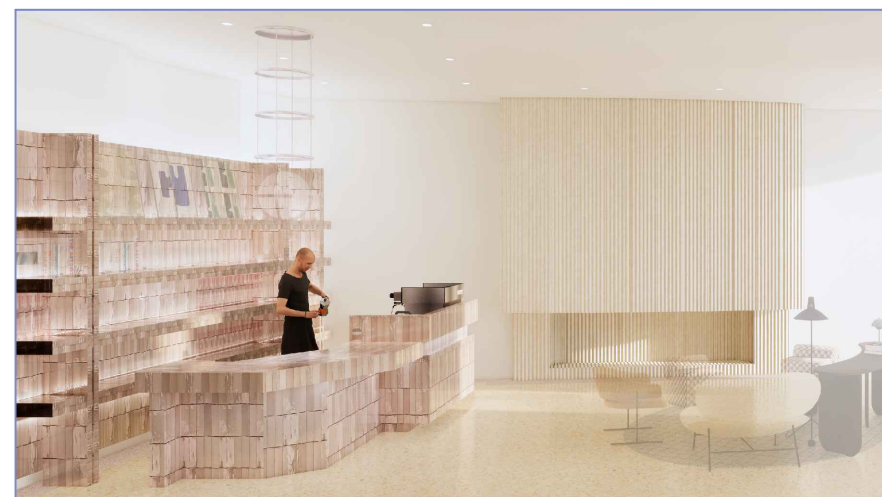

Sagamore Lobby



Sagamore New Door

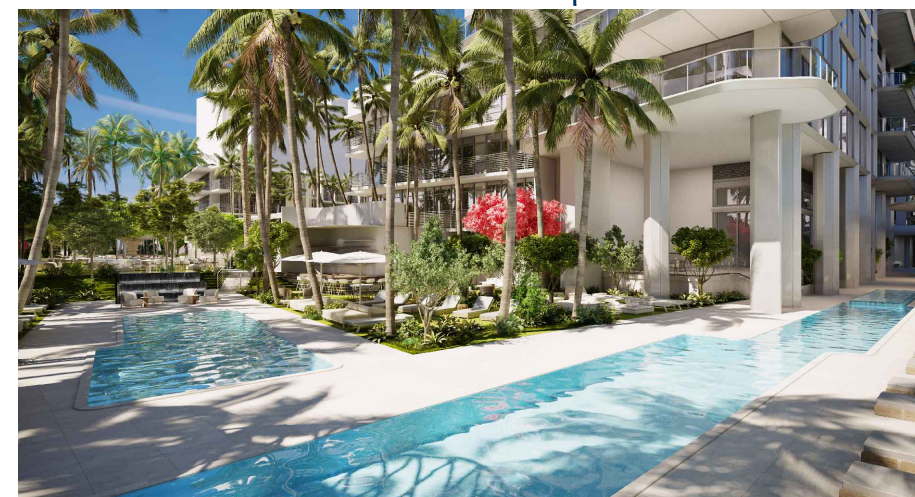

Rear Yard




Sagamore Facade - Terrace Restoration

OVERALL PROJECT SCOPE OF WORK

- The Sagamore Lobby, Outdoor seating and corridor.
- Restoration of historic Sagamore facade massing.
- New rear yard, Pool deck, and beach restaurant.
- New Residential building ground up addition
- New Ritz entry canopy.

INTERIOR & EXTERIOR SCOPE OF WORK AREAS

- 1-Proposed Sagamore Area
- 2-Proposed Rear yard & pool deck Area
- 3-Restoration of Sagamore Facade & Addition of Exterior Door

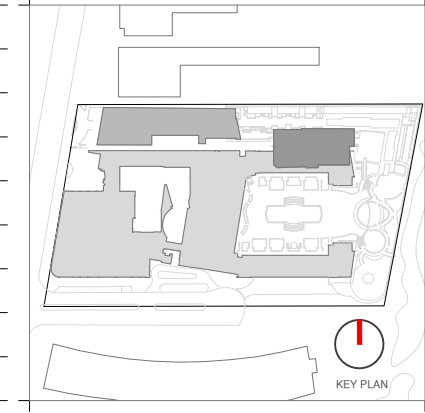

Rev.	Date	Rev.	Date

HPB FINAL SUBMITTAL

Ritz-Sagamore
1 Lincoln Road
Miami Beach, FL 33139

Owner: Di Lido Beach Resort LLC.
Name: EBJ Sagamore LLC.
Address: Sobe Sky Development LLC.
Tel: Di Lido Beach Resort Hotel Corporation
Email:

Consultant: STUDIO MUNGE.
Name: 25 Wingold Avenue.
Address: Toronto, ON Canada M6B 1P8
Tel: 416.588.1668
Email:

Consultant: LANDSCAPE ARCHITECT
Name: Naturalistic.
Address: 6915 Red Road, Suite 224
Tel: Coral Gables, FL 33143
Email: 786.717.8564

Consultant: MEP
Name: MG Engineering.
Address: 6915 Red Road, Suite 224
Tel: 2800 Biscayne Blvd
Email: Miami, FL 33137
305.755.3833

Consultant: Desimore Consulting Engineering
Name: 800 Brickell Avenue, 6th Floor
Address: Miami, FL 33131
Tel: 305.441.0755
Email:

Architect: Kobi Karp Architecture and Interior Design, Inc.
Name: 571 NW 28TH ST
Address: Miami, Florida 33137 USA
Tel: +1(305) 573 1818
Fax: +1(305) 573 3766

K O B I

K A R P

K O B I

K A R P

SCOPE OF WORK RITZ-SAGAMORE

Date	05-08-2023	Sheet No.
Scale	1"=50'-0"	A0.50
Project	2018	